


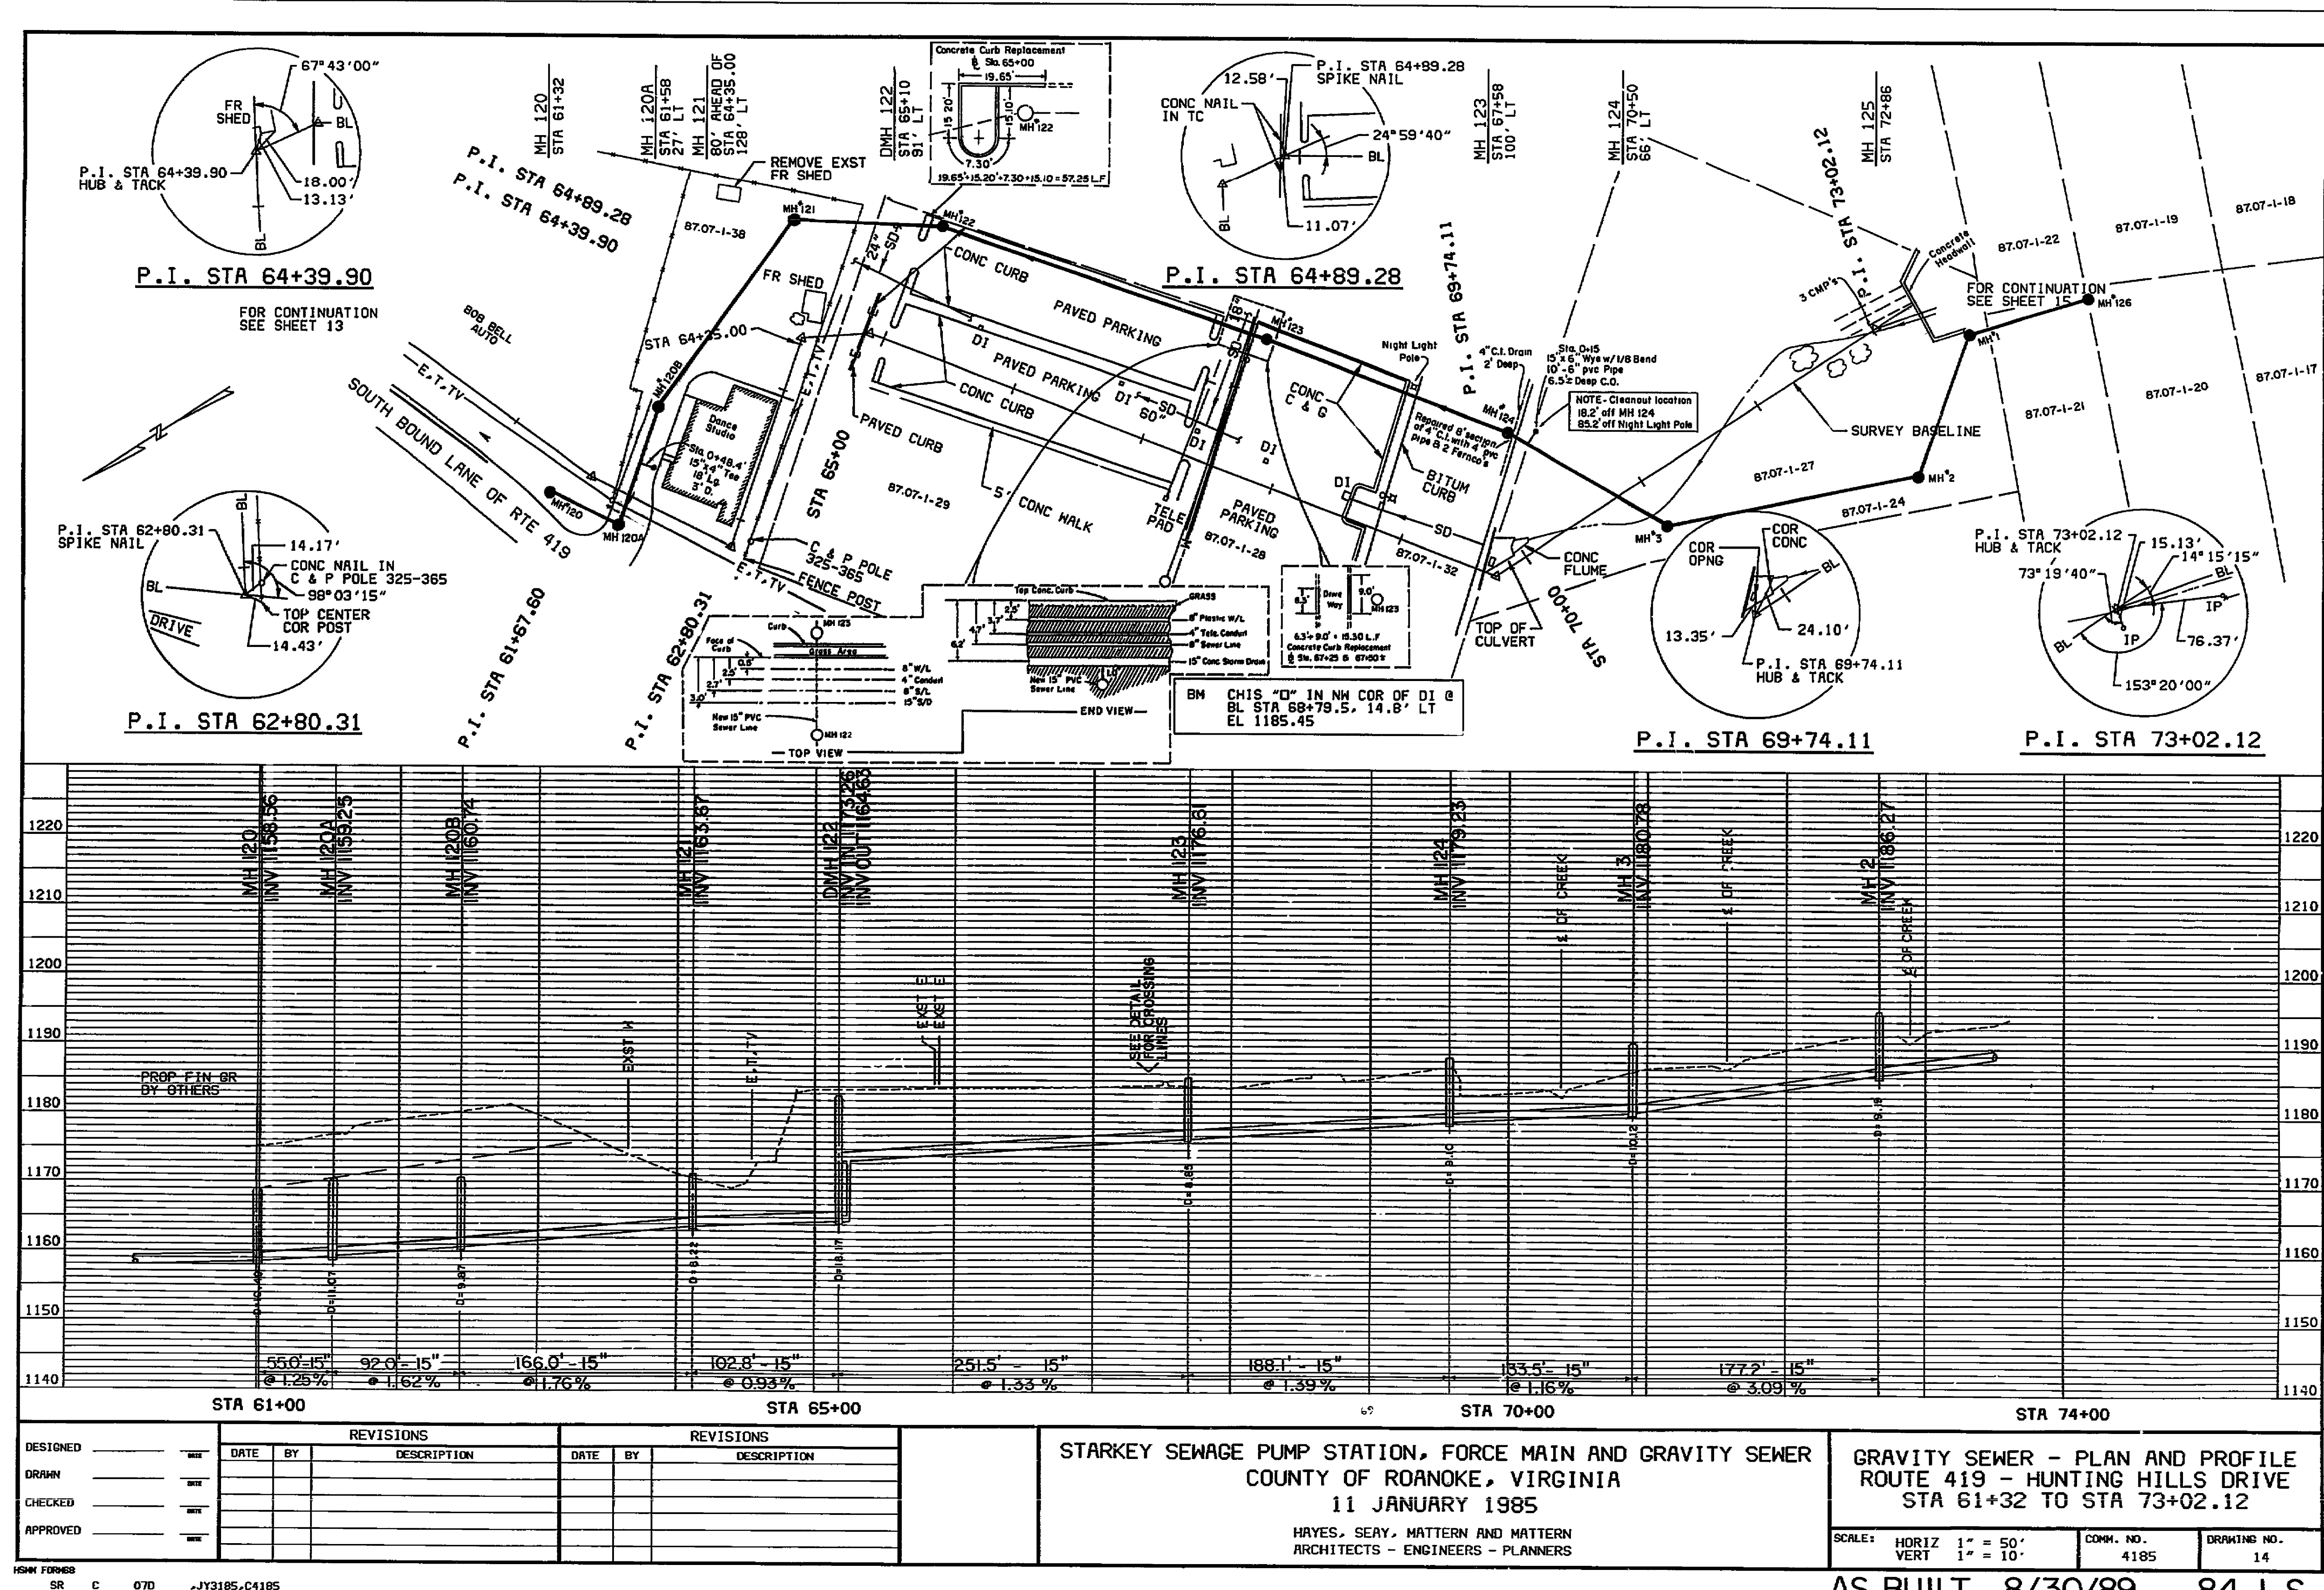

DESIGNED	DATE	BY	REVISIONS		DATE	BY	REVISIONS	
			DESCRIPTION				DESCRIPTION	
DRAWN								
CHECKED								
APPROVED								

STARKEY SEWAGE PUMP STATION, FORCE MAIN AND GRAVITY SEWER
COUNTY OF ROANOKE, VIRGINIA
11 JANUARY 1985
HAYES, SEAY, MATTERN AND MATTERN
ARCHITECTS - ENGINEERS - PLANNERS

GRAVITY SEWER - PLAN AND PROFILE ROUTE 419 - HUNTING HILLS DRIVE STA 61+32 TO STA 73+02.12			
SCALE:	HORIZ 1" = 50'	VERT 1" = 10'	DRIVING NO. 14
COMM. NO.	4185		

AS BUILT 8/30/89 84-I-S