
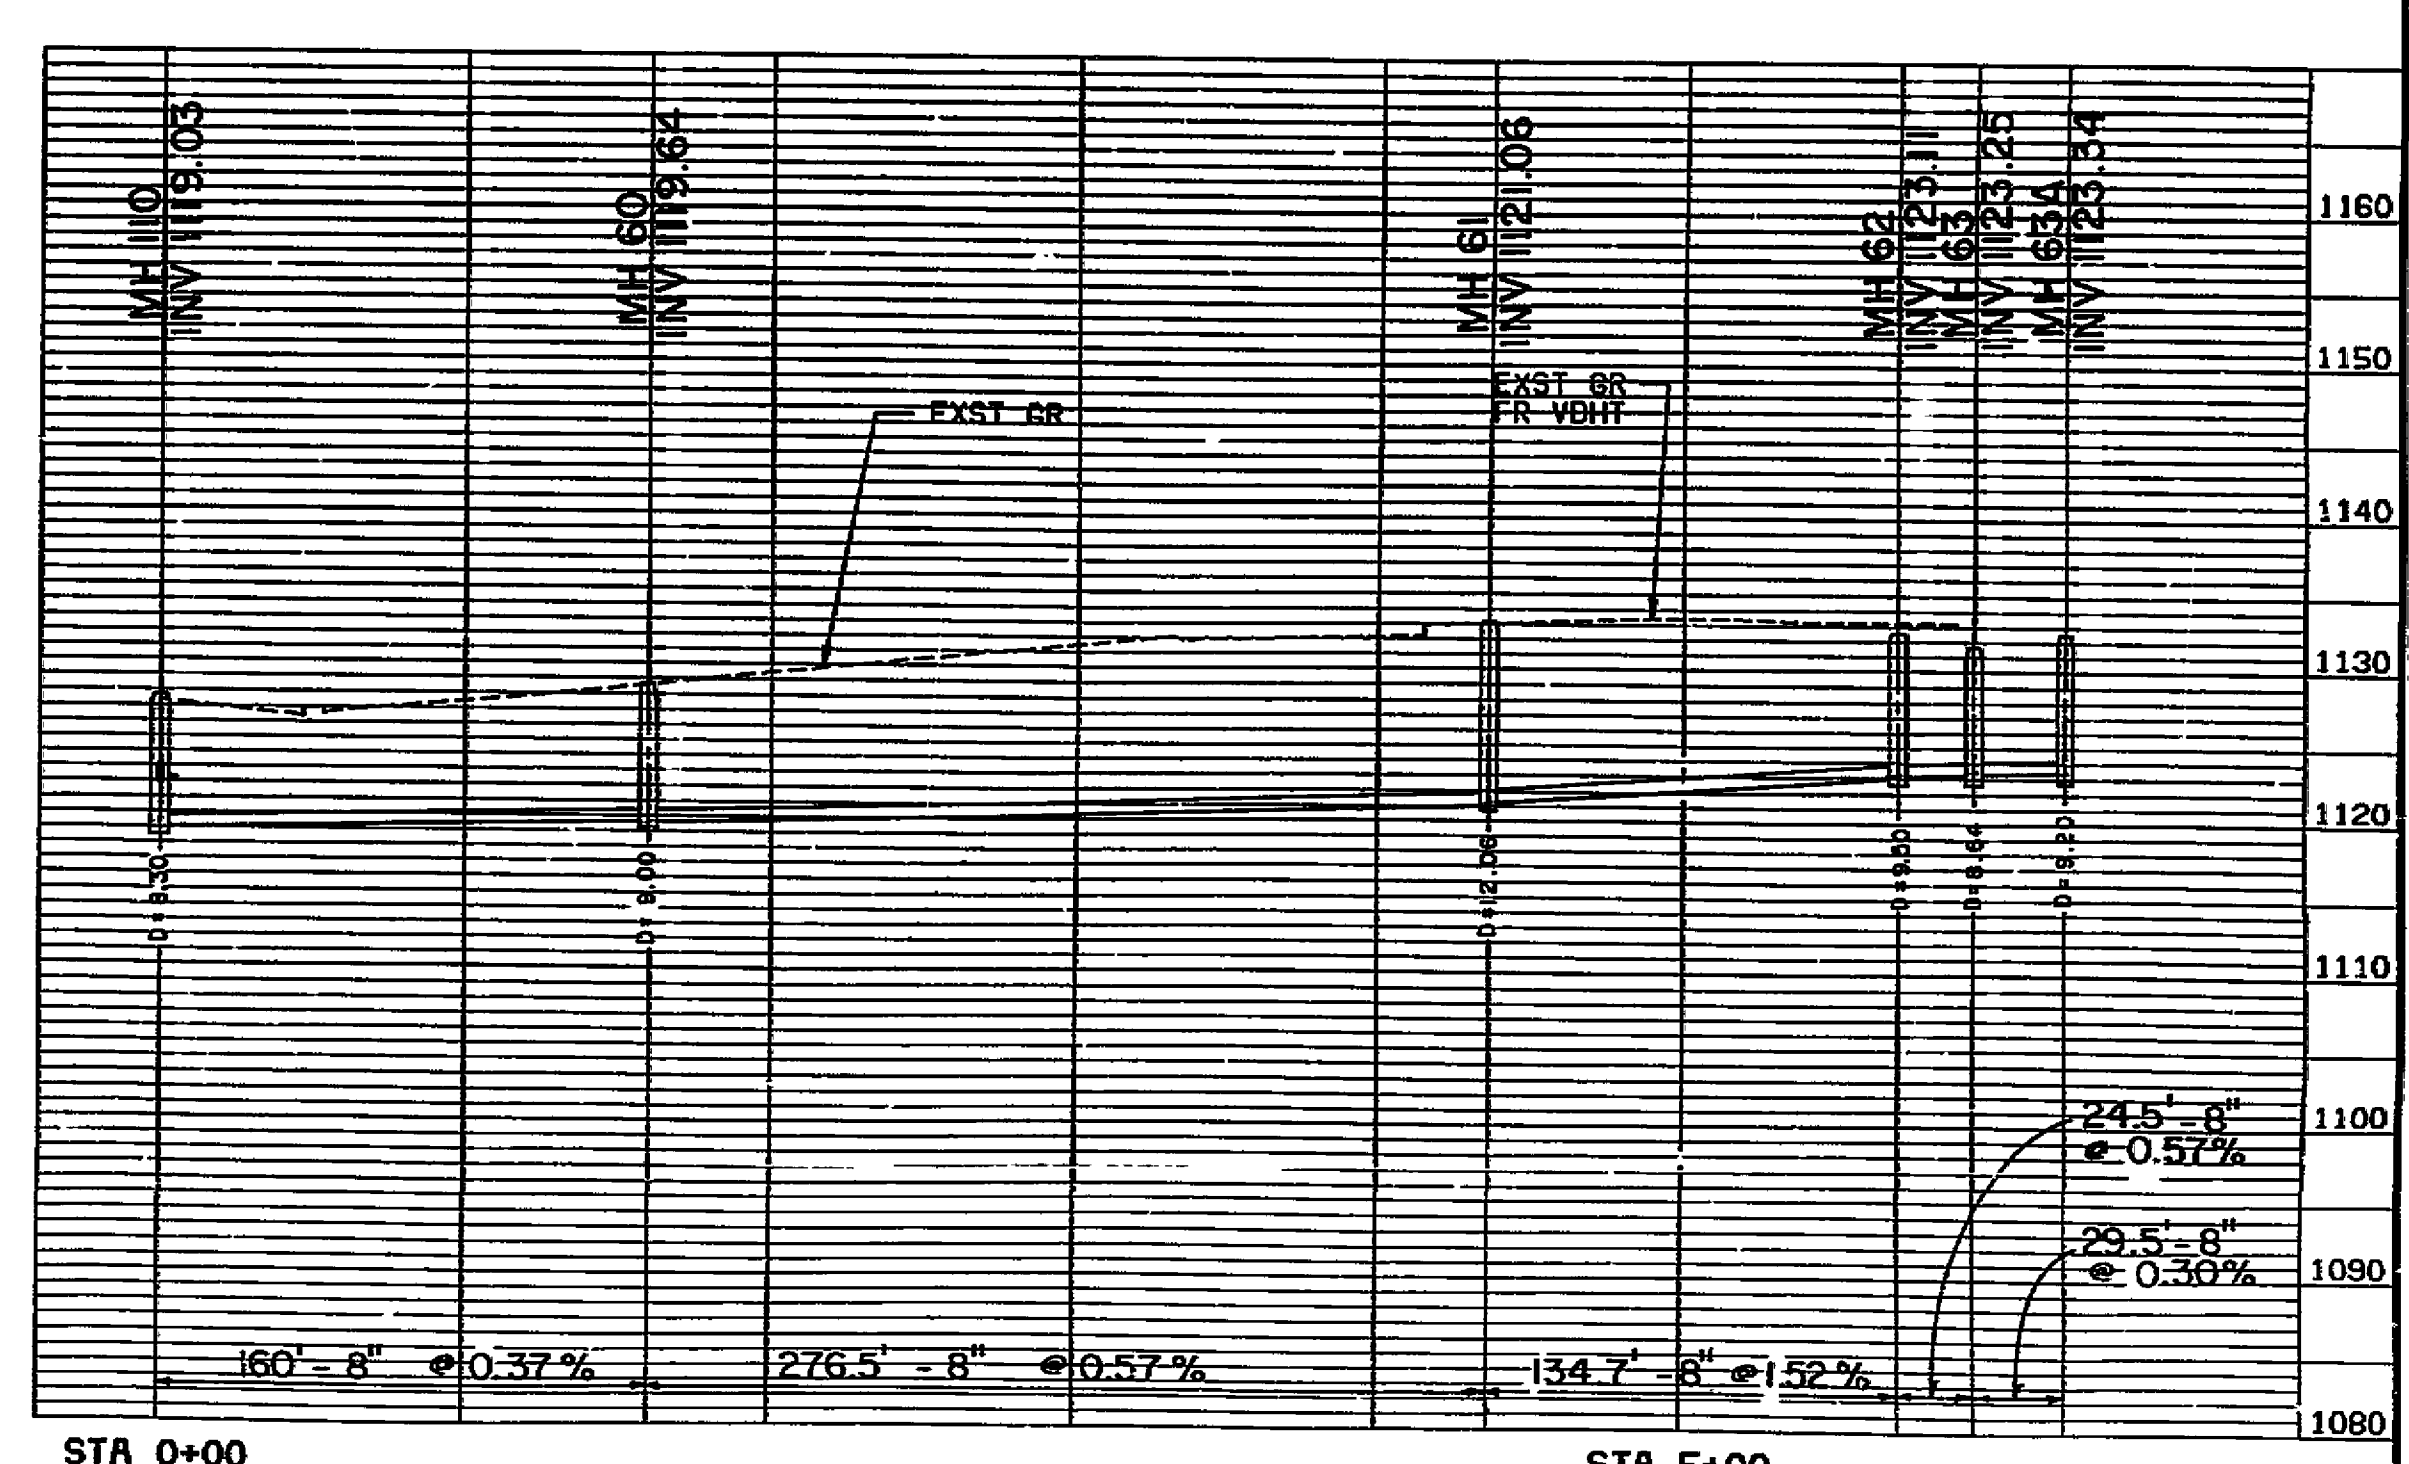
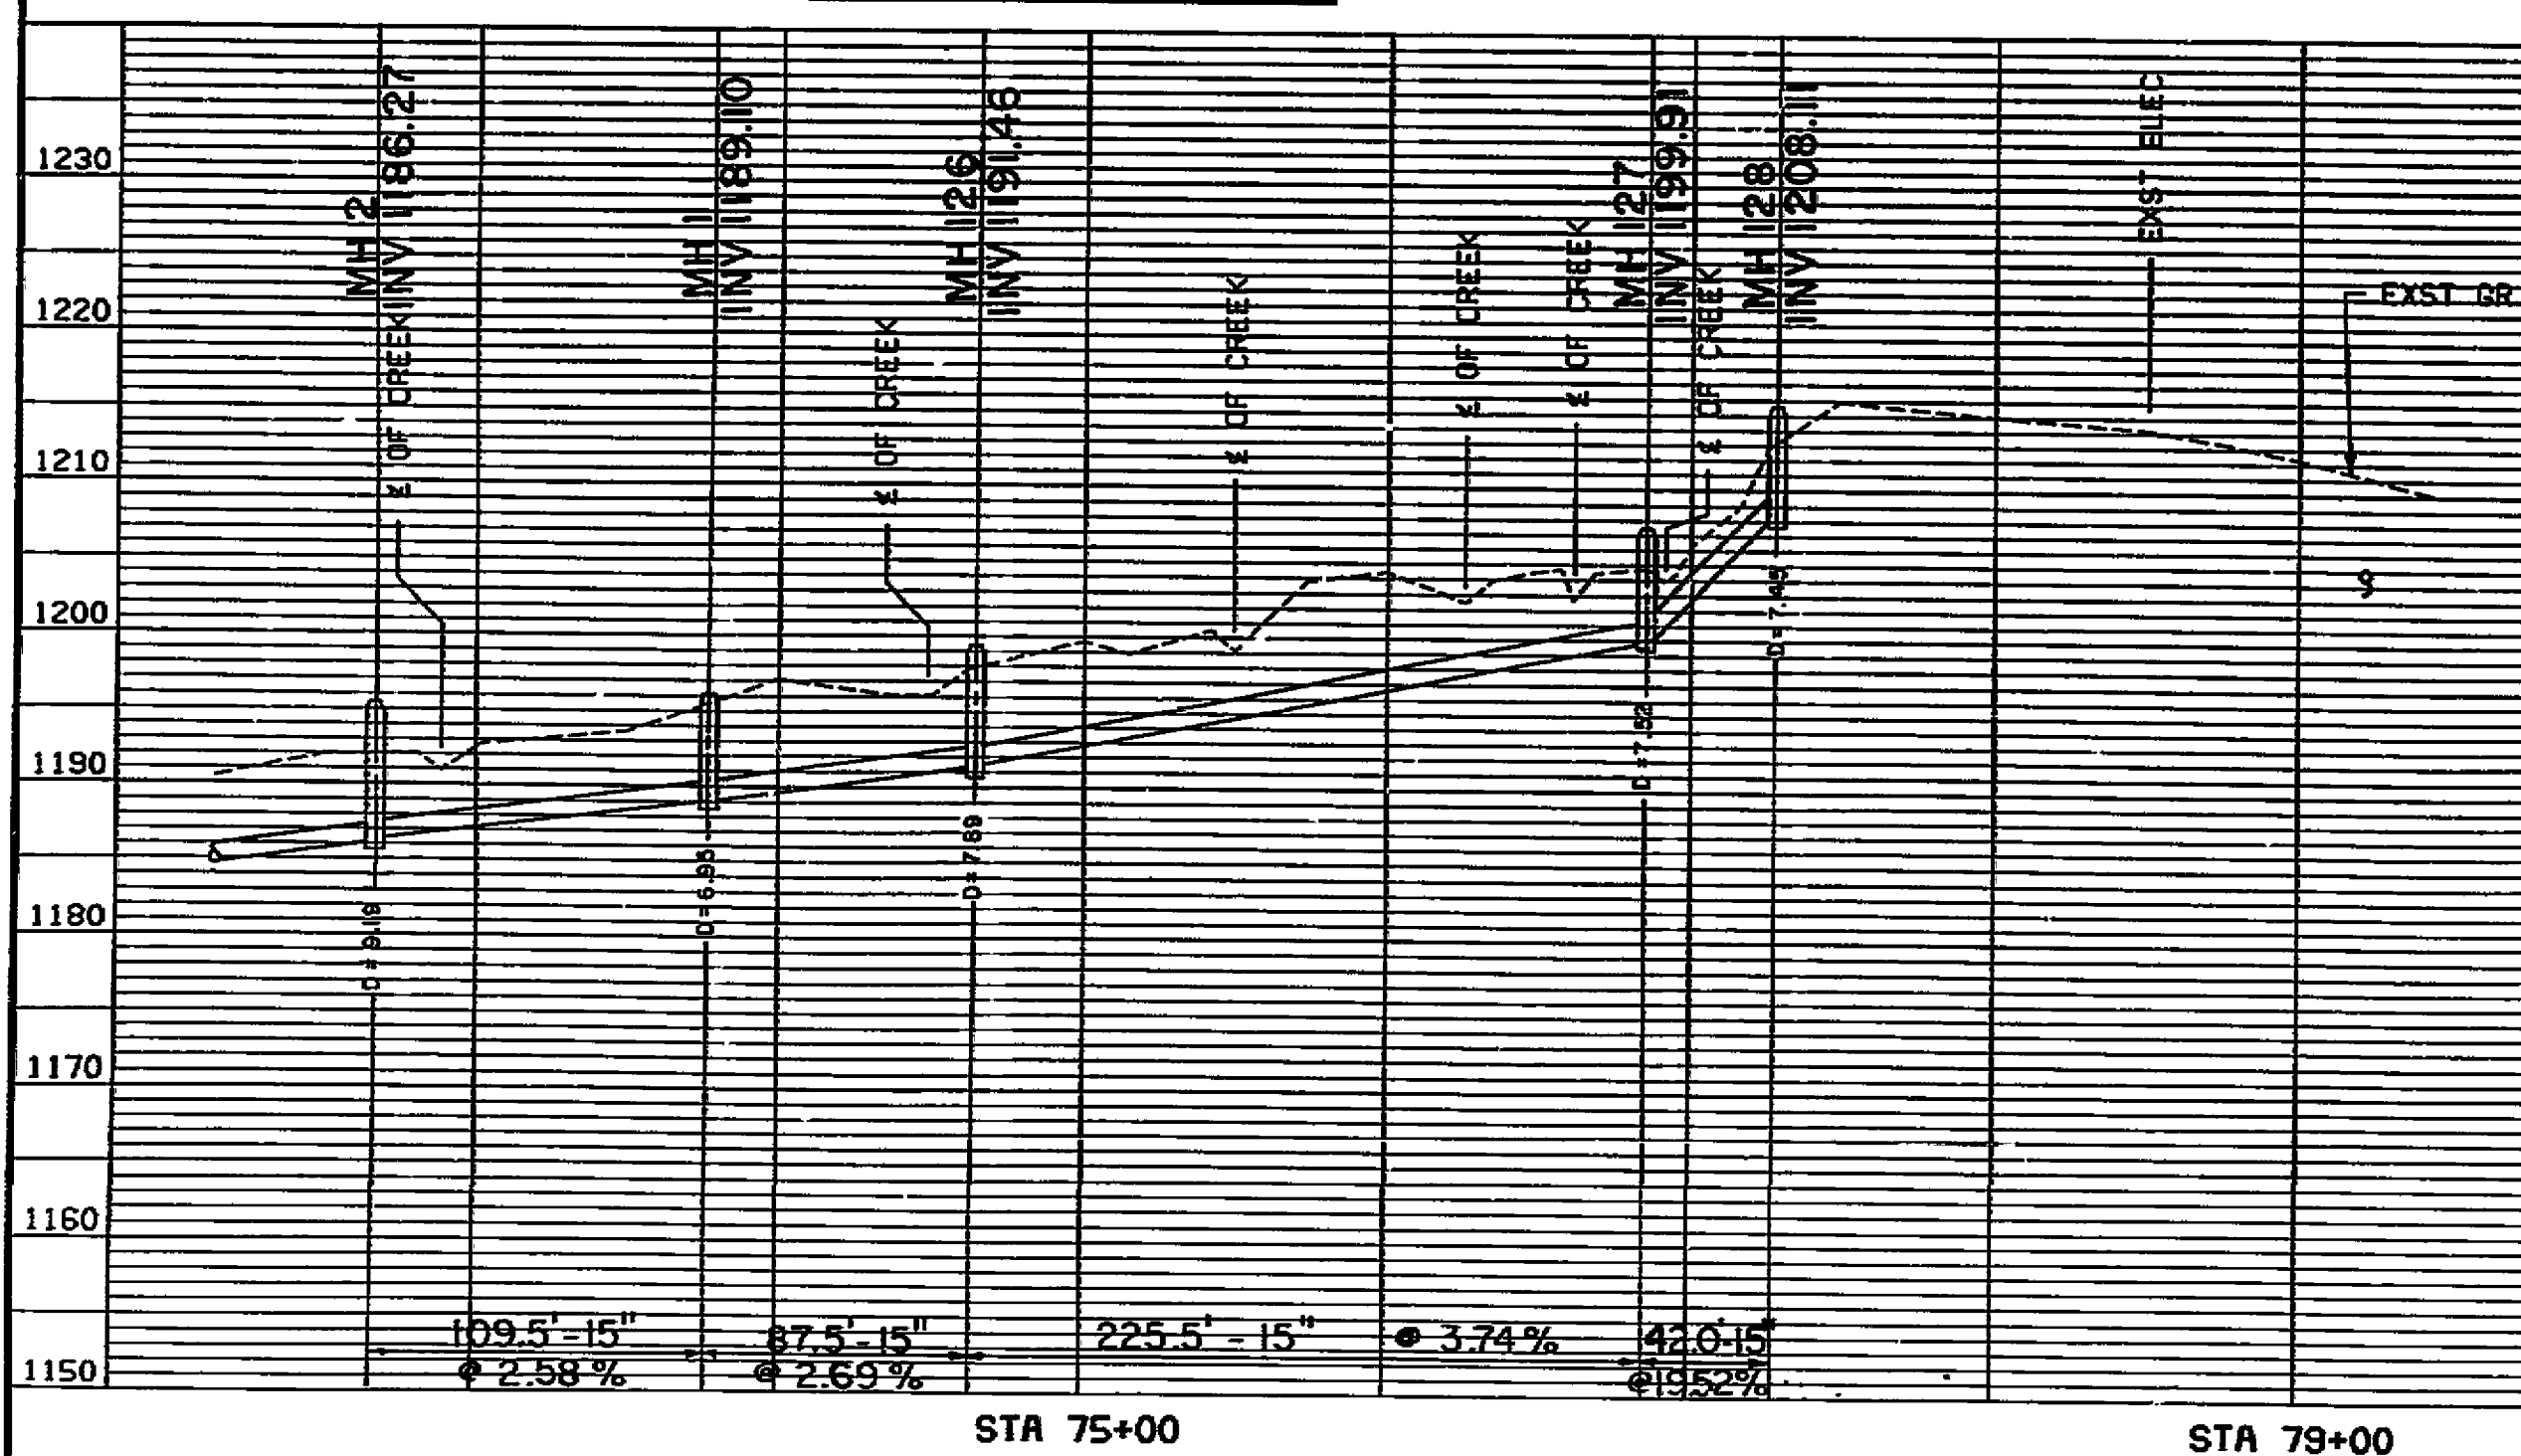


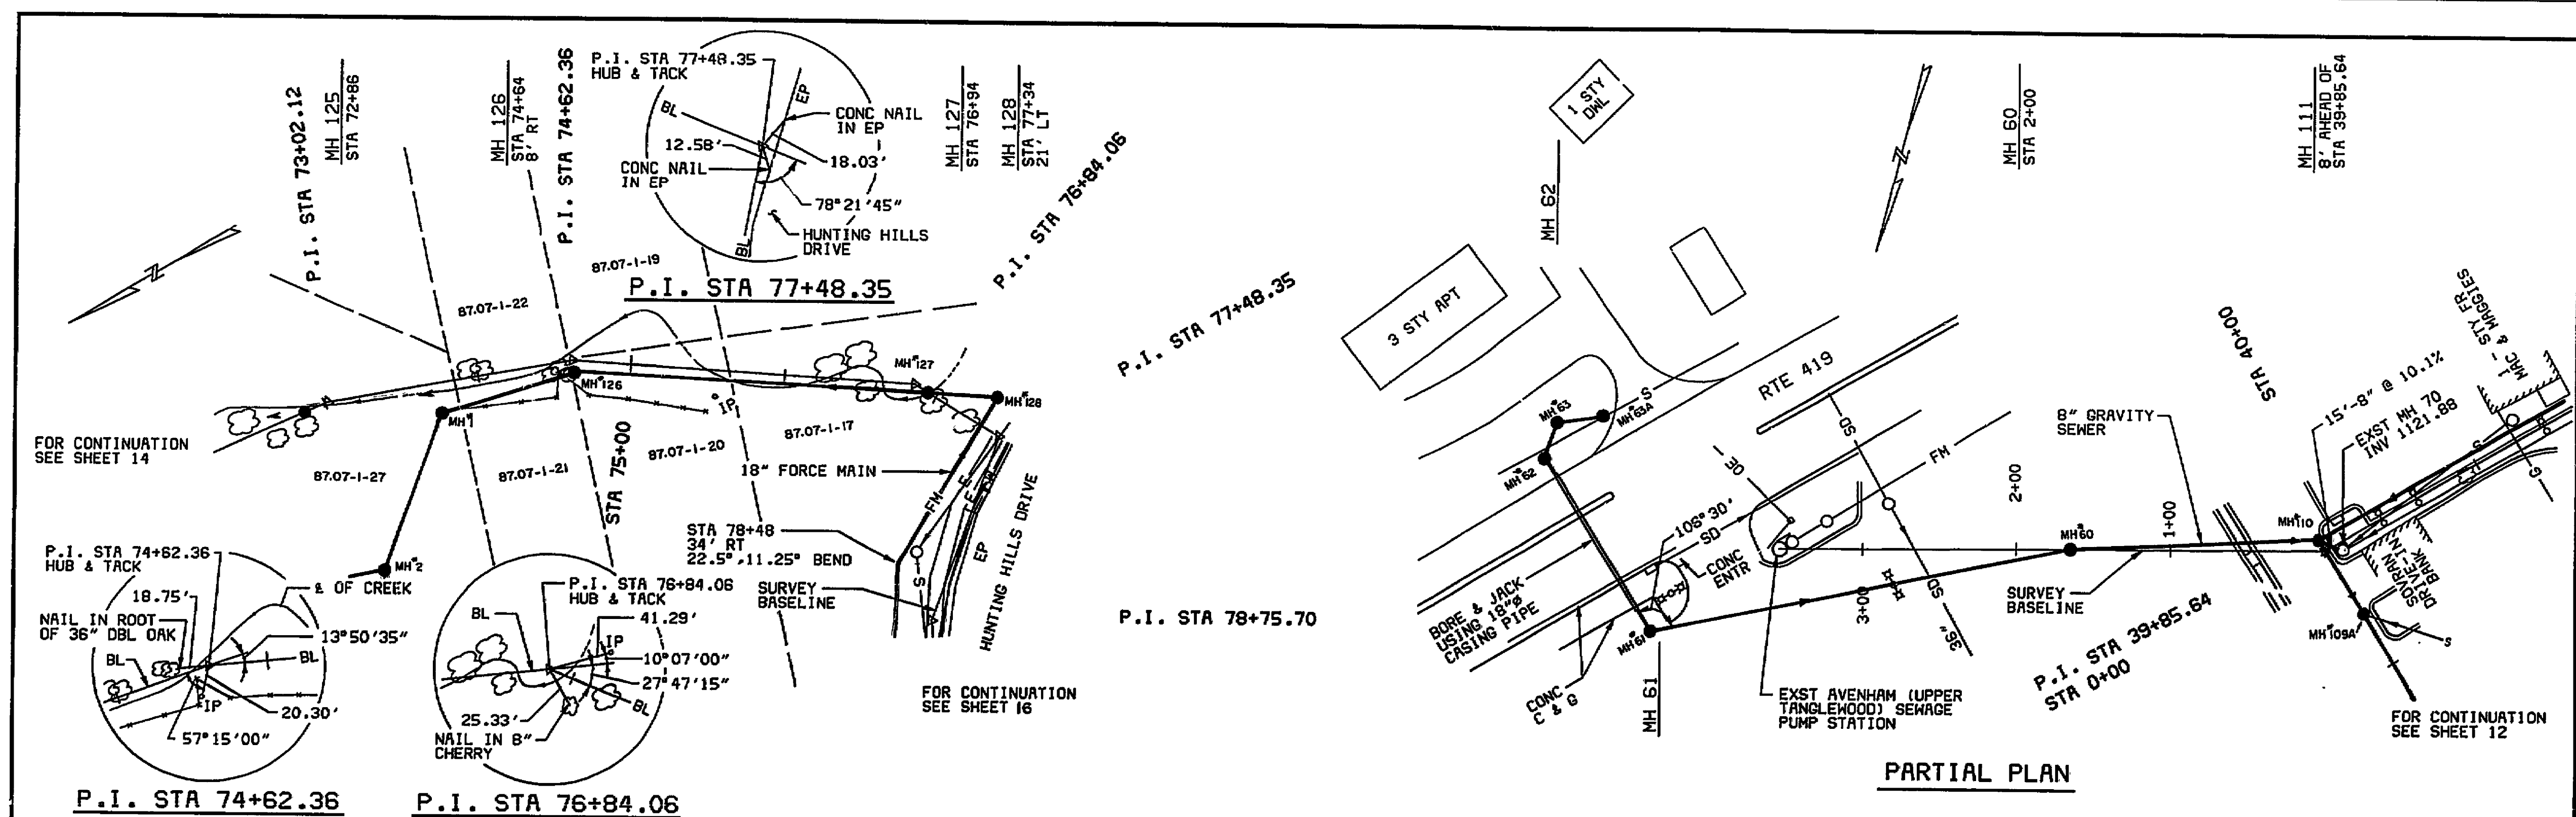

DESIGNED	DATE	BY	DESCRIPTION	DATE	BY	DESCRIPTION

STARKEY SEWAGE PUMP STATION, FORCE MAIN AND GRAVITY SEWER
COUNTY OF ROANOKE, VIRGINIA
11 JANUARY 1985
HAYES, SEAY, MATTERN AND MATTERN
ARCHITECTS - ENGINEERS - PLANNERS

GRAVITY SEWER - PLAN AND PROFILE
HUNTING HILLS DRIVE
STA 73+02.12 TO STA 78+00
SCALE: HORIZ 1" = 50' VERT 1" = 10'
CONV. NO. 4185
DRAWING NO. 15

AS BUILT 8/30/89 84-I-S