
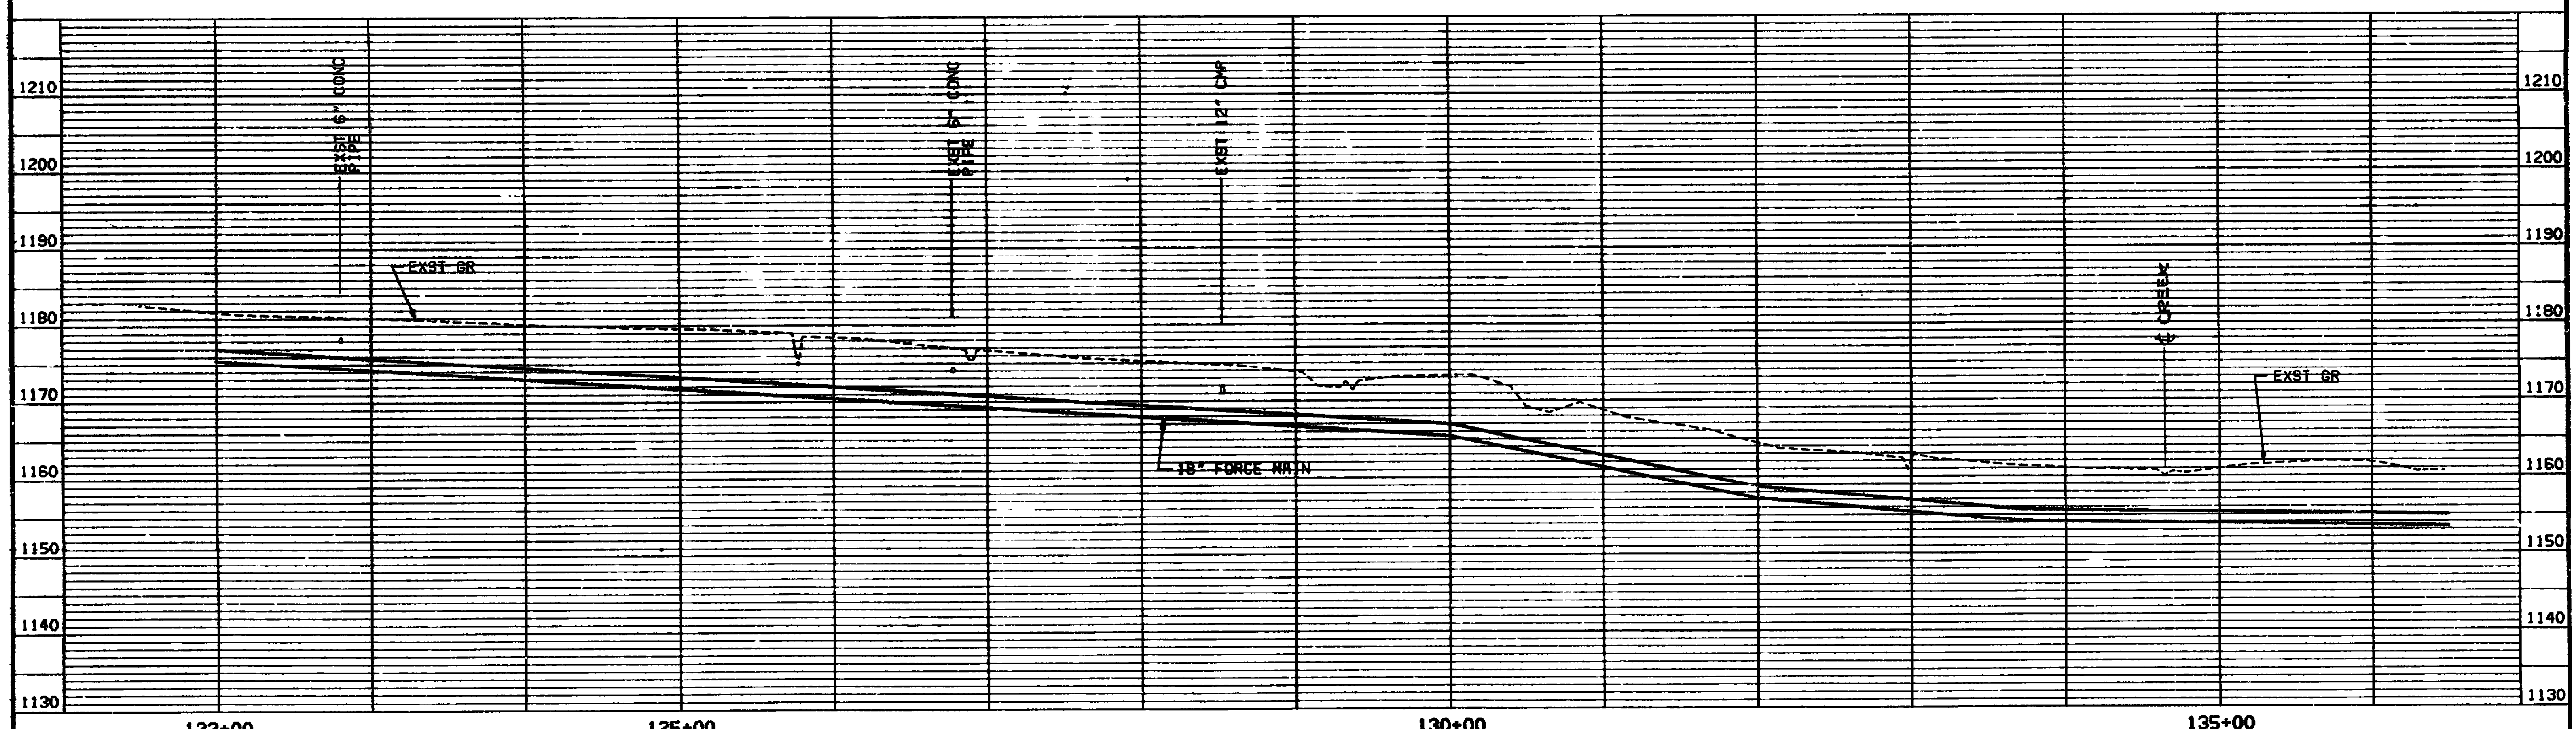


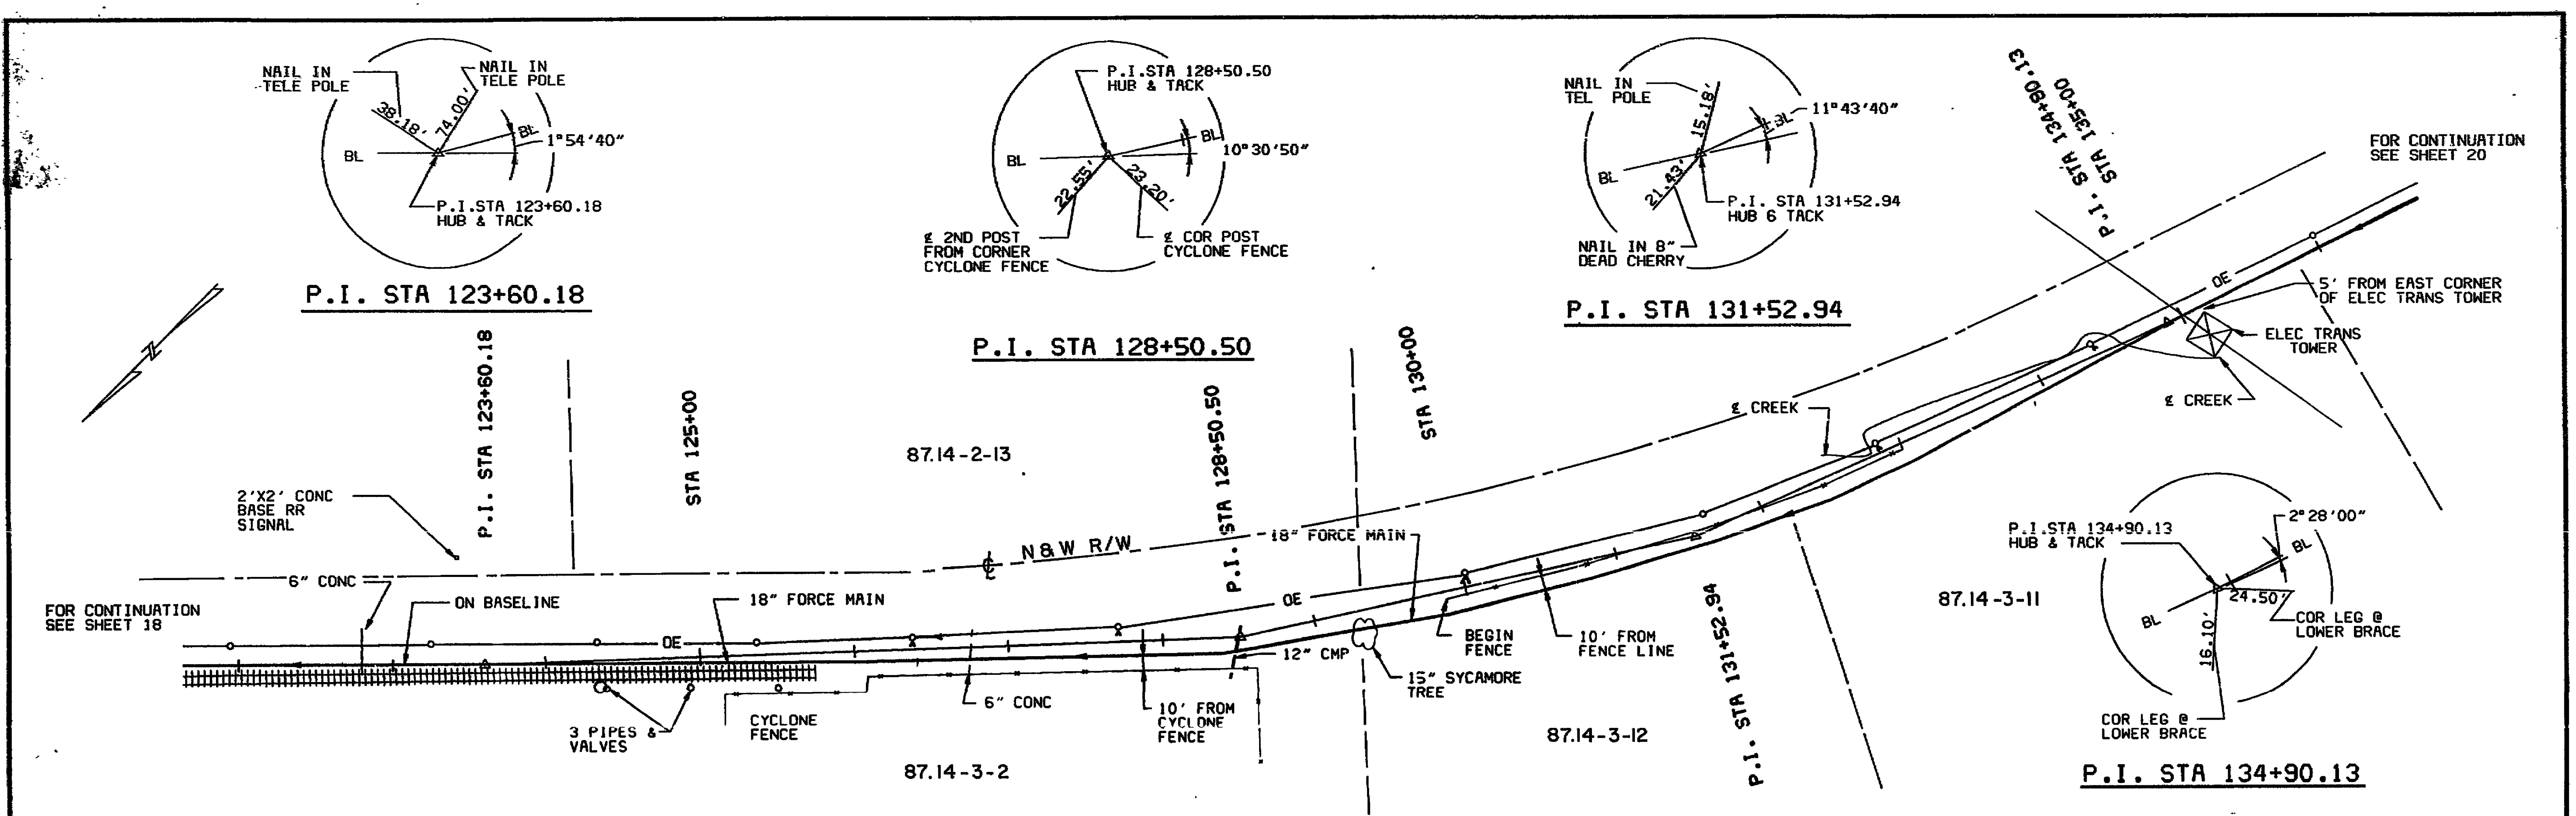

DESIGNED		DATE		BY		REVISIONS		DATE		BY		REVISIONS		DATE		BY		REVISIONS	
DESCRIPTION		DESCRIPTION		DESCRIPTION		DESCRIPTION		DESCRIPTION		DESCRIPTION		DESCRIPTION		DESCRIPTION		DESCRIPTION		DESCRIPTION	
DESIGNED	MJB	DATE	5/15/85	BY		DESCRIPTION		DATE		BY		DESCRIPTION		DATE		BY		DESCRIPTION	
DRAWN	DAM	DATE	5/15/85	BY		DESCRIPTION		DATE		BY		DESCRIPTION		DATE		BY		DESCRIPTION	
CHECKED	MMH	DATE	5/15/85	BY		DESCRIPTION		DATE		BY		DESCRIPTION		DATE		BY		DESCRIPTION	
APPROVED	PRC	DATE	5/15/85	BY		DESCRIPTION		DATE		BY		DESCRIPTION		DATE		BY		DESCRIPTION	

STARKEY SEWAGE PUMP STATION, FORCE MAIN AND GRAVITY SEWER
COUNTY OF ROANOKE, VIRGINIA
11 JANUARY 1985

FORCE MAIN PLAN AND PROFILE
ROUTE 633
STA 122+00 TO STA 136+50

SCALE: HORIZ. 1" = 50'

VERT. 1" = 10'

AS BUILT 8/30/89

