
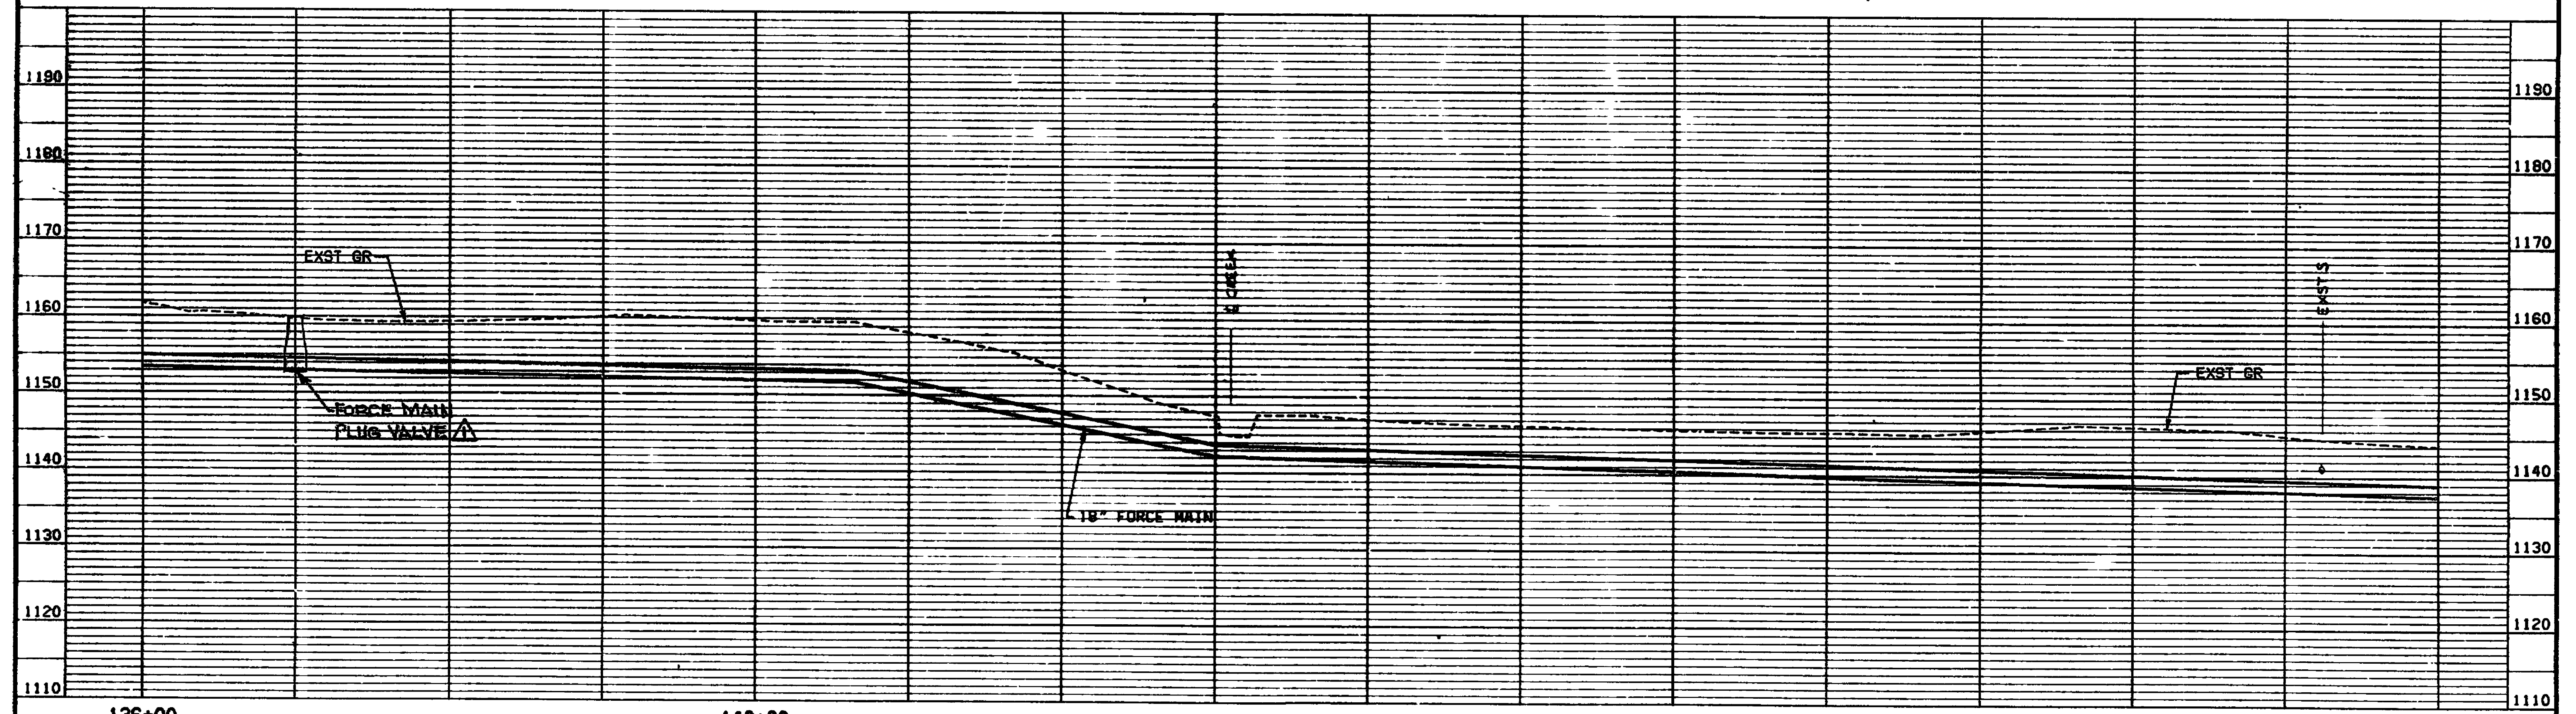


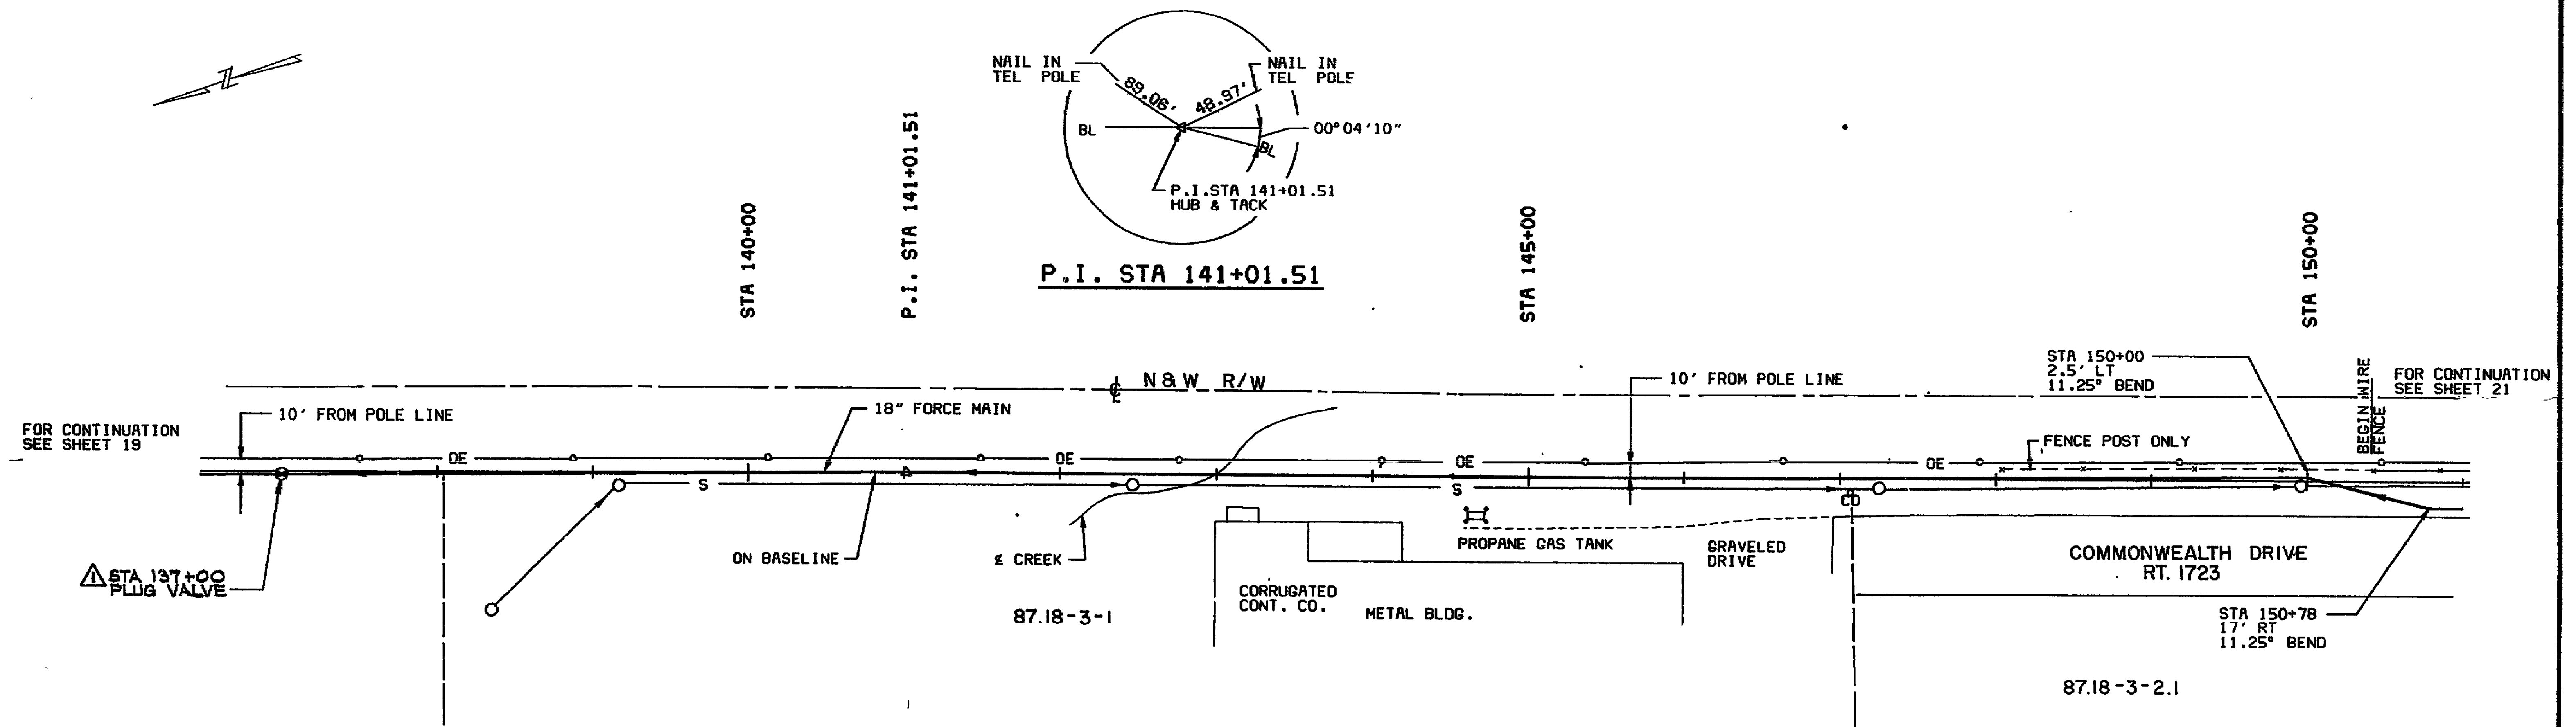

DESIGNED <i>MLB</i>	DATE <i>7/19/88</i>	BY <i>SG</i>	DESCRIPTION <i>REV PER ADDENDUM 12/2/87</i>	DATE	BY	DESCRIPTION
DRAWN <i>Drm</i>						
CHECKED <i>AWM</i>						
APPROVED <i>RBC</i>						

STARKEY SEWAGE PUMP STATION, FORCE MAIN AND GRAVITY SEWER
COUNTY OF ROANOKE, VIRGINIA
11 JANUARY 1985

HAYES, SEAY, MATTERN AND MATTERN
ARCHITECTS - ENGINEERS - PLANNERS

FORCE MAIN PLAN AND PROFILE
ROUTE 1723
STA 136+50 TO 151+00

SCALE: HORIZ. 1" = 50'
VERT. 1" = 10'

CONC. NO. *17-1185*

DRAWING NO. *84-138*

