
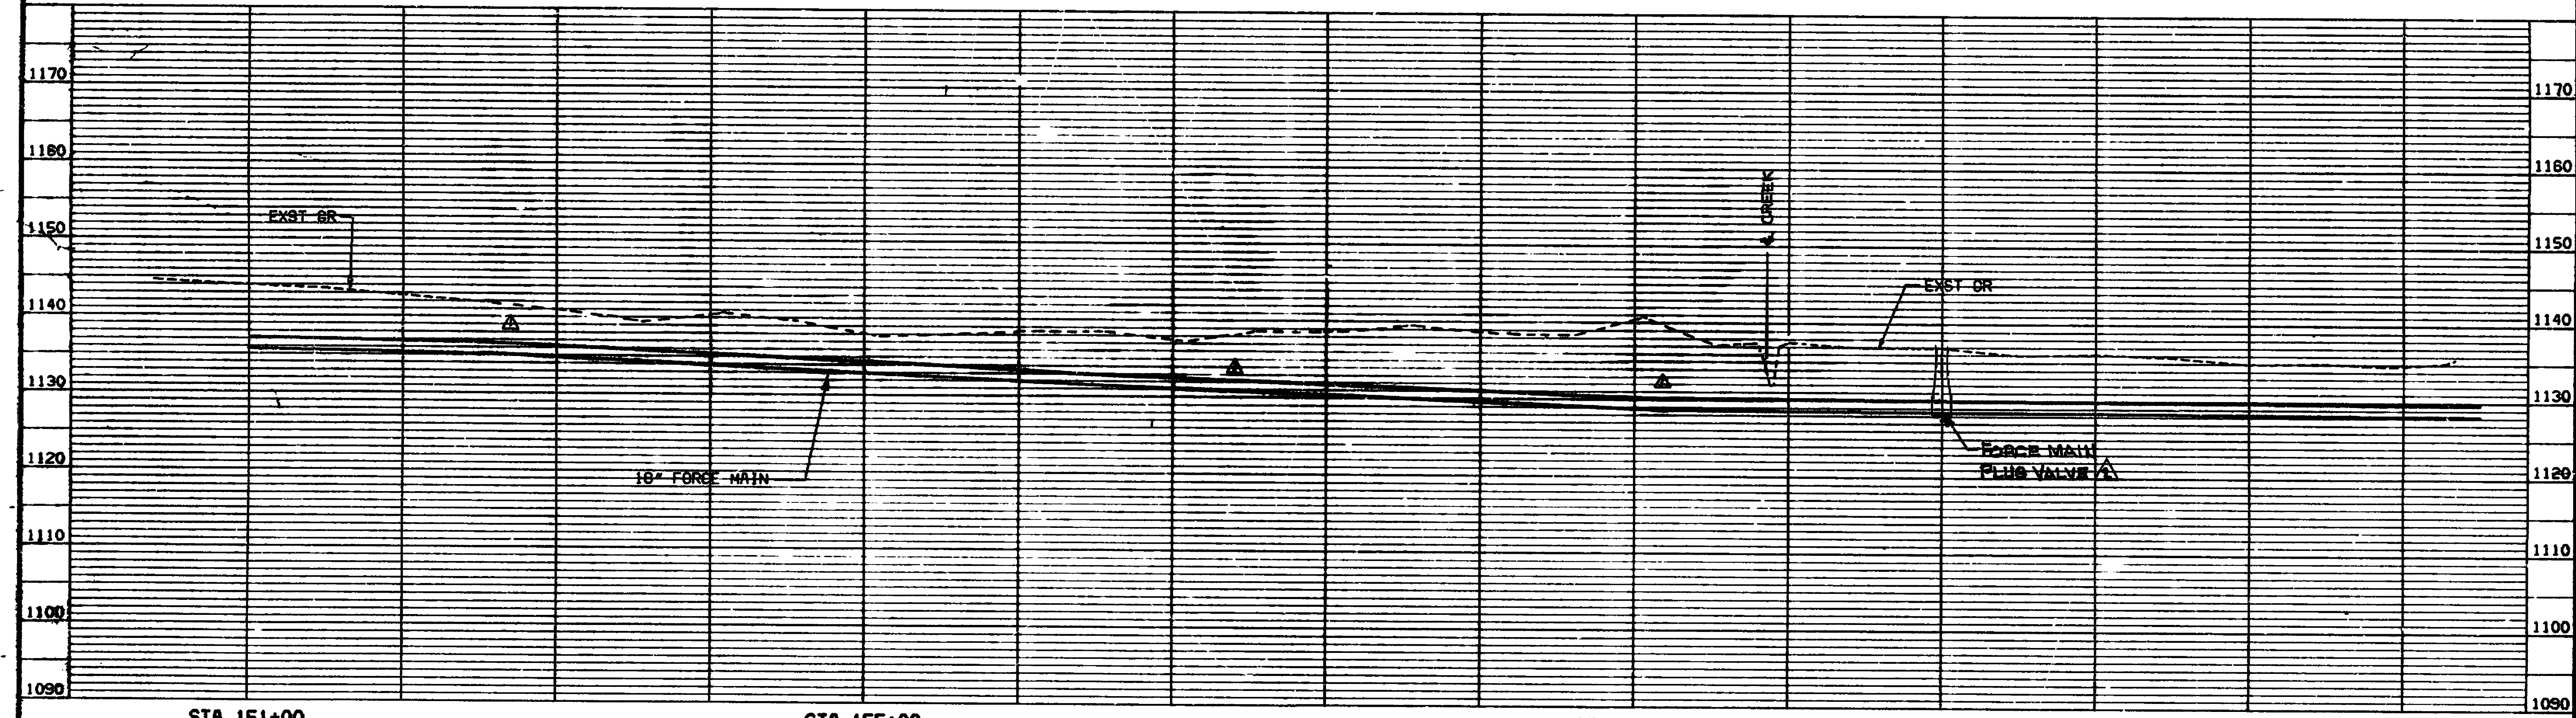


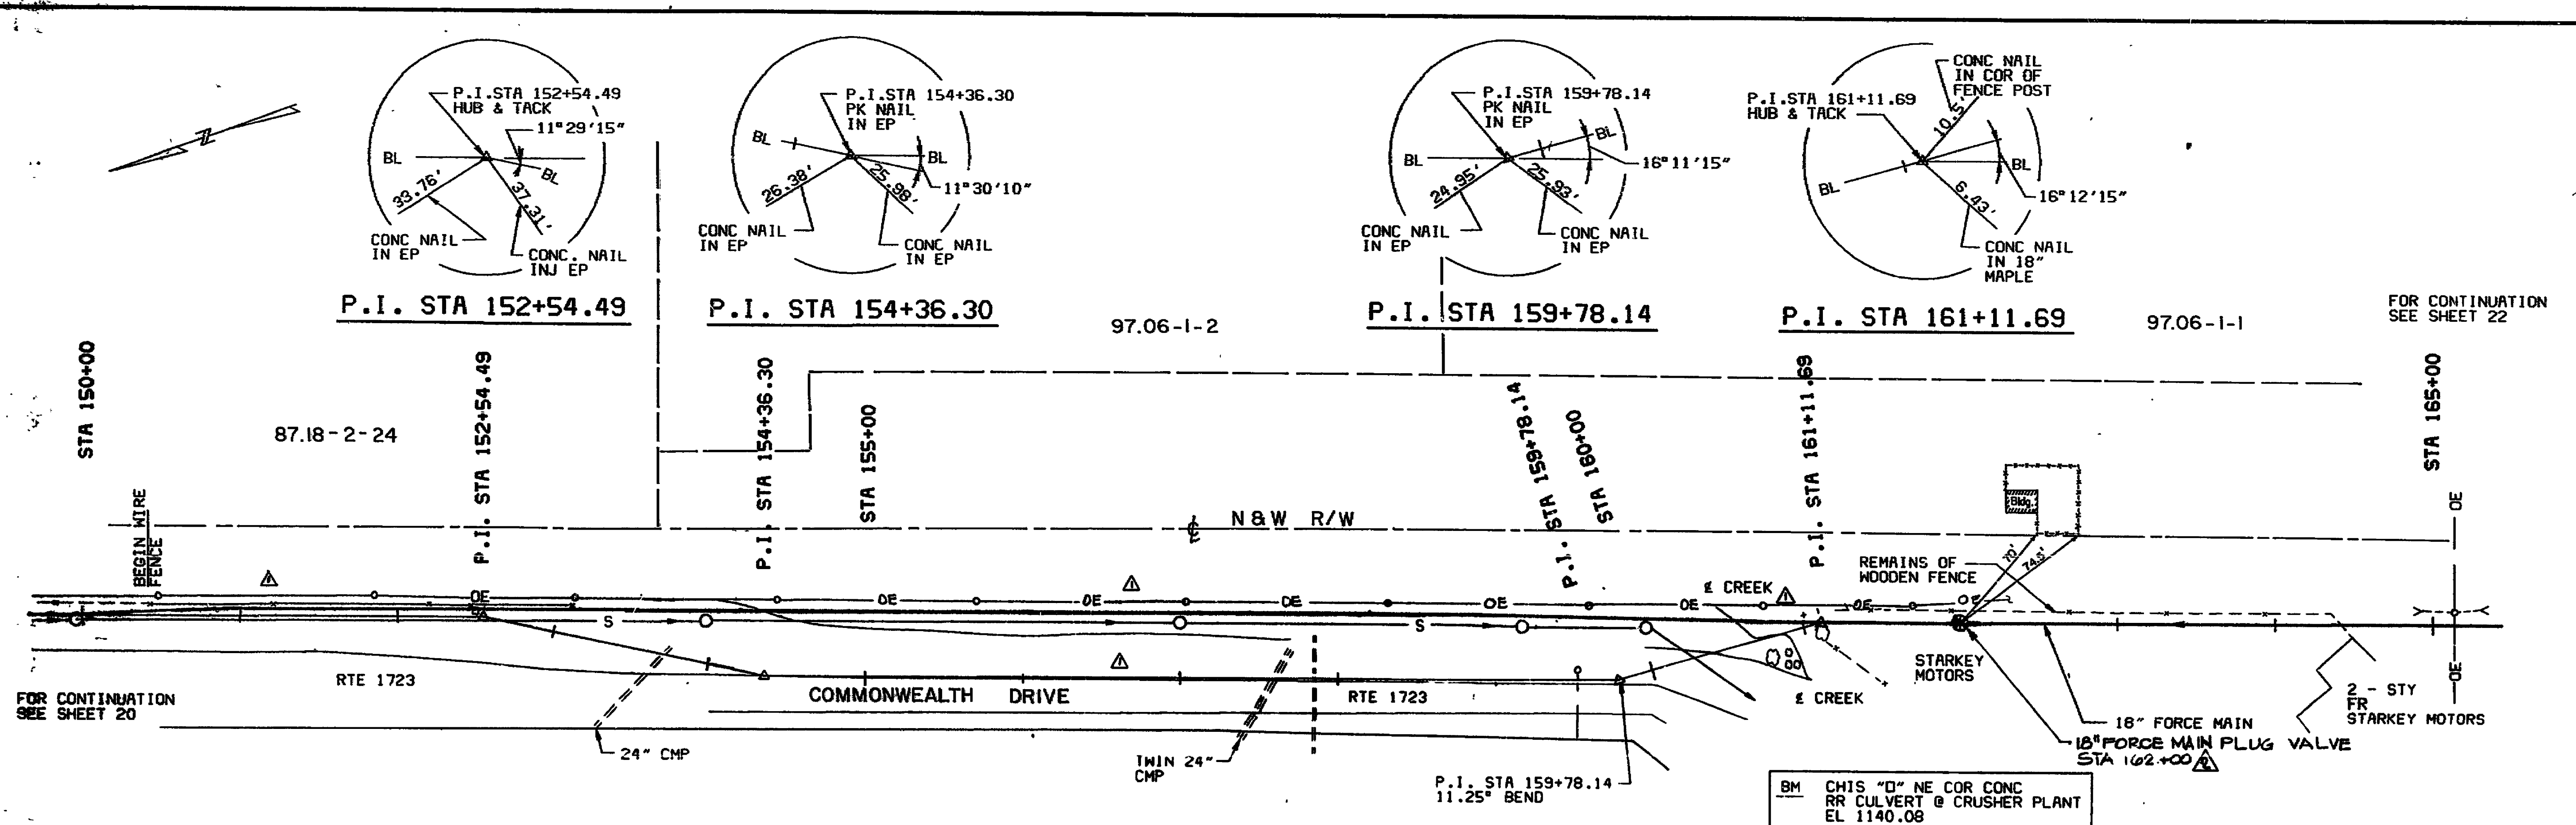

DESIGNED				DATE				BY				DESCRIPTION			
M.A.				7/19/85				A.C.B.				REALIGNMENT			
DRAWN				7/19/85				S.H.				REV PER ADDENDUM #2 1/2/87			
CHECKED															
APPROVED															

STARKEY SEWAGE PUMP STATION, FORCE MAIN AND GRAVITY SEWER
COUNTY OF ROANOKE, VIRGINIA
11 JANUARY 1985
HAYES, SEAY, MATTERN AND MATTERN
ARCHITECTS - ENGINEERS - PLANNERS

STARKEY JR.
1978

FORCE MAIN - PLAN AND PROFILE
ROUTE 613
STA 151+00 TO STA 165+50

SCALE: HORIZ 1" = 50'
VERT 1" = 10'

COM. NO. 84-1-S
DRAWING NO. 84-1-S

