



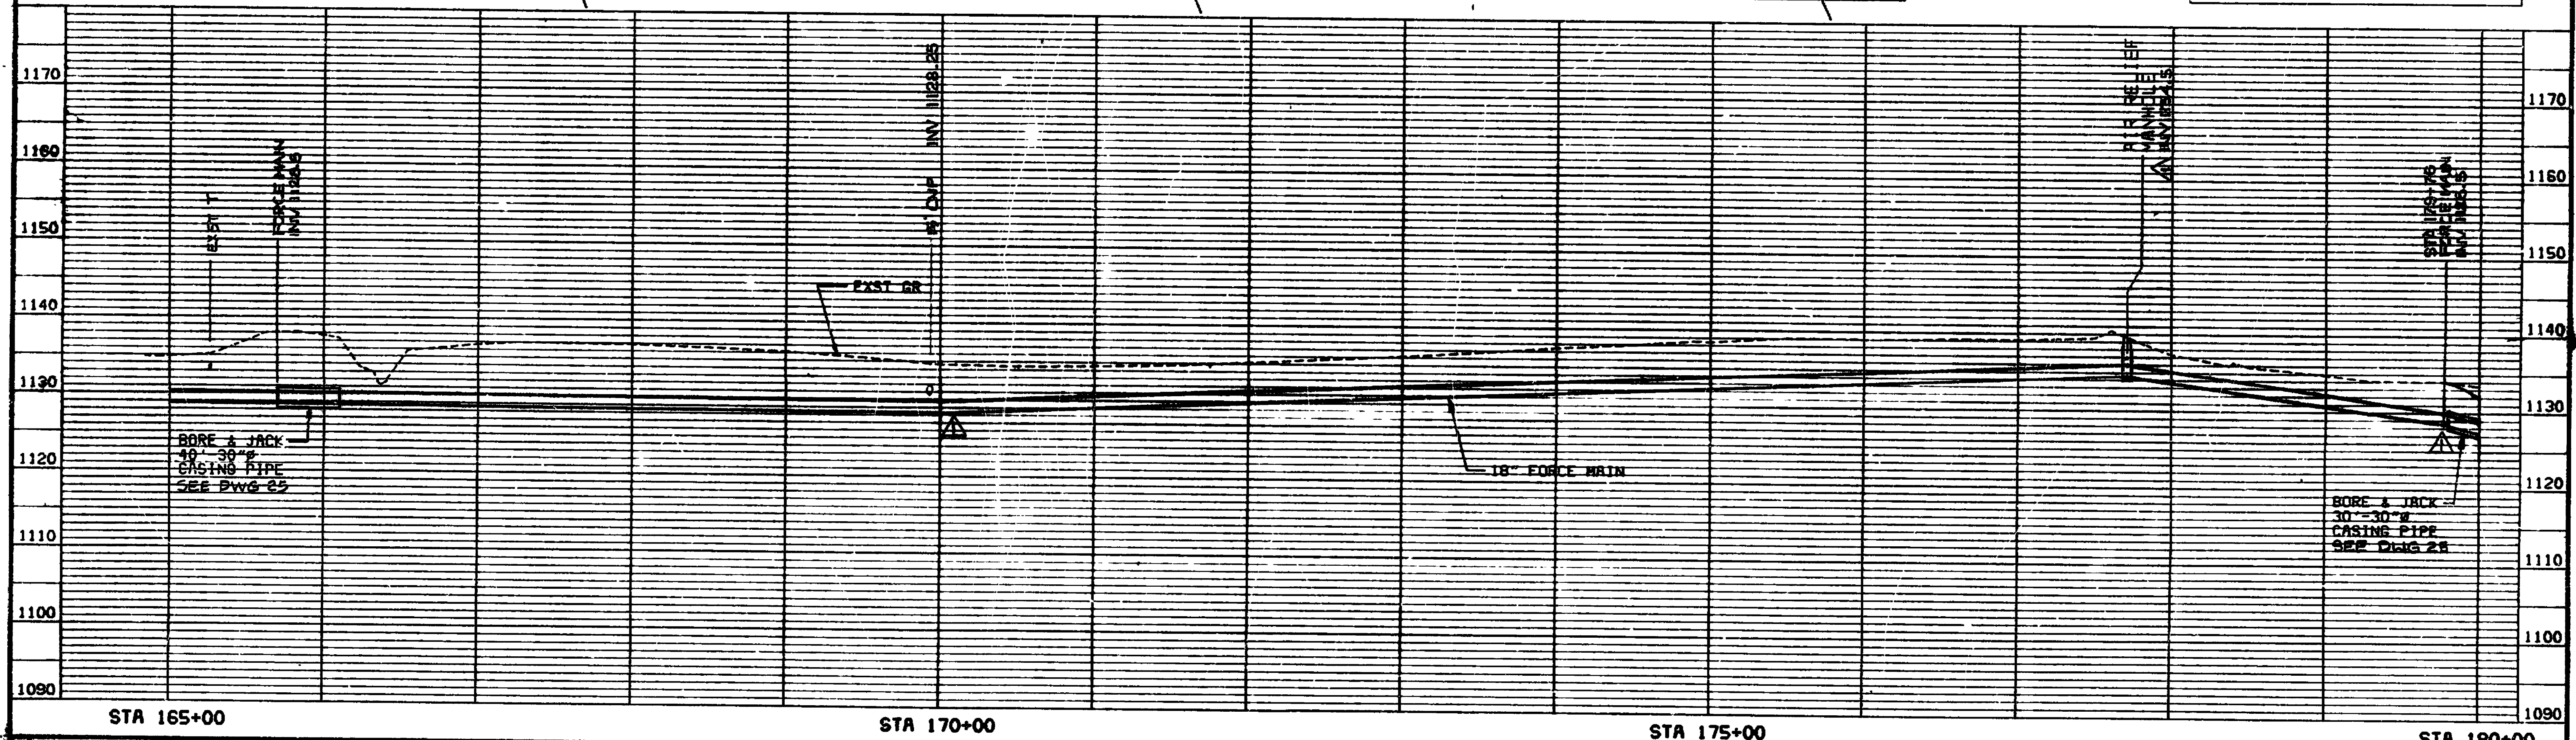

DESTIGNED <i>MLB</i> DRAWN <i>DM</i> CHECKED <i>MM</i> APPROVED <i>RL</i>	<table border="1" style="width: 100%; border-collapse: collapse;"> <tr> <th colspan="4">REVISIONS</th> </tr> <tr> <th>DATE</th> <th>BY</th> <th>DESCRIPTION</th> <th></th> </tr> <tr> <td>7/19/88</td> <td>SG</td> <td>REV PER ADDENDUM 2 12/87</td> <td></td> </tr> </table>	REVISIONS				DATE	BY	DESCRIPTION		7/19/88	SG	REV PER ADDENDUM 2 12/87			STARKEY SEWAGE PUMP STATION, FORCE MAIN AND GRAVITY SEWER COUNTY OF ROANOKE, VIRGINIA 11 JANUARY 1985 HAYES, SEAY, MATTERN AND MATTERN ARCHITECTS - ENGINEERS - PLANNERS	FORCE MAIN - PLAN AND PROFILE ROUTE 613 STA 165+50 TO STA 180+00
REVISIONS																
DATE	BY	DESCRIPTION														
7/19/88	SG	REV PER ADDENDUM 2 12/87														

SCALE: HORIZ. 1" = 50'
 VERT. 1" = 10'

AS BUILT 8/30/89

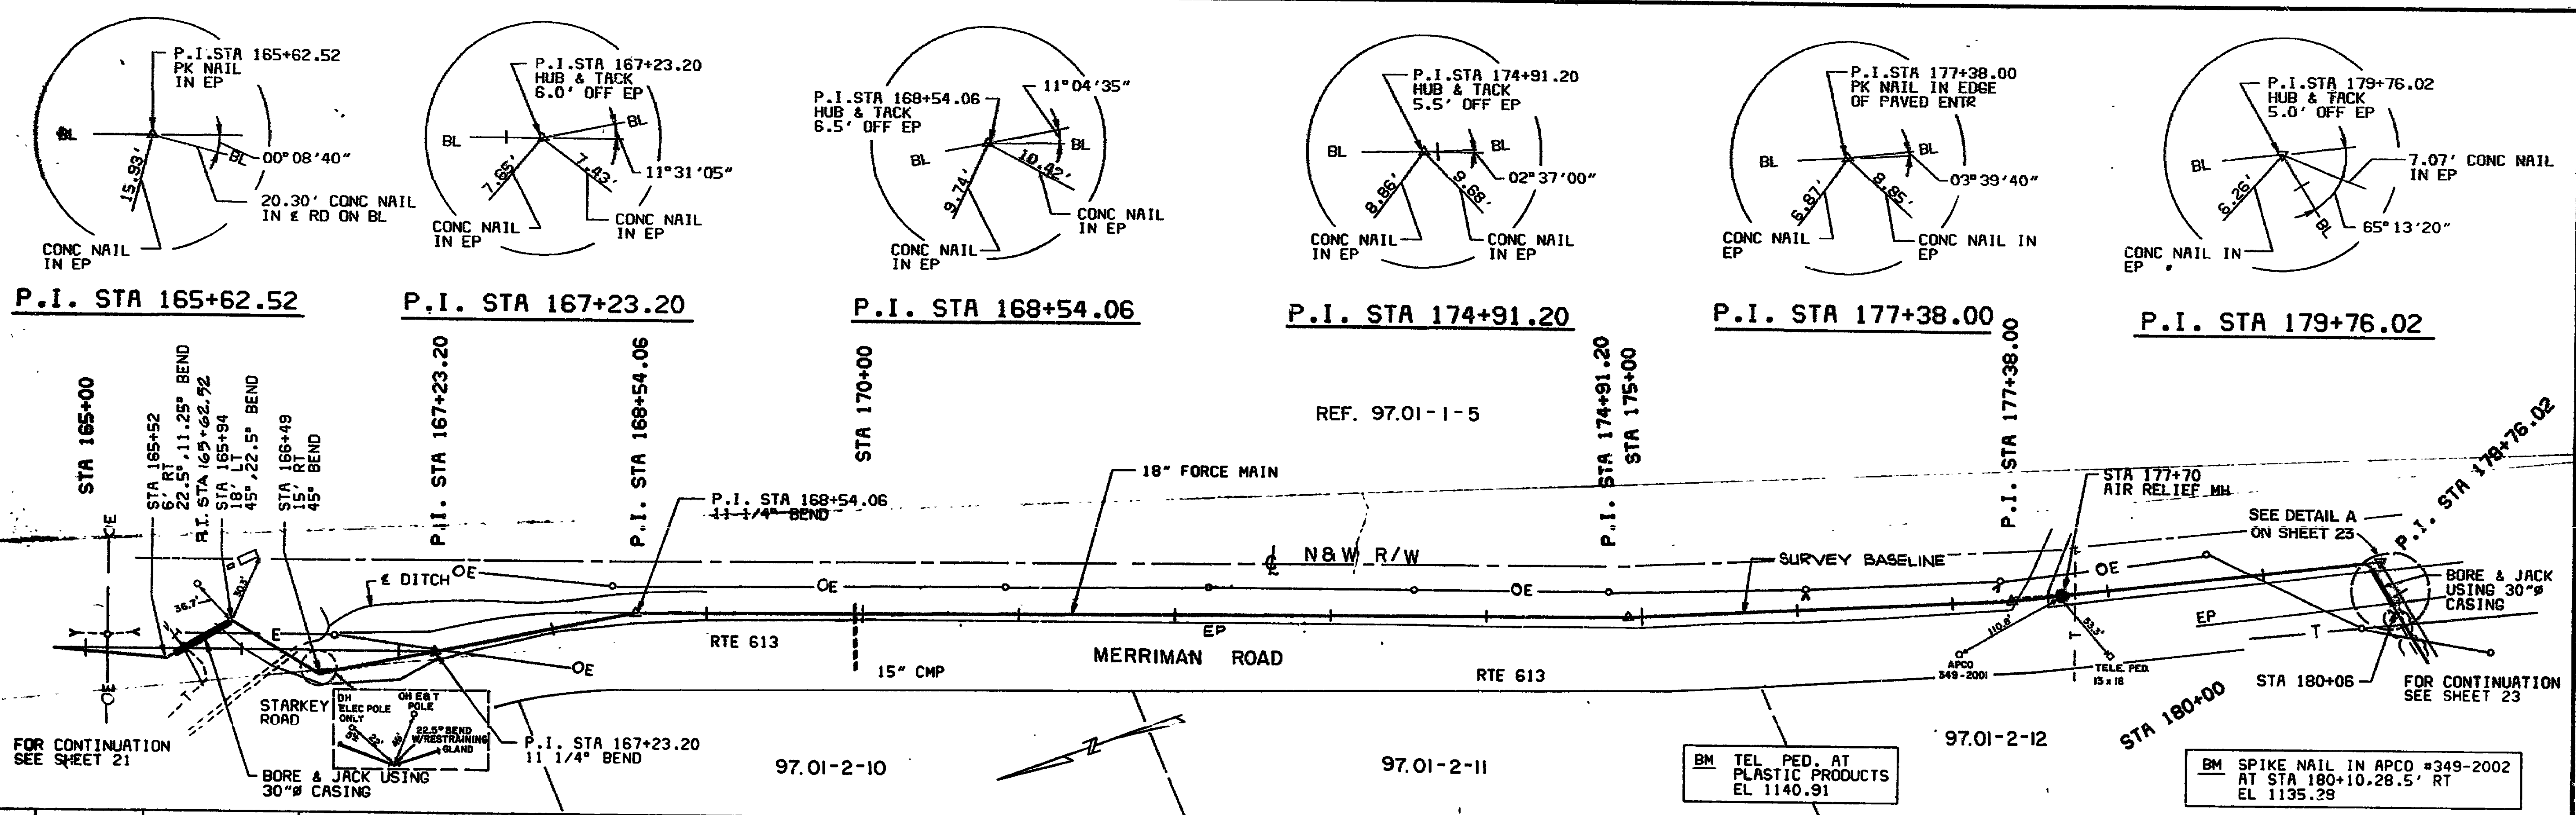