



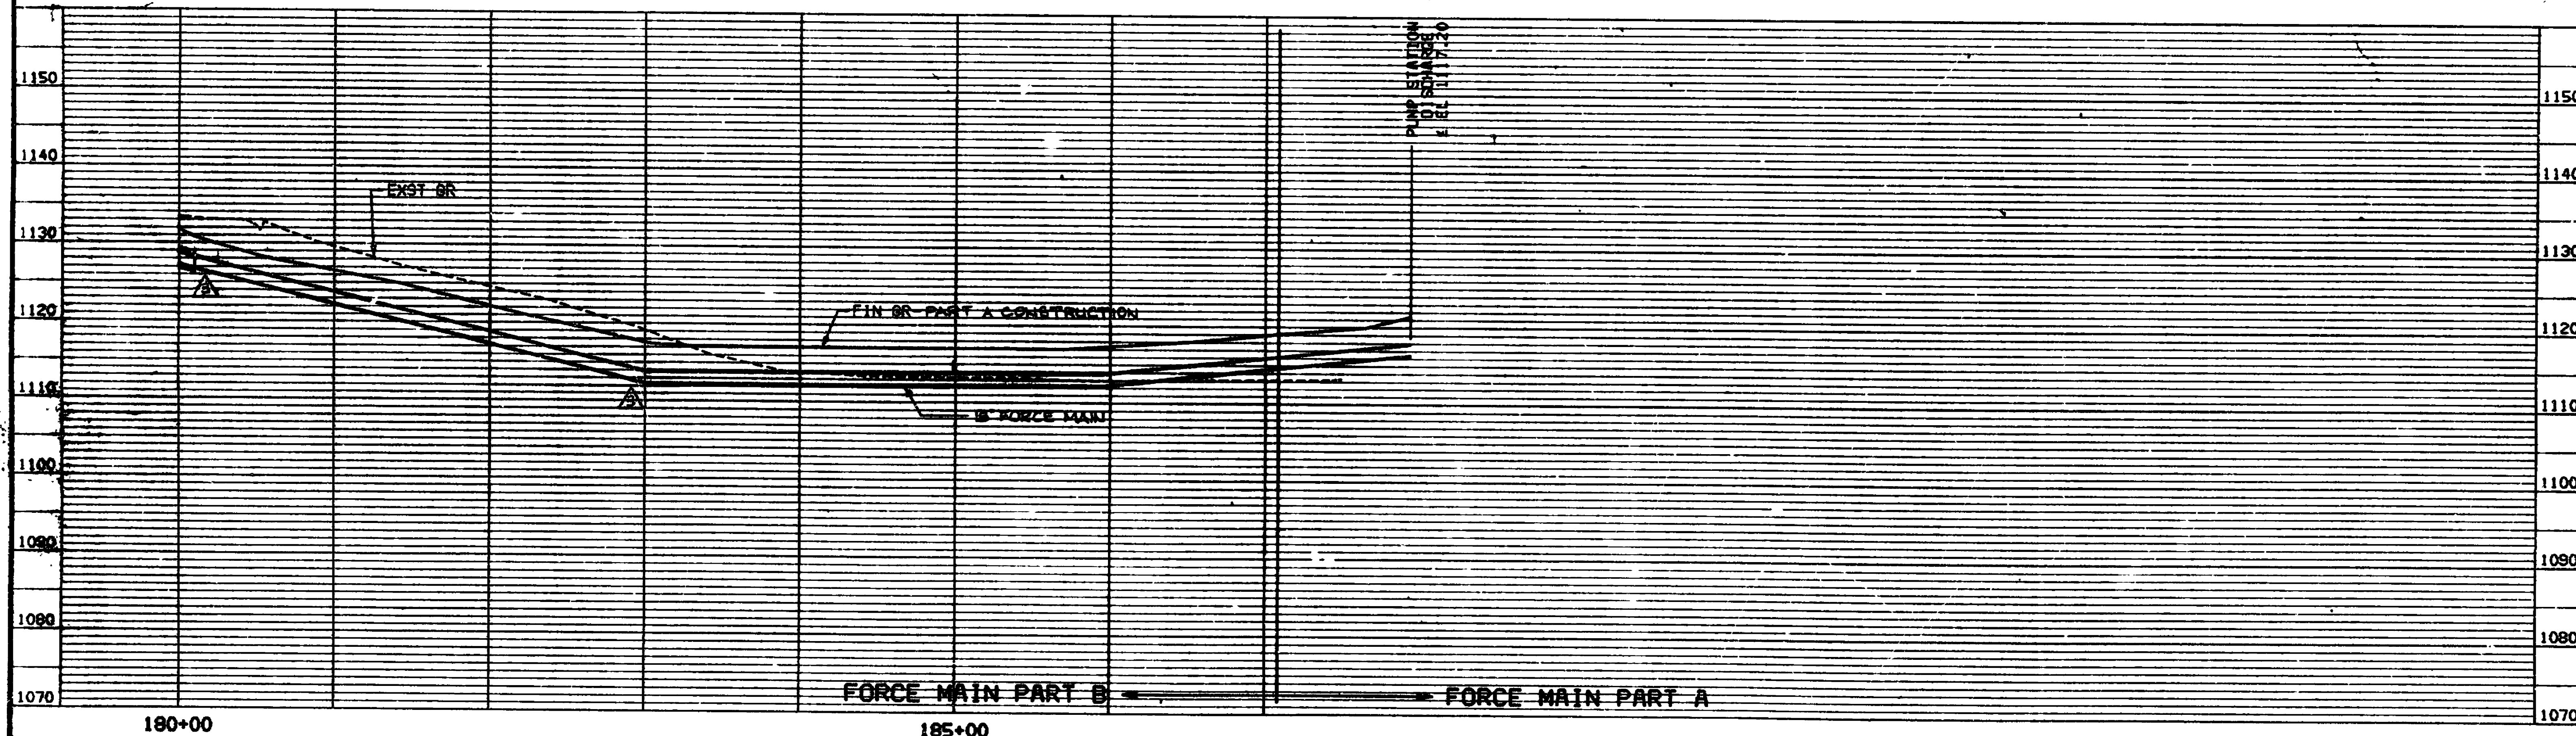

DESIGNED <i>MCR</i>	DATE <i>5/1/85</i>	BY <i>MCS</i>	DESCRIPTION <i>REVISIONS PER ROANOKE CO 8/1/85</i>	DATE <i>8/1/85</i>	BY <i>SG</i>	DESCRIPTION <i>REV. PER ADDENDUM #2 12/85</i>
DRAWN <i>DM</i>	DATE <i>5/1/85</i>	BY <i>SG</i>				
CHECKED <i>AMM</i>	DATE <i>5/1/85</i>					
APPROVED <i>RDC</i>	DATE <i>5/1/85</i>					

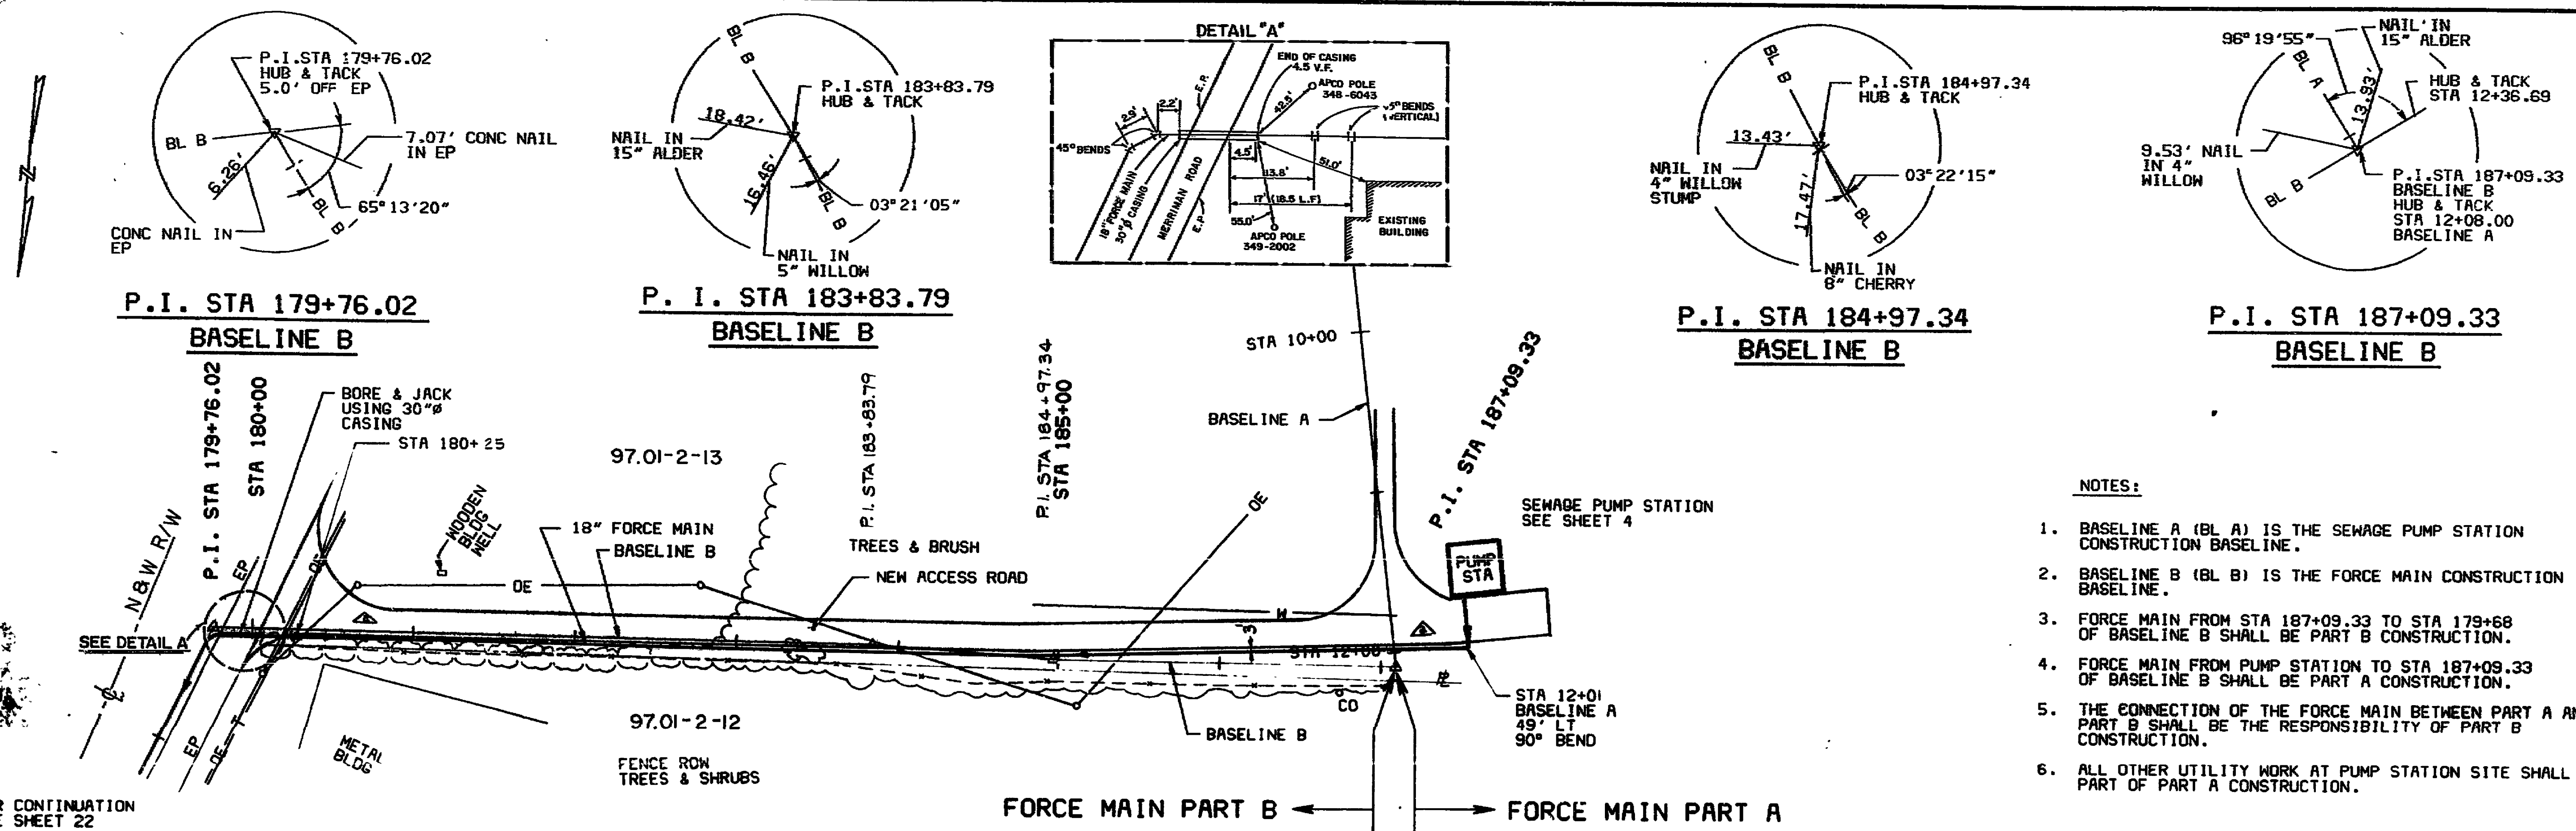

STARKEY SEWAGE PUMP STATION, FORCE MAIN AND GRAVITY SEWER
COUNTY OF ROANOKE, VIRGINIA
11 JANUARY 1985
 HAYES, SEAY, MATTERN AND MATTERN
 ARCHITECTS - ENGINEERS - PLANNERS

FORCE MAIN PLAN AND PROFILE
ROUTE 613
STA 180+00 TO END

SCALE: HORIZ 1" = 50'
 VERT 1" = 10'

AS BUILT 8/30/89 84-1-S