



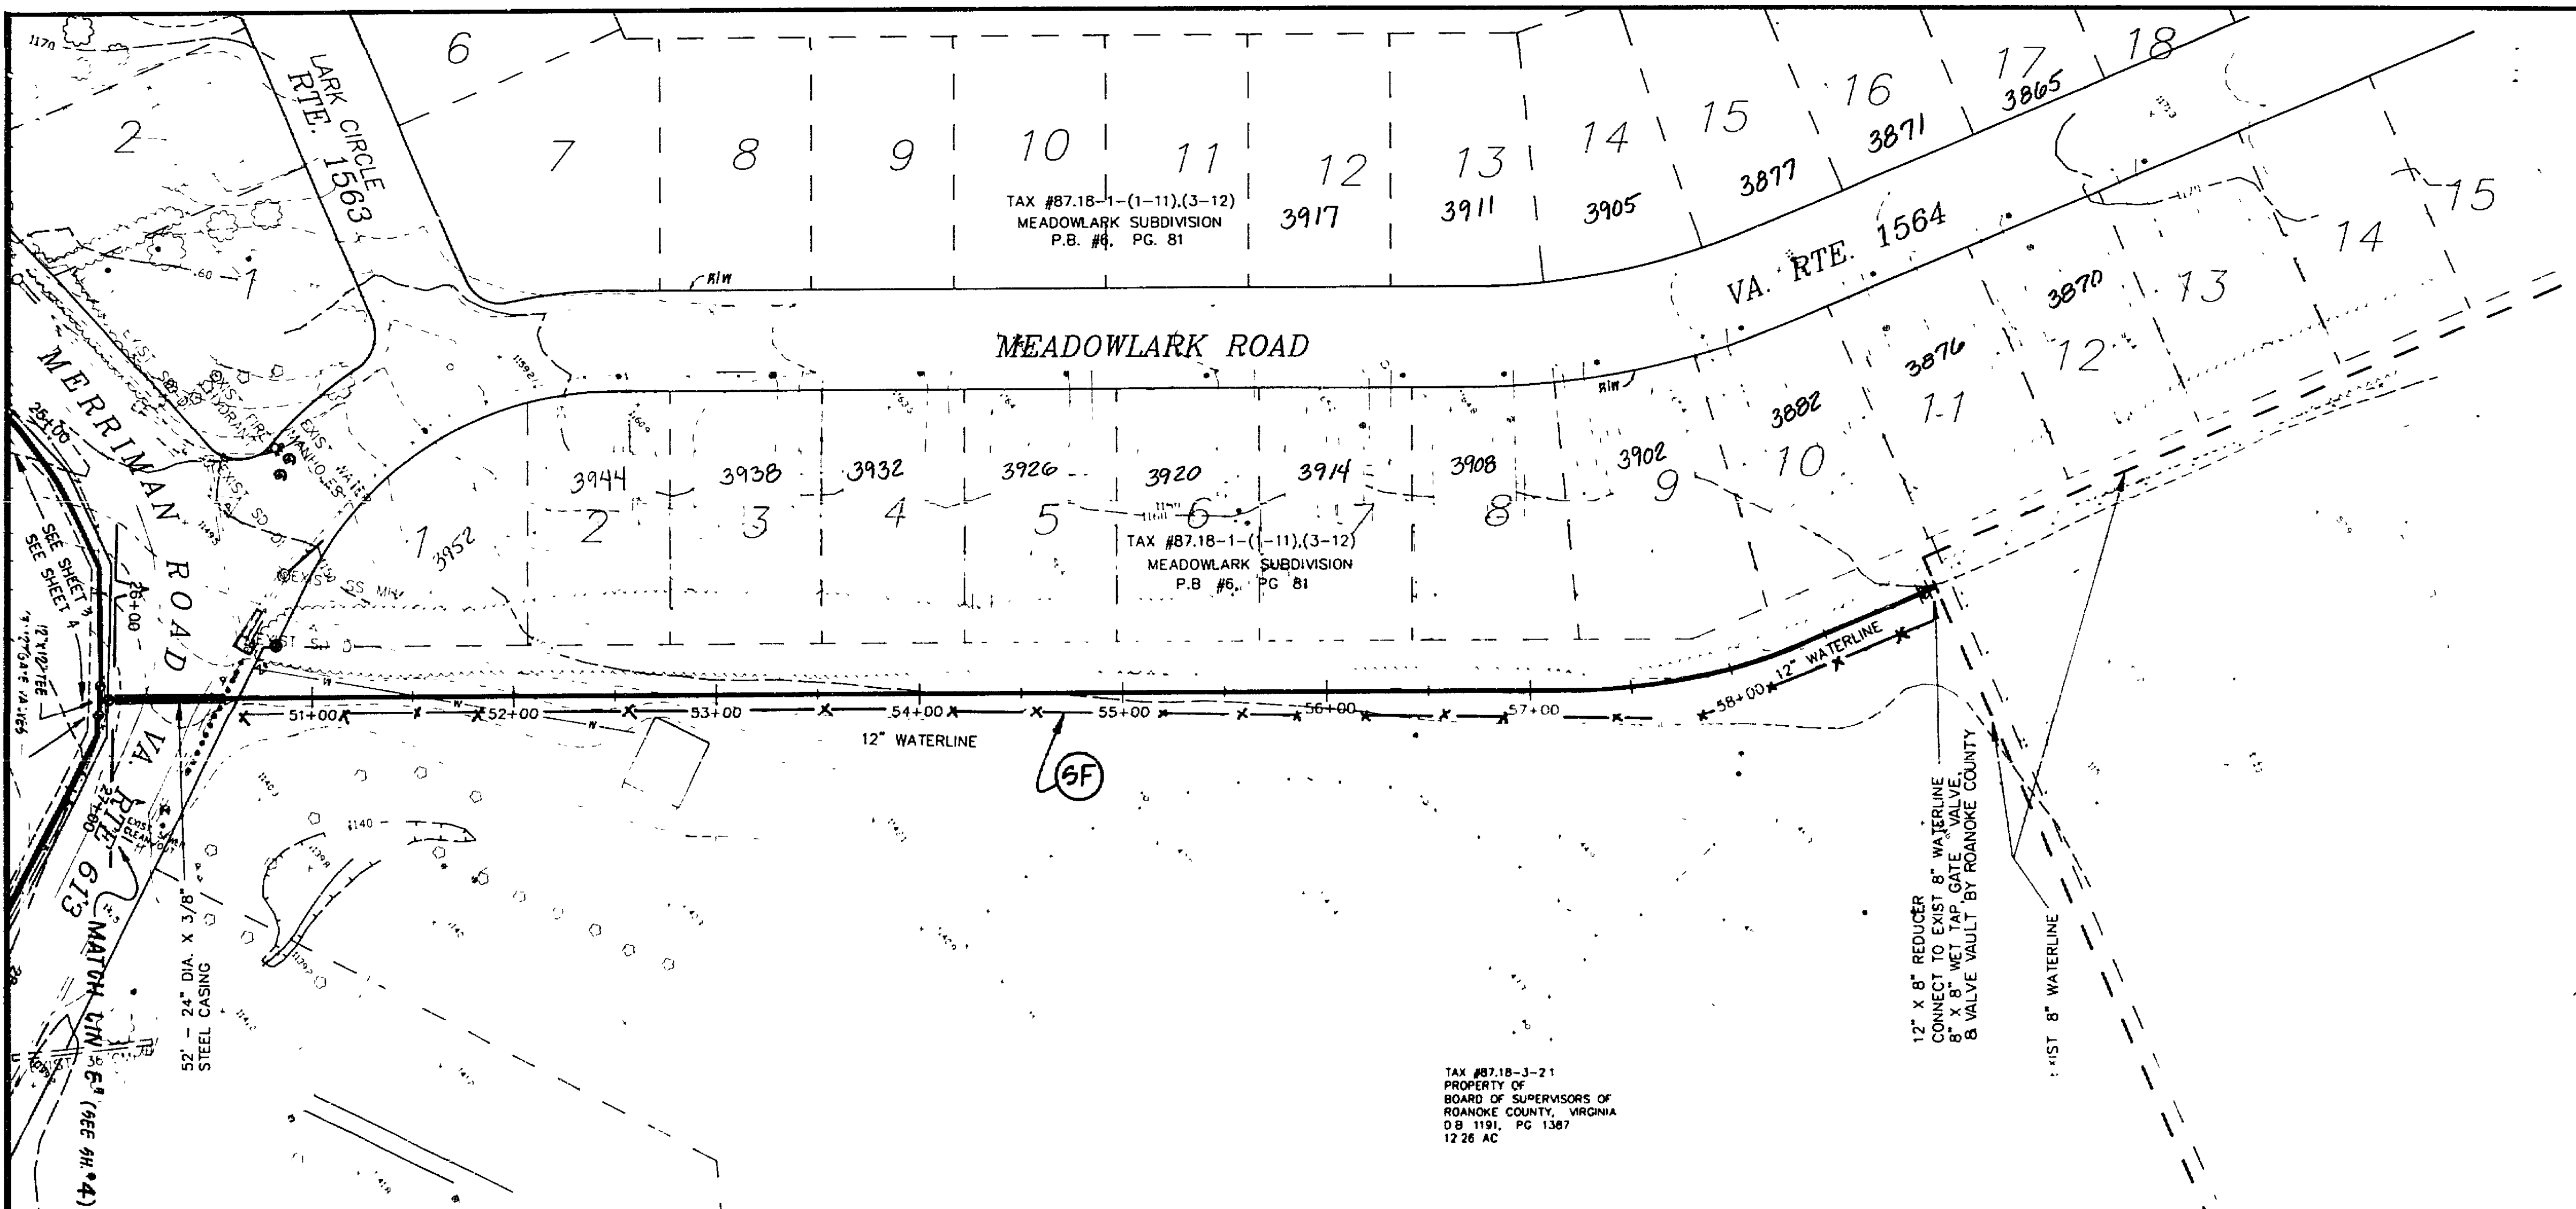

KEY	NO.	EROSION CONTROL LEGEND	SYMBOL
CE	3.02	TEMPORARY STONE CONSTRUCTION ENTRANCE	
PS	3.32	PERMANENT SLEDDING	
SF	3.05	SILT FENCE	
DD	3.09	TEMPORARY DIVERSION DIKE	
CRS	3.03	CONSTRUCTION ROAD STABILIZATION	
CD	3.20	ROCK CHECK DAMS	
IP	3.07	STORM DRAIN INLET PROTECTION	
OP	3.18	OUTLET PROTECTION	

STORM DRAIN STRUCTURES, WATER VALVES AND SANITARY SEWER MANHOLES ARE BASED ON ACTUAL FIELD LOCATION. ALL OTHER UNDERGROUND UTILITIES ARE BASED ON LOCATION BY RESPECTIVE UTILITY COMPANIES AND ARE APPROXIMATE AND SHOULD BE FIELD VERIFIED BEFORE CONSTRUCTION.

LEGEND	
	OVERHEAD ELECTRIC
	UNDERGROUND ELECTRIC
	GAS
	WATER LINE
	SANITARY SEWER LINE
	STORM PIPE
	GUARD RAIL
	CHAIN LINK FENCE
	POWER POLE
	PROP. WATER
	FIRE HYD.
	GATE VALVE
	AIR RELEASE ASSEMBLY
	BLOW-OFF
	HEDGE ROW
	SHRUBS
	TREES
	SPOT ELEVATION

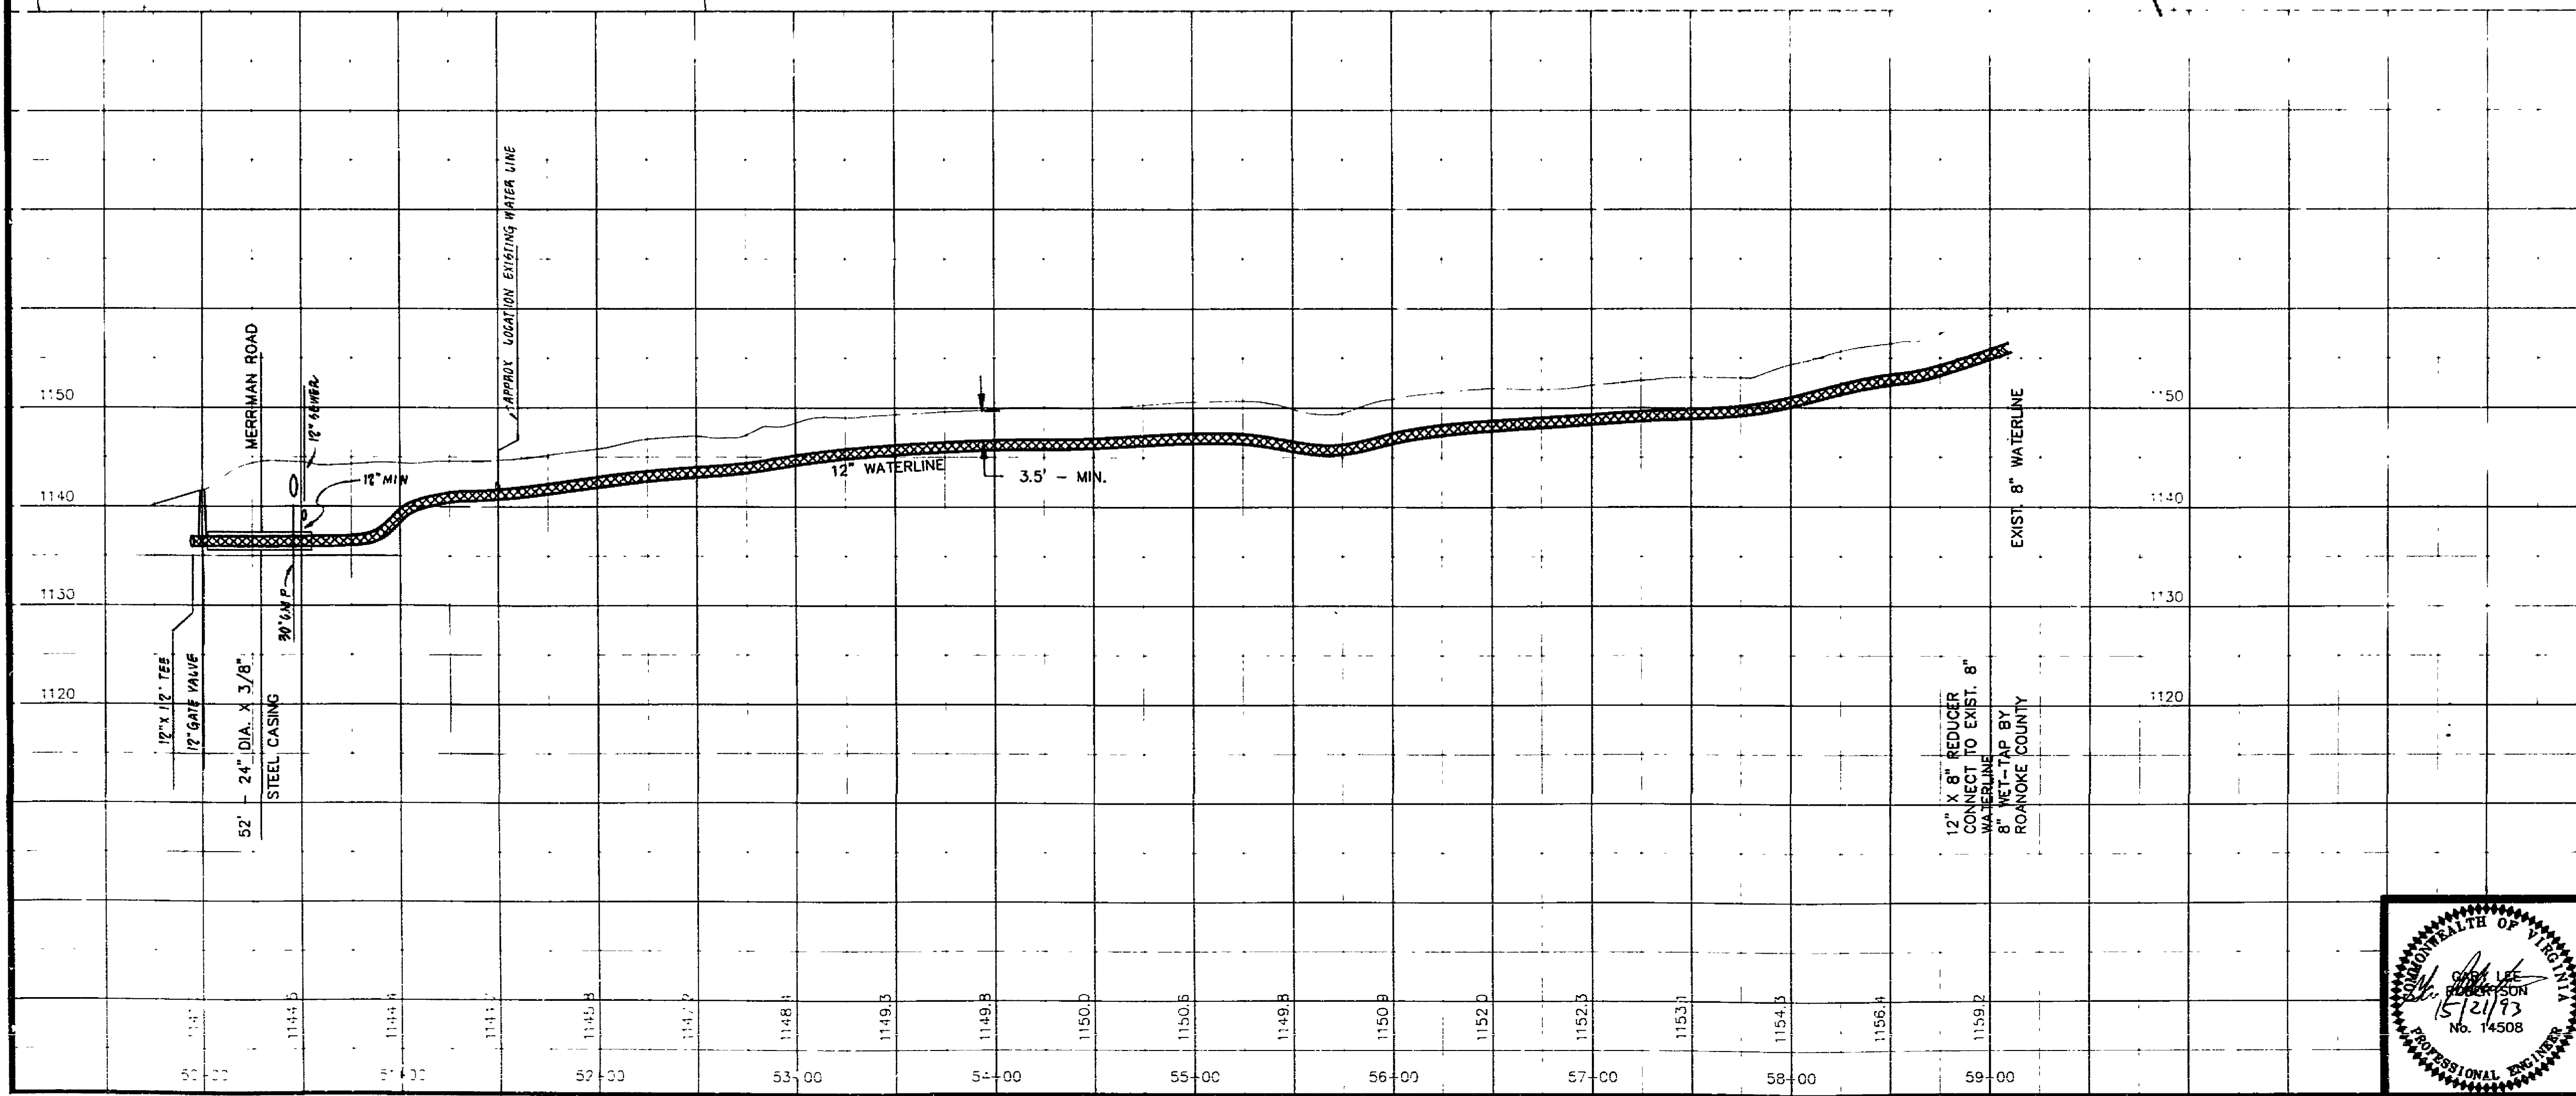

2

5-17-93

ADDED EXISTING WATERLINE

1

9-2-93

COMBINED CONSTRUCTION PHASES

DESIGNED - G.P.-V.S.

DRAWN - FOR - P.W.

CHECKED - G.P.

PLAN & PROFILE

FOR

STARKEY ROAD

WATERLINE EXTENSION

PREPARED FOR

ROANOKE COUNTY UTILITY DEPARTMENT

CAVE SPRING MAGISTERIAL DISTRICT

ROANOKE COUNTY, VIRGINIA

LUMSDEN ASSOCIATES, P.C.

ENGINEERS-SURVEYORS-PLANNERS


ROANOKE, VIRGINIA

SCALE: 1" = 50' (HORIZ.)

SCALE: 1" = 10' (VERT.)

DATE: 1 NOV 1990

SHEET 9 OF 12

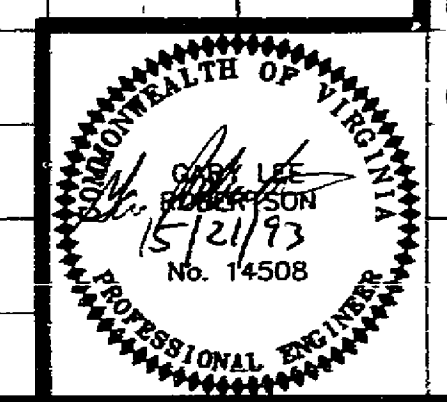

WT-0363