
 


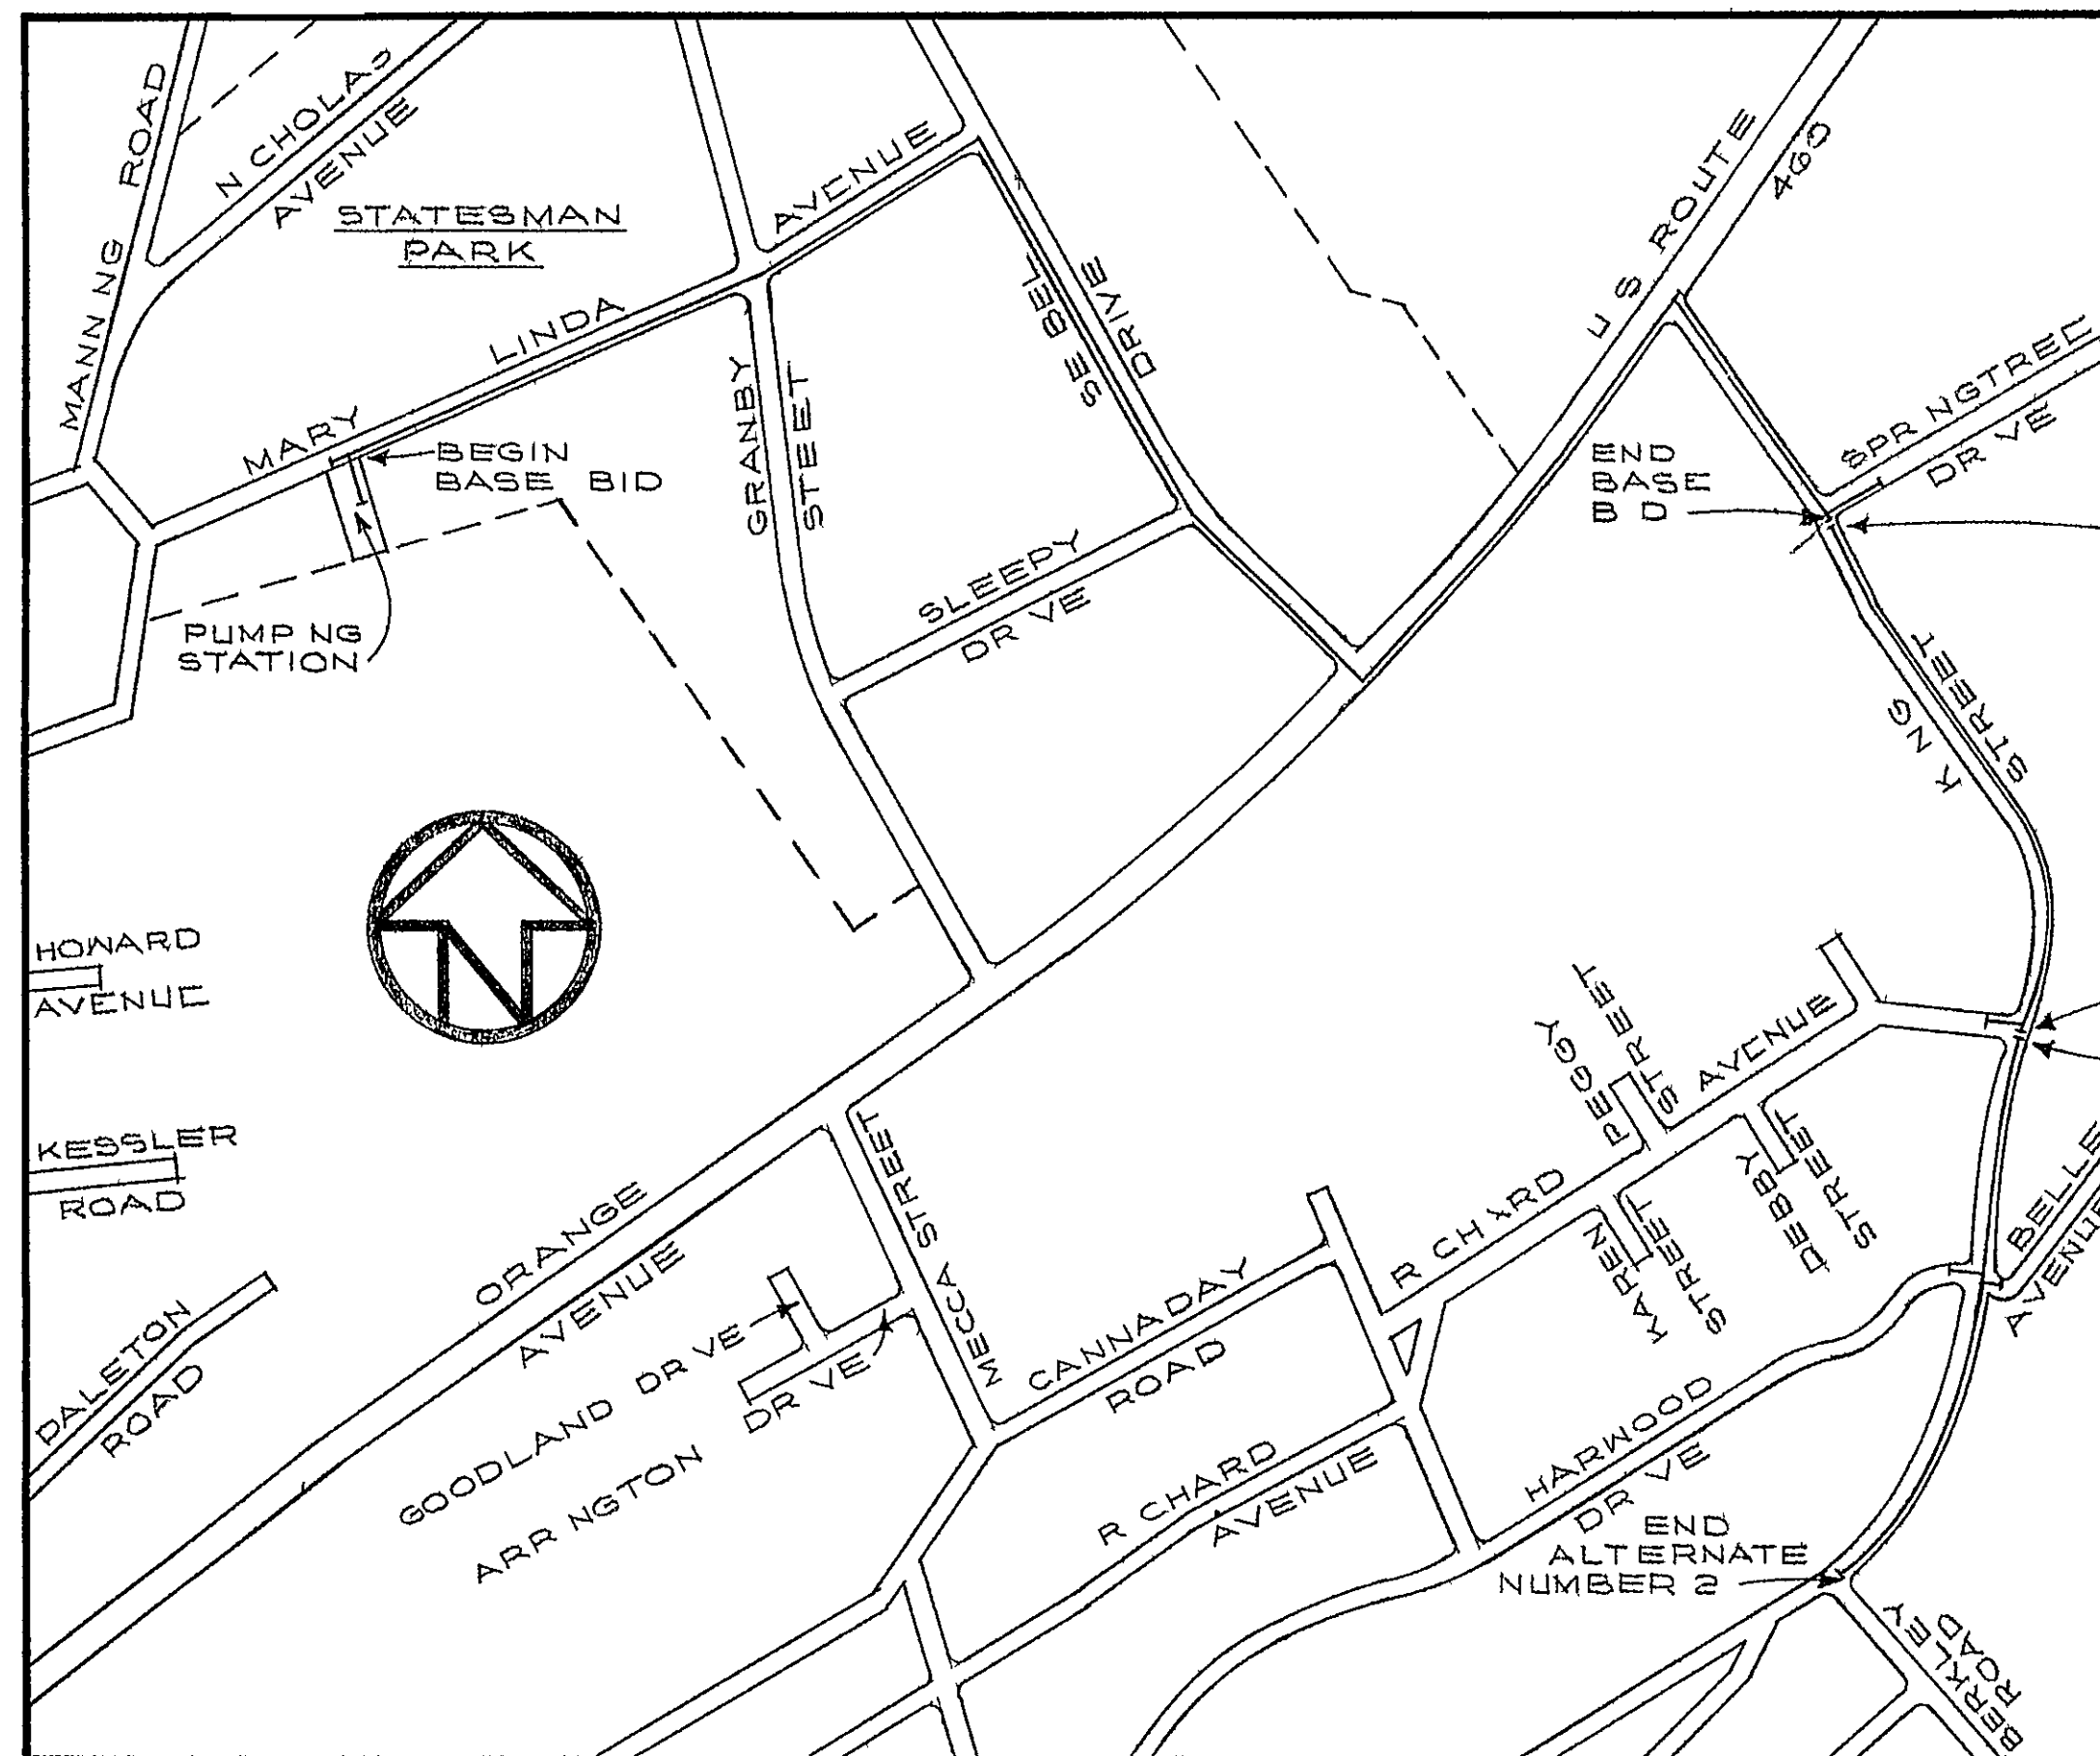


VICINITY MAP




GENERAL NOTES

NOTE 1 20"x20"x20" TEE EXISTS WITH BLIND FLANGE, REMOVE BLIND FLANGE AND INSTALL 12"x20" REDUCER, 12" GATE VALVE AND VAULT, 12"x20" REDUCER

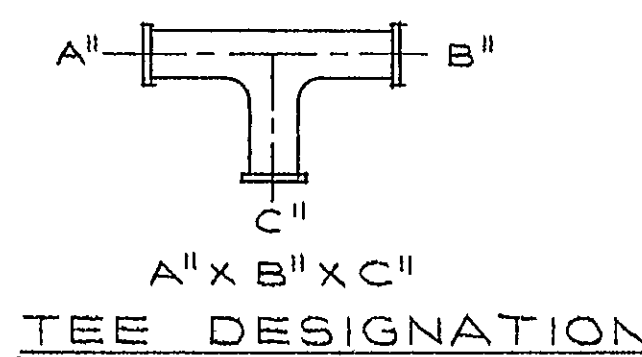

LEGEND	
—T—	UNDERGROUND TELEPHONE CABLE
—G—	UNDERGROUND GAS MAIN
—E—	UNDERGROUND ELECTRIC CABLE
—SS—	UNDERGROUND SANITARY SEWER
—	NEW WATER LINE
----	EXISTING WATER LINE
—●—	NEW VALVE AND VAULT
—○—	EXISTING VALVE AND VAULT
+	HYDRANT LATERAL 6" DUCTILE IRON PIPE
✱	HYDRANT LATERAL WITH HYDRANT
—	STREET RIGHT-OF-WAY (INCLUSIVE)
□	EXISTING METER BOX (SERVICE AS REQ'D)

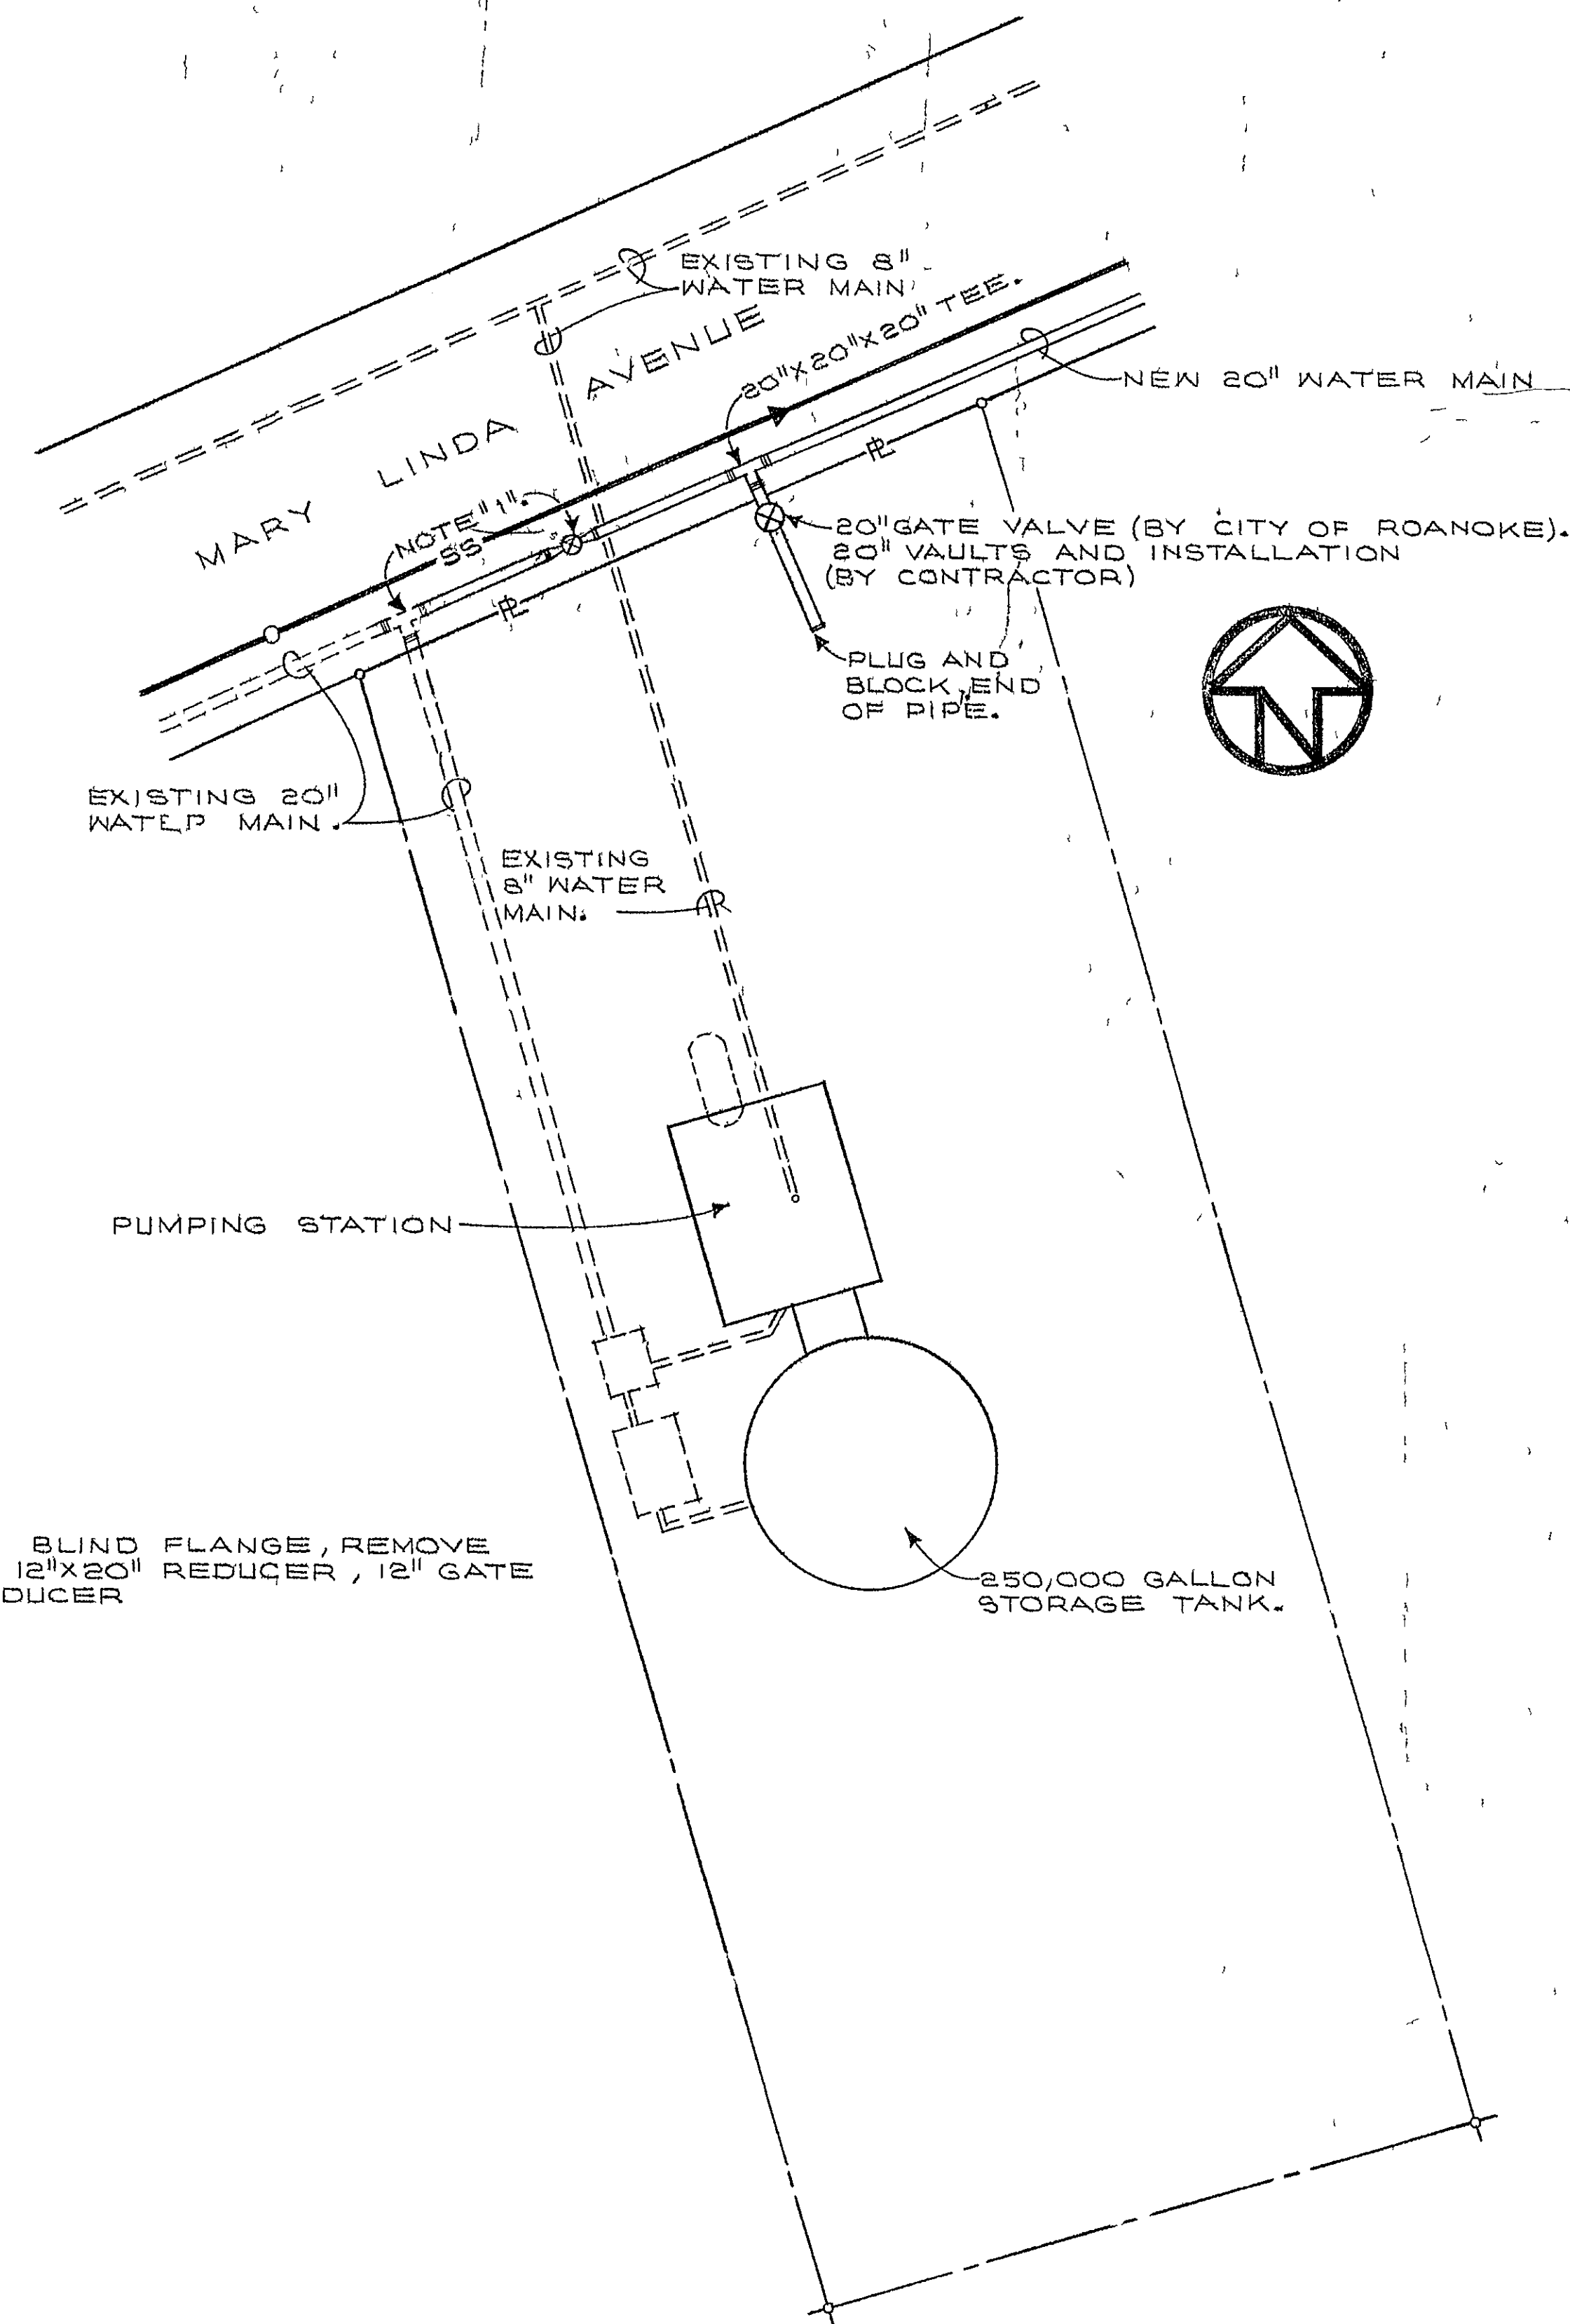

SITE PLAN - PUMPING STATION
SCALE 1" = 20'-0"

<i>Ad B. Bandy</i>	10/1/77
DIRECTOR UTILITIES	DATE
<i>Thomas A. Bandy</i>	10-7-77
CITY ENGINEER OF ROANOKE, VA.	DATE
<i>Dr. B. Bandy</i>	10-7-77
DIRECTOR OF PUBLIC WORKS	DATE
<i>William G. K. H.</i>	Oct 9, 1977
AGENT FOR ROANOKE PLANNING COM.	DATE

DATE STARTED				
DATE COMP 1978				
FEET (H/H)		SIZE	VALVE (H/H)	BOX
F H				
COMP				
F H STUD				
ONLY				
SERV INS BY				
MAIN INS BY contractor				
NO 3/4 SERV INS.				
CITY OR CO City				
DEPT. INSP Engineering				

NOTE
LOCATION OF EXISTING UTILITIES
ARE TO BE ASCERTAINED IN THE
FIELD PRIOR TO CONSTRUCTION.
VERIFY LOCATION OF UTILITIES
SHOWN ON DRAWINGS

10/27/77	1	VARIOUS CHANGES.	LBV
DATE	REV	DESCRIPTION	BY
10/27/77	1	MAP, LEGEND & SITE PLAN	LBV
10/27/77	1	WATER MAIN EXTENSION	LBV
10/27/77	1	FROM MARY LINDA AVE	LBV
10/27/77	1	TO BERKLEY ROAD N.E.	LBV
10/27/77	1	ROANOKE, VIRGINIA	LBV
10/27/77	1	CITY OF ROANOKE	LBV
10/27/77	1	OFFICE OF CITY ENGINEER	LBV
10/27/77	1	ROANOKE, VIRGINIA	LBV
10/27/77	1	CC DIRECTOR MUST VERIFY ALL DIMENSIONS	LBV
10/27/77	1	BEFORE PROJECT BEGINS. RESERVING WITH WORK	LBV