


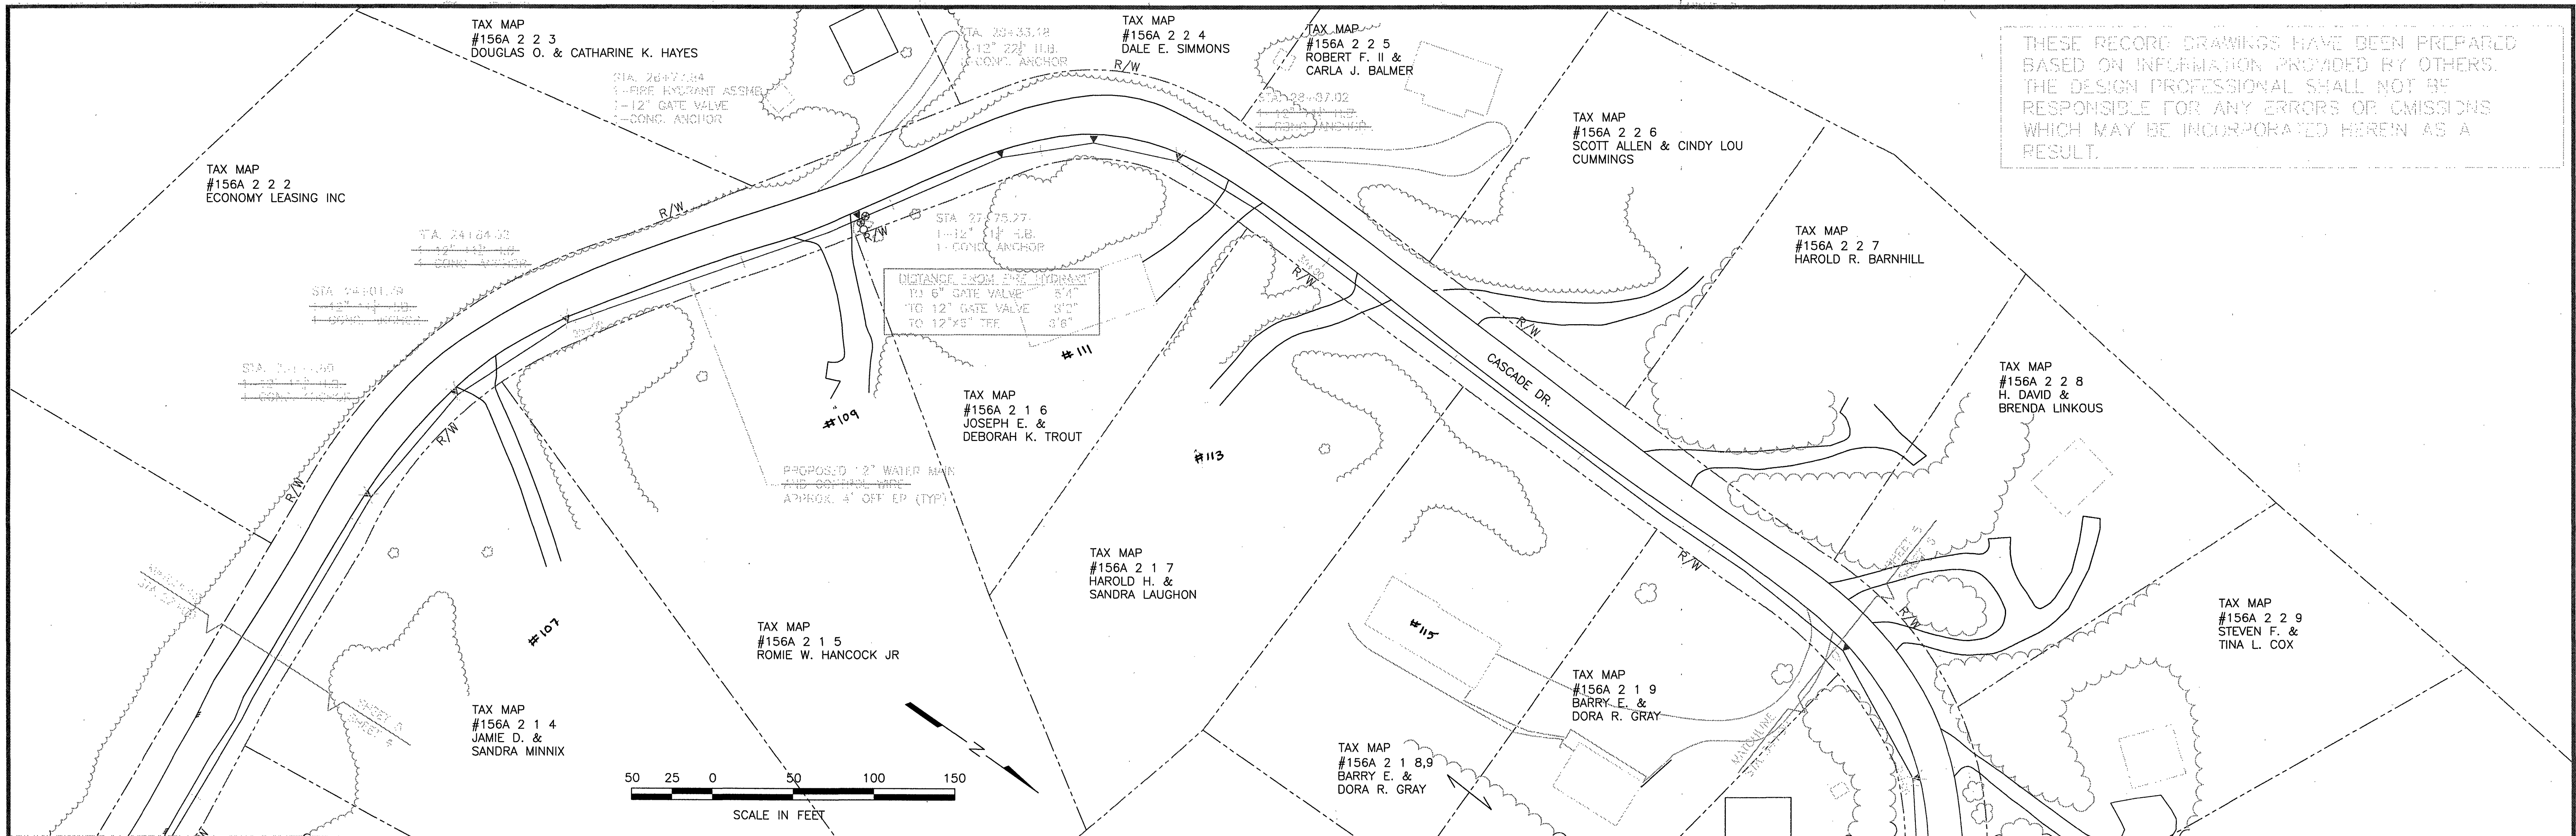

 ANDERSON & ASSOCIATES, INC. Professional Design Services www.andasoc.com Virginia - North Carolina - Tennessee 100 Ardmore St. Blacksburg, Va. 24060 540-552-5592	DATE : 31 AUG 00 DESIGNED: RBE,PJM DRAWN : RBE,PJM CHECKED : TWD	REVISIONS: RECORD: 29 AUG 01	STEWARTSVILLE PHASE 2 WATER SYSTEM BEDFORD COUNTY, VIRGINIA	PLAN AND PROFILE STA. 22+00 TO 34+00	DOCUMENT NO. 16265.5 - 029 SHEET 5 OF 10
--	---	------------------------------------	--	--	---