
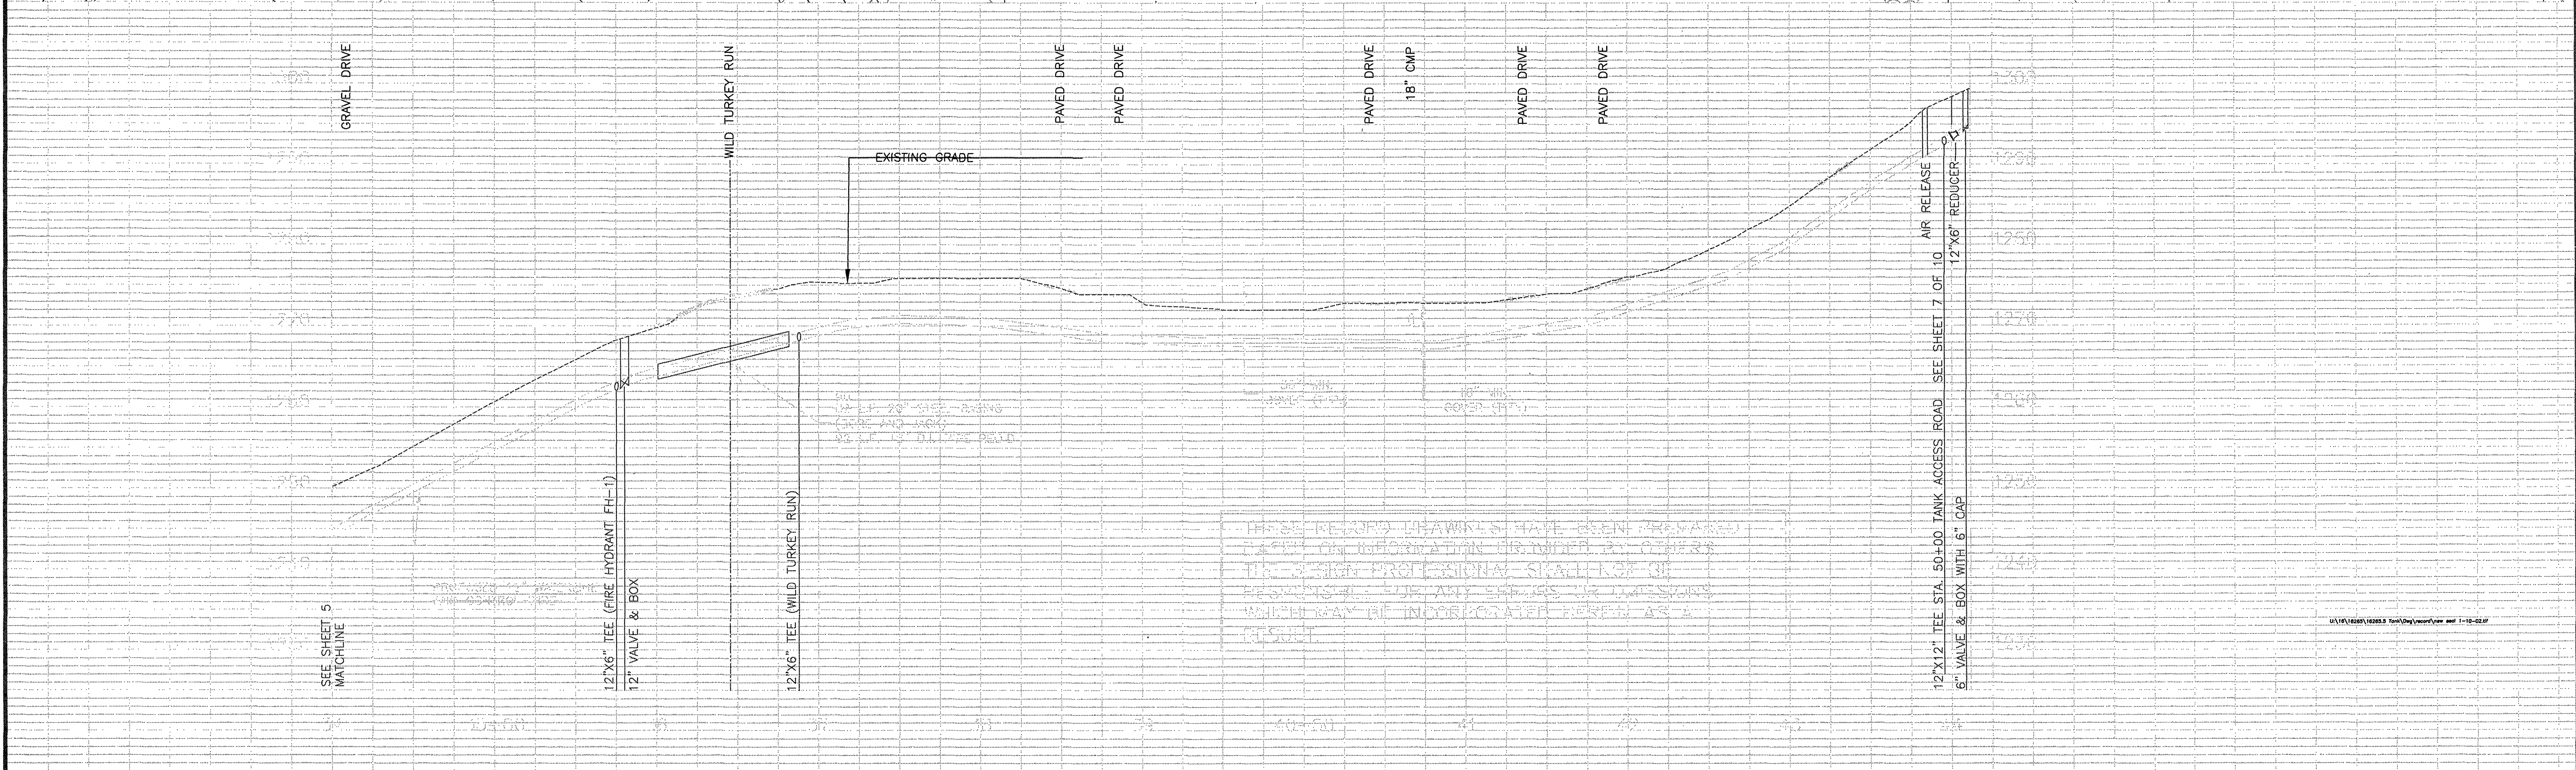


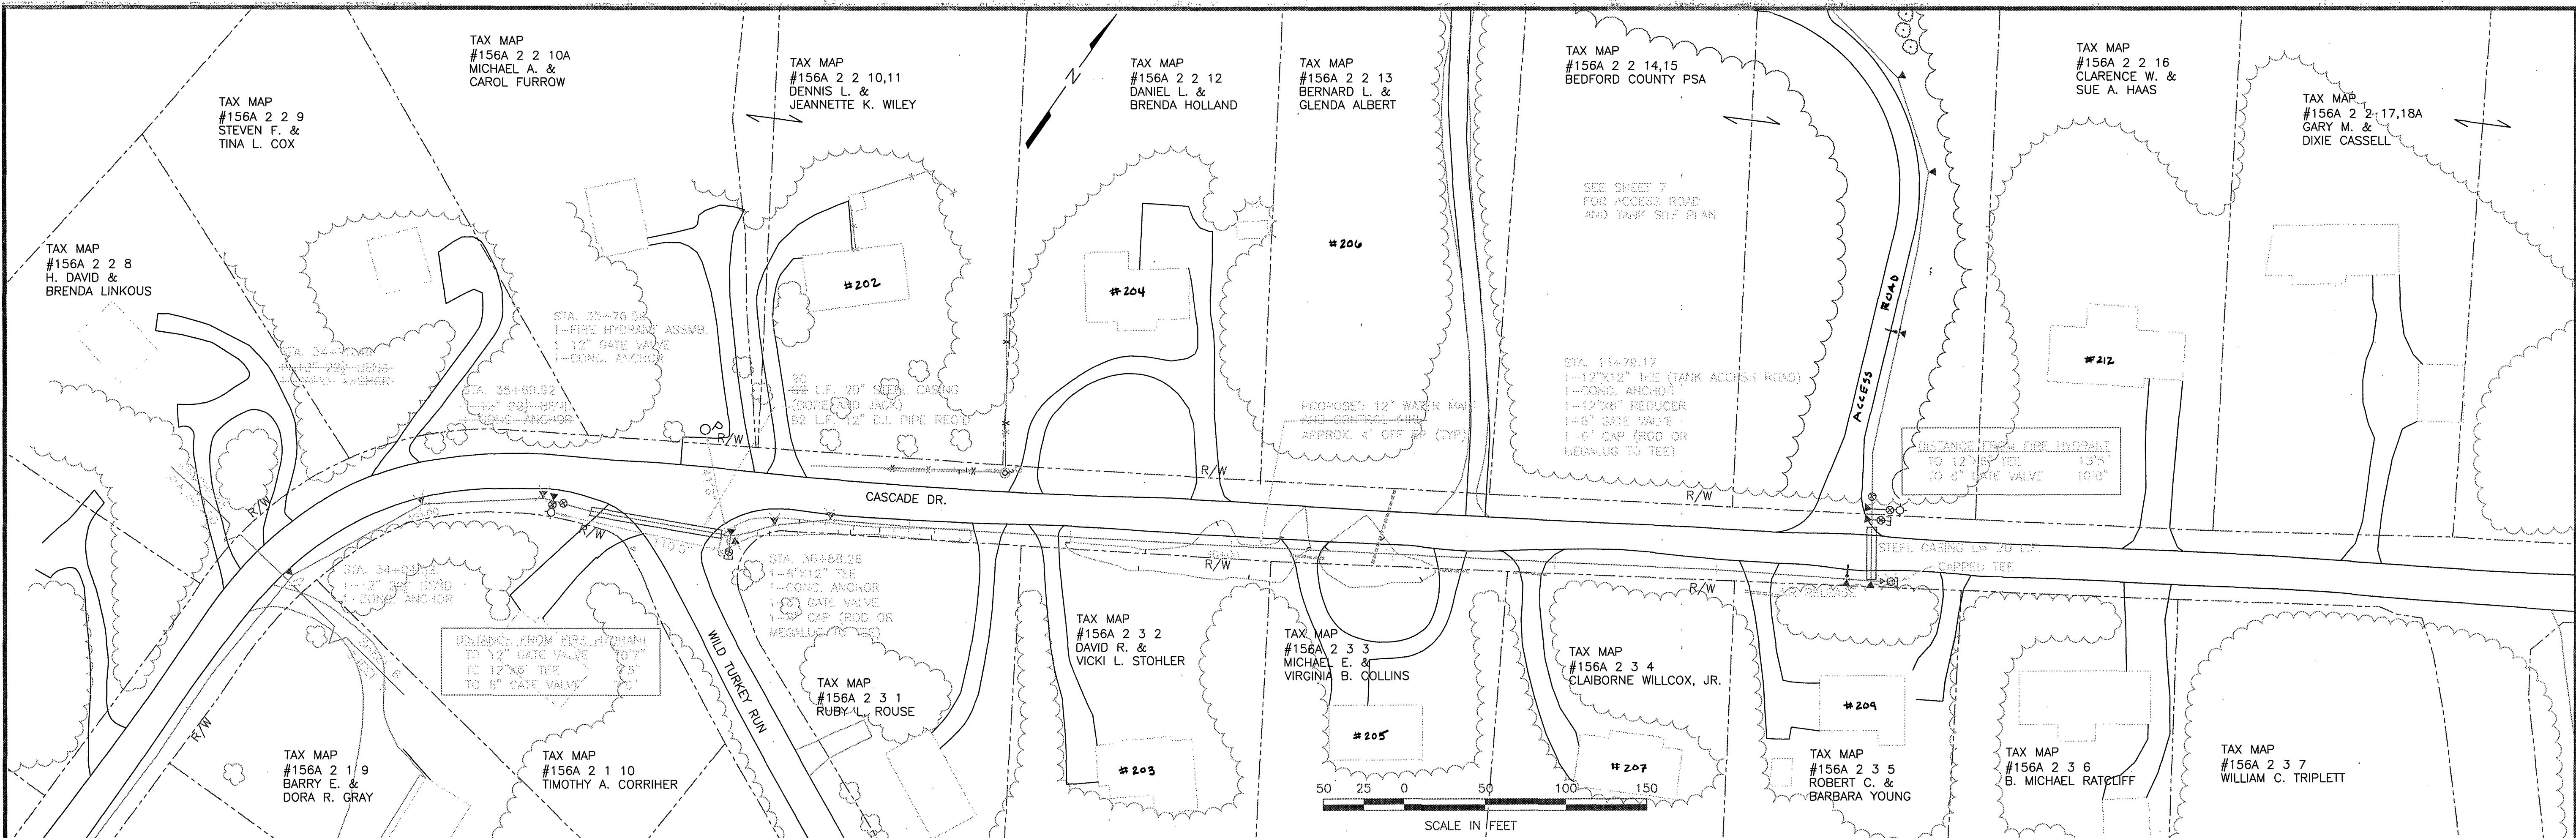

 ANDERSON & ASSOCIATES, INC. Professional Design Services www.andassoc.com Virginia - North Carolina - Tennessee	DATE : 31 AUG 00 DESIGNED: RBE,PJM DRAWN : RBE,PJM CHECKED : TWD	REVISIONS: 01 FEB 01	RECORD: 29 AUG 01	STEWARTSVILLE PHASE 2 WATER SYSTEM BEDFORD COUNTY, VIRGINIA	PLAN AND PROFILE STA. 34+00 TO 44+11.75	DOCUMENT NO. 16265.5 - 030
	100 Ardmore St. Blacksburg, Va. 24060 540-552-5592					SHEET 6 OF 10