

File: \\VA-PROJECTS\N\N\41381A\000\ACADD\G-002_33834.DWG
Saved: 5/22/2018 2:13:37 PM, Plotted: 5/25/2018 1:14:58 PM, Current User: Alan.Lee@SowdByr, 5415

PROJECT LOCATION MAP
1" = 2500'

ROANOKE
COUNTY

CITY OF
ROANOKE

SUNNYBROOK DRIVE

WILLIAMSON RD

PLANTATION DRIVE
11 SR

WILLIAMSON ROAD

SR 101

I-581

I-581

COYE RD NW

SR 117

HERSHBERGER RD NW

I-460

SALEM TURNPIKE NW

SHENANDOAH AVE NW

BOULEVARD ST

ROANOKE RIVER

ELM AVE



ROANOKE RIVER

IIS 220

I-460

SHEET INDEX

SHEET NUMBER	SHEET TITLE
G-001	TITLE SHEET
G-002	PROJECT LOCATION MAP AND SHEET INDEX
G-003	LEGEND AND GENERAL NOTES
G-004	ABBREVIATIONS
G-005	FIRE PROTECTION AREA COVERAGE MAP
C-200	PROJECT AREA MAP
C-201	PLAN AND PROFILE - MANOR STREET WATER MAIN (STA. 10+00 TO E.O.L.)
C-202	PLAN AND PROFILE - ELWOOD STREET WATER MAIN (STA. 10+00 TO E.O.L.)
C-203	PLAN AND PROFILE - MIDDLETON STREET WATER MAIN (STA. 10+00 TO E.O.L.)
C-204	PLAN AND PROFILE - GREENWAY DRIVE WATER MAIN (STA. 10+00 TO STA. 21+00)
C-205	PLAN AND PROFILE - GREENWAY DRIVE & BOXLEY ROAD WATER MAIN (GREENWAY DRIVE STA. 21+00 TO E.O.L.; BOXLEY ROAD STA. 26+94 TO 33+00)
C-206	PLAN AND PROFILE - BOXLEY ROAD WATER MAIN (STA. 33+00 TO STA. 45+00)
C-207	PLAN AND PROFILE - BOXLEY ROAD WATER MAIN (STA. 45+00 TO E.O.L.)
C-208	PLAN AND PROFILE - NORTHWAY DRIVE WATER MAIN (STA. 10+00 TO E.O.L.)
C-209	PLAN AND PROFILE - CHESTER DRIVE WATER MAIN (STA. 10+00 TO E.O.L.)
C-210	PLAN AND PROFILE - SUNNYBROOK DRIVE WATER MAIN (STA. 10+00 TO STA. 18+00)
C-211	PLAN AND PROFILE - SUNNYBROOK DRIVE WATER MAIN (STA. 18+00 TO E.O.L.)
C-401	EROSION & SEDIMENT CONTROL NOTES AND DETAILS
C-501	GENERAL DETAILS
C-502	WATER DETAILS
C-503	WATER DETAILS
C-504	WATER DETAILS
C-505	WATER DETAILS
C-601	TRAFFIC CONTROL DETAILS AND NOTES
C-602	TRAFFIC CONTROL DETAILS AND NOTES

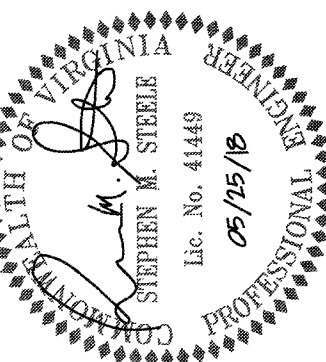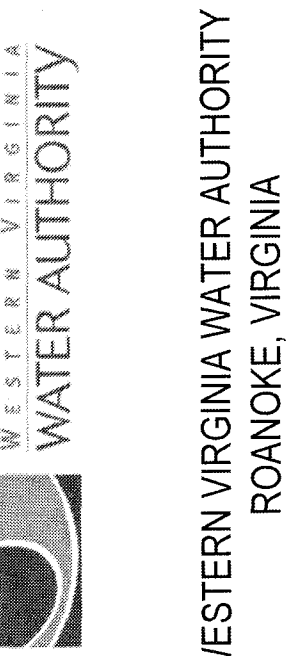

IT IS A VIOLATION OF LAW FOR ANY PERSON, FIRM OR ENTITY, WHOSE NAME IS LISTED ON ANY ENGINEERING OR SURVEYING DOCUMENT, TO REPRODUCE OR TRANSMIT IN ANY MANNER, IN ANY MEDIUM, ANY PART OF THE CONTENTS OF ANY SUCH DOCUMENT, WITHOUT THE WRITTEN PERMISSION OF THE ENGINEER OR SURVEYOR, OR THE FIRM OR ENTITY, WHOSE NAME IS LISTED ON THE DOCUMENT.

WESTERN VIRGINIA WATER AUTHORITY
SUNNYBROOK DRIVE
WATER MAIN REPLACEMENT
ROANOKE COUNTY, VIRGINIA

No.	Submital / Revision	App'd By	Date
1	80% SUBMITTAL	SMS/MBH	5-18-18
2	CLIENT REVIEW	SMS/MBH	5-25-18

PROJECT LOCATION MAP
AND SHEET INDEX

Designed By: MBH	Drawn By: RAS	Checked By: LES
Issue Date: 05/18/18	Project No: 33834	Scale: AS SHOWN

Drawing No.:
G-002