 


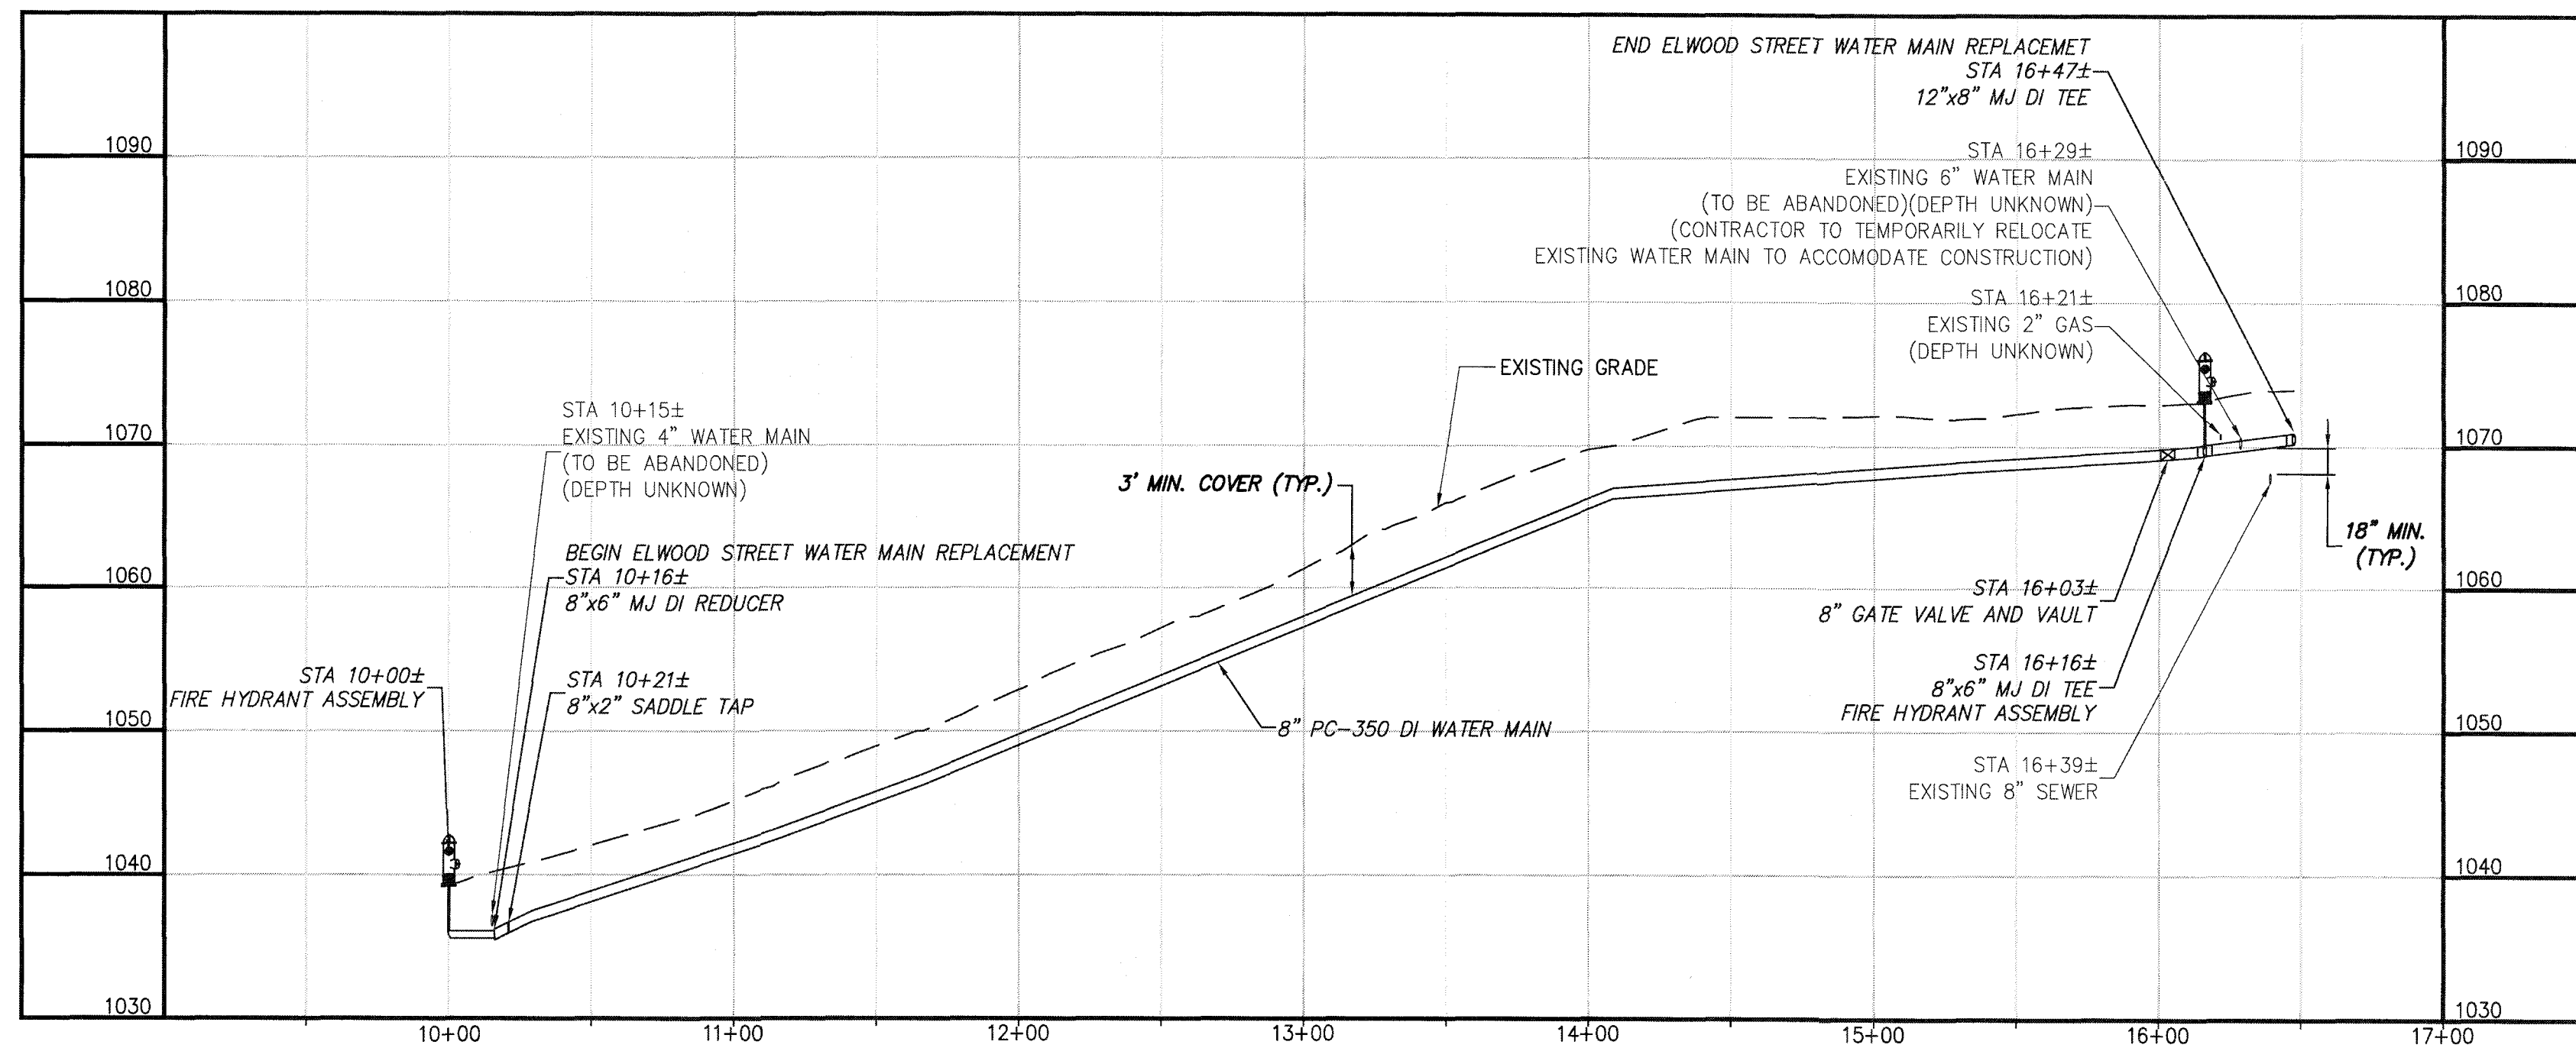


File: V:\PROJECTS\WV\433834\CADD\ACAD\C-202-33834-PLAN AND PROFILE.DWG
Saved: 5/24/2018 4:10:13 PM Plotted: 5/25/2018 1:16:00 PM Current User: Spikes, Alan Last Saved By: 5734

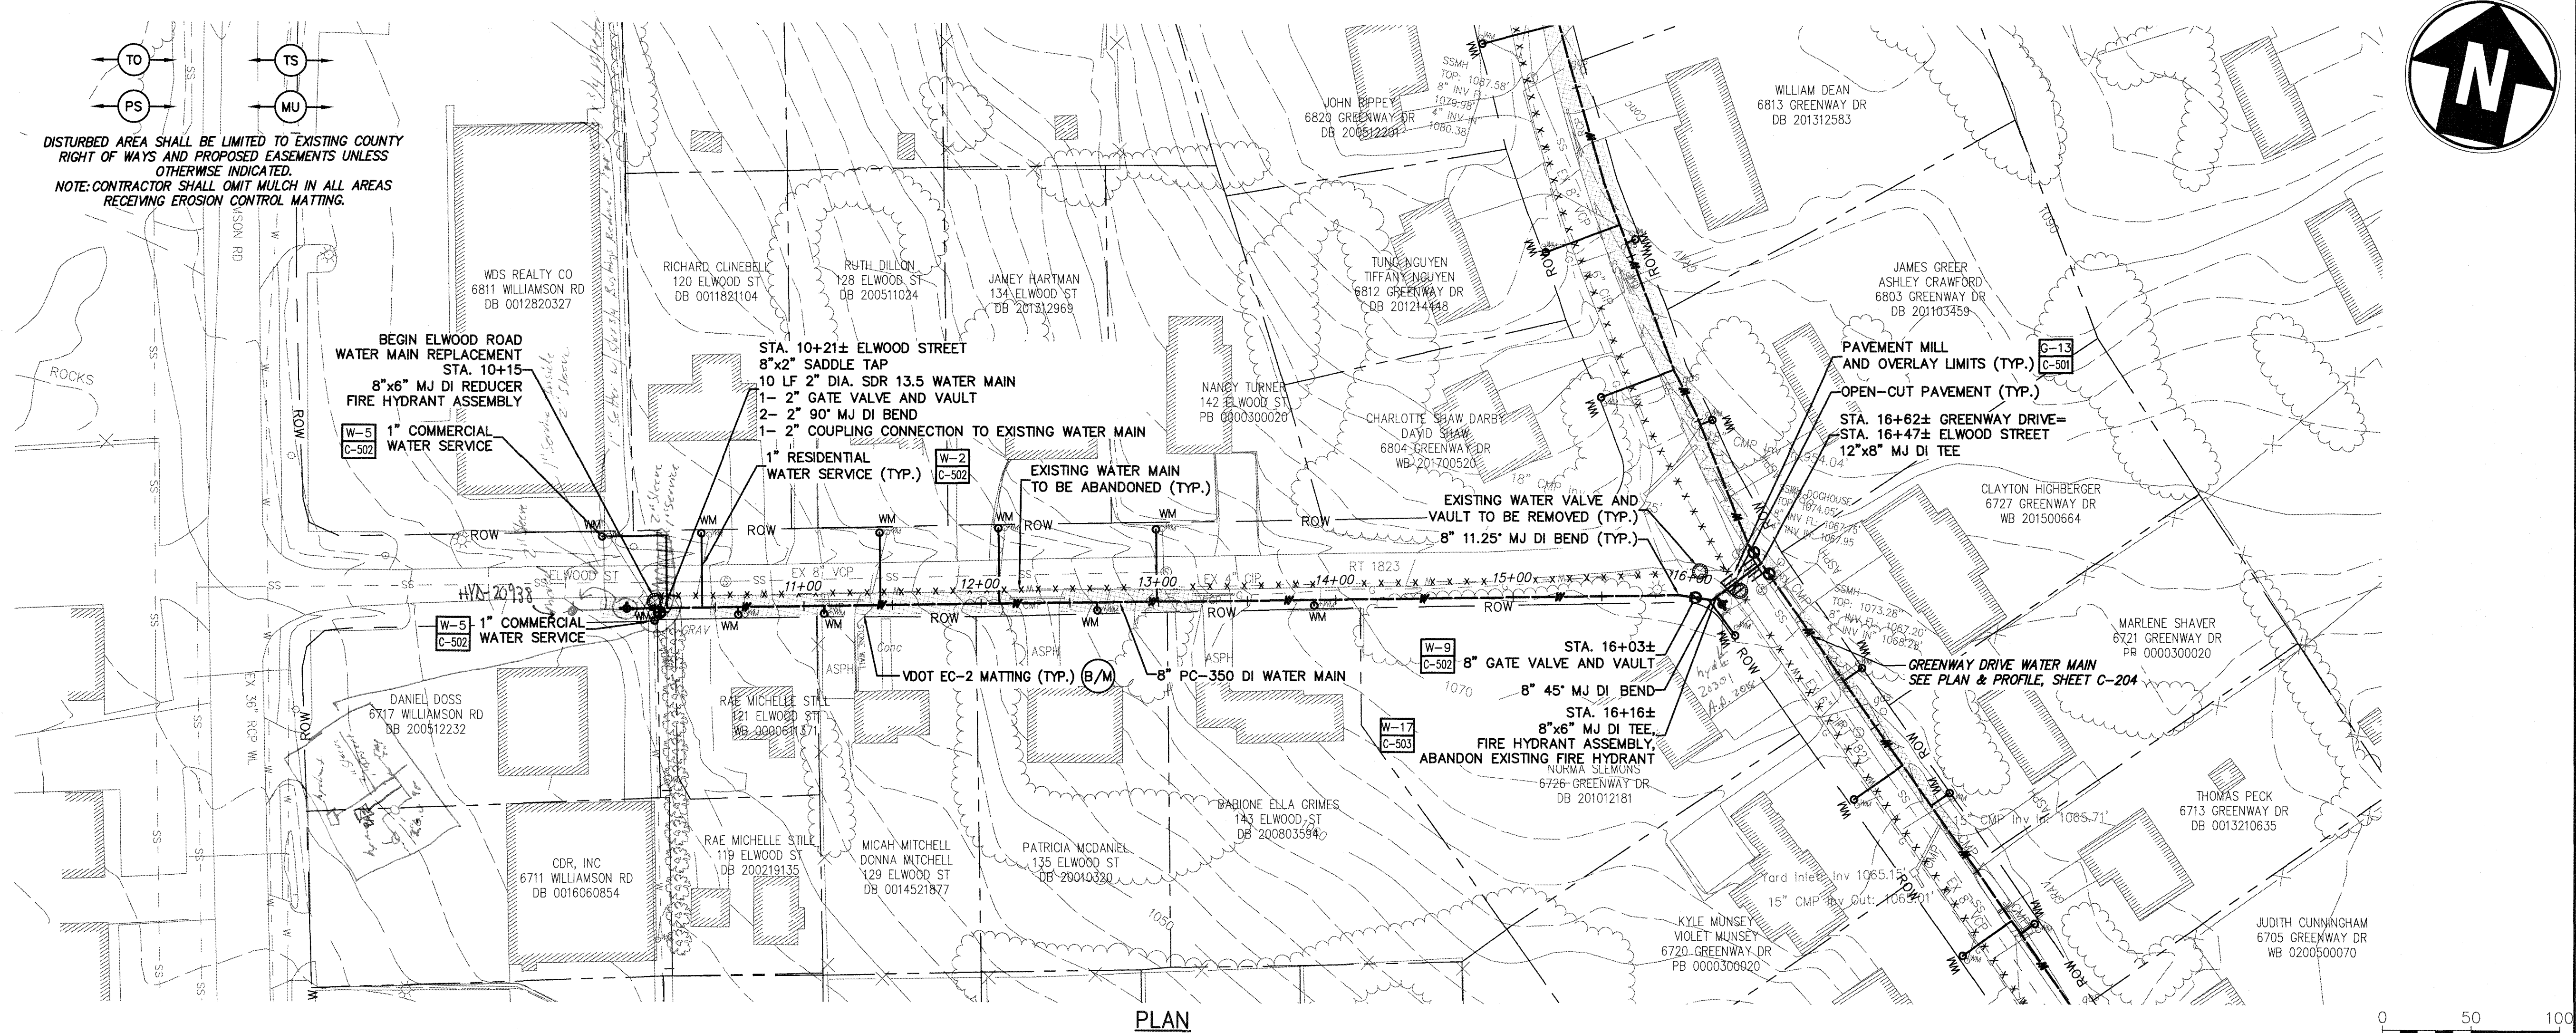

WESTERN VIRGINIA WATER AUTHORITY
ROANOKE, VIRGINIA

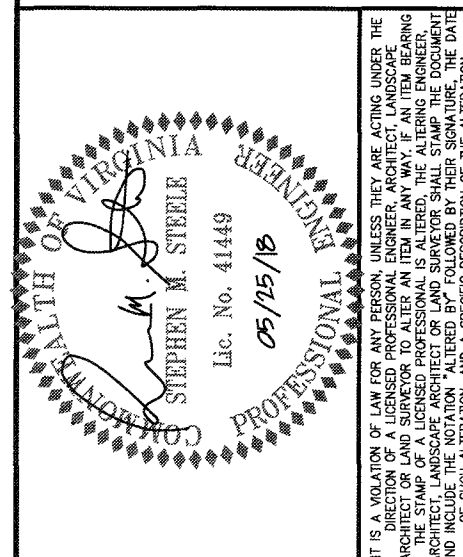

WESTERN VIRGINIA WATER AUTHORITY
SUNNYBROOK DRIVE
WATER MAIN REPLACEMENT
ROANOKE COUNTY, VIRGINIA

No.	Summary / Revision	App'd By	Date
1	90% SUBMITTAL	SMS/MBH	5-15-18
2	CLIENT REVIEW	SMS/MBH	5-25-18

PLAN AND PROFILE -
ELWOOD STREET
WATER MAIN
(STA. 10+00 TO E.O.L.)

Designed By: MBH	Drawn By: RAS	Checked By: LES
Issue Date: 05/18/18	Project No: 33834	Scale: AS SHOWN

Drawing No.:

C-202