



File: V:\PROJECTS\WV\33834\CADD\33834-PLAN AND PROFILE.DWG
Saved: 5/24/2018 4:10:13 PM Plotted: 5/25/2018 1:16:09 PM Current User: Squires, Alan User: Squires, Alan

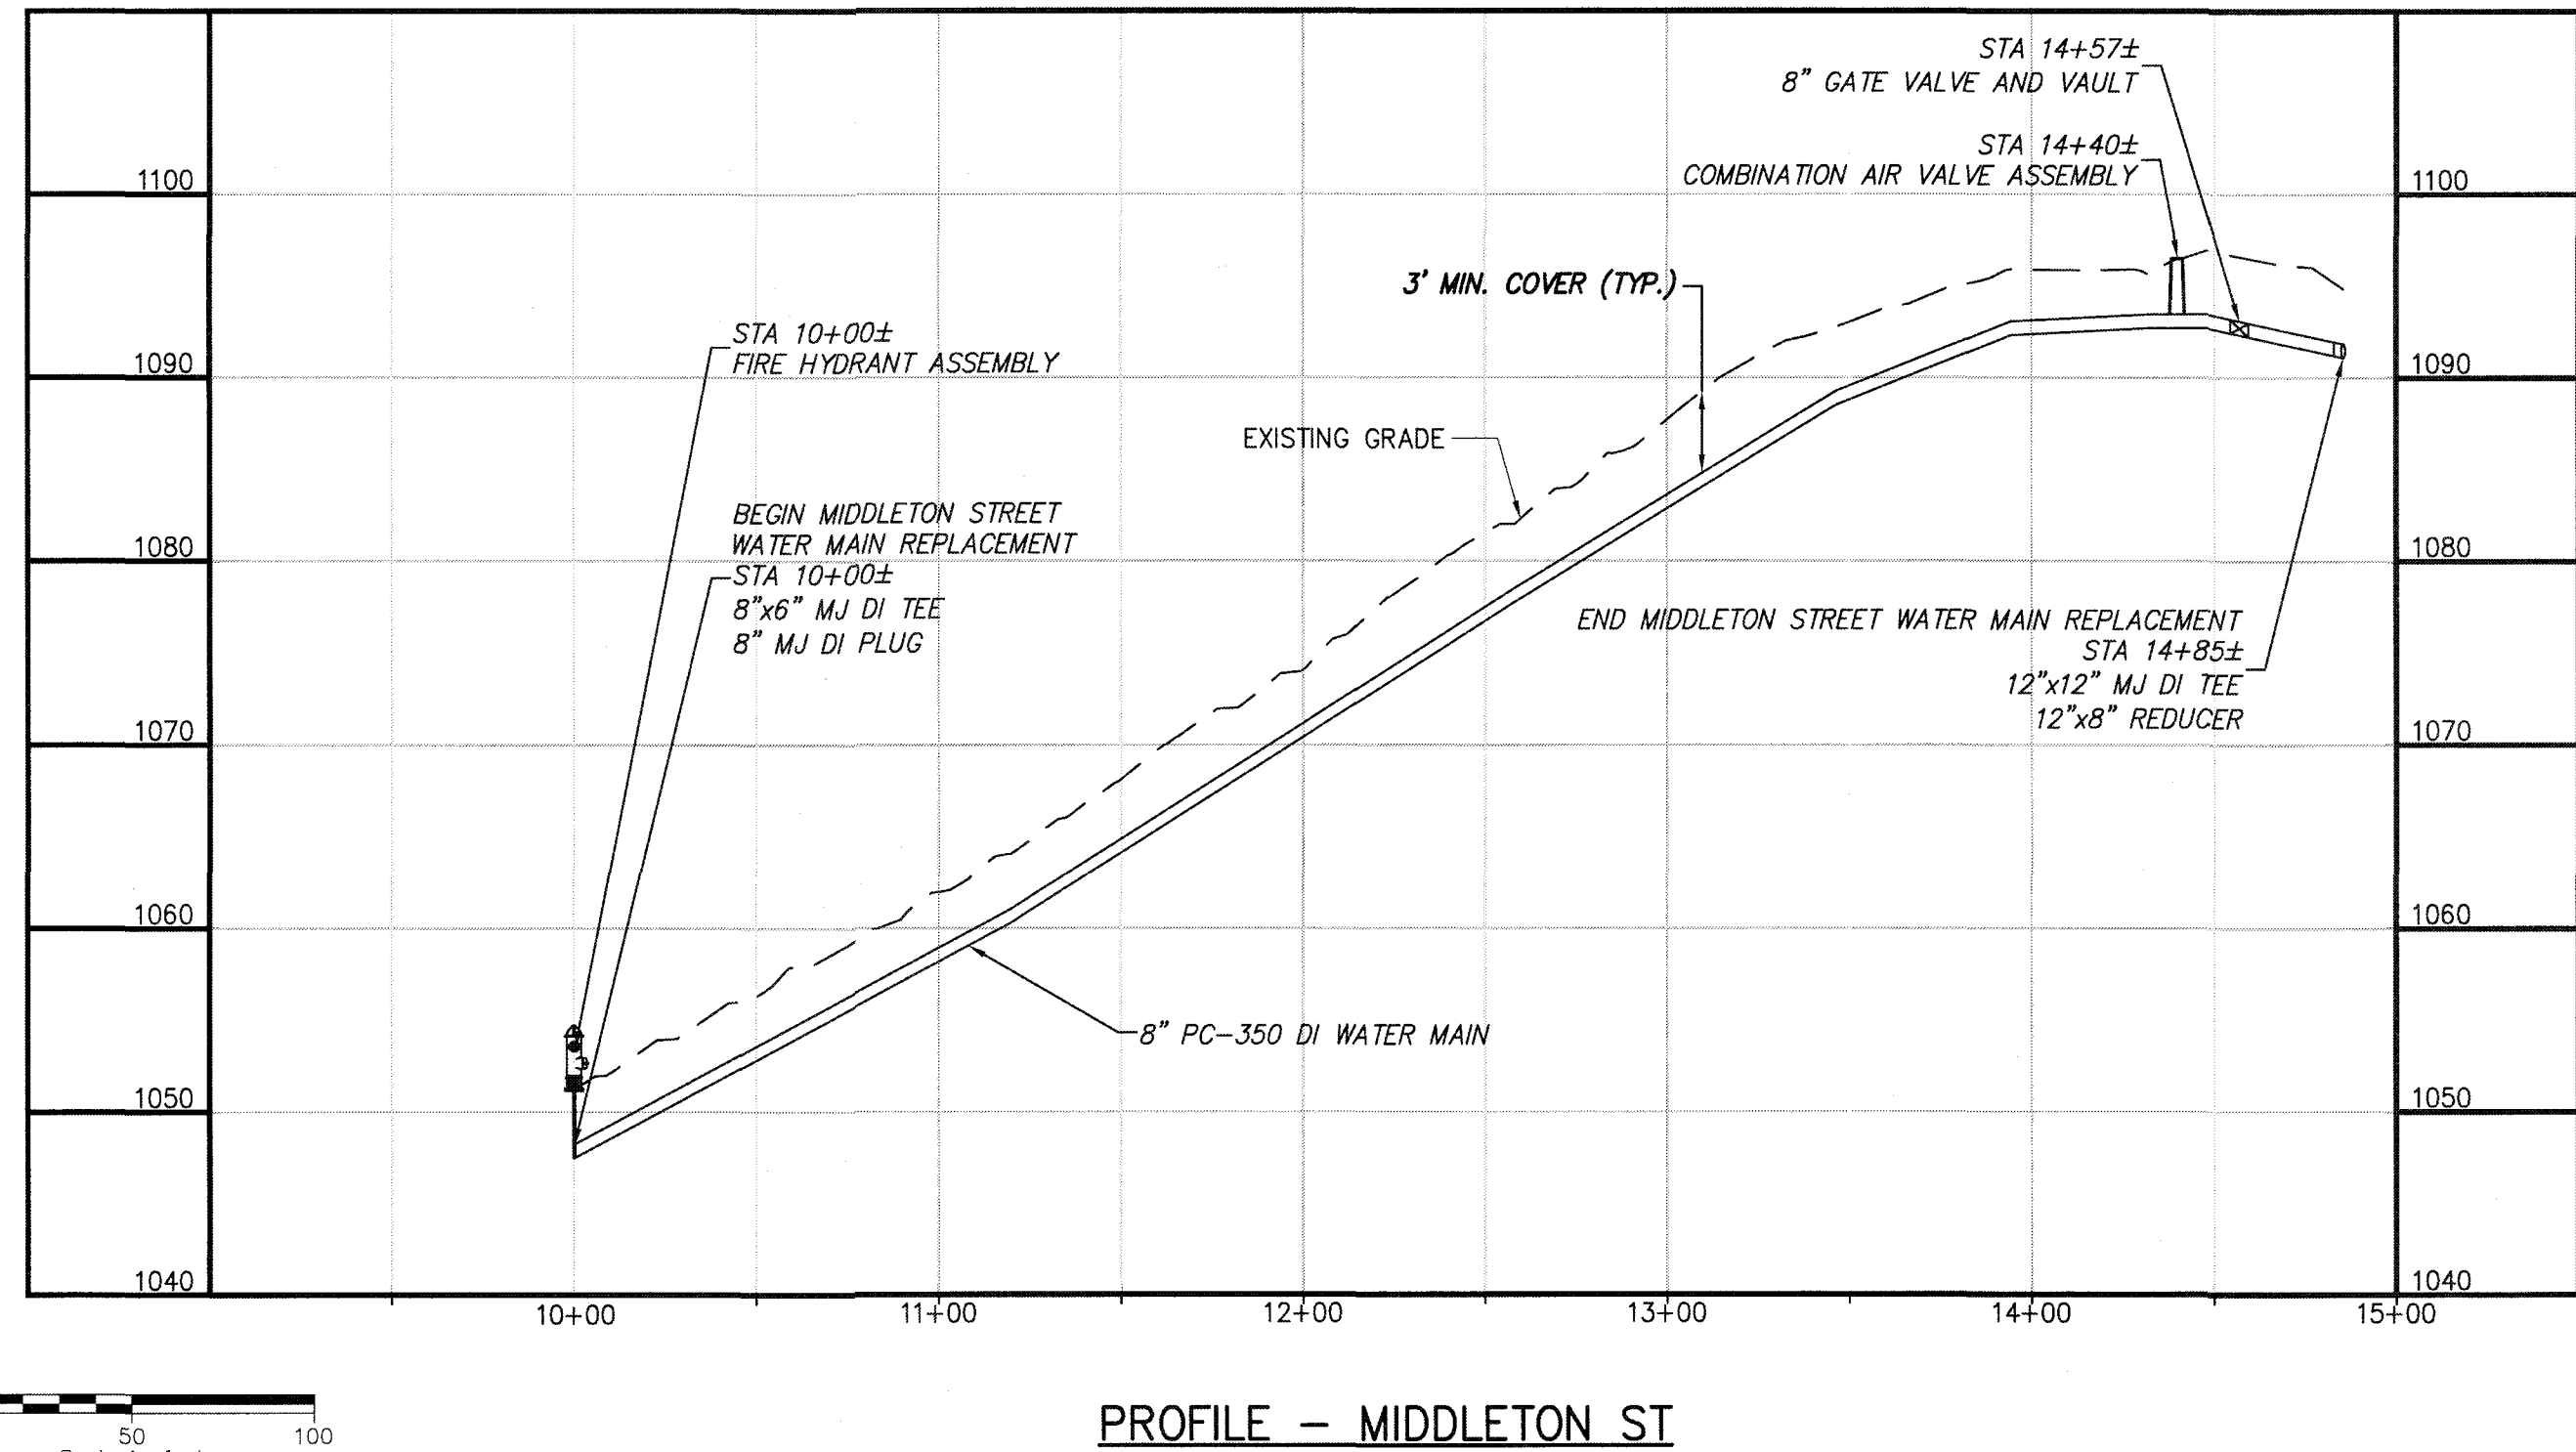


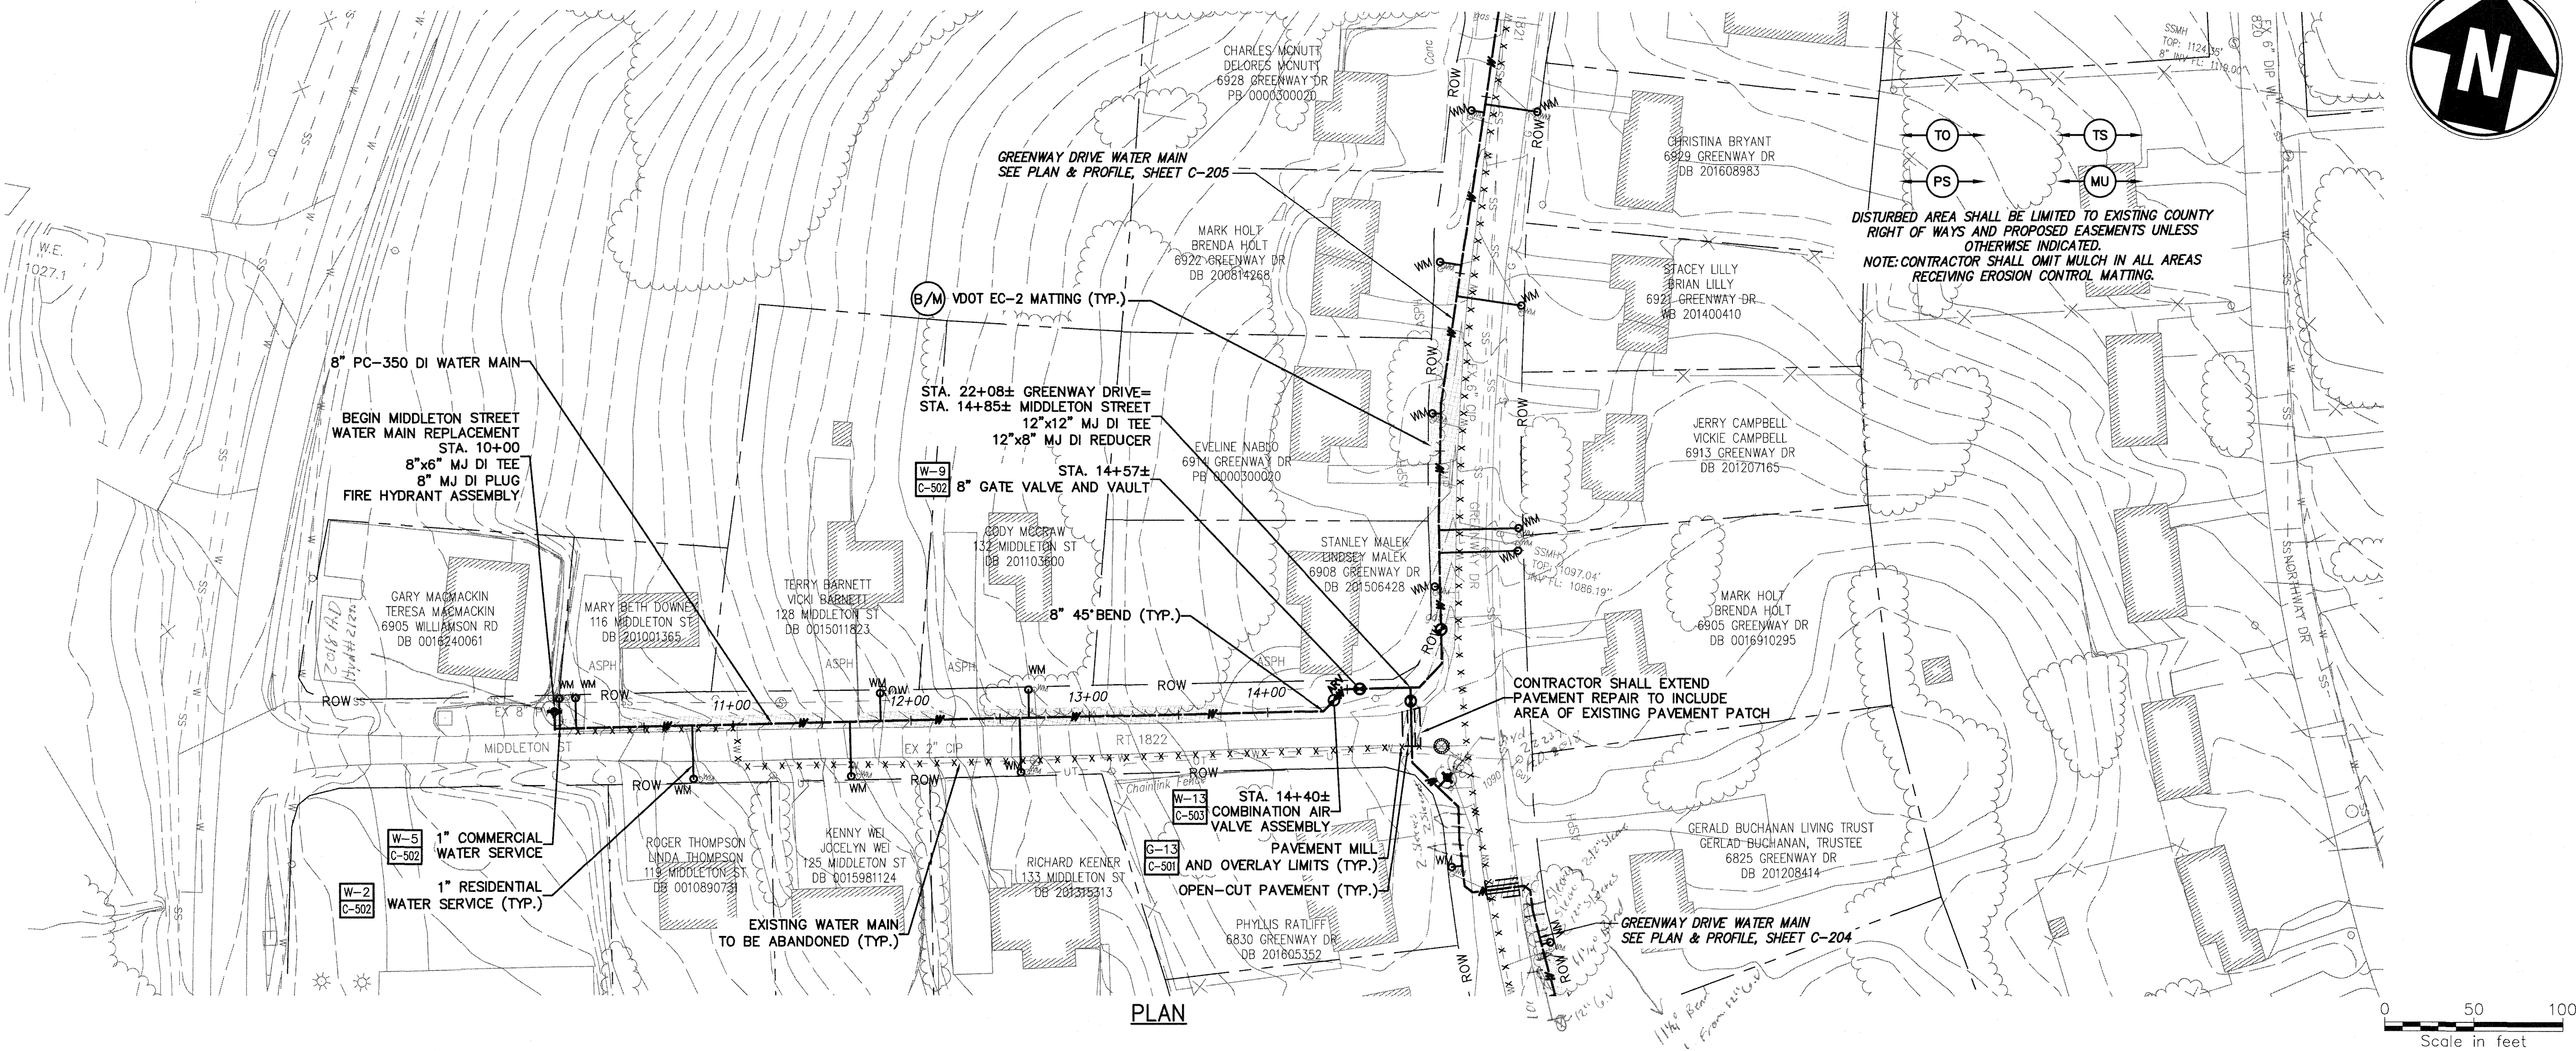

1341 Research Center Drive, Suite 2100
Roanoke, VA 24060
540.952.5500

WESTERN VIRGINIA
WATER AUTHORITY

WESTERN VIRGINIA WATER AUTHORITY
ROANOKE, VIRGINIA

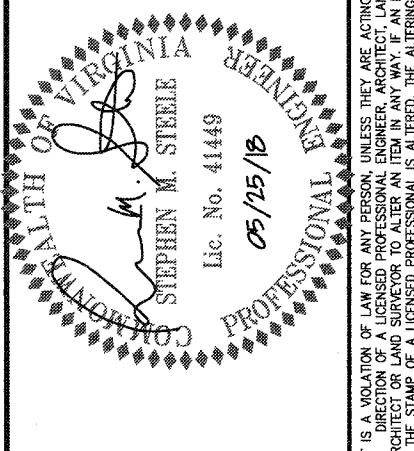

WESTERN VIRGINIA WATER AUTHORITY
SUNNYBROOK DRIVE
WATER MAIN REPLACEMENT
ROANOKE COUNTY, VIRGINIA

No.	Summary / Revision	Revised By	Date
1	90% SUBMITTAL	SMS/MBH	5-16-18
2	CLIENT REVIEW	SMS/MBH	5-25-18

PLAN AND PROFILE -
MIDDLETON STREET
WATER MAIN
(STA. 10+00 TO E.O.L.)

Designed By:	Drawn By:	Checked By:
MBH	RAS	LES

Issue Date:	Project No:	Scale:
05/18/18	33834	AS SHOWN

Drawing No.:
C-203