
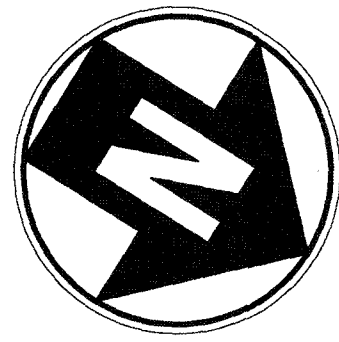
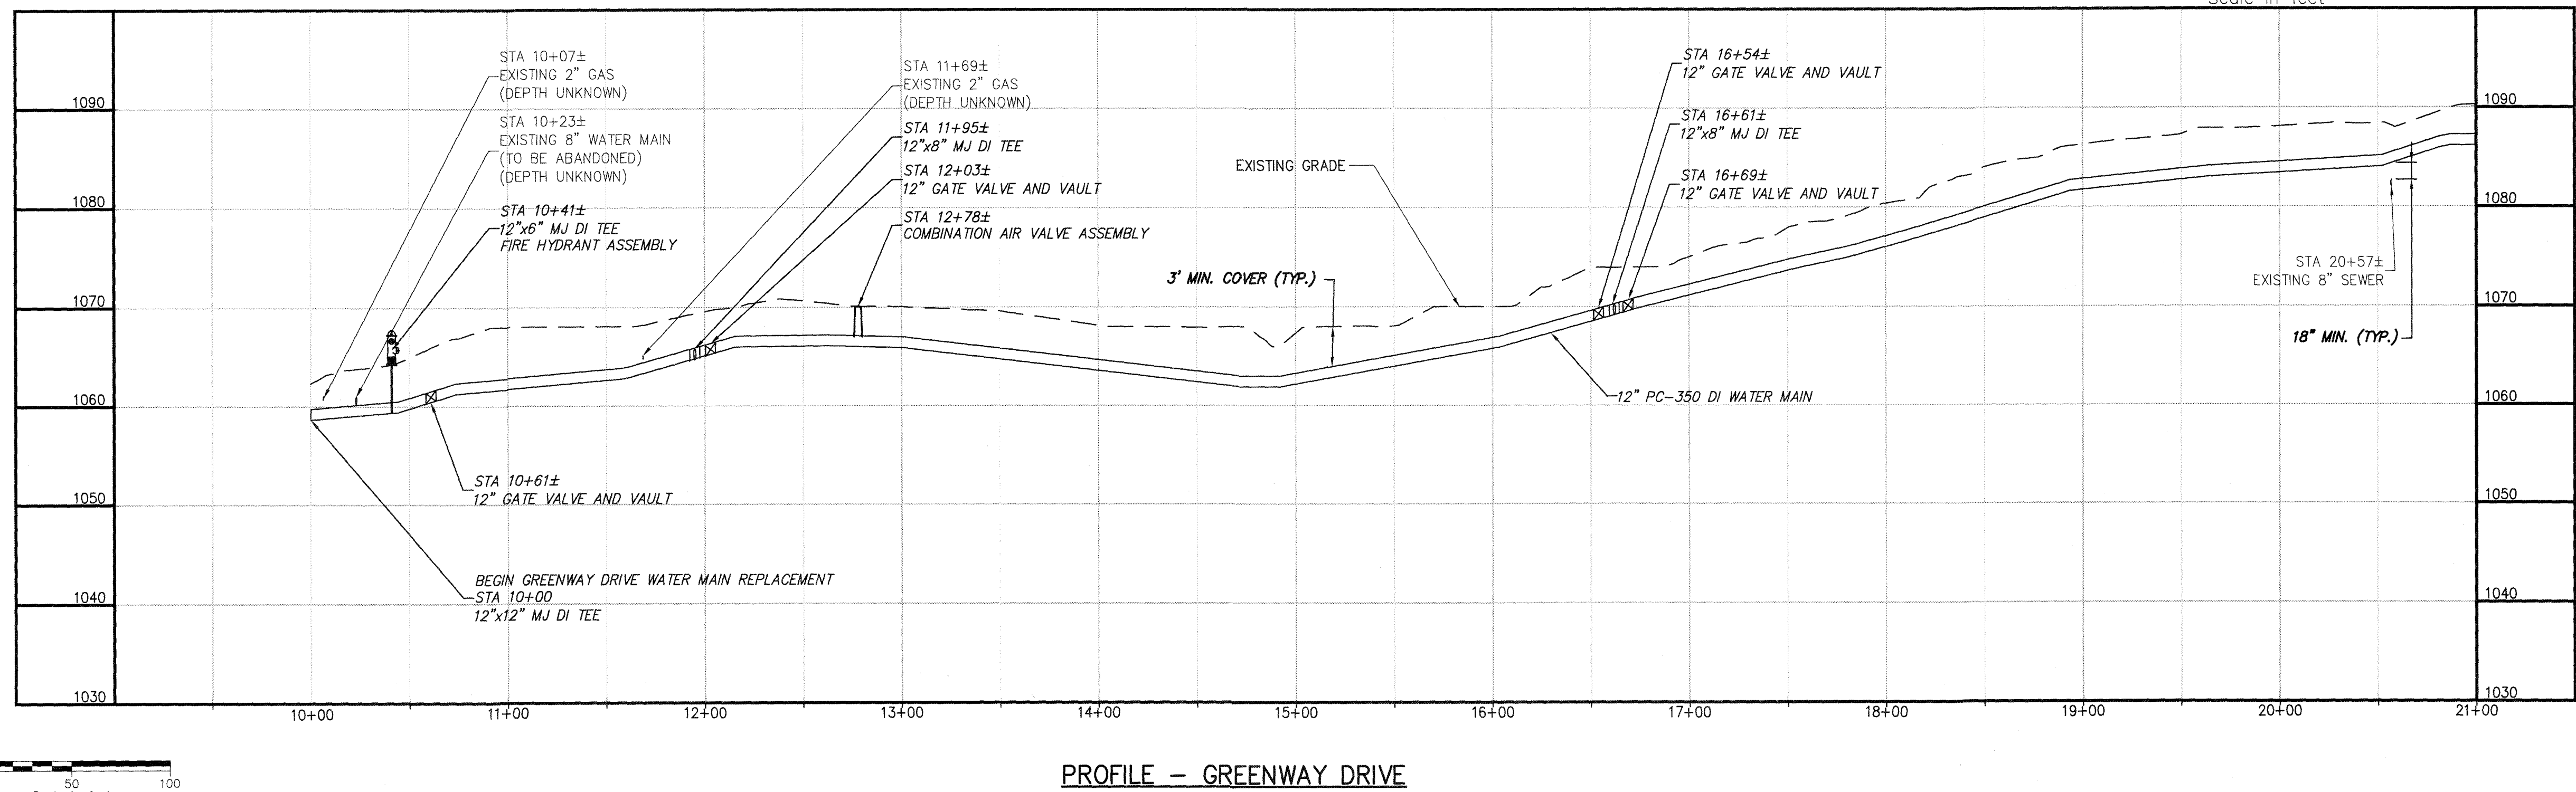
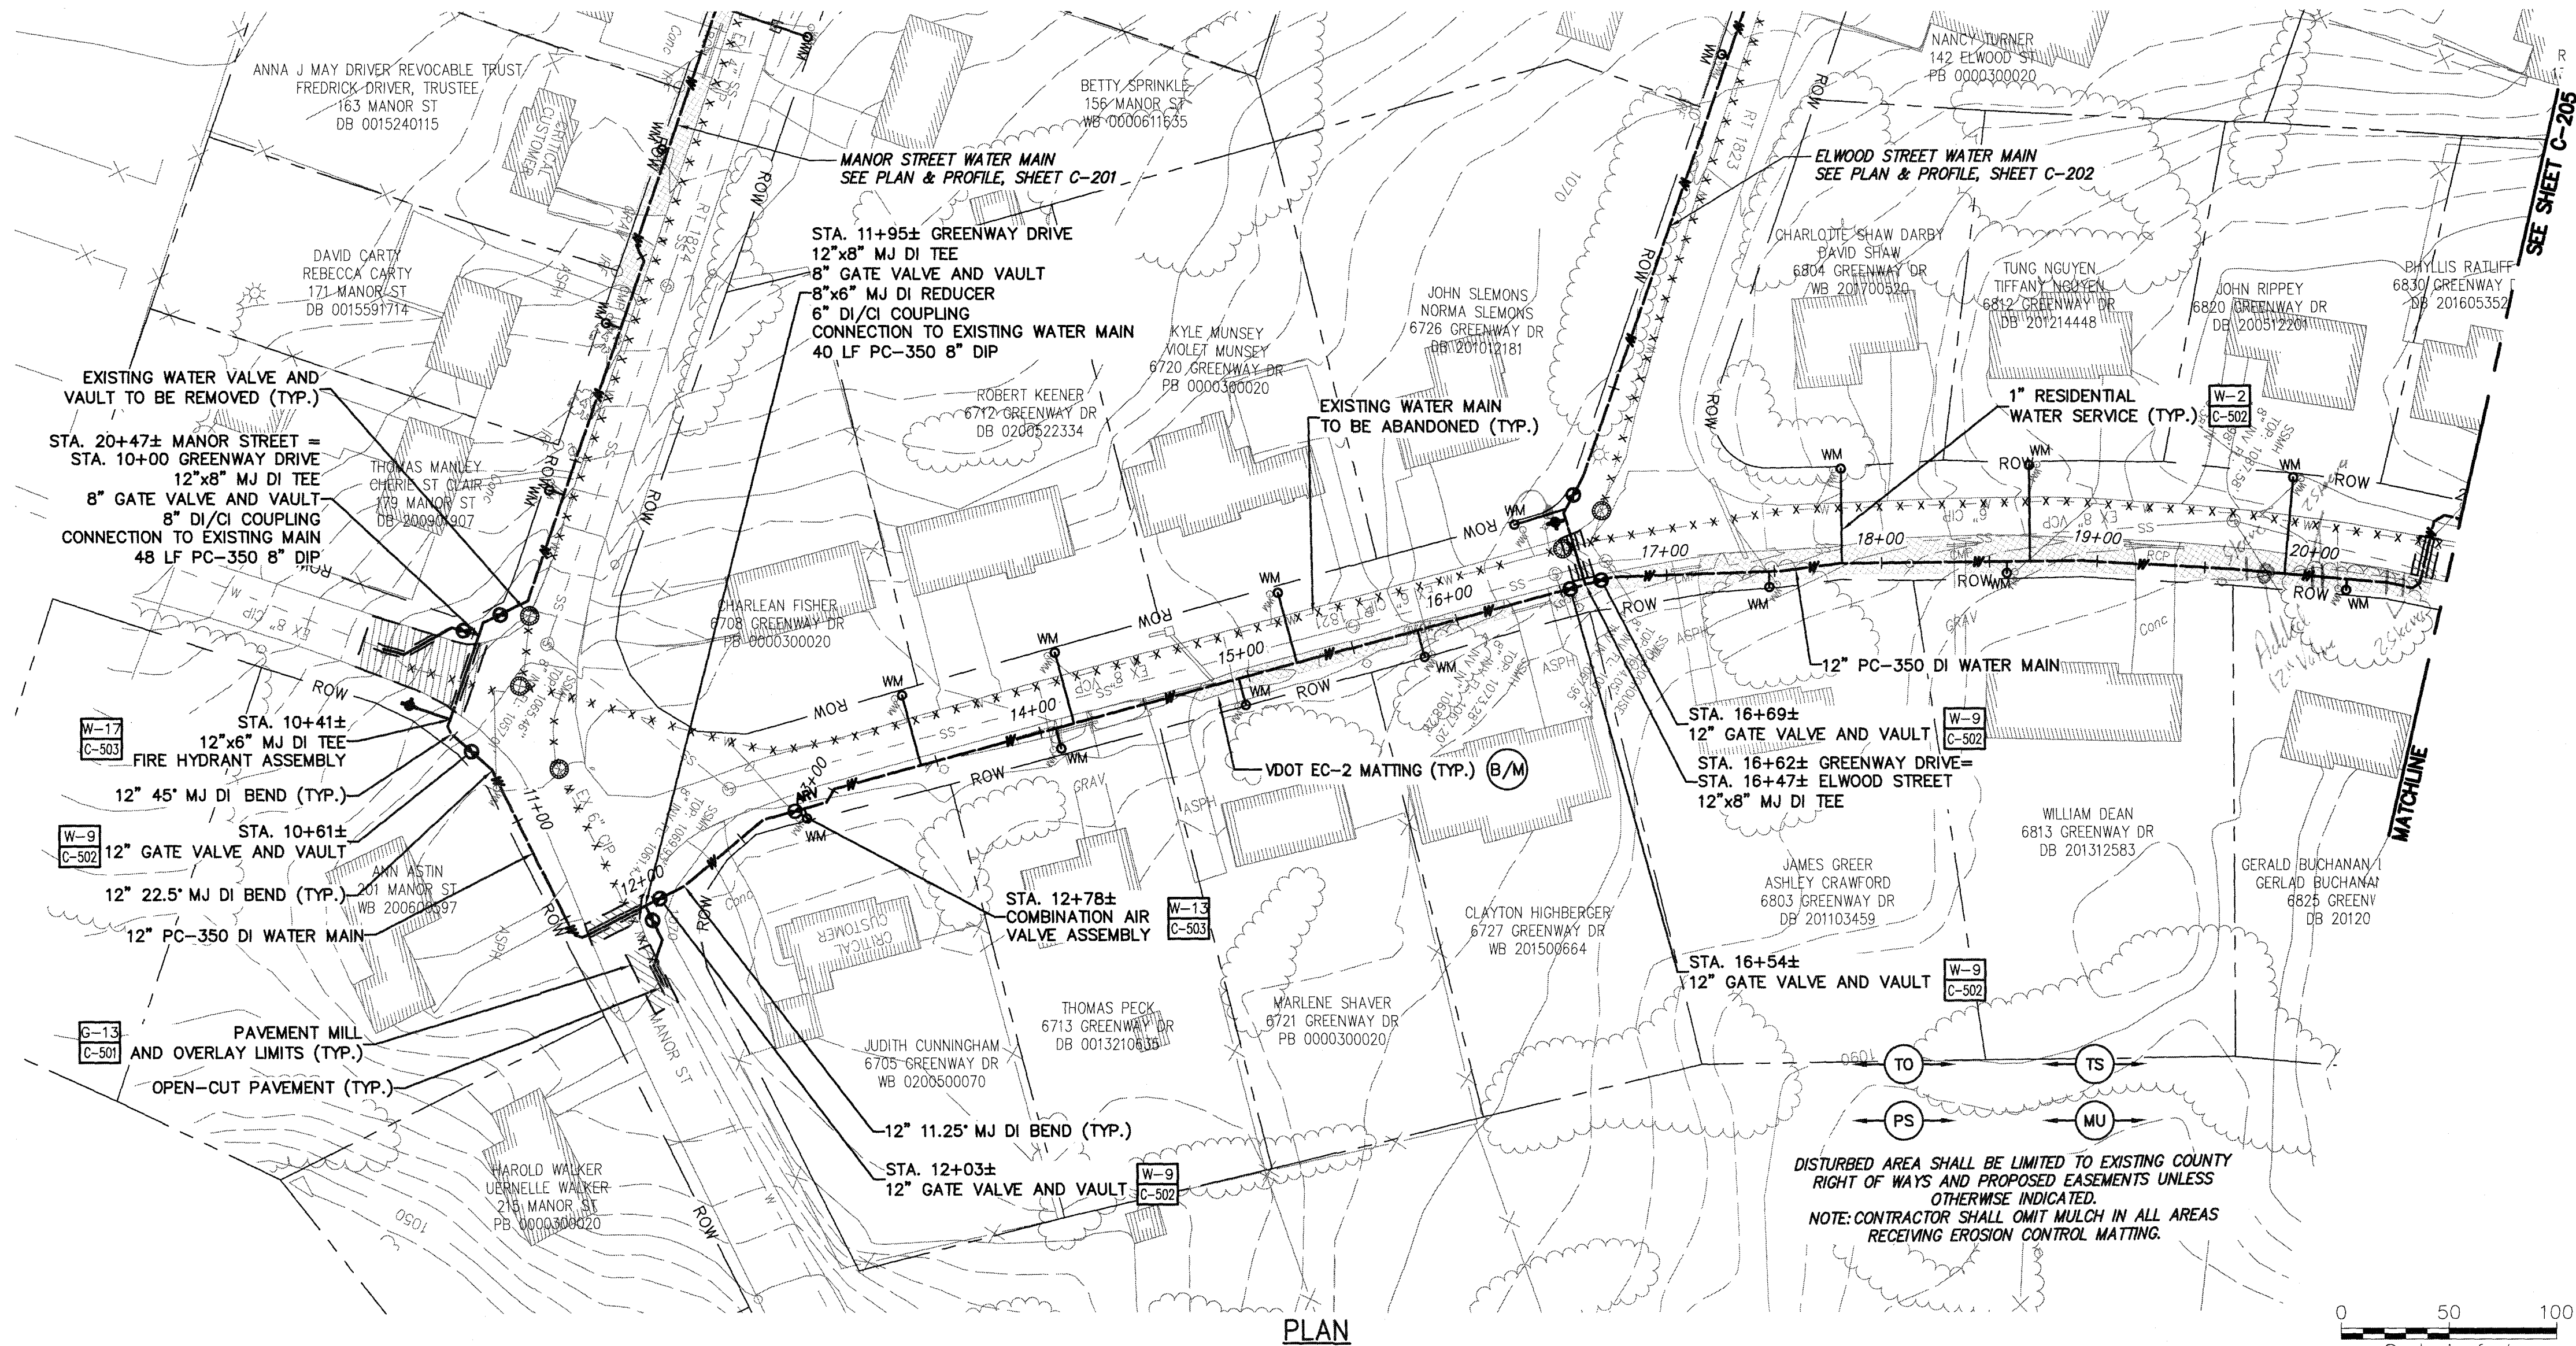


WESTERN VIRGINIA WATER AUTHORITY
ROANOKE, VIRGINIA

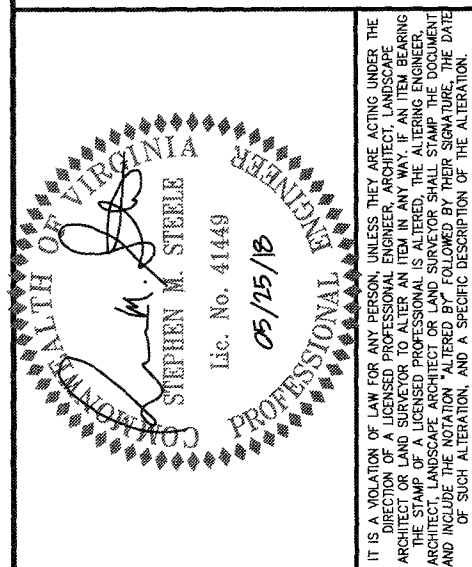

WESTERN VIRGINIA WATER AUTHORITY
SUNNYBROOK DRIVE
WATER MAIN REPLACEMENT
ROANOKE COUNTY, VIRGINIA

No.	Submitted / Revision	By	Date
1	80% SUBMITTAL	SMS/MBH	5-18-18
2	CLIENT REVIEW	SMS/MBH	5-25-18

PLAN AND PROFILE -
GREENWAY DRIVE
WATER MAIN
(STA. 10+00 TO STA. 21+00)

Designed By: MBH	Drawn By: RAS	Checked By: LES
Issue Date: 05/18/18	Project No: 33834	Scale: AS SHOWN

Drawing No.:

C-204