 


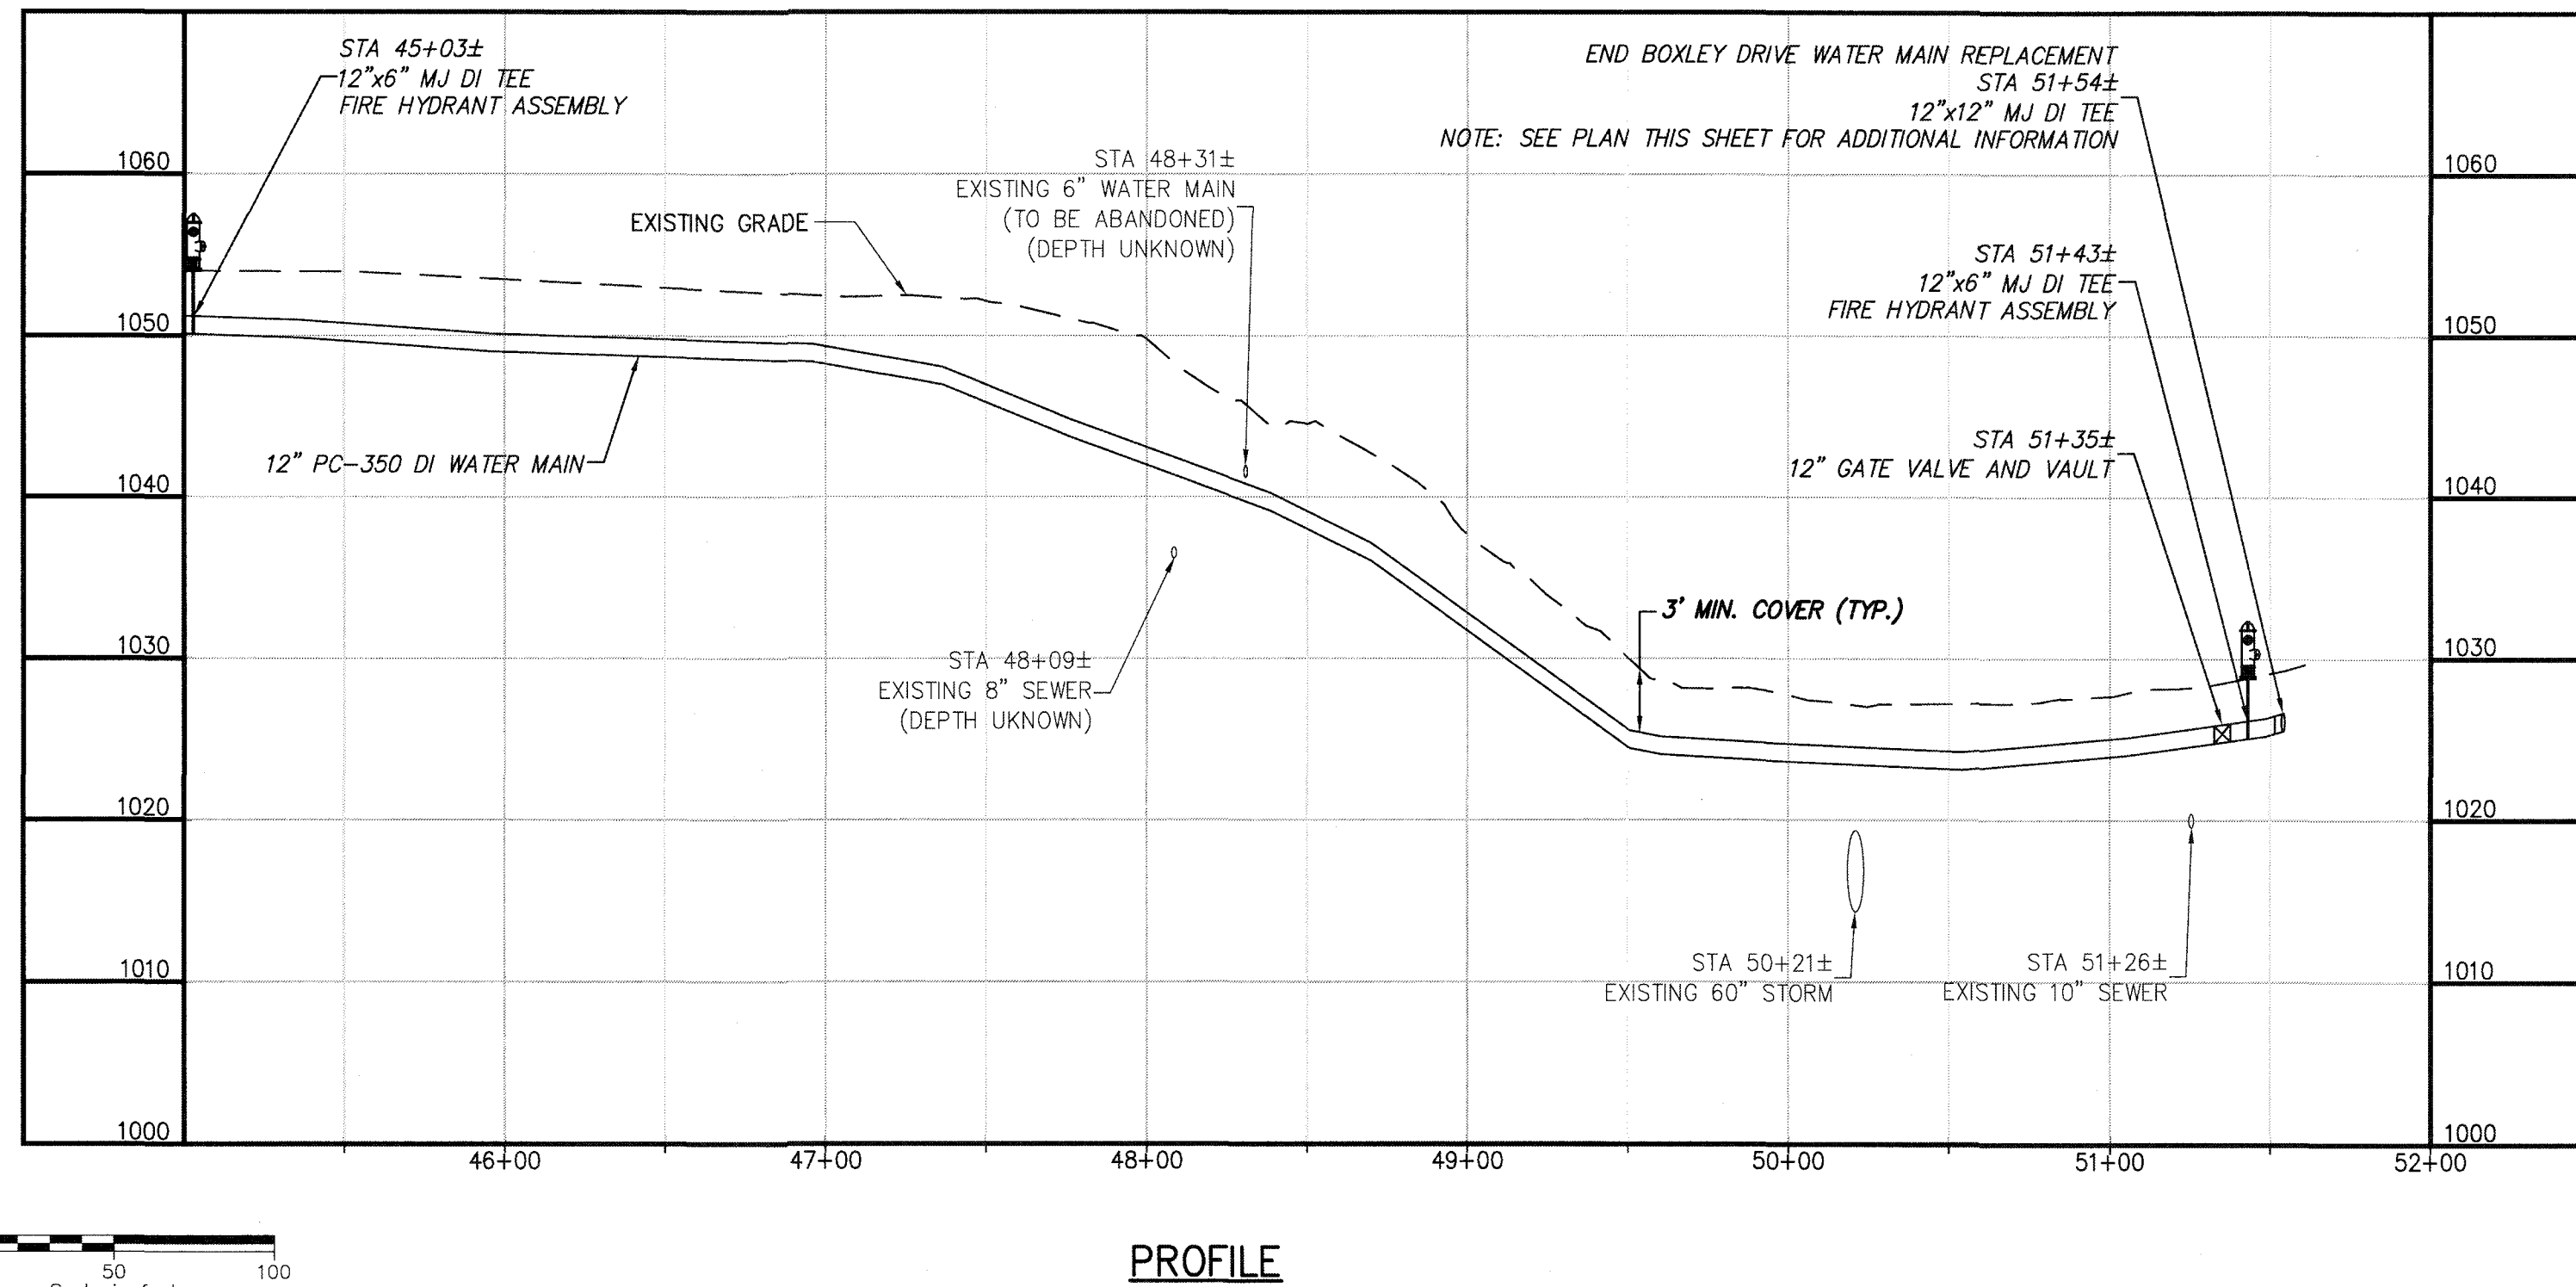


File: V:\PROJECTS\ANY\433834\CADD\ACAD\C-207-33834-PLAN AND PROFILE.DWG
Saved: 5/24/2018 4:10:13 PM Plotter: 5/25/2018 1:16:49 PM Current User: Sautter, Alan Last Saved By: 5734

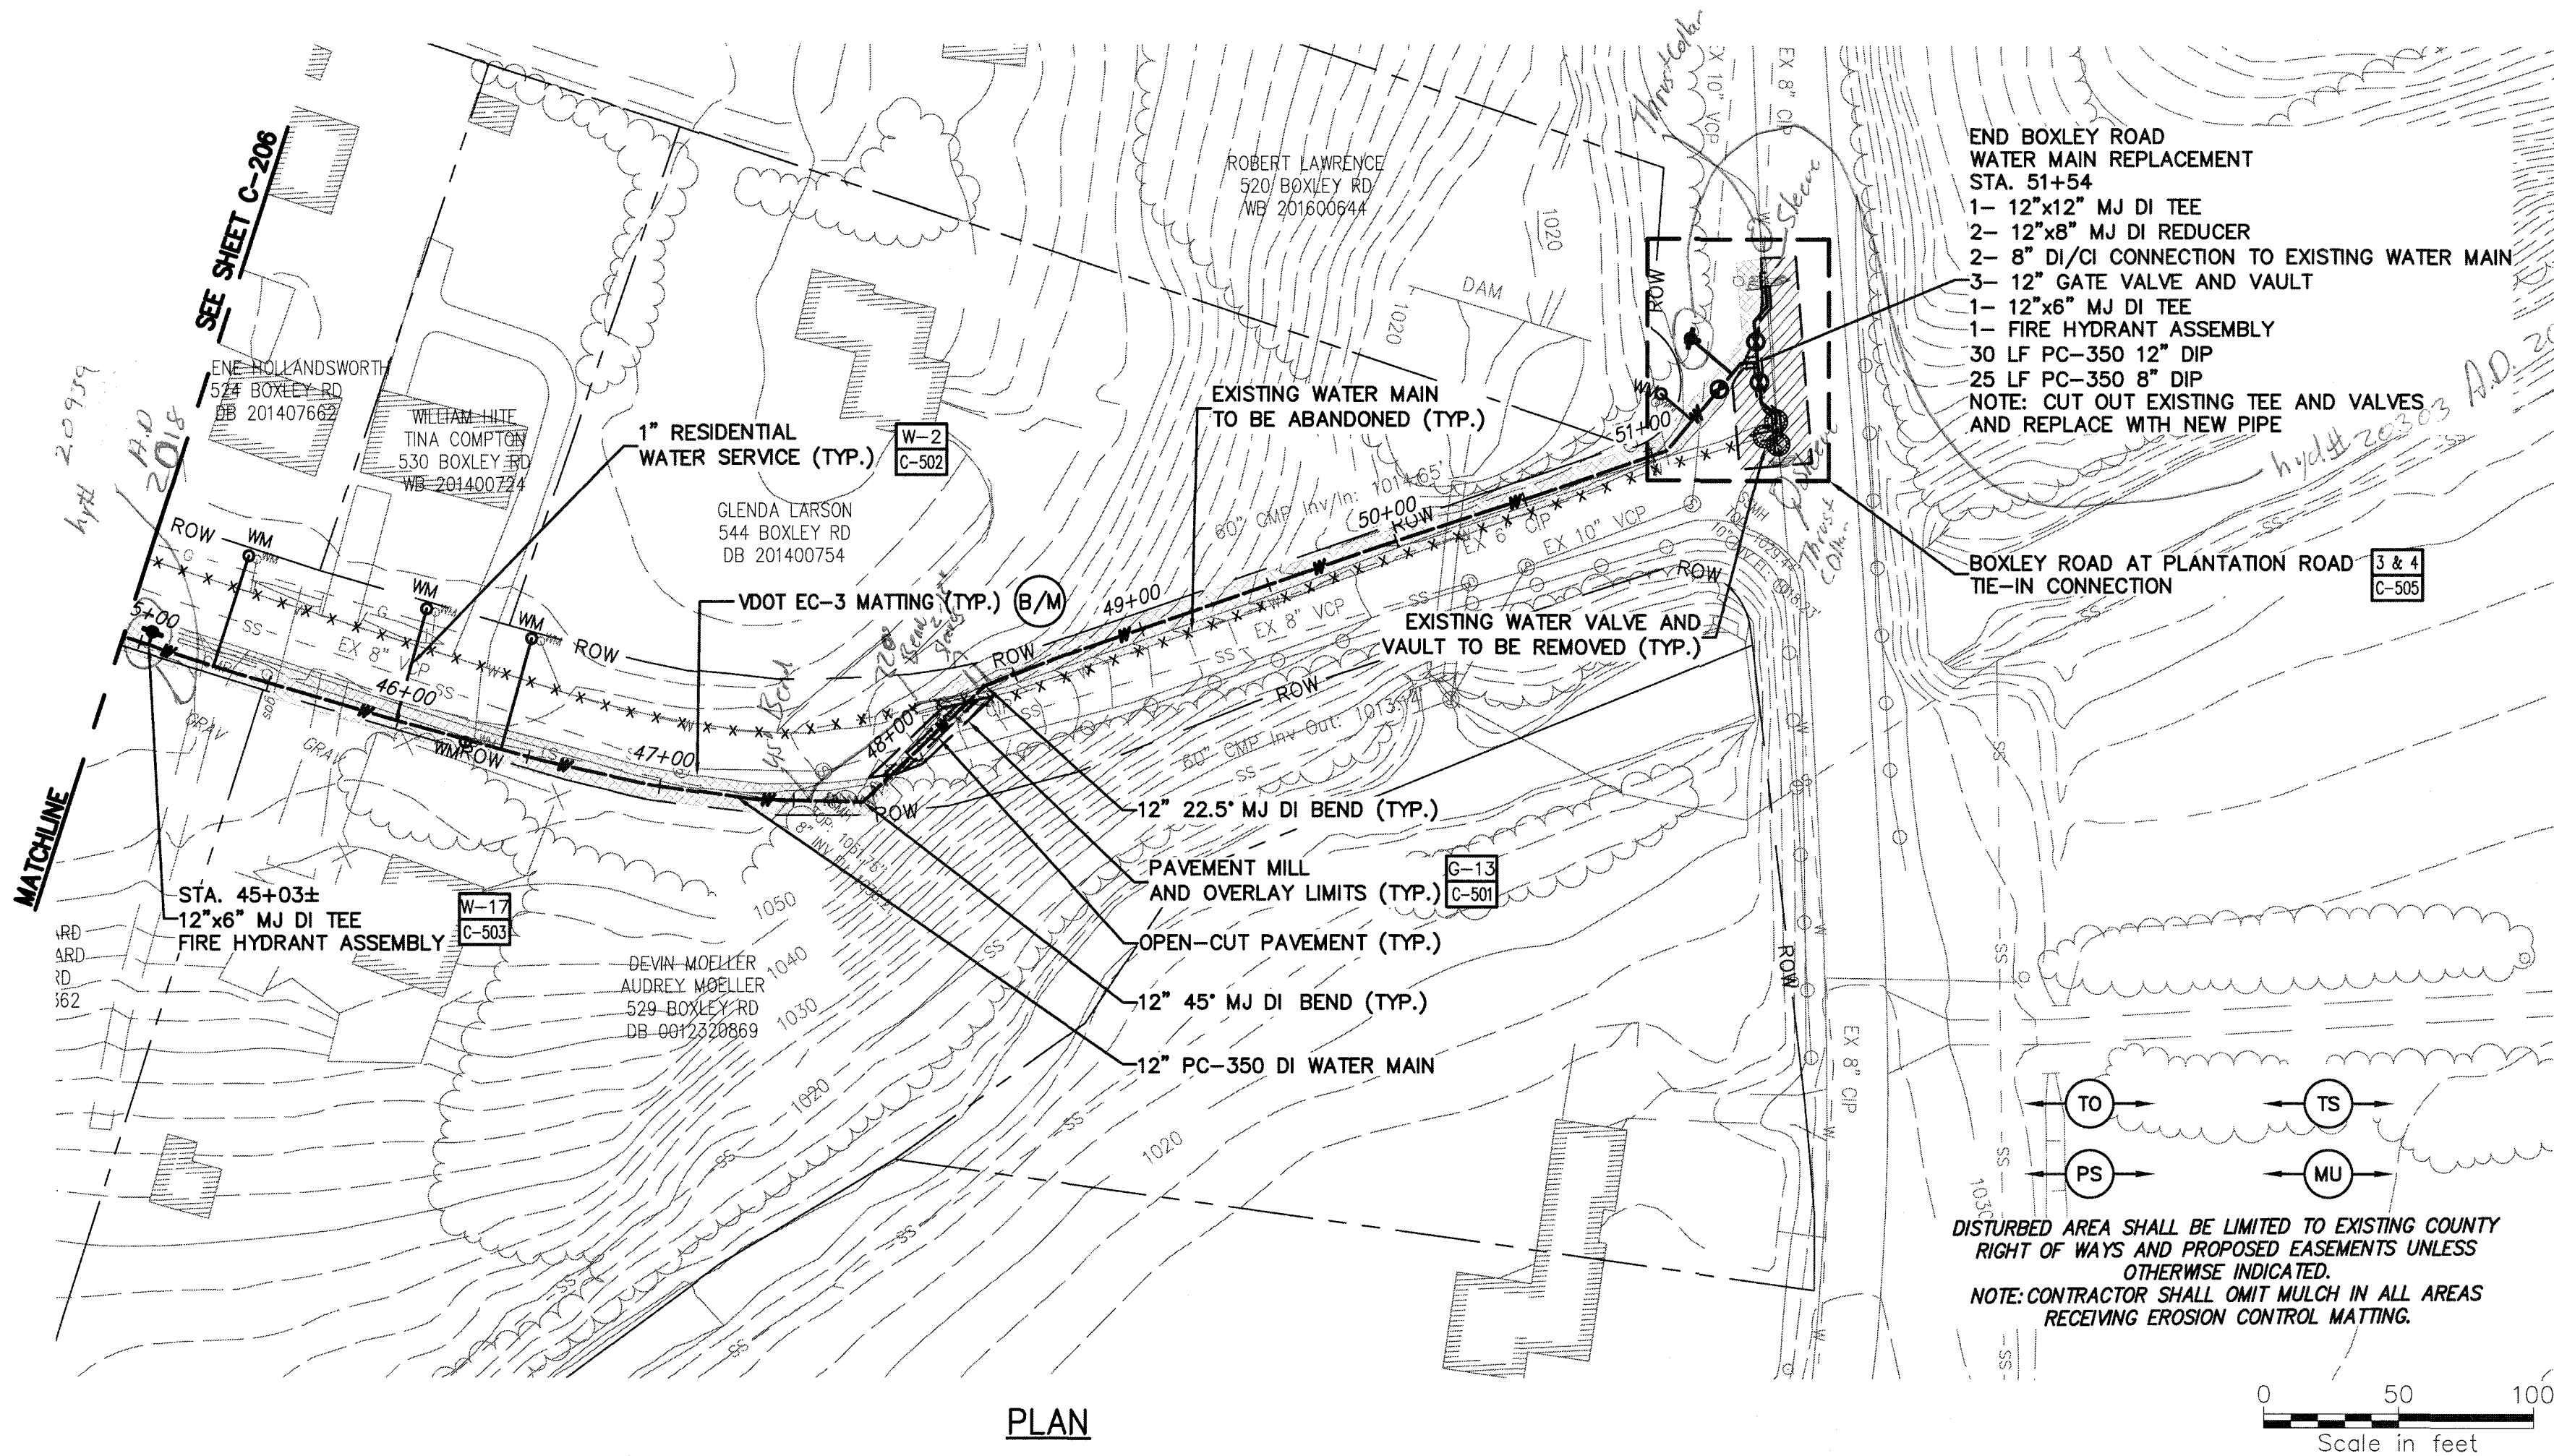

WESTERN VIRGINIA WATER AUTHORITY
ROANOKE, VIRGINIA

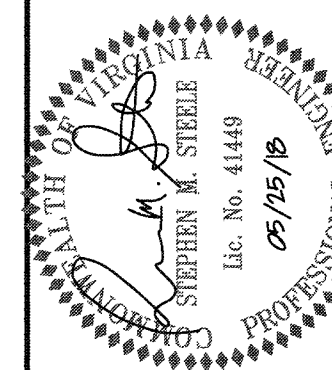

I, the undersigned, being a graduate engineer, hereby certify that the work shown on the foregoing drawing was prepared by me or under my direct supervision and that I am a duly licensed professional engineer in the State of Virginia.

WESTERN VIRGINIA WATER AUTHORITY
SUNNYBROOK DRIVE
WATER MAIN REPLACEMENT
ROANOKE COUNTY, VIRGINIA

No.	Summary / Revision	App'd By	Date
1	90% SUBMITTAL	SMS MBH	5-18-18
2	CLIENT REVIEW	SMS MBH	5-25-18

PLAN AND PROFILE - BOXLEY
ROAD WATER MAIN
(STA. 45+00 TO E.O.L.)

Designed By: MBH	Drawn By: RAS	Checked By: LES
Issue Date: 05/18/18	Project No: 33834	Scale: AS SHOWN

Drawing No.:
C-207