



File: V:\PROJECTS\ANYVA\33834\CADD\ACAD\VC-200-33834-PLAN AND PROFILE.DWG
Saved: 5/24/2018 4:10:13 PM, Plotted: 5/25/2018 11:06:59 PM, Current User: Sources, Alan Lee/Sources, 5734

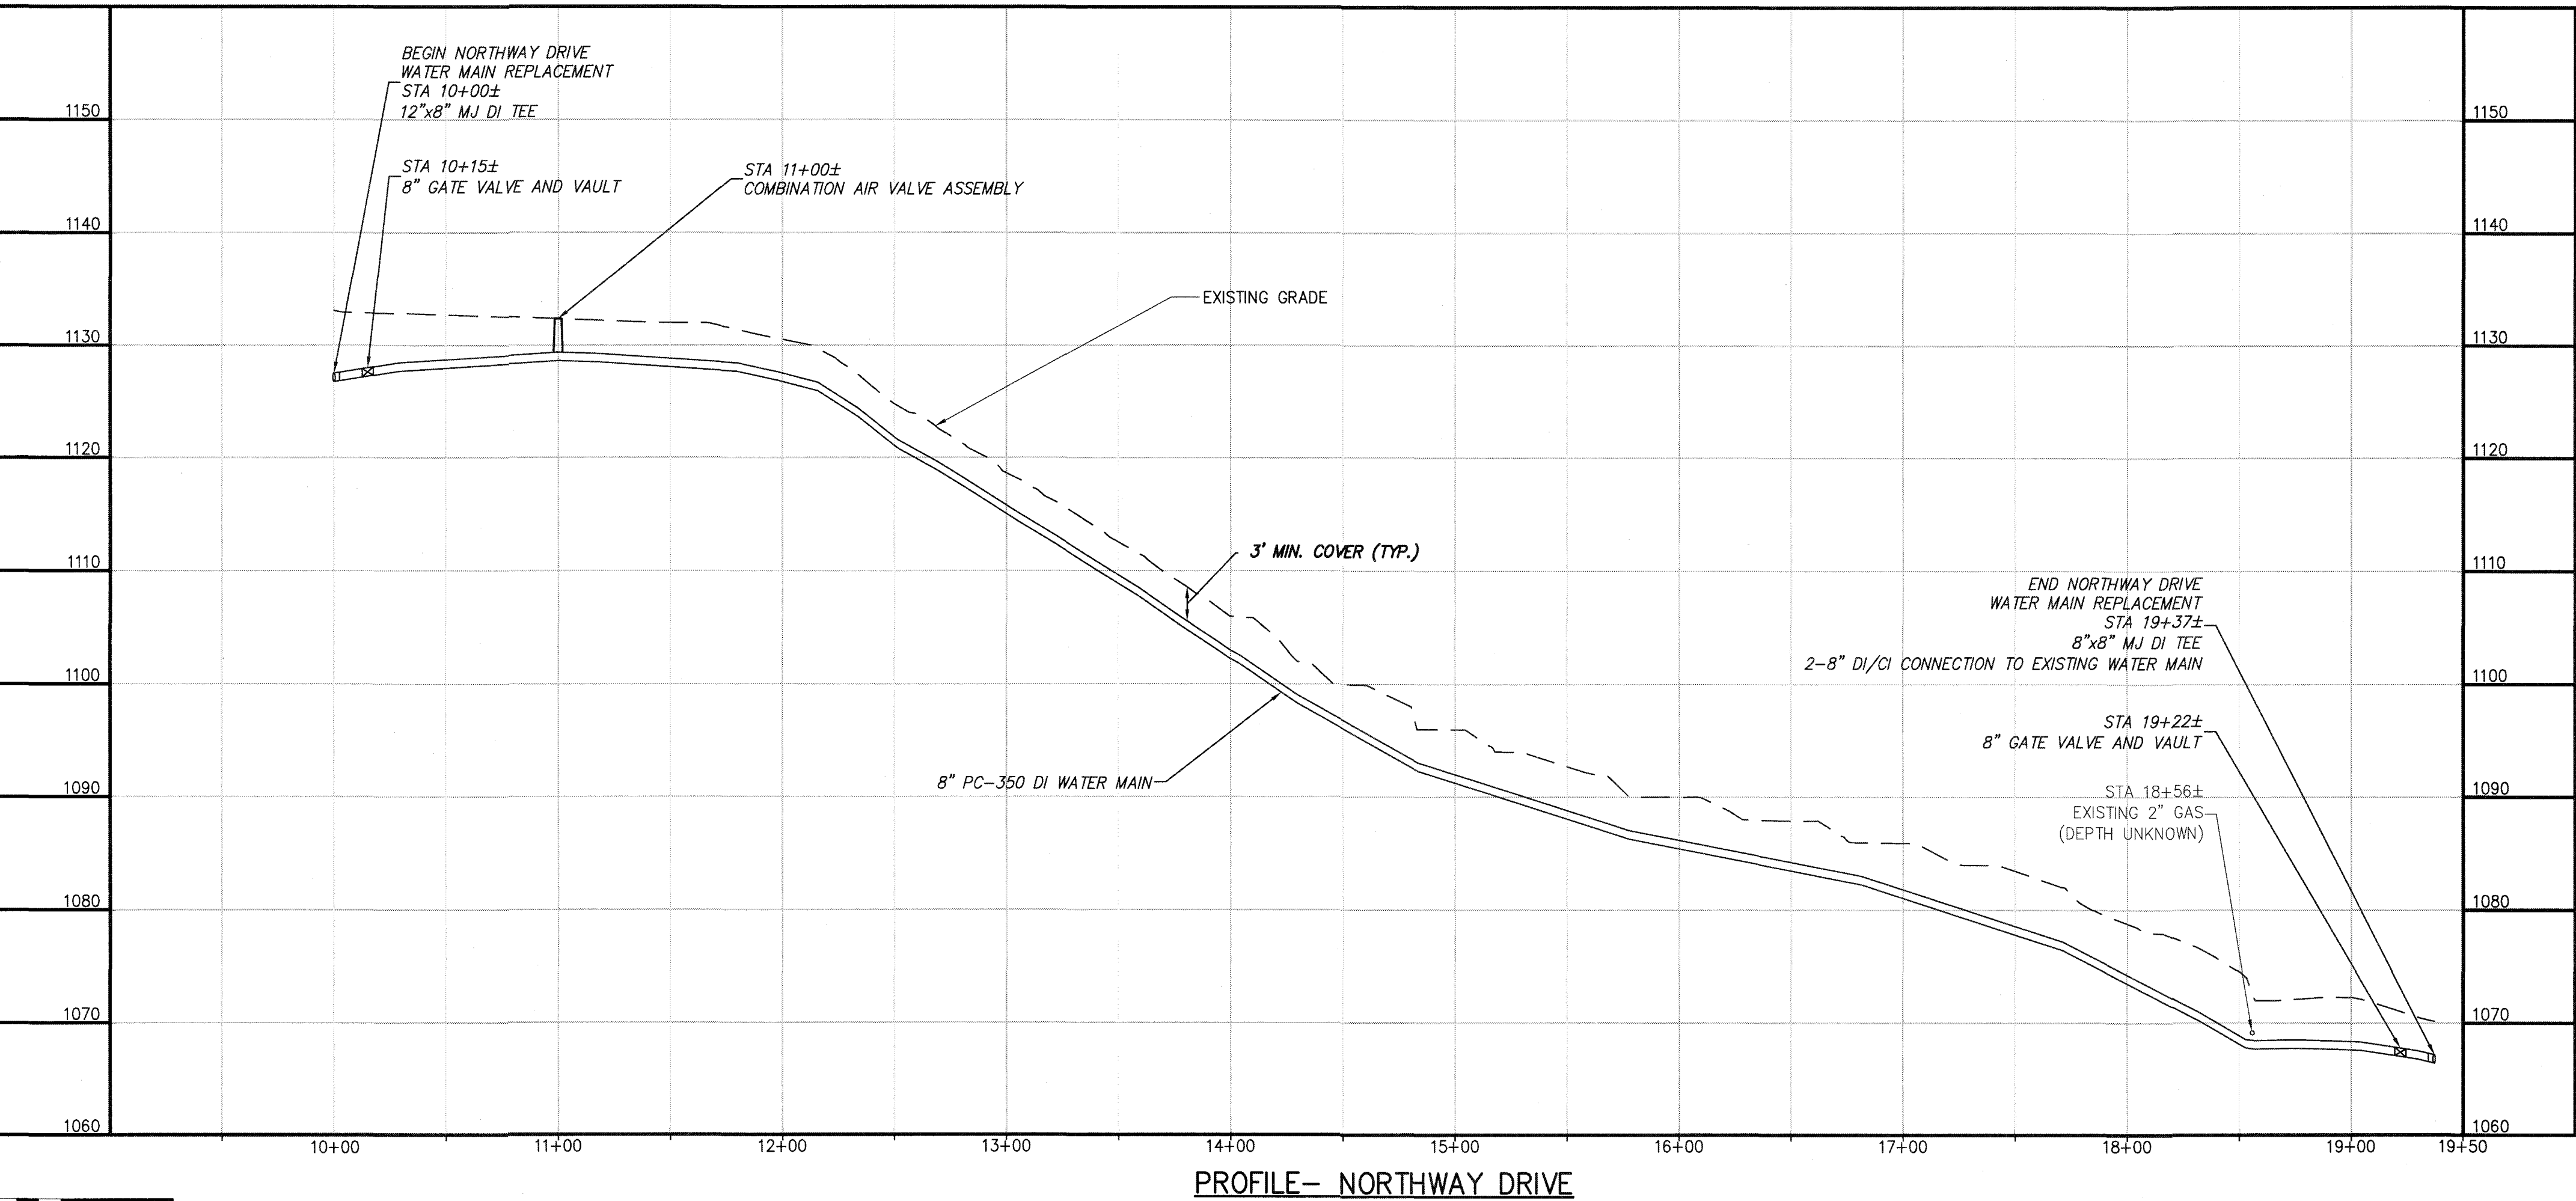


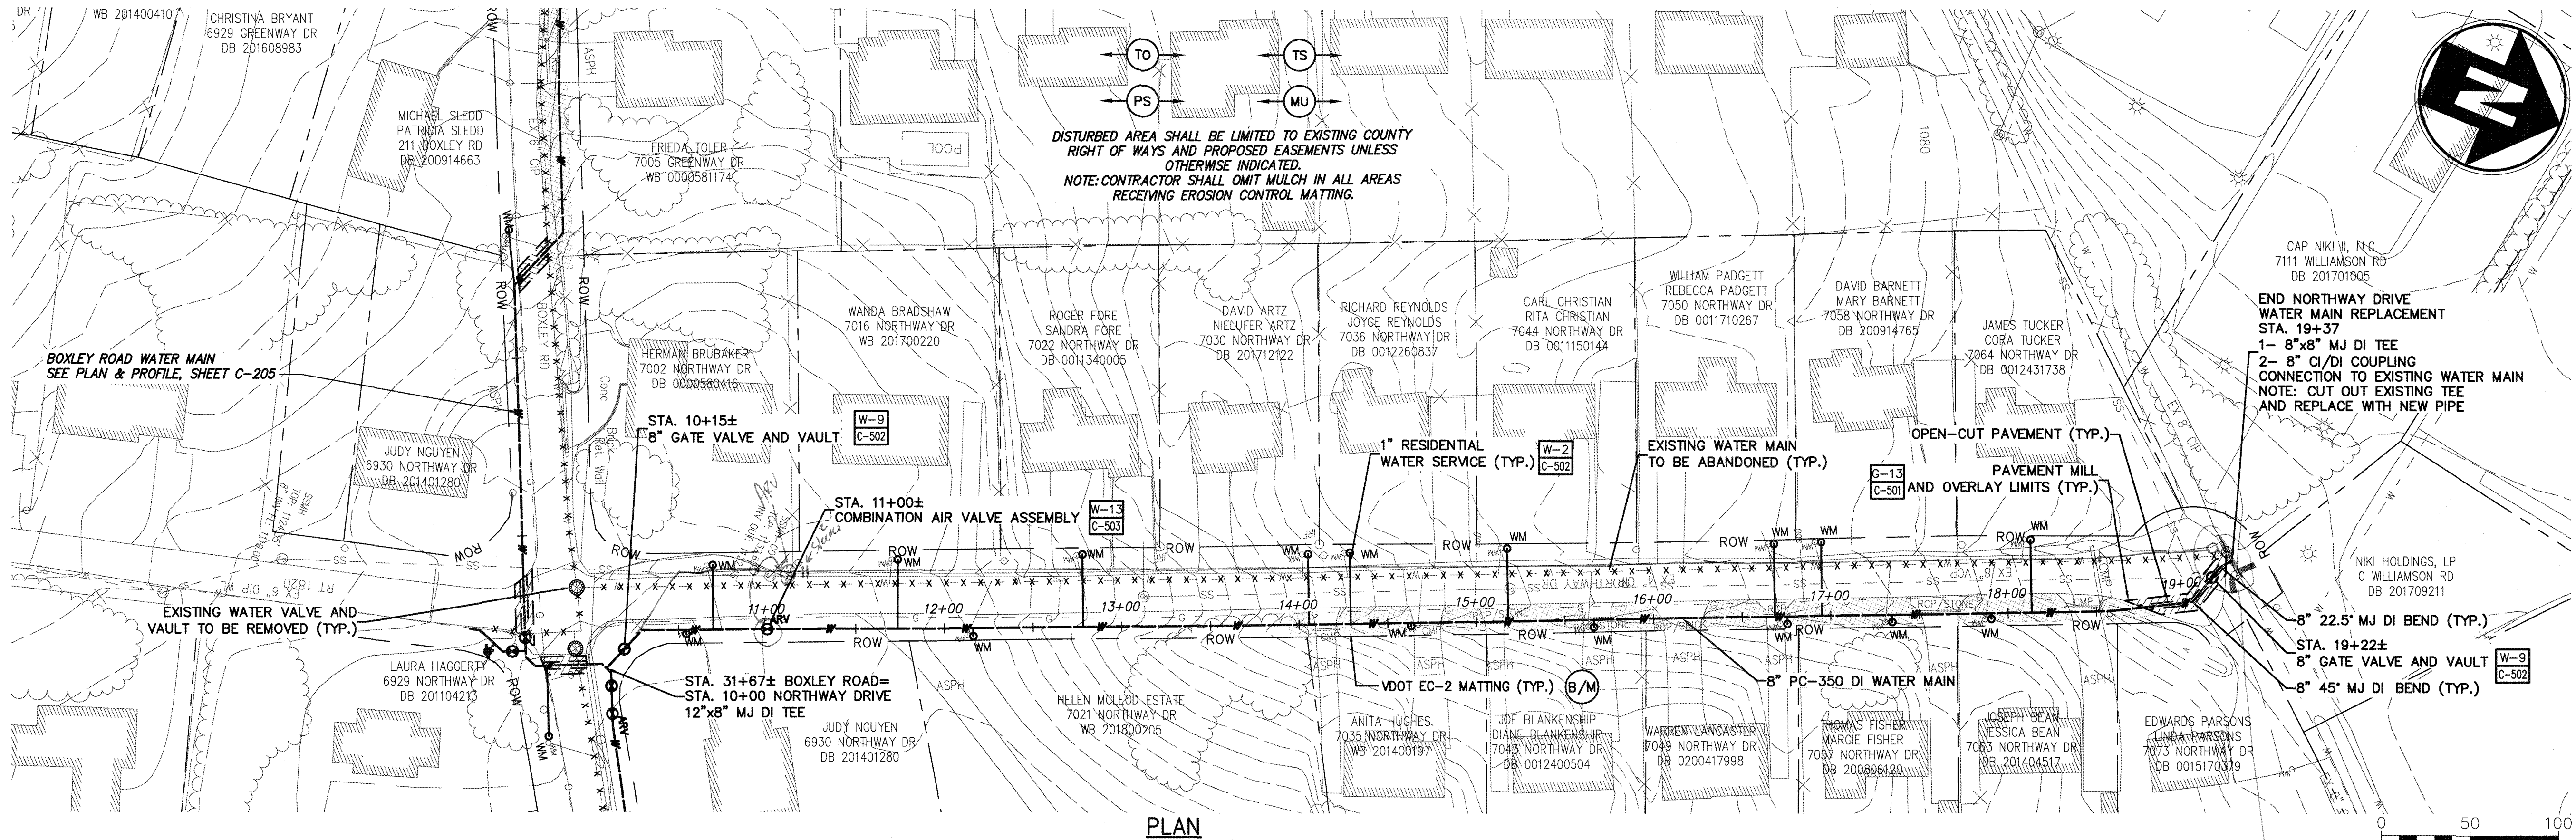

1341 Research Center Drive, Suite 2100
940.552.5548 • www.chaplanes.com

WESTERN VIRGINIA
WATER AUTHORITY

WESTERN VIRGINIA WATER AUTHORITY
ROANOKE, VIRGINIA

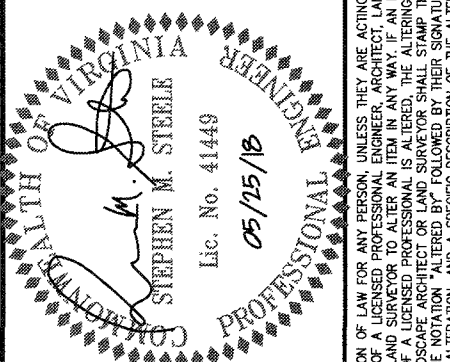

WESTERN VIRGINIA WATER AUTHORITY
SUNNYBROOK DRIVE
WATER MAIN REPLACEMENT
ROANOKE COUNTY, VIRGINIA

No.	Submitted / Revision	App'd By	Date
1	90% SUBMITTAL	SMS/MBH	5-18-18
2	CLIENT REVIEW	SMS/MBH	5-25-18

PLAN AND PROFILE -
NORTHWAY DRIVE
WATER MAIN
(STA. 10+00 TO E.O.L.)

Designed By	Drawn By	Checked By
MBH	RAS	LES

Issue Date	Project No.	Scale
05/18/18	33834	AS SHOWN

Drawing No.:
C-208