



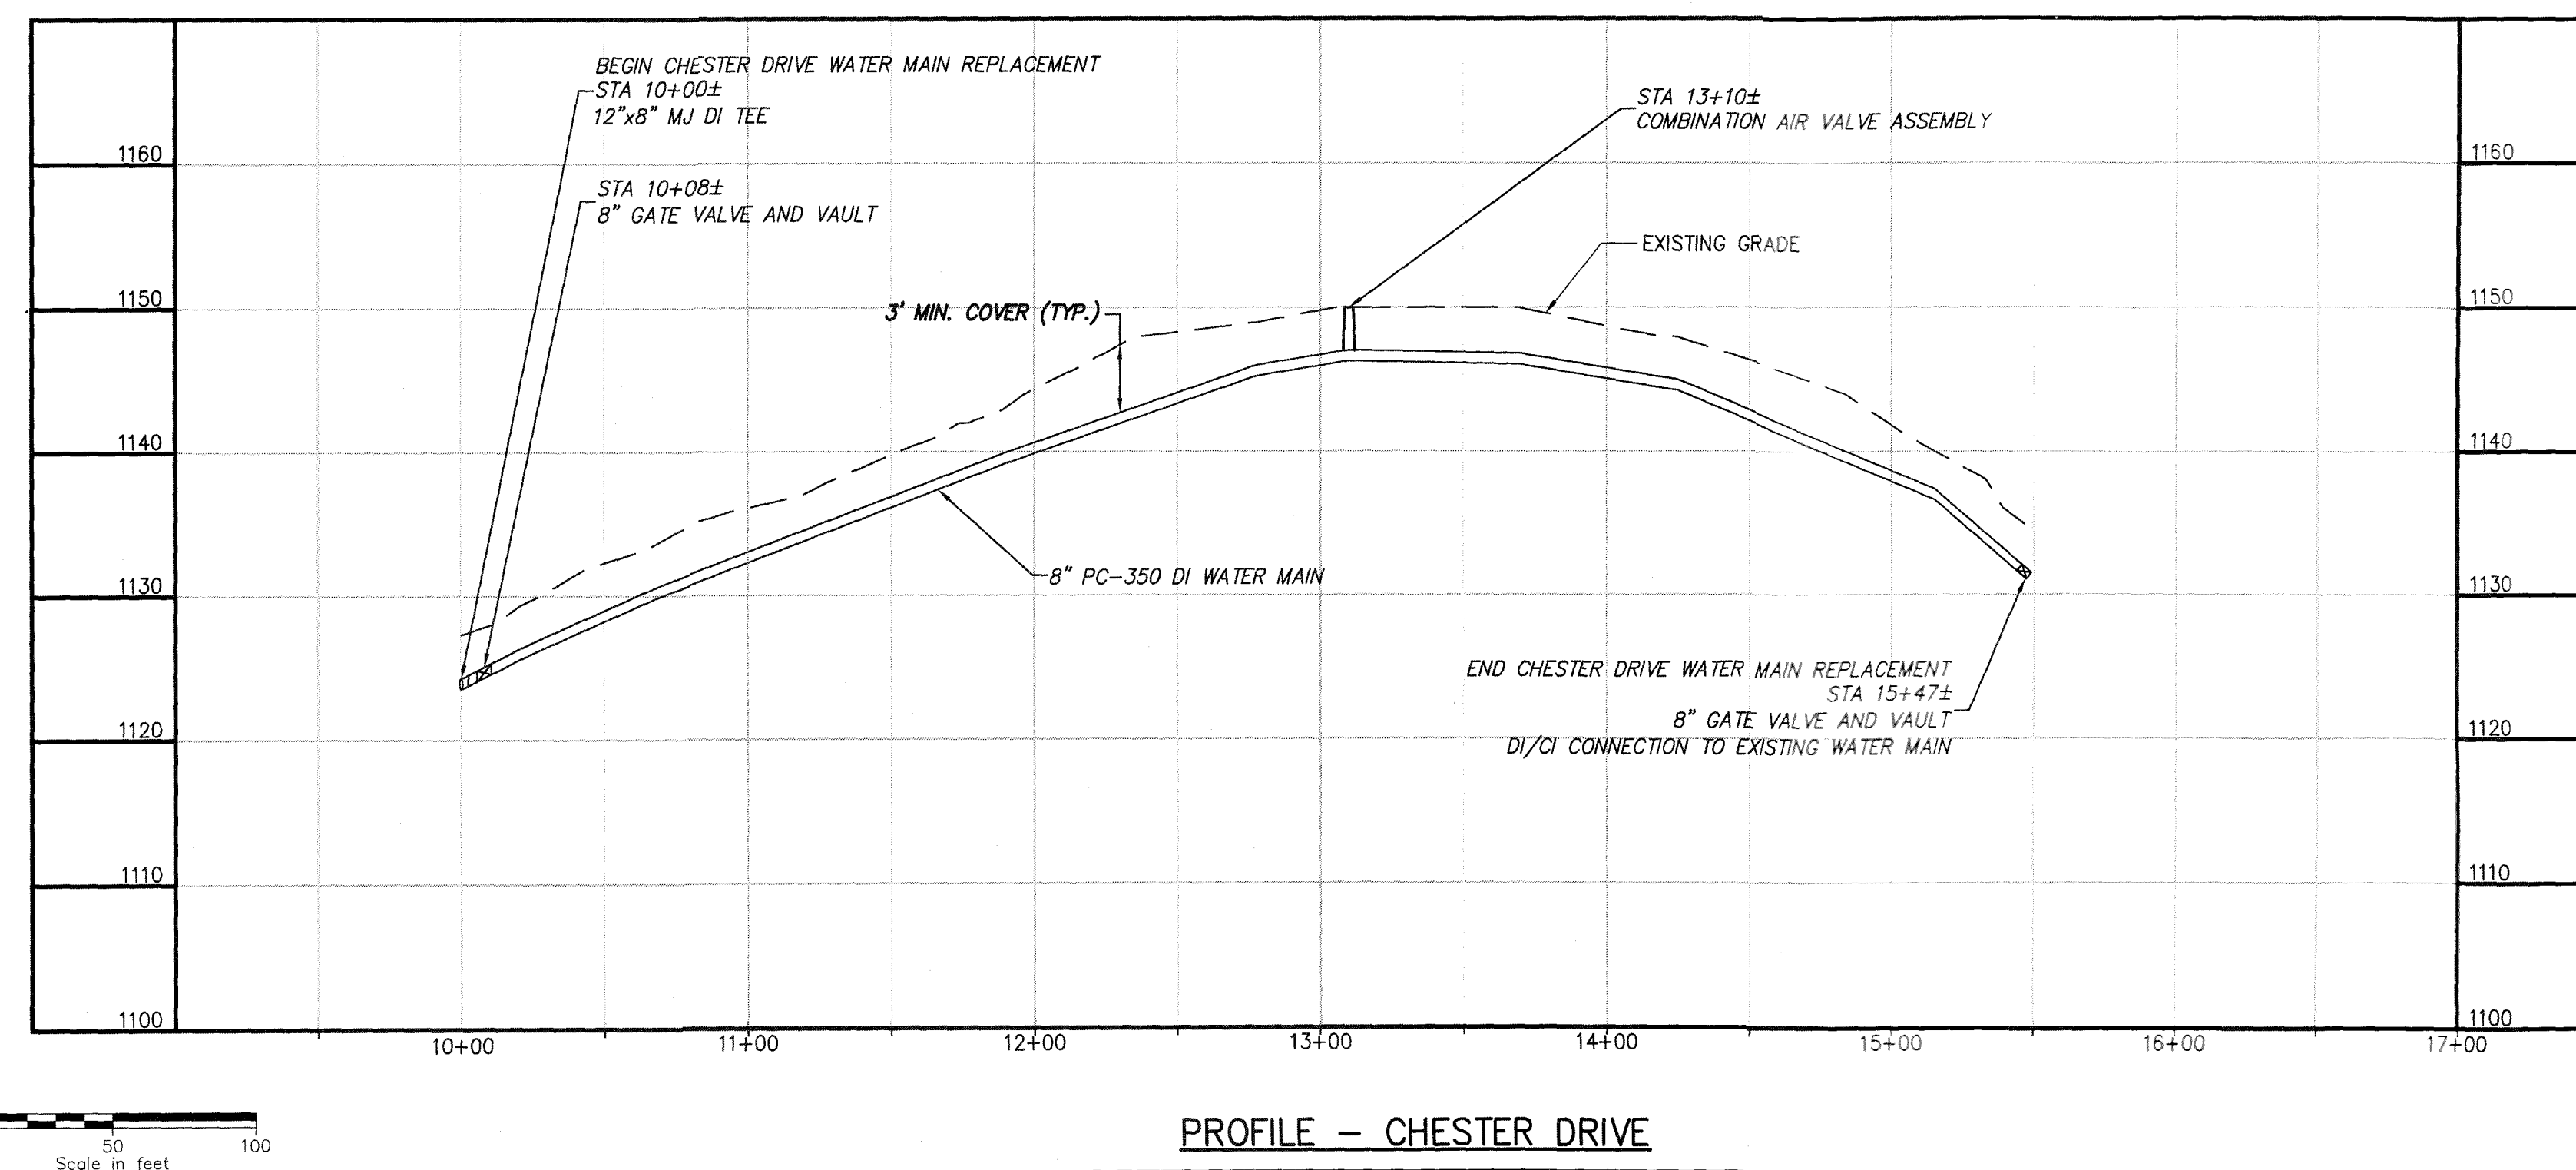


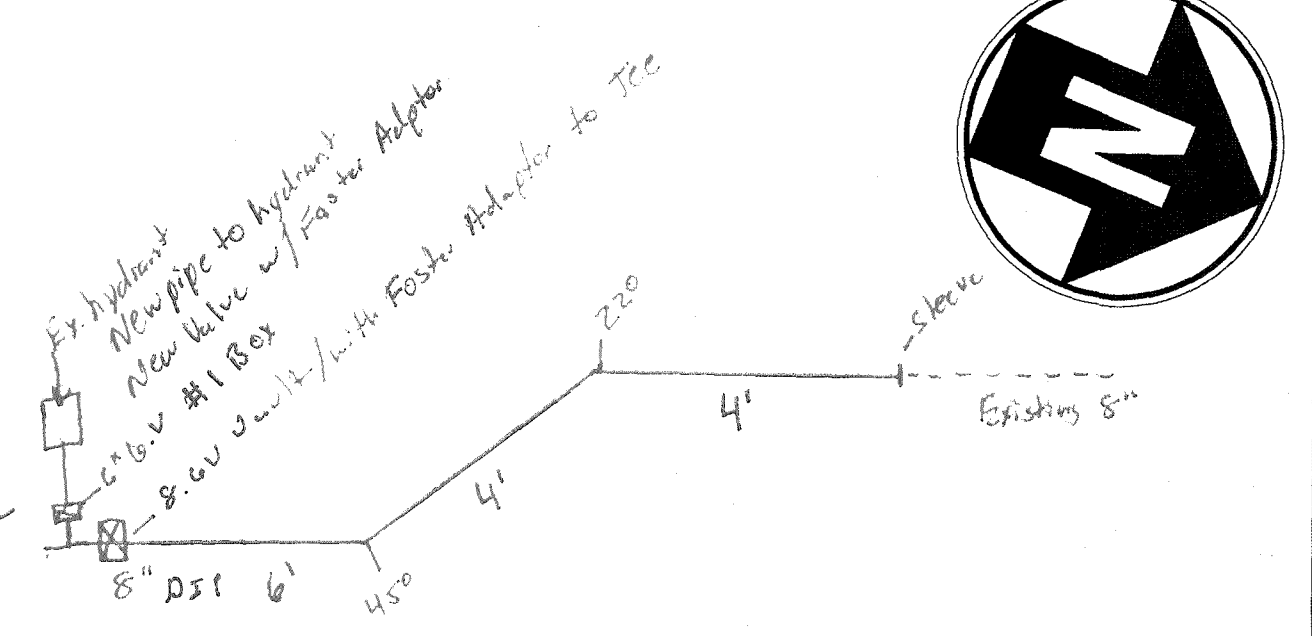

 Drawing Copyright © 2018
 1341 Research Center Drive, Suite 2100
 Blacksburg, VA 24060
 540.552.5548 • www.chiacompanies.com



WESTERN VIRGINIA
WATER AUTHORITY
ROANOKE, VIRGINIA

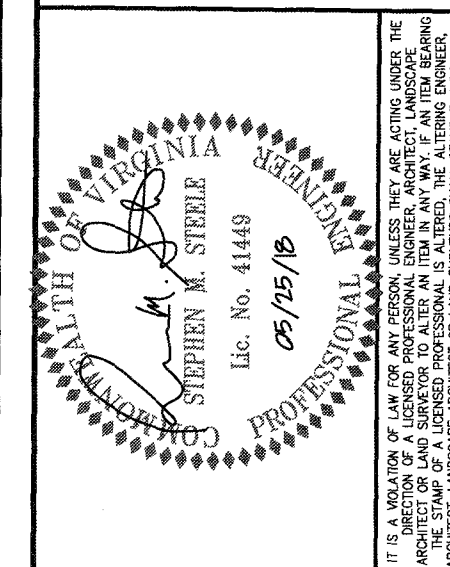

WESTERN VIRGINIA WATER AUTHORITY
SUNNYBROOK DRIVE
WATER MAIN REPLACEMENT
ROANOKE COUNTY, VIRGINIA

[illegible]

PLAN AND PROFILE -
CHESTER DRIVE
WATER MAIN
(STA. 10+00 TO E.O.L.)

Designed By: MBH	Drawn By: RAS	Checked By: LES
Issue Date: 05/18/18	Project No: 33834	Scale: AS SHOWN

Drawing No.:
C-209