


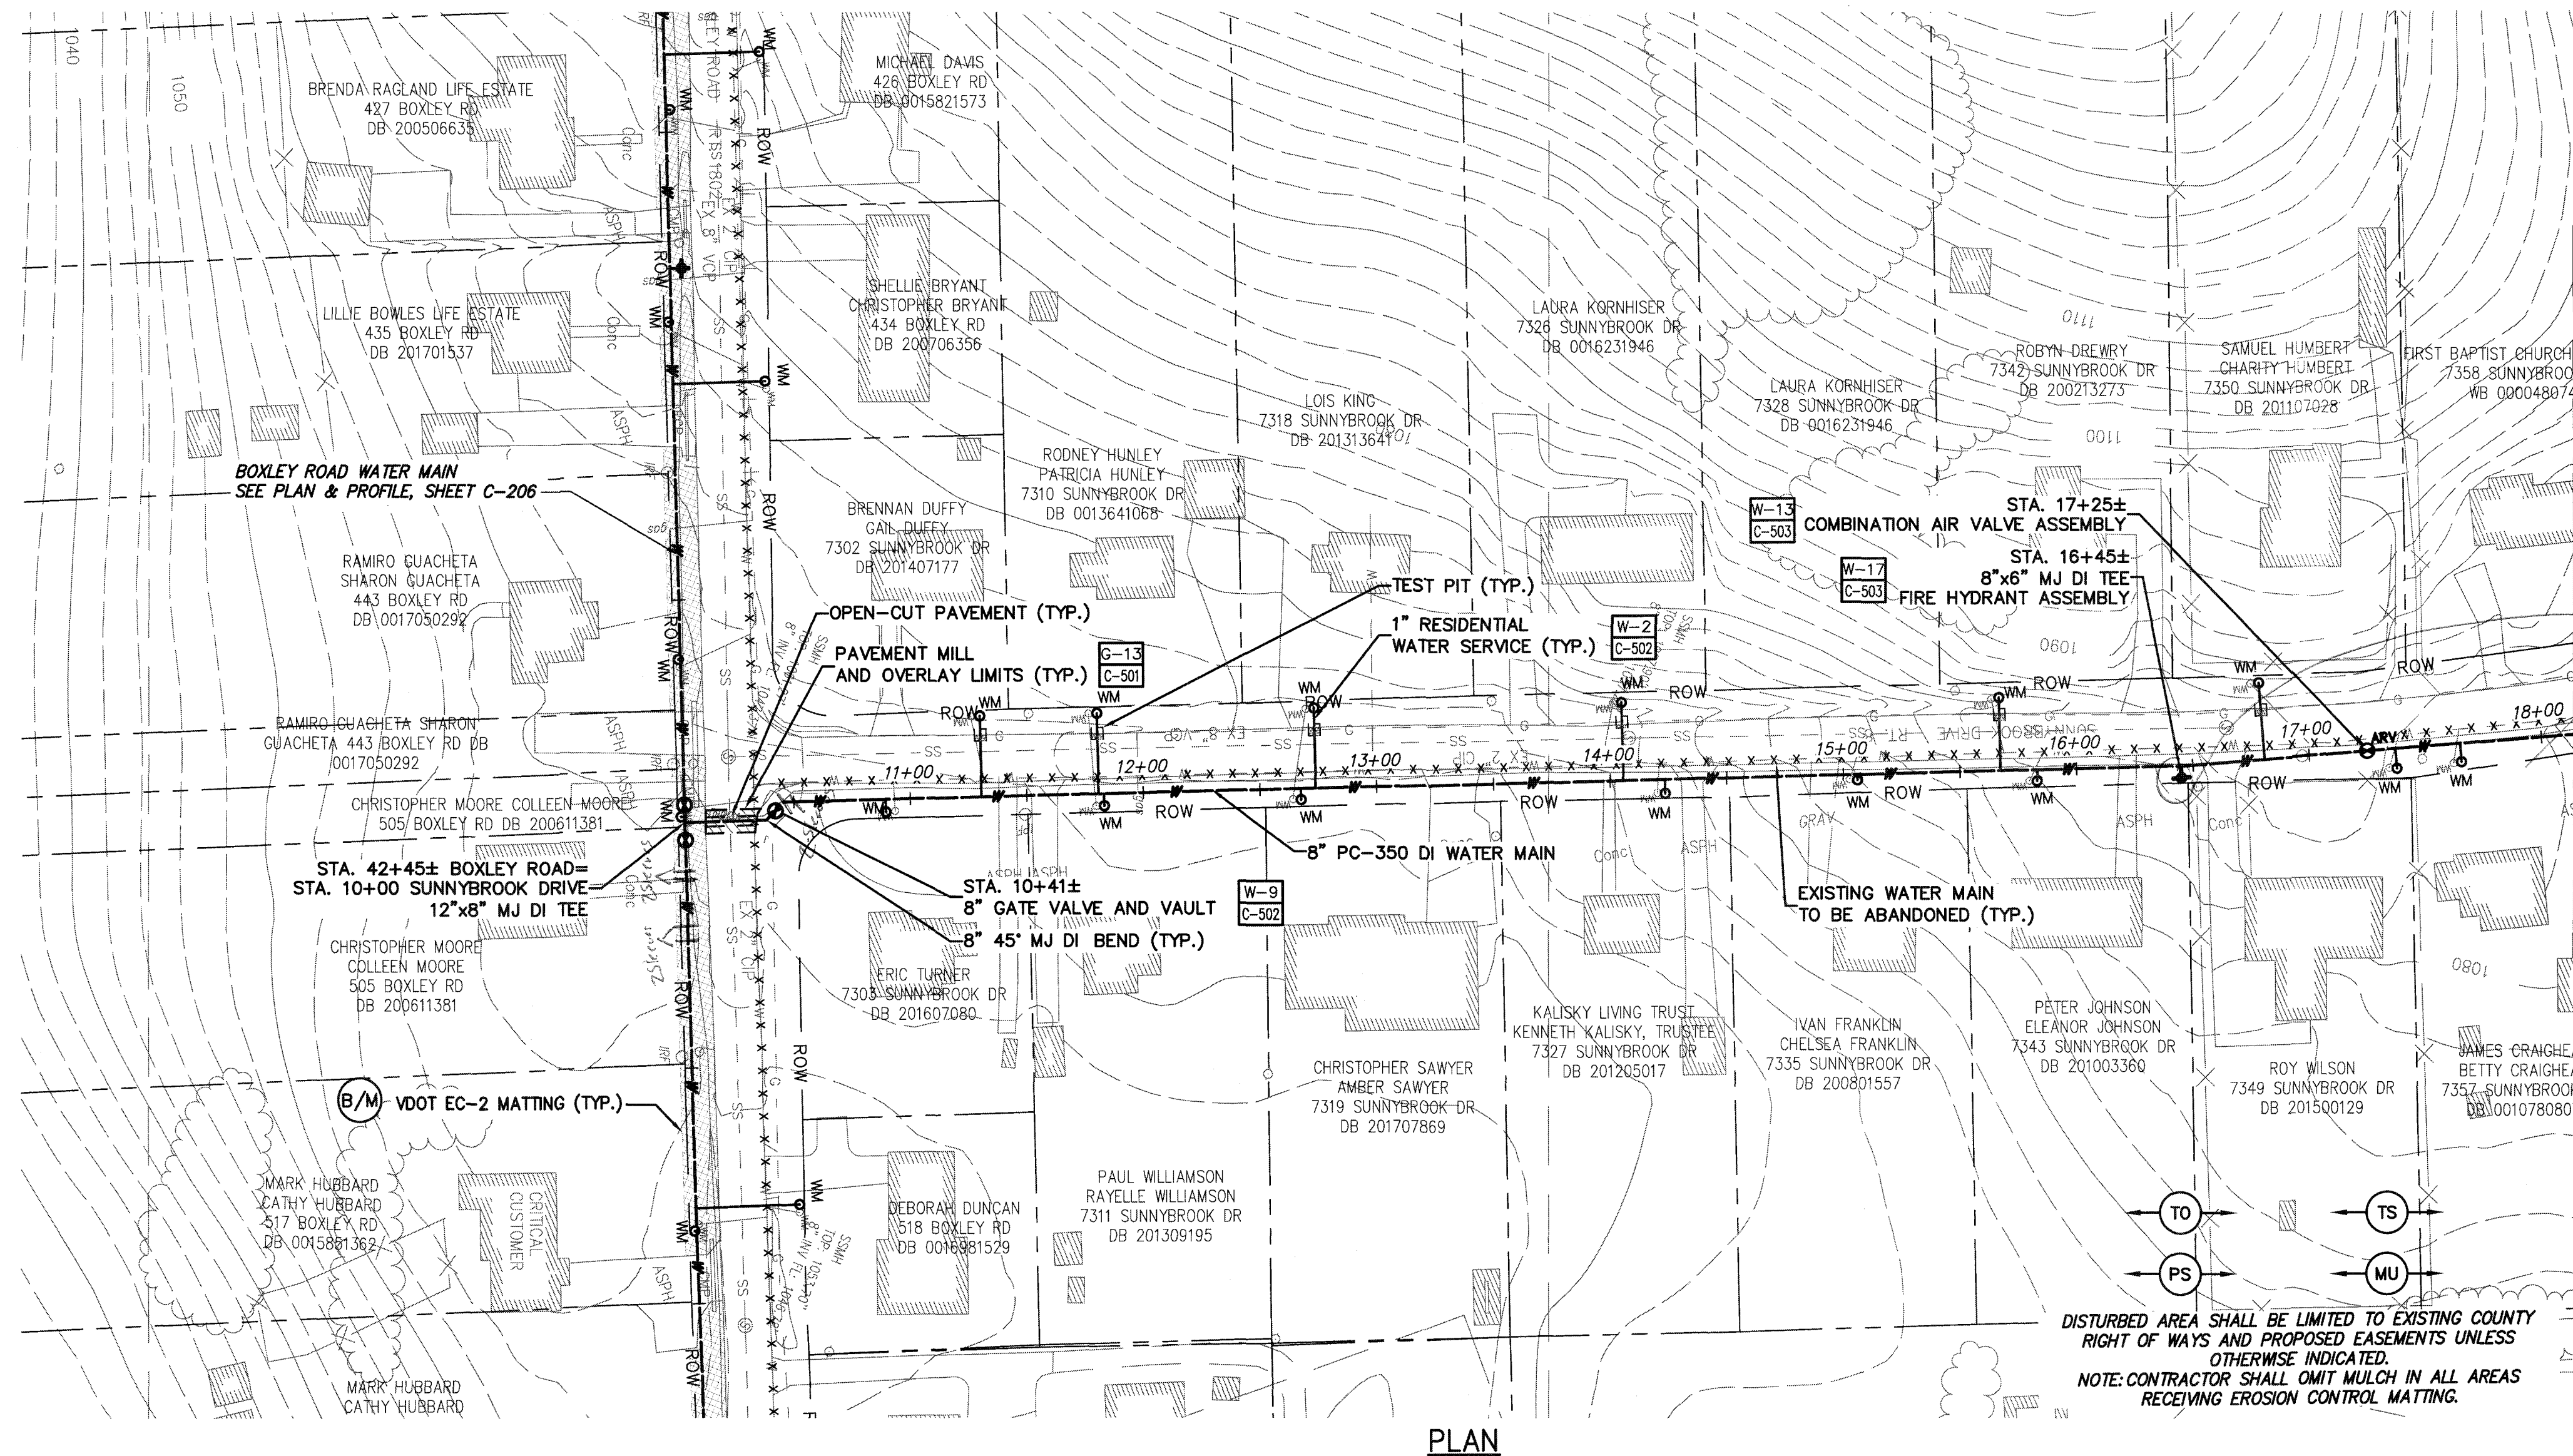


File: V:\PROJECTS\WV\433834\ACAD\C-206-33834-PLAN AND PROFILE.DWG
Saved: 5/24/2018 4:10:13 PM Plotted: 5/25/2018 1:17:19 PM Current User: Squires, Alan Last Saved By: 5734

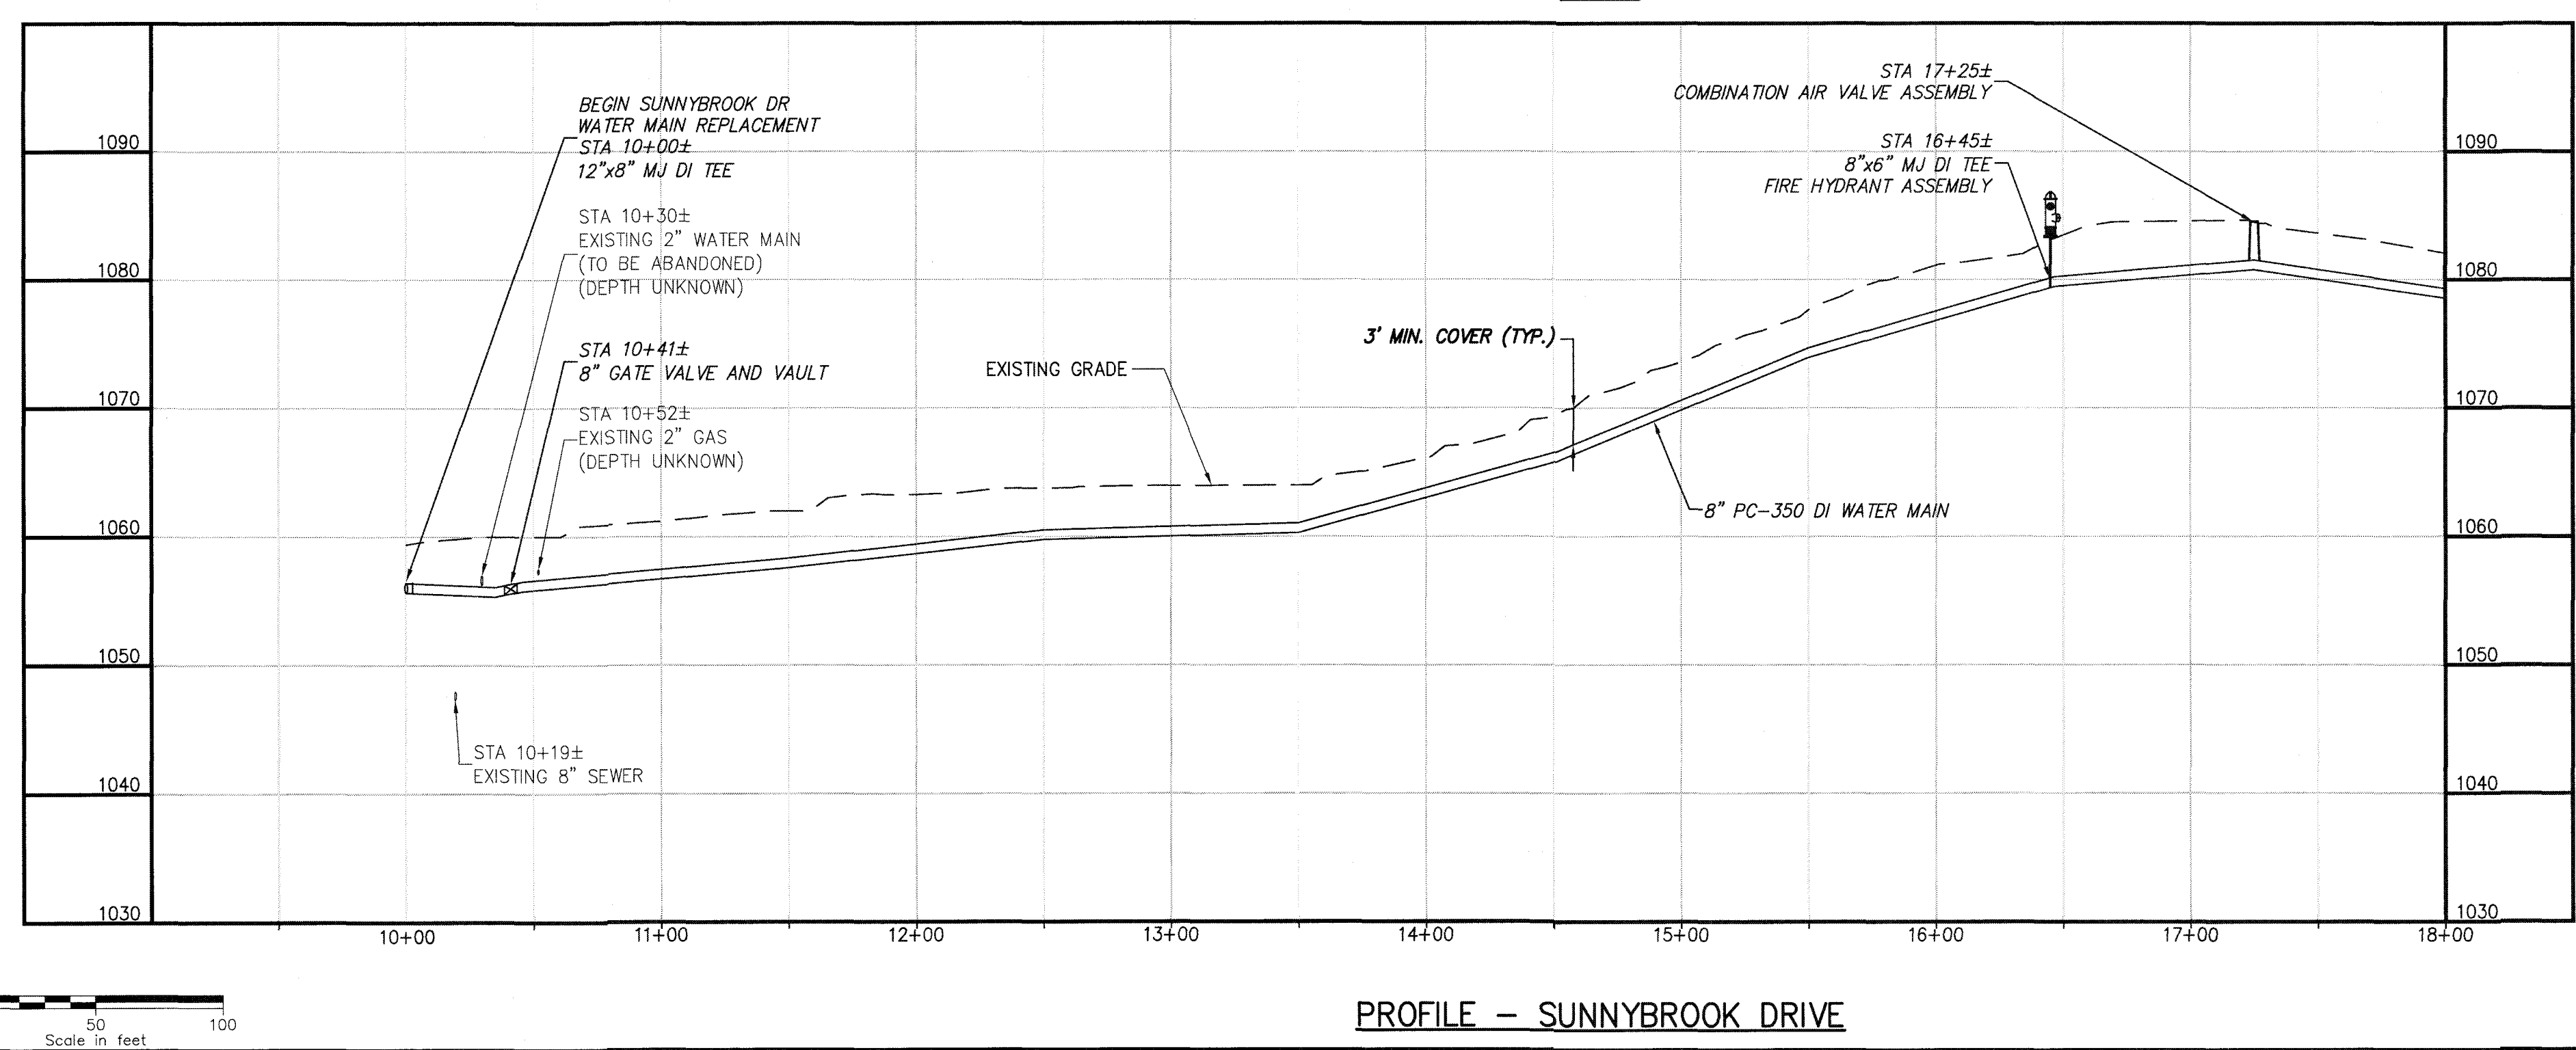


2015 AD
17# 21292

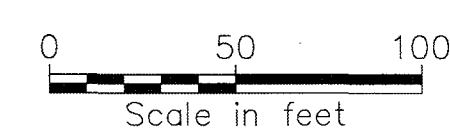


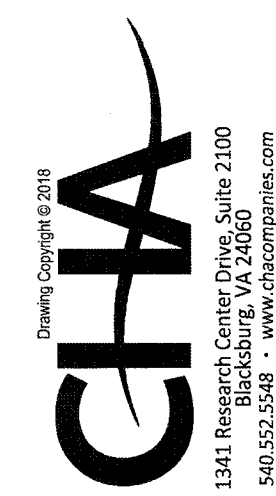

1341 Riverchase Parkway, Suite 2100
Buckeye, VA 22600
540.952.5548 • www.chacorporates.com

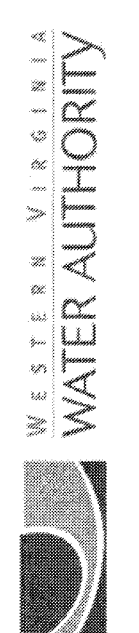

WESTERN VIRGINIA WATER AUTHORITY
ROANOKE, VIRGINIA

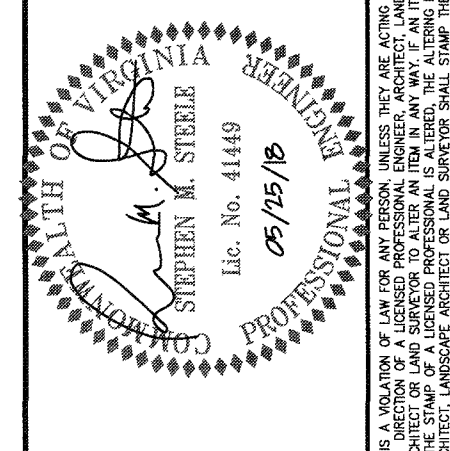

IT IS A VIOLATION OF LAW FOR ANY PERSON, FIRM OR CORPORATION, UNLESS THEY ARE A LICENSED PROFESSIONAL ENGINEER, TO PREPARE, SEAL OR SIGN ANY ENGINEERING DRAWING, SPECIFICATION, REPORT OR OTHER DOCUMENT, OR TO BE RESPONSIBLE FOR ANY SUCH ACTION, WITHOUT BEING A LICENSED PROFESSIONAL ENGINEER. ANY PERSON, FIRM OR CORPORATION WHOSE NAME IS PLACED ON ANY SUCH DOCUMENT, KNOWING IT IS NOT A LICENSED PROFESSIONAL ENGINEER, OR WHOSE NAME IS PLACED ON ANY SUCH DOCUMENT, KNOWING IT IS NOT A LICENSED PROFESSIONAL ENGINEER, OR WHOSE NAME IS PLACED ON ANY SUCH DOCUMENT, KNOWING IT IS NOT A LICENSED PROFESSIONAL ENGINEER, IS SUBJECT TO THE PENALTIES OF THE LAW.

WESTERN VIRGINIA WATER AUTHORITY
SUNNYBROOK DRIVE
WATER MAIN REPLACEMENT
ROANOKE COUNTY, VIRGINIA

No.	Submital / Revision	App'd By	Date
1	90% SUBMITTAL	SMS/MBH	5-18-18
2	CLIENT REVIEW	SMS/MBH	5-25-18

PLAN AND PROFILE -
SUNNYBROOK DRIVE
WATER MAIN
(STA. 10+00 TO STA. 18+00)

Designed By	Drawn By	Checked By
MBH	RAS	LES

Issue Date	Project No.	Scale
05/18/18	33834	AS SHOWN

Drawing No.:
C-210