
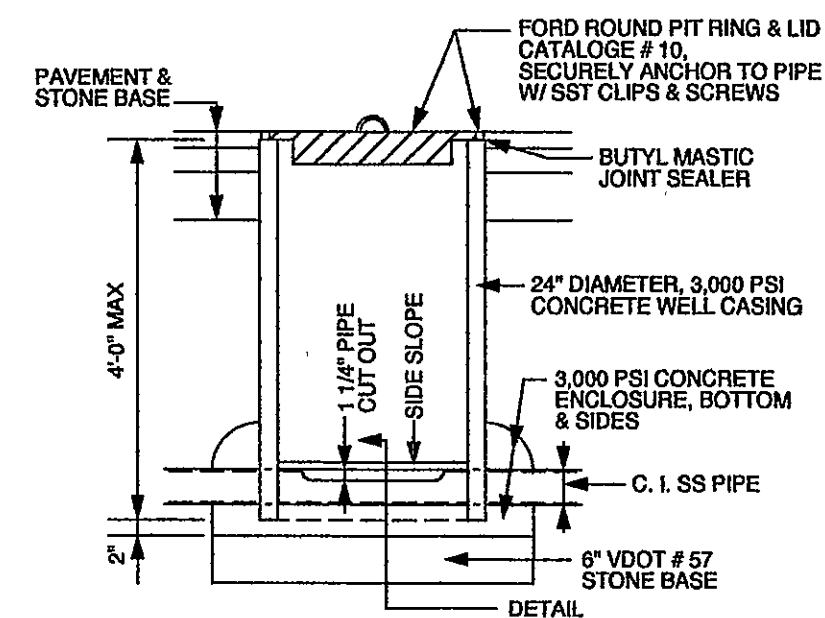
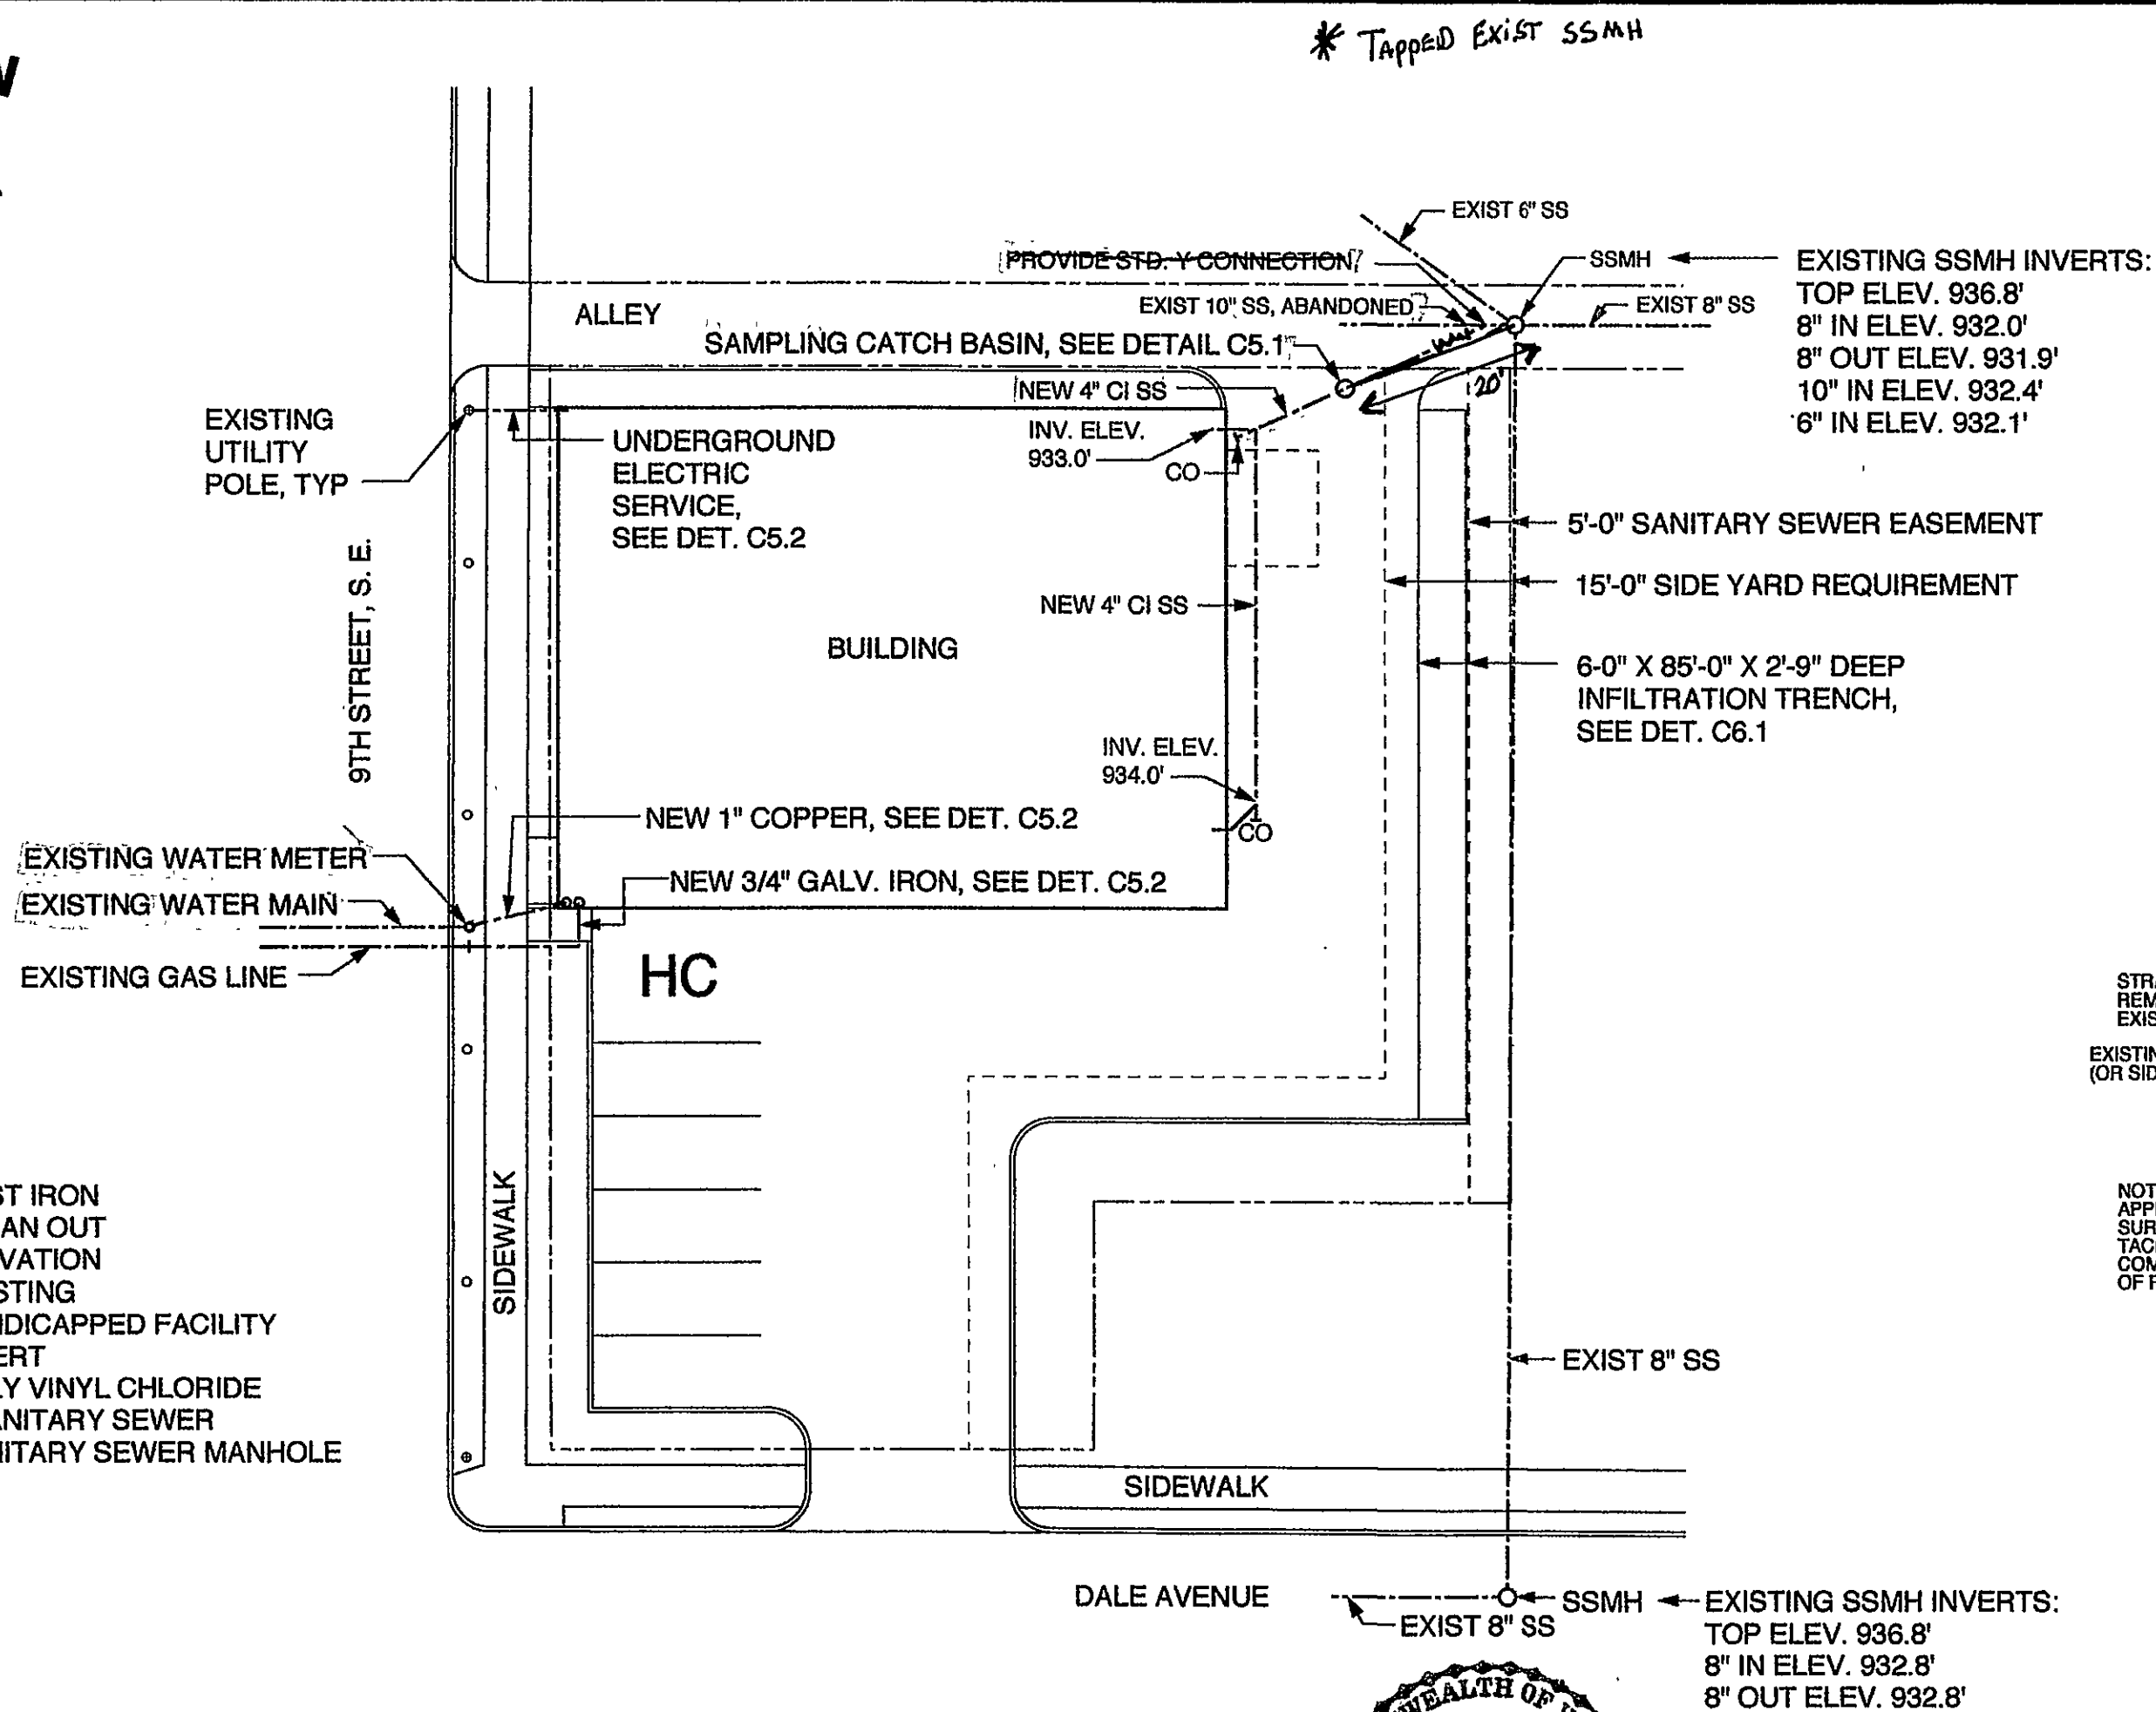


SAMPLING CATCH BASIN DETAIL C5.1
SCALE: 1/2" = 1'-0"

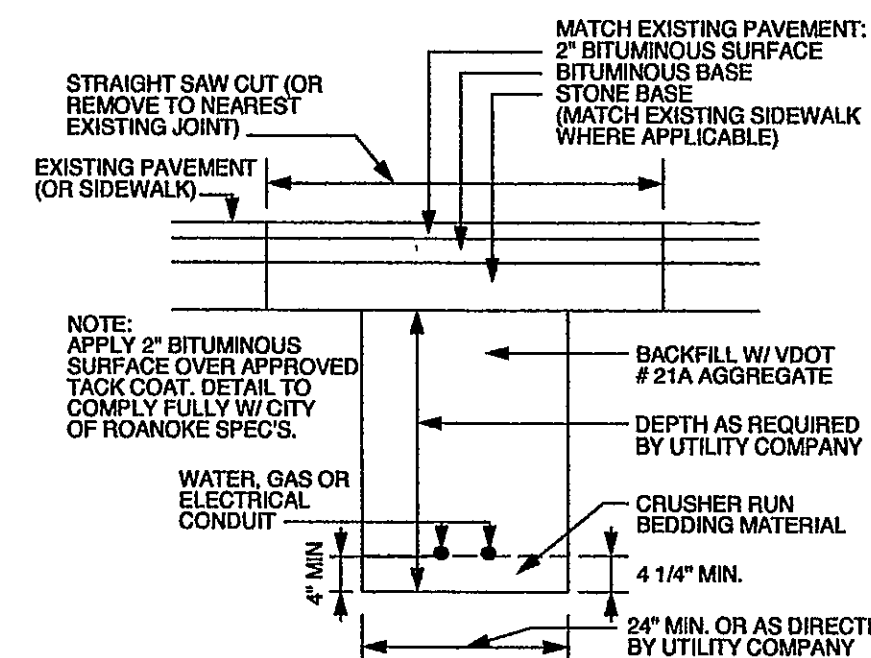


UTILITY TRENCH REPAIR DETAIL C5.2
SCALE: 1/2" = 1'-0"

- LEGEND:**
- CI CAST IRON
 - CO CLEAN OUT
 - ELEV ELEVATION
 - EXIST EXISTING
 - HC HANDICAPPED FACILITY
 - INV INVERT
 - PVC POLY VINYL CHLORIDE
 - SS SANITARY SEWER
 - SSMH SANITARY SEWER MANHOLE

SITE PLAN
SCALE: 1" = 20'-0"

NOTE: ALL PIPING TO CONFORM TO THE NATIONAL PLUMBING CODE.

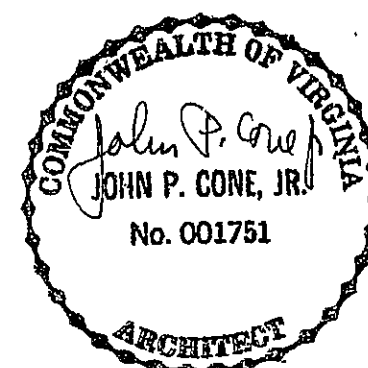

C-5

**SUPER "D" DRUG STORE
PHARMACY**
414 NINTH ST., S.E., ROANOKE, VA.

UTILITIES PLAN
John P. Cone, Jr. Architect
Salem, Virginia
August, 2004