


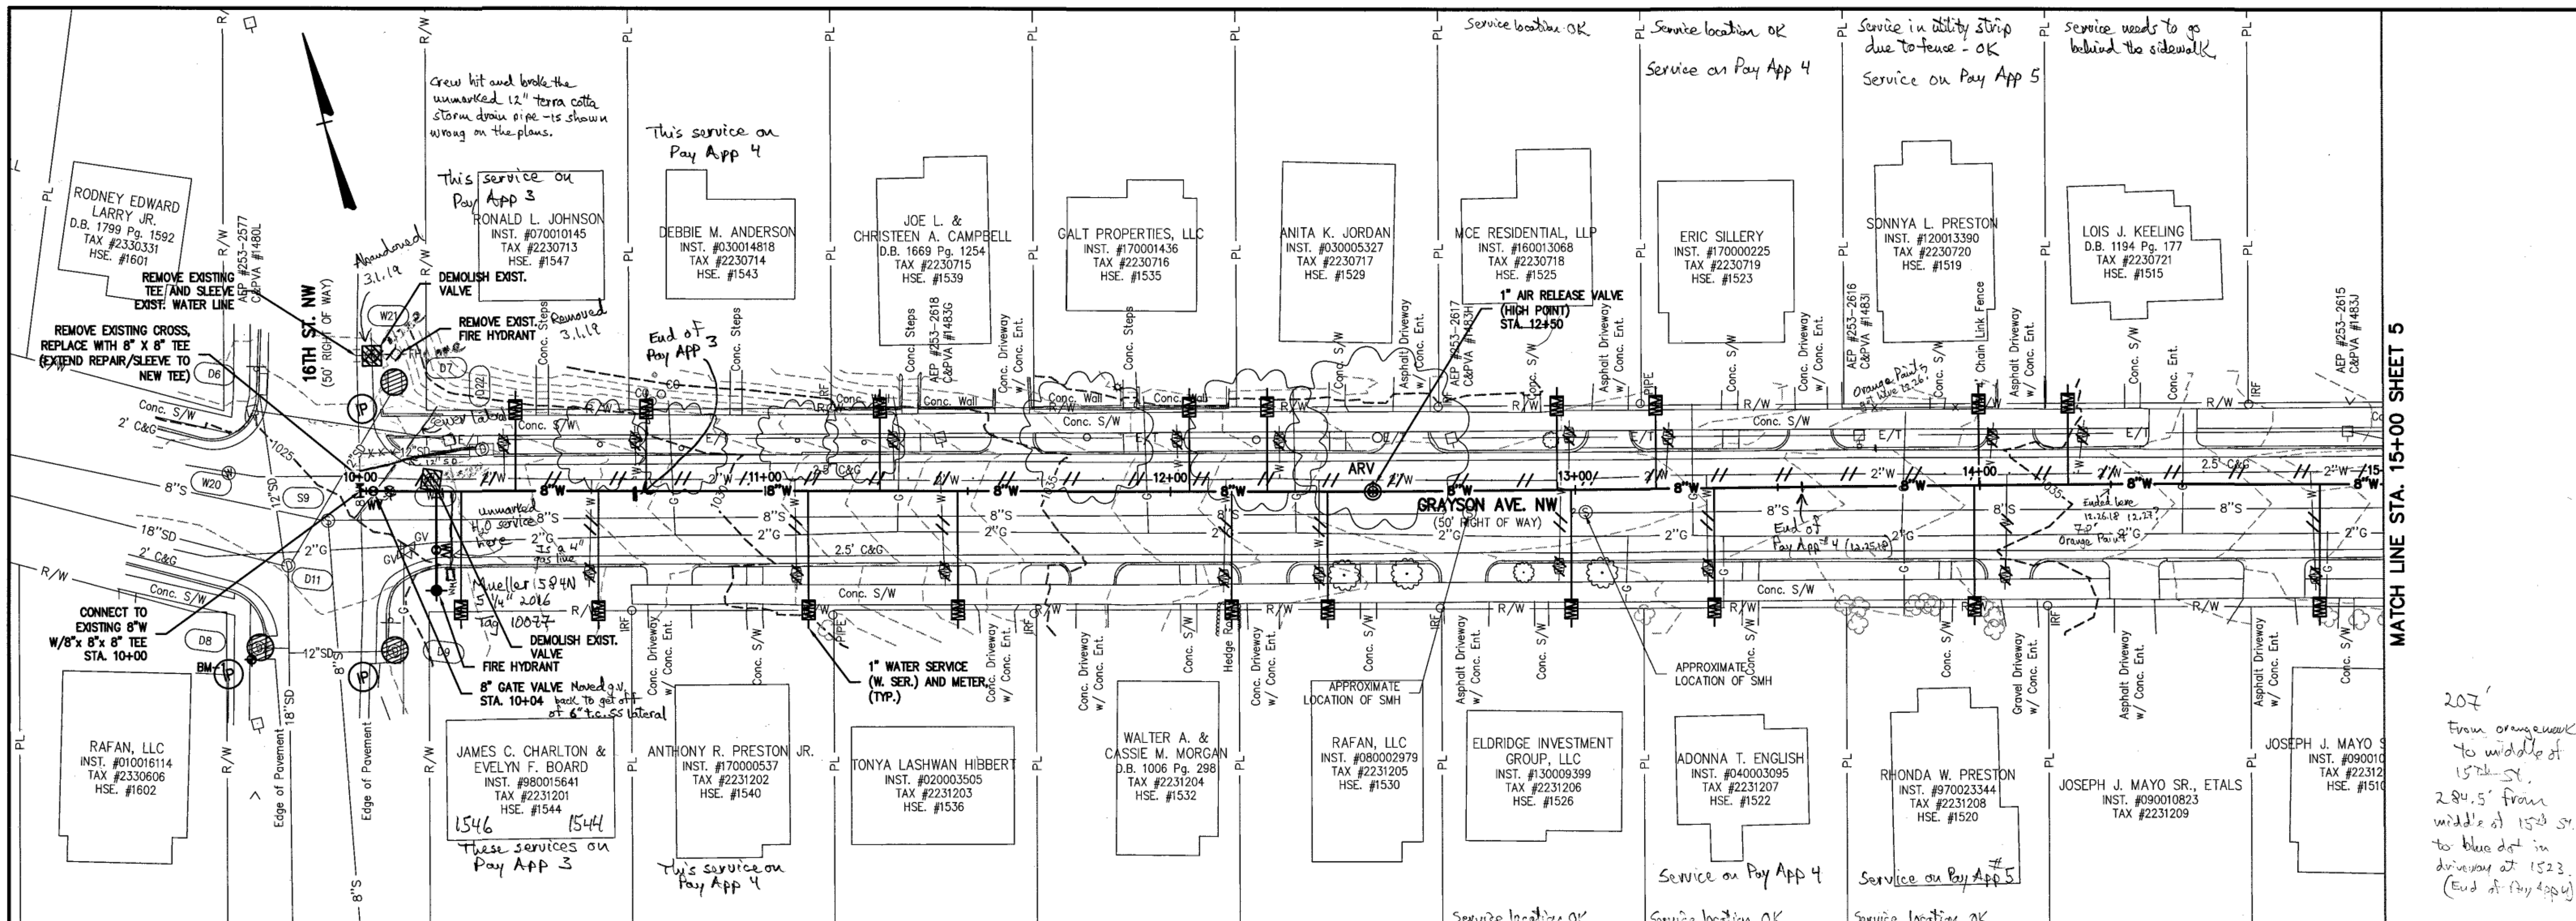

8 INCH WATER MAIN - GRAYSON AVE. PROFILE

Water Info.

Pipe: 8", 6" American DIP, CL 350


Service Line: 1" Endot HOPE, SDR 9

Valves:

Kennedy 8", CCW ON, 27 turns

Mueller 8", CCW ON, 27 turns

Mueller 6", CCW ON, 21 turns

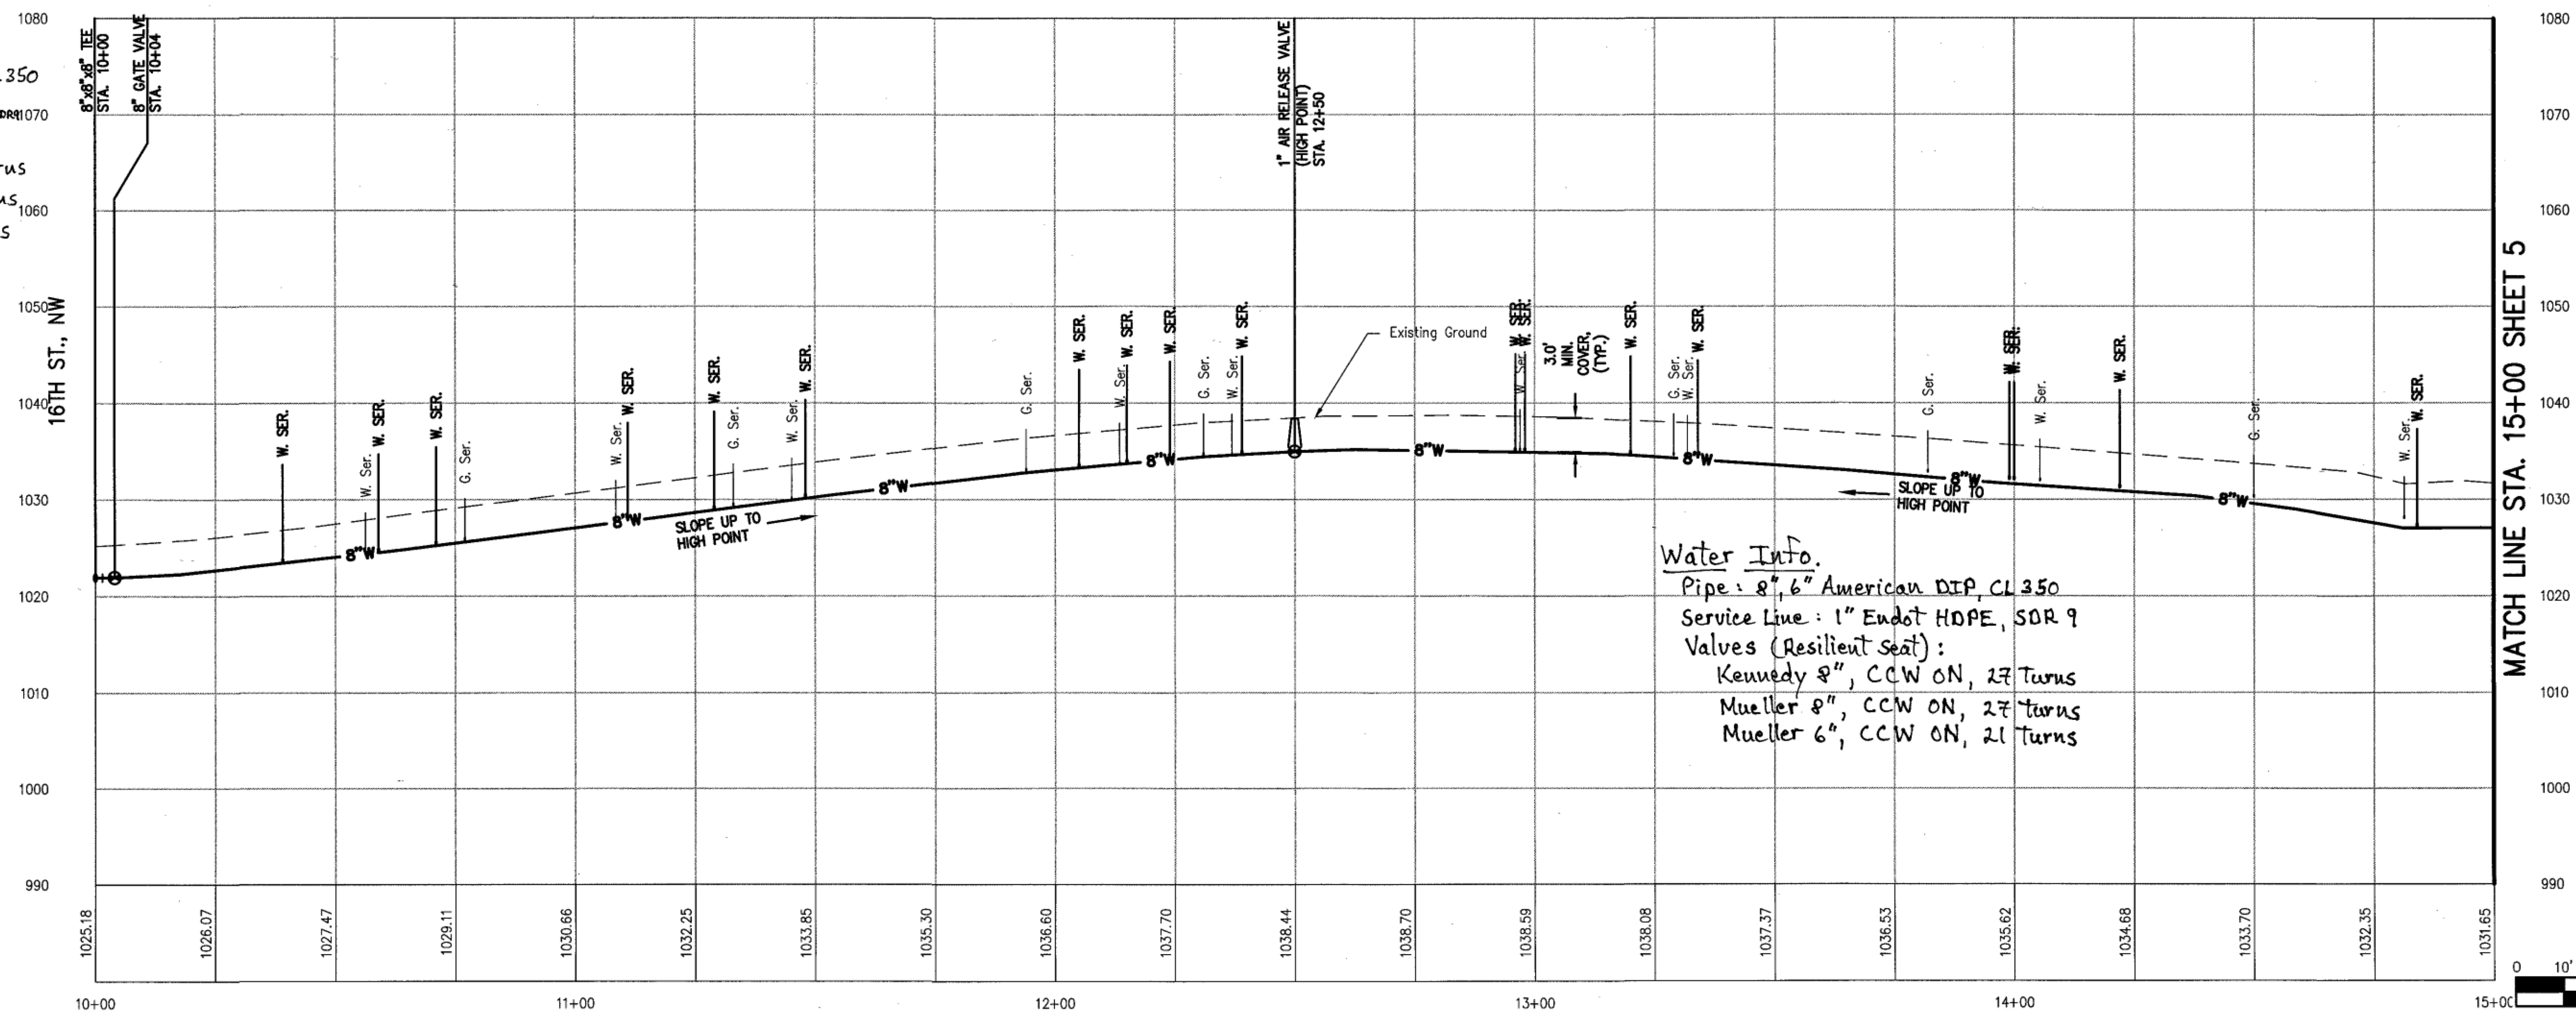

Water Info.

Pipe: 8", 6" American DIP, CL 350


Service Line: 1" Endot HOPE, SDR 9

Valves (Resilient Seat):

Kennedy 8", CCW ON, 27 turns

Mueller 8", CCW ON, 27 turns

Mueller 6", CCW ON, 21 turns

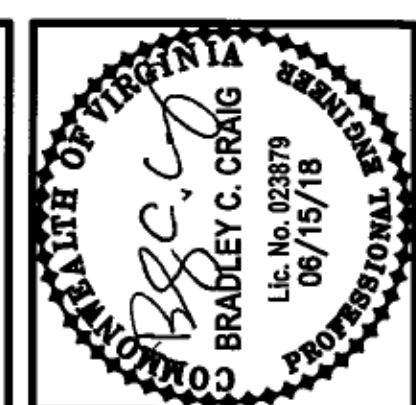

Date	
Revisions	

Issue Date:	JUNE 15, 2018
Drawn By:	DBL/ARB
Designed By:	DBL
Checked By:	BCC
Date:	06/15/18

Mattern & Craig
ENGINEERS/SURVEYORS
701 FIRST STREET, S.W.
ROANOKE, VIRGINIA 24016
(540) 345-8342
FAX (540) 345-7891



STRACUSE AVENUE
WATERLINE REPLACEMENT
PLAN AND PROFILE - 8" WATERLINE
WESTERN VIRGINIA WATER AUTHORITY

Vertical Scale:	1" = 10'
Horizontal Scale:	1" = 20'
Commission Number:	3813
Sheet No.:	4