

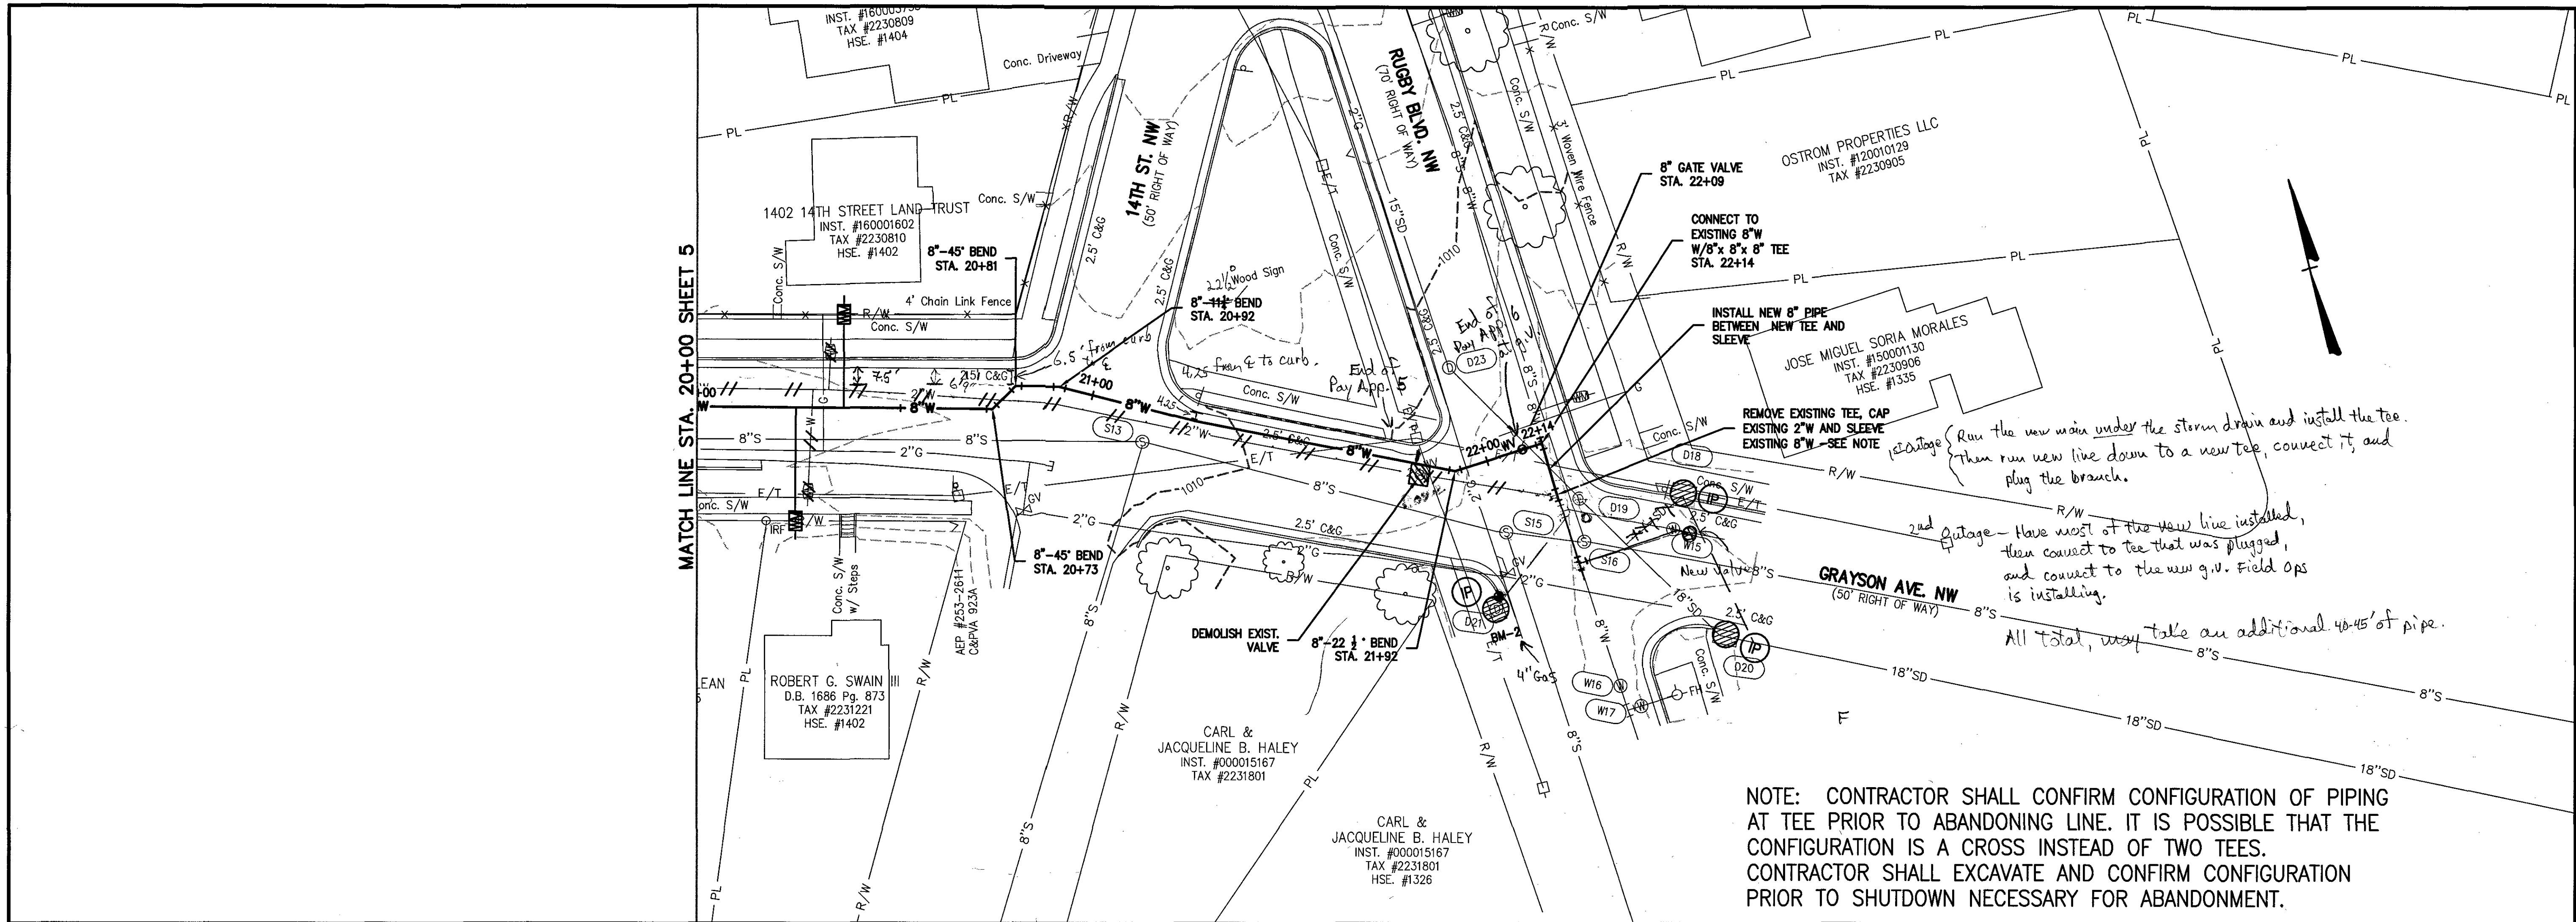
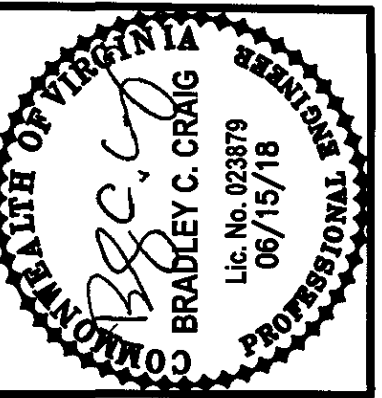


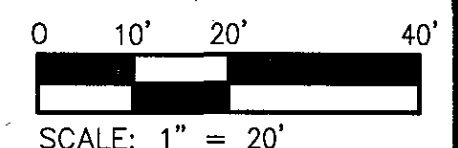

8 INCH WATER MAIN – GRAYSON AVE. PROFILE

Found an 8" cross

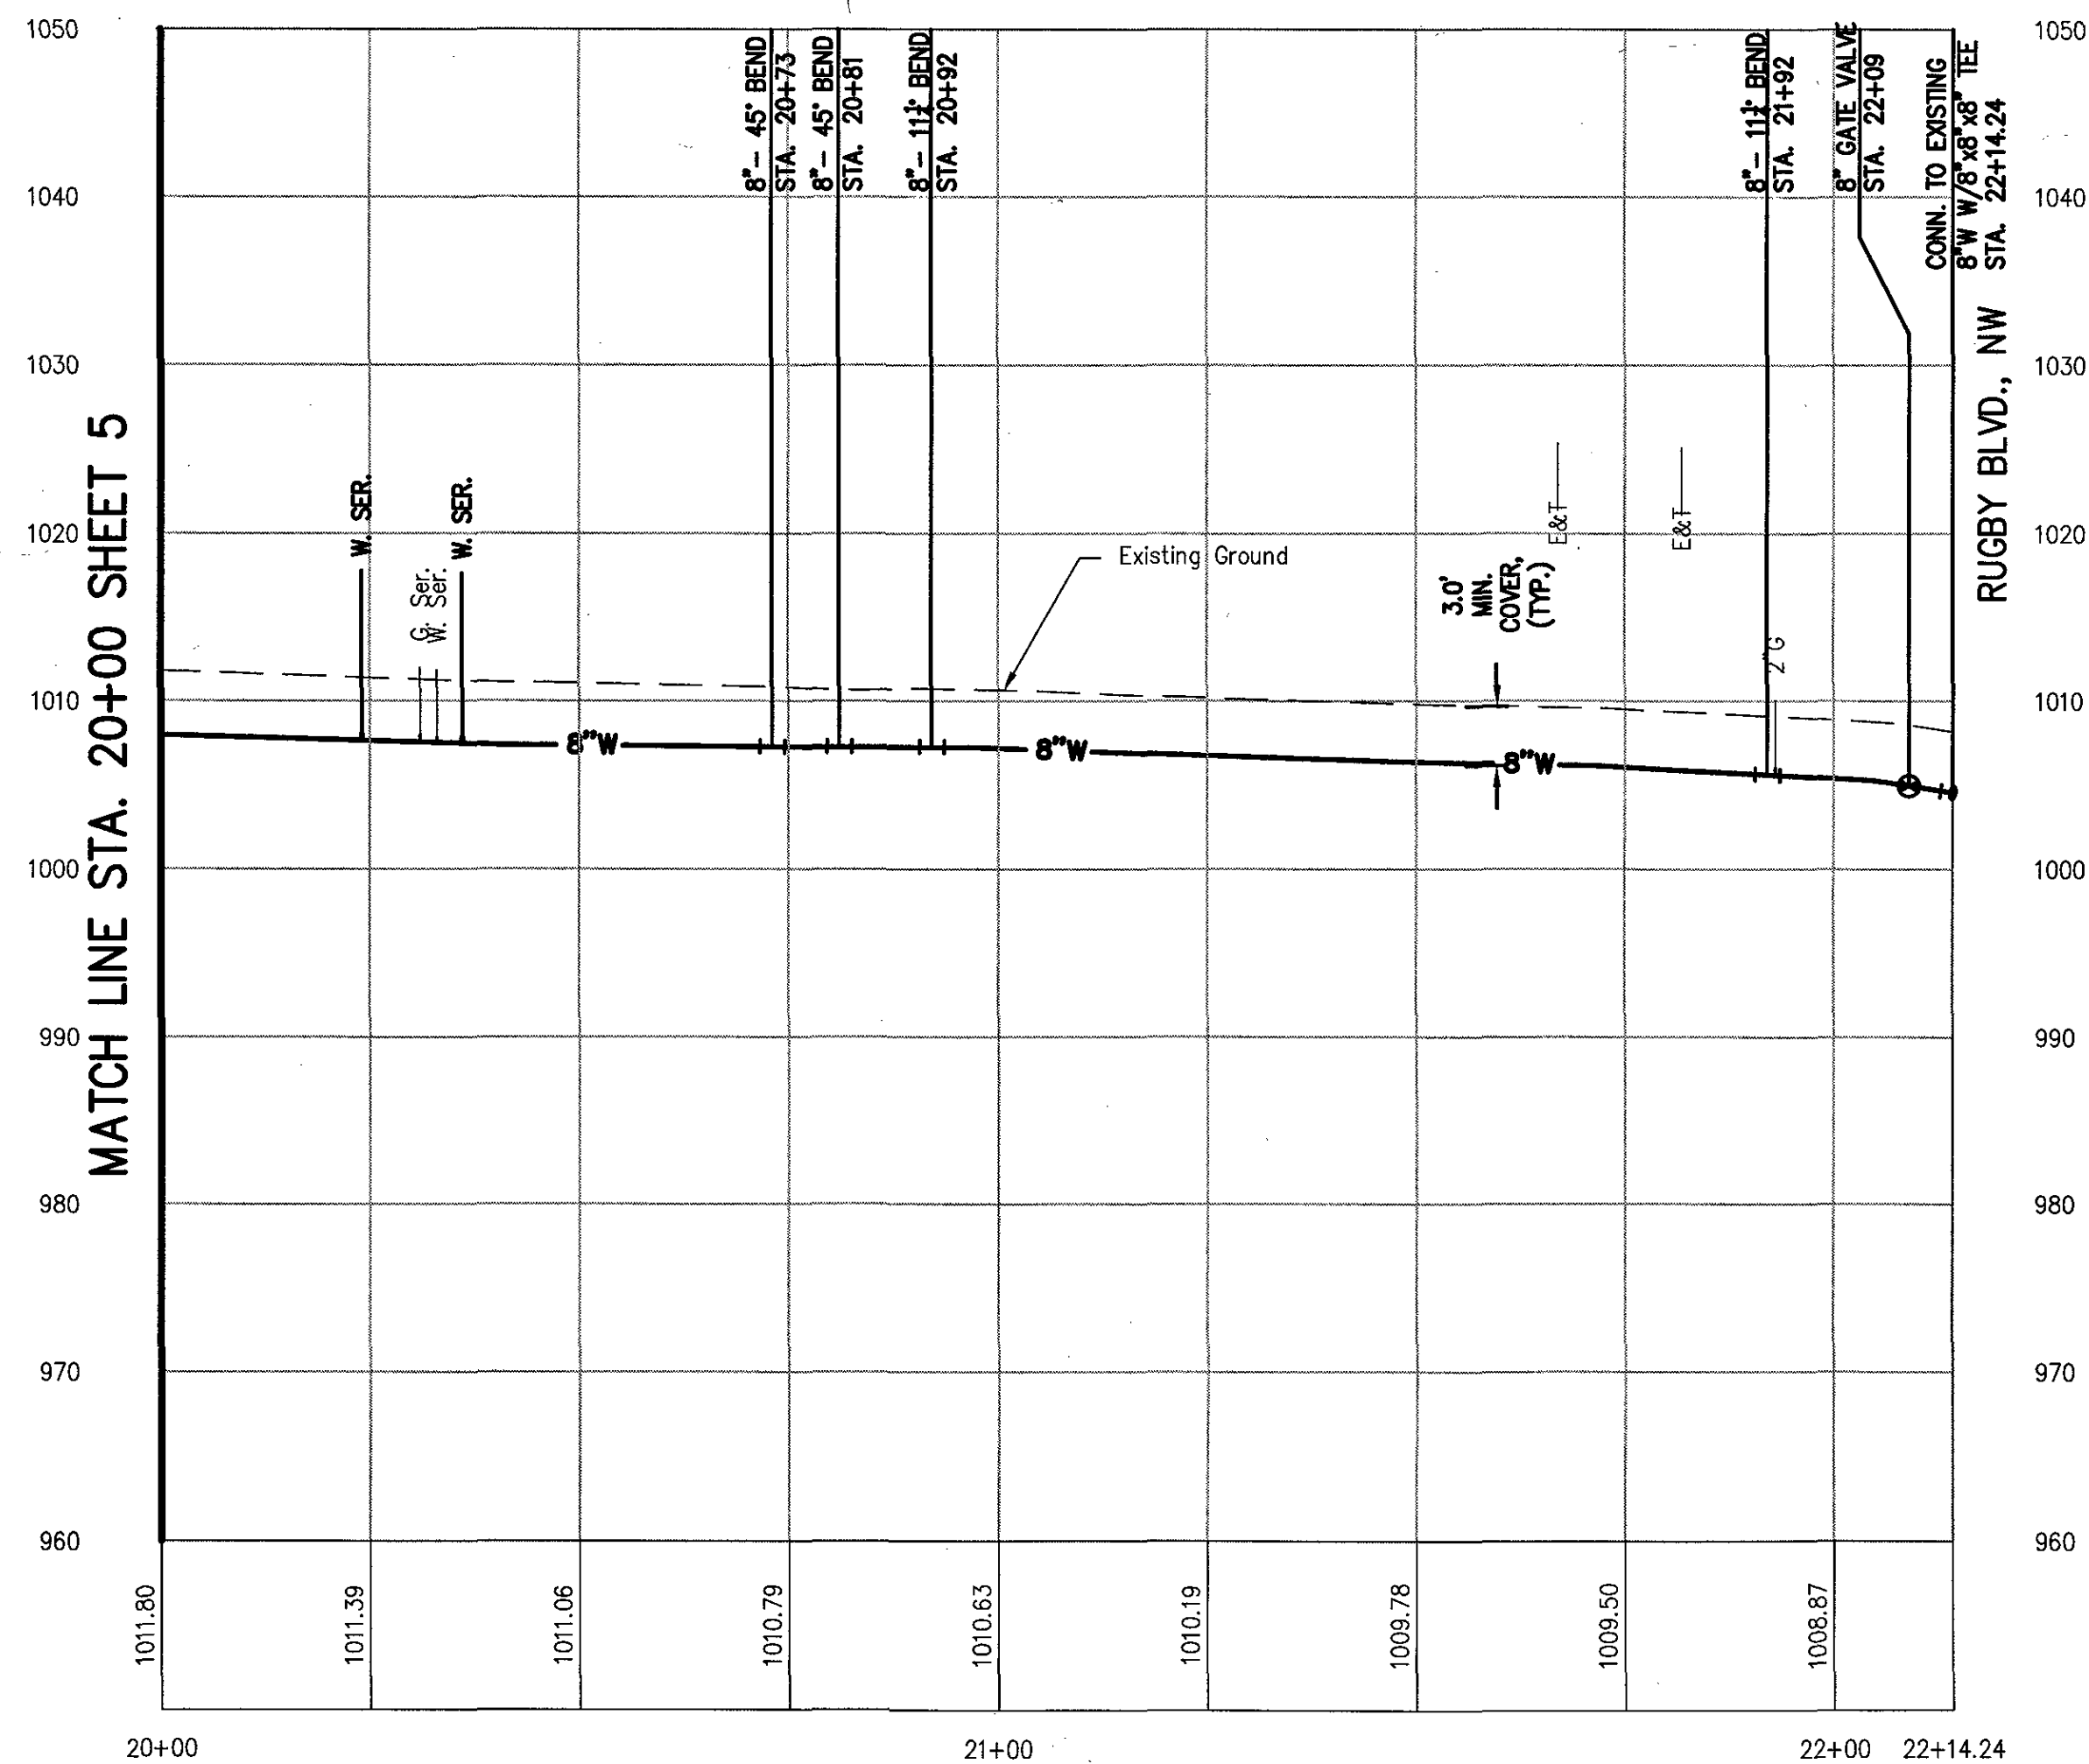

Date	
Revisions	

Issue Date:	JUNE 15, 2018
Drawn By:	DBL/ARB
Designed By:	DBL
Checked By:	BOC
Date:	06/15/18

Mattern & Craig
ENGINEERS-SURVEYORS
701 FIRST STREET, S.W.
ROANOKE, VIRGINIA 24016
PHONE (540) 345-5342
FAX (540) 345-7691

SYRACUSE AVENUE
WATERLINE REPLACEMENT
PLAN AND PROFILE – 8" WATERLINE
WESTERN VIRGINIA WATER AUTHORITY

Vertical Scale:
1" = 10'

Horizontal Scale:
1" = 20'

Commission Number:
3813

Sheet No.:
6