

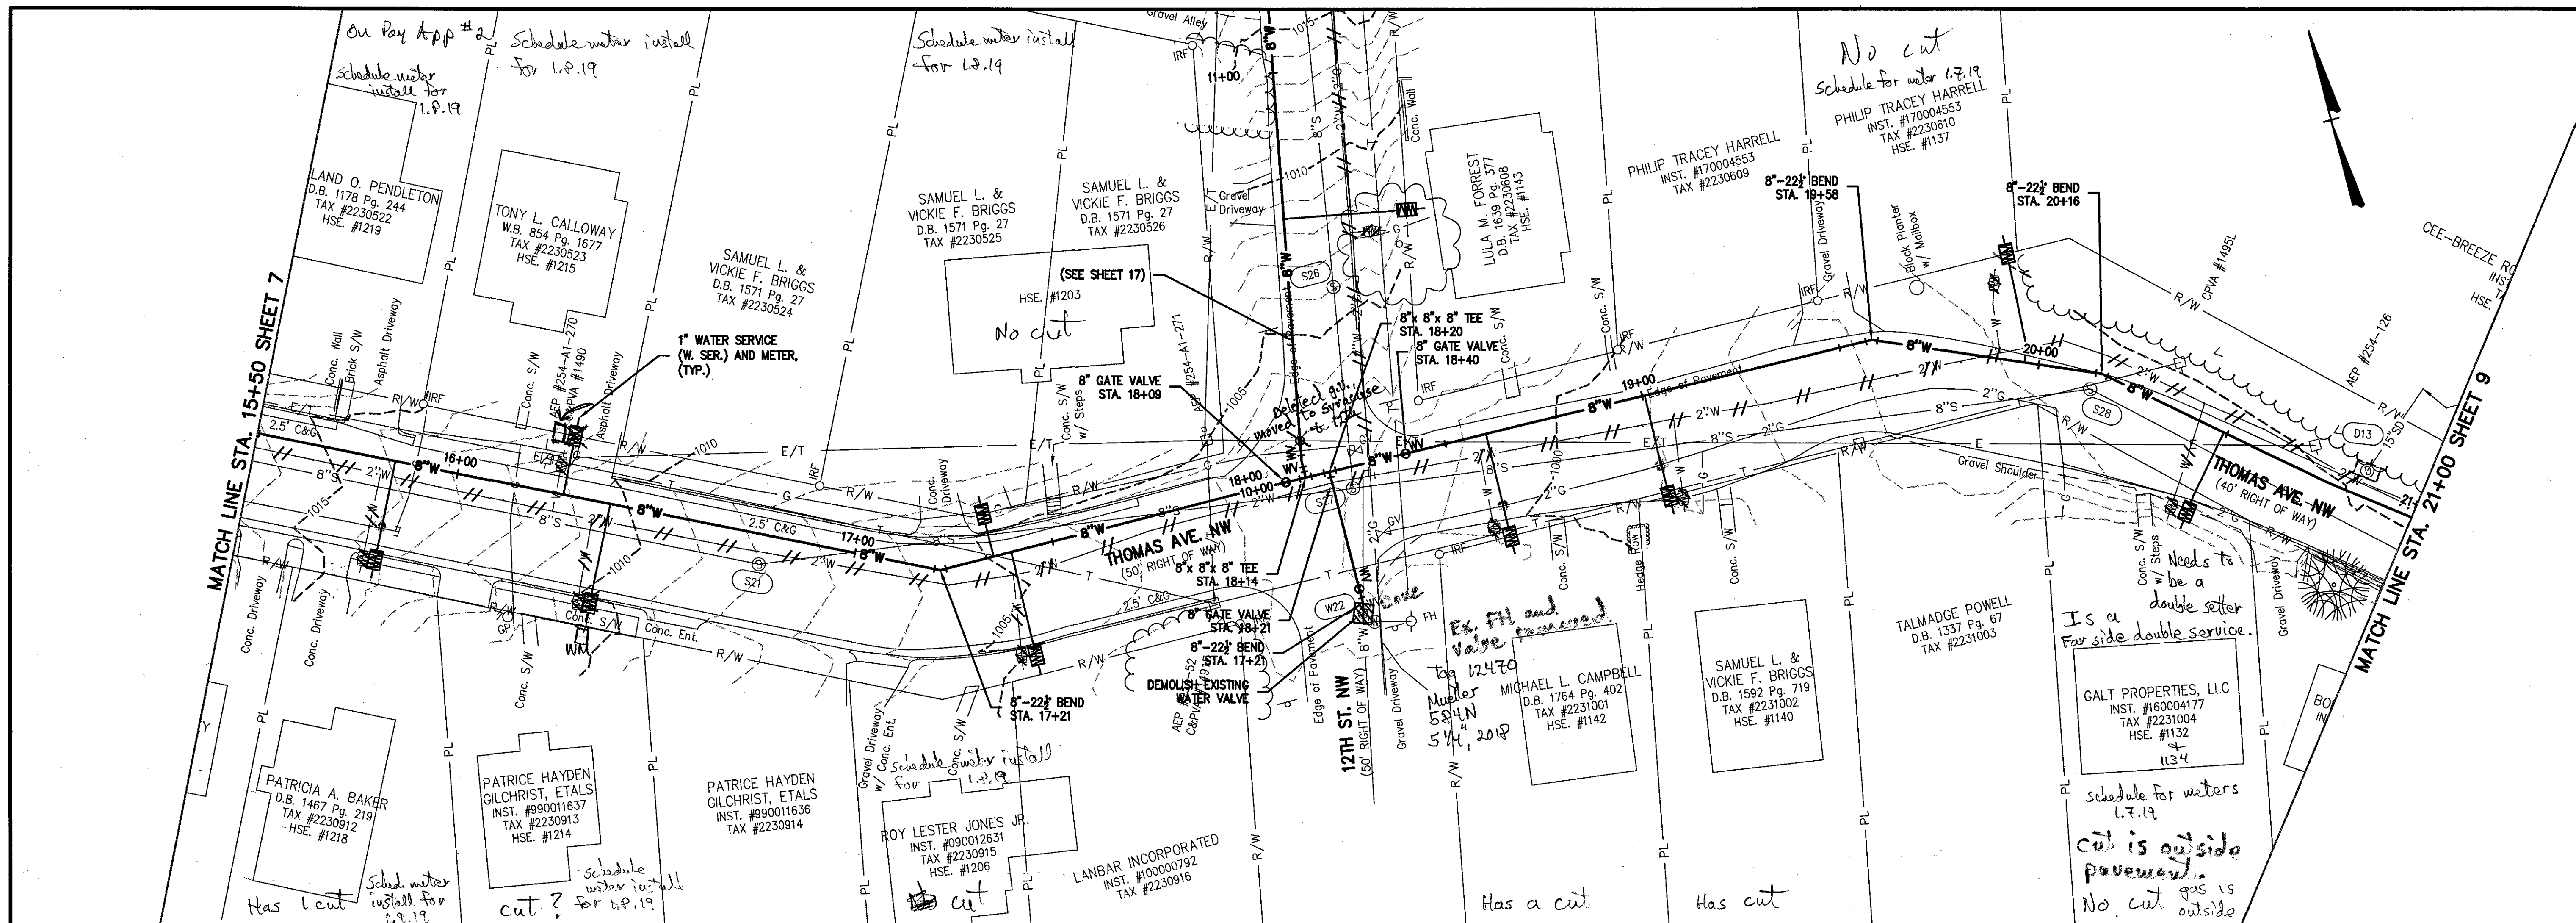


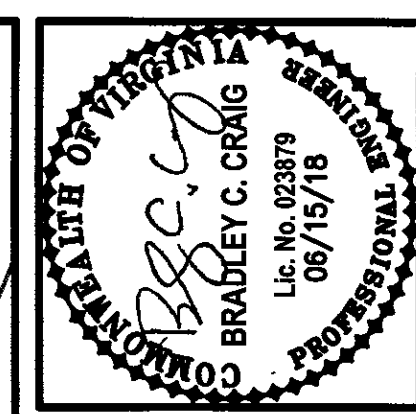

8 INCH WATER MAIN – THOMAS AVE. PROFILE

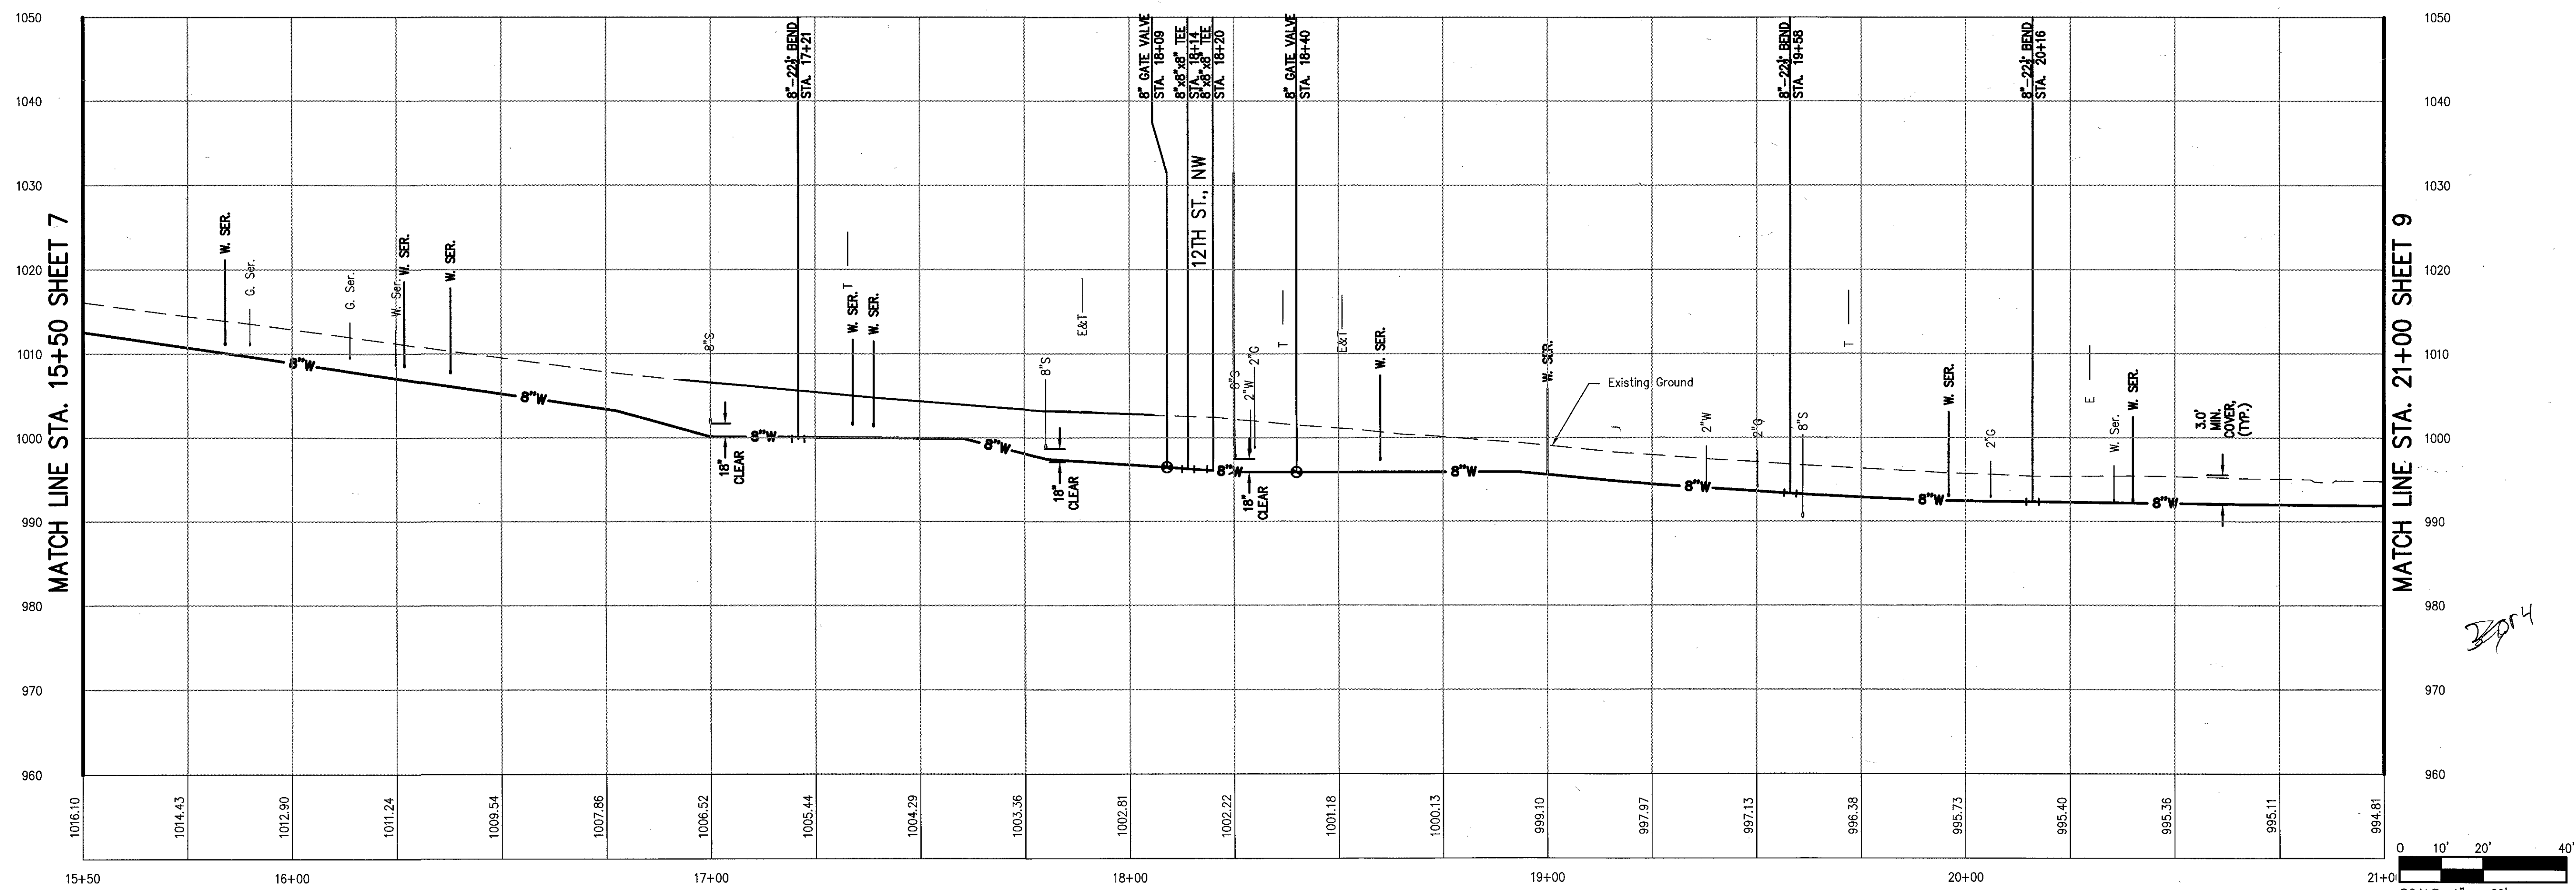

Revisions	Date

Issue Date:	JUNE 15, 2018
Drawn By:	
Designed By:	
Checked By:	
Date:	06/15/18

Mattern & Craig
ENGINEERS/SURVEYORS
701 FIRST STREET, S.W.
ROANOKE, VIRGINIA 24016
(540) 345-3342
FAX (540) 345-7651

SYRACUSE AVENUE
WATERLINE REPLACEMENT

PLAN AND PROFILE – 8" WATERLINE

WESTERN VIRGINIA WATER AUTHORITY

Vertical Scale:
1" = 10'

Horizontal Scale:
1" = 20'

Commission Number:
3813

Sheet No.:
8