
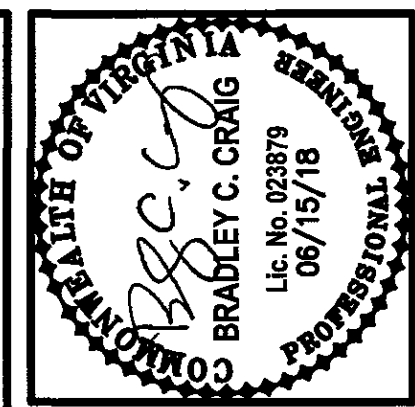
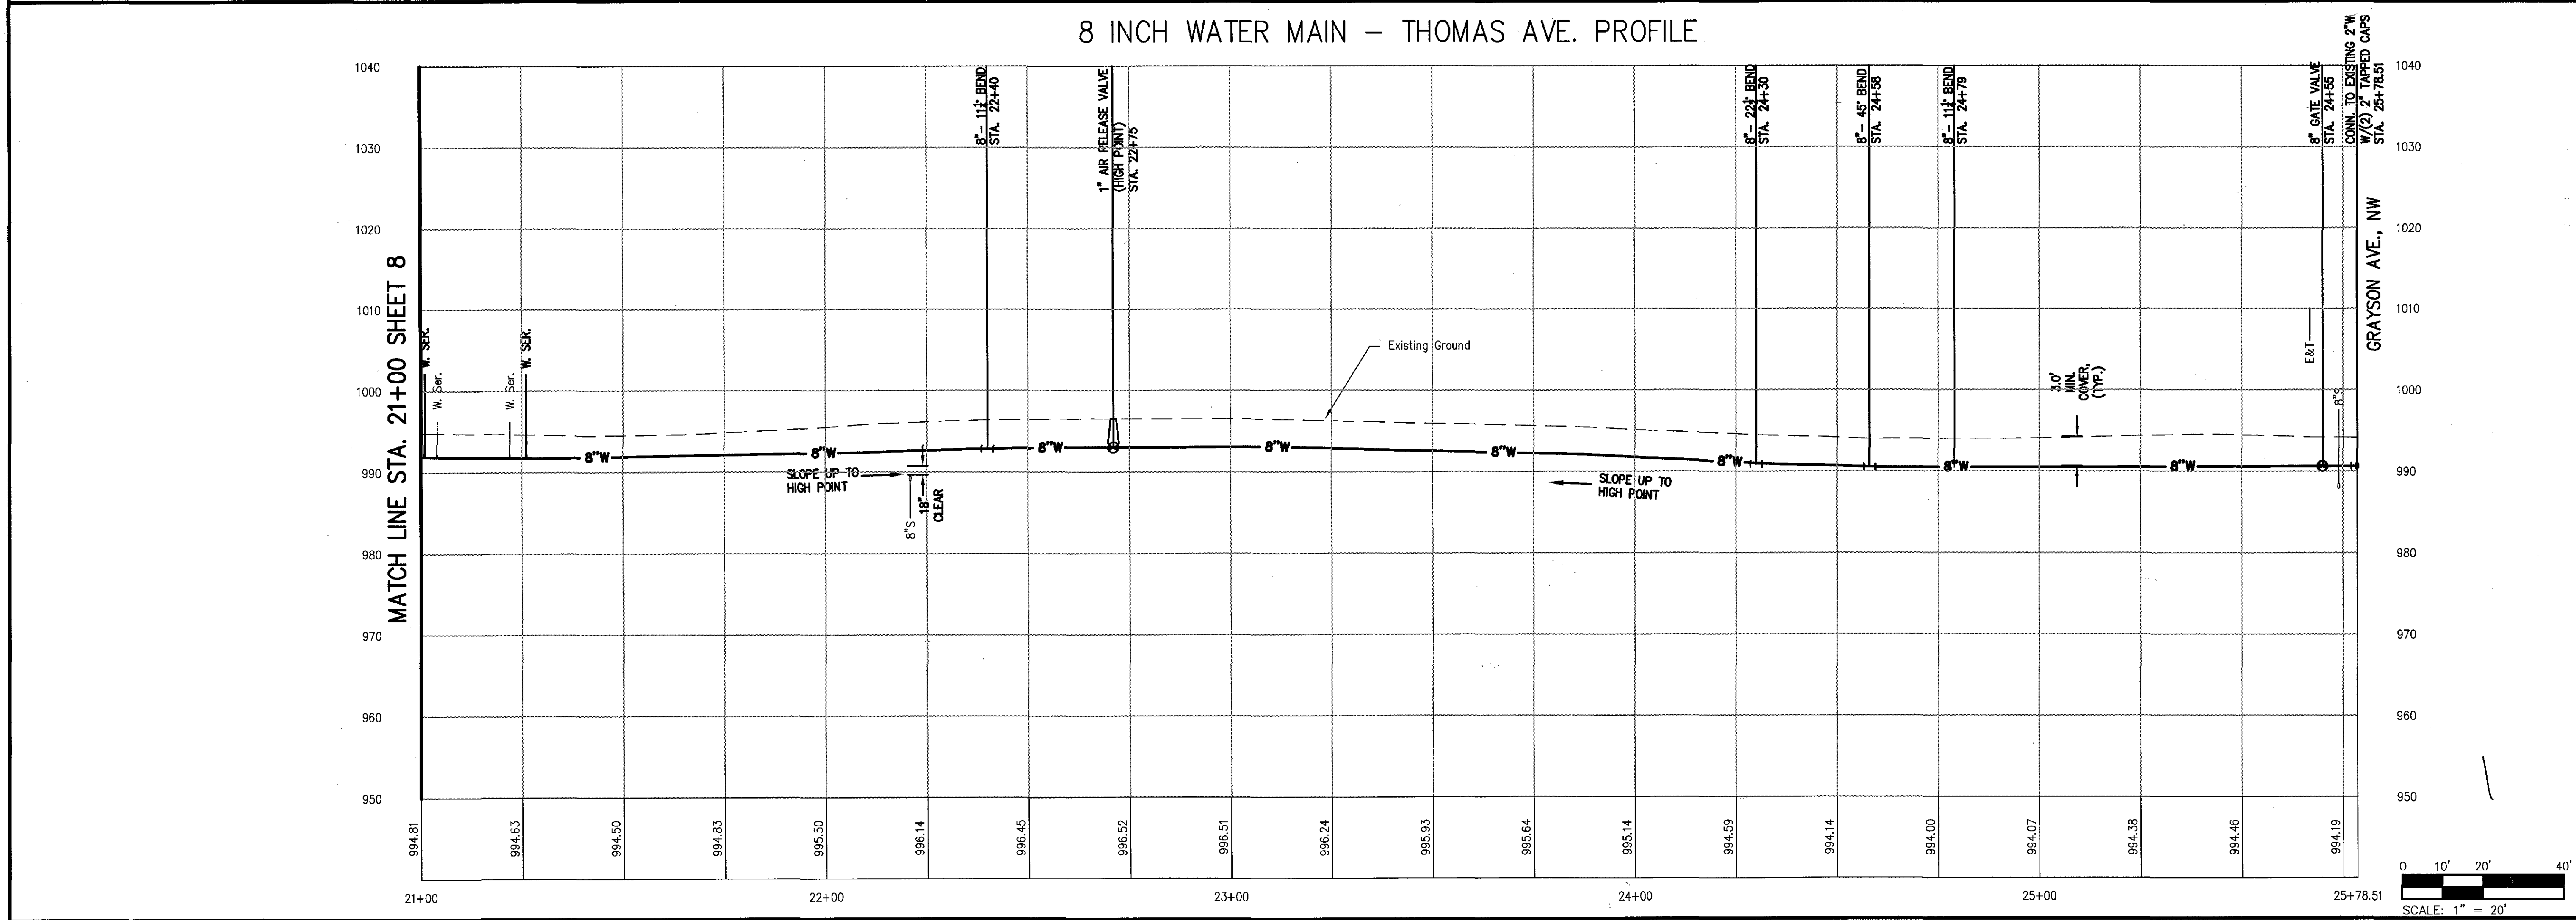


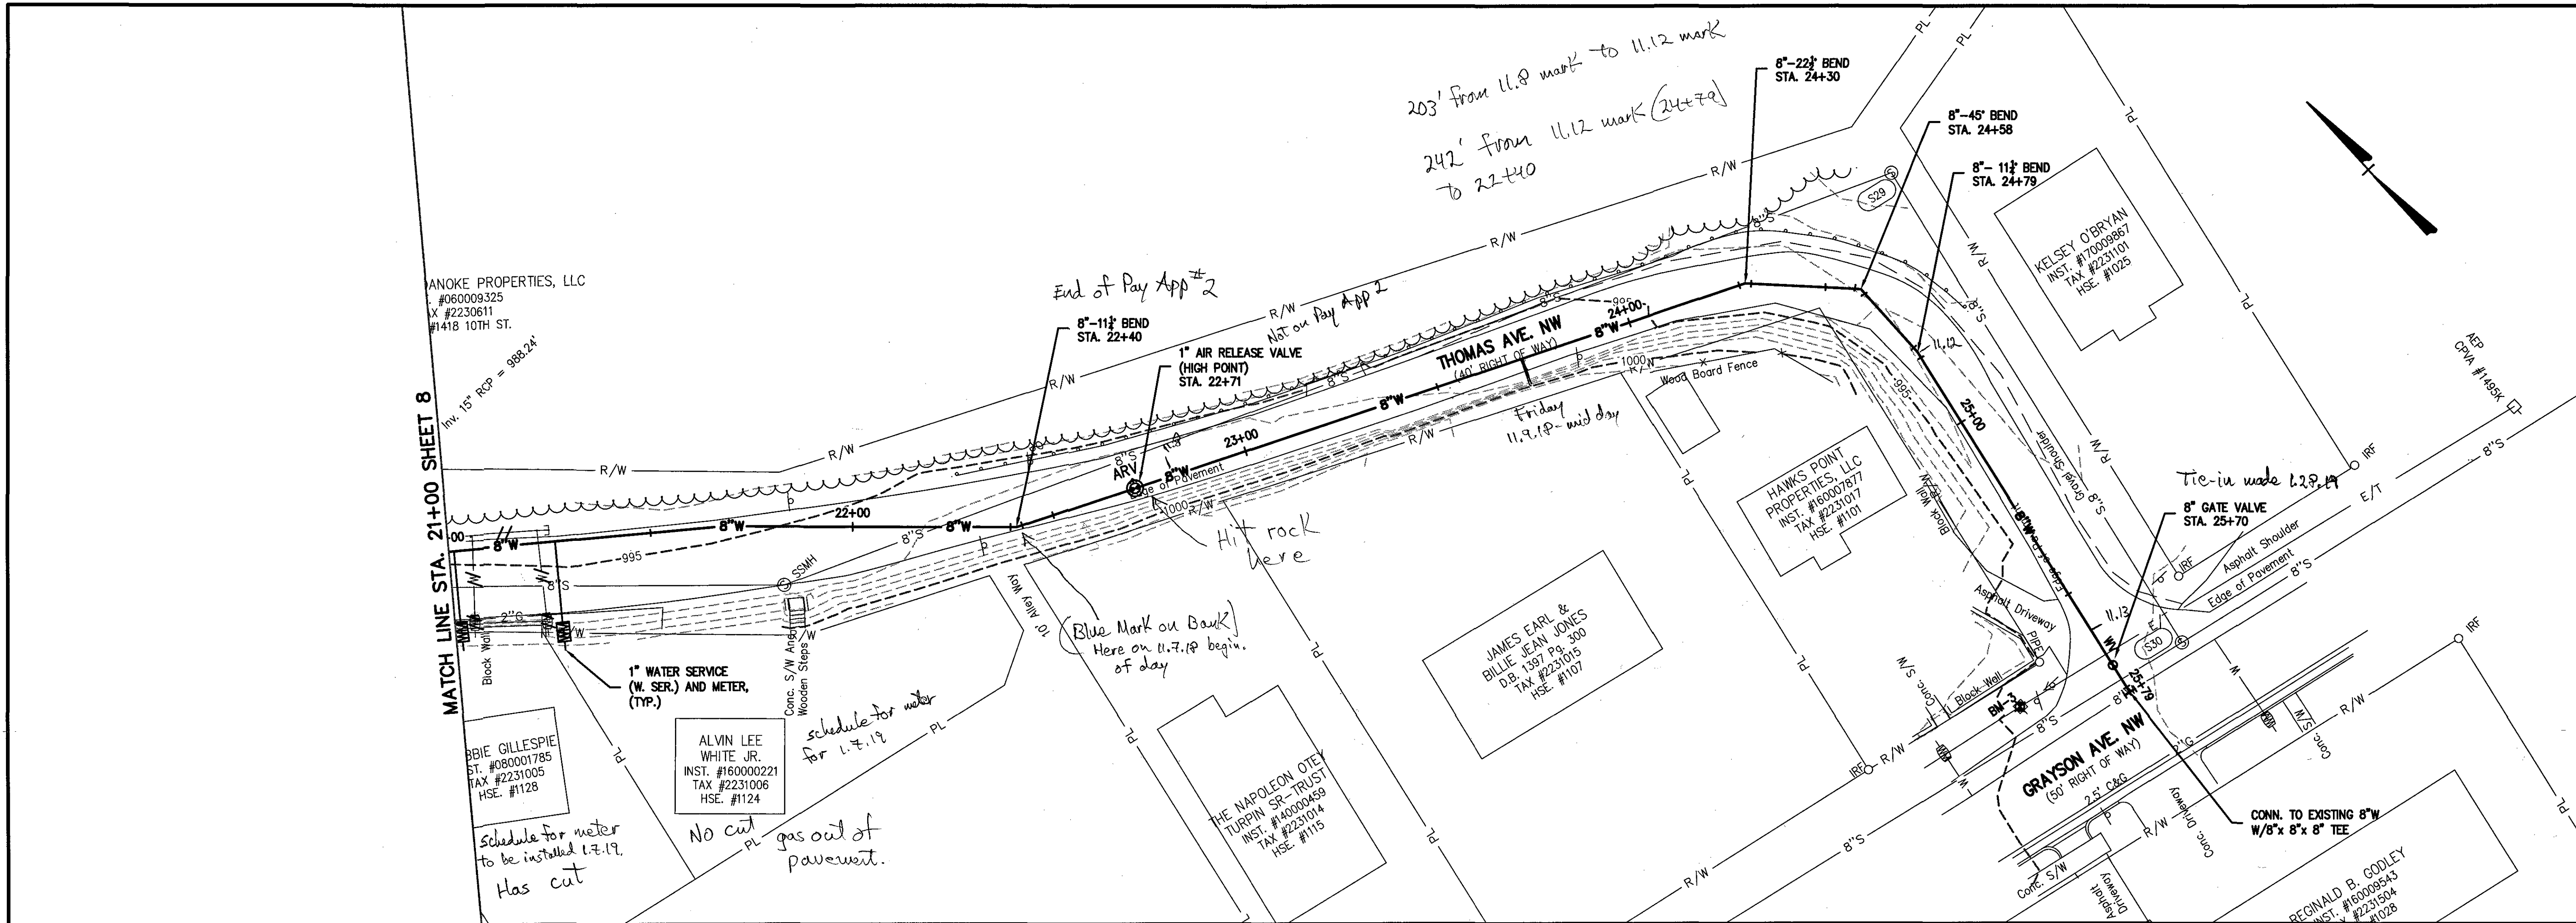

Revisions	Date

Issue Date:	JUNE 15, 2018
Drawn By:	
Designed By:	
Checked By:	
Date:	06/15/18

Mattern & Craig
ENGINEERS-SURVEYORS
701 FIRST STREET, S.W.
ROANOKE, VIRGINIA 24016
(540) 345-9342
FAX (540) 345-7691

SYRACUSE AVENUE
WATERLINE REPLACEMENT

PLAN AND PROFILE - 8" WATERLINE

WESTERN VIRGINIA WATER AUTHORITY

Vertical Scale:	1" = 10'
Horizontal Scale:	1" = 20'
Commission Number:	3813
Sheet No.:	9