

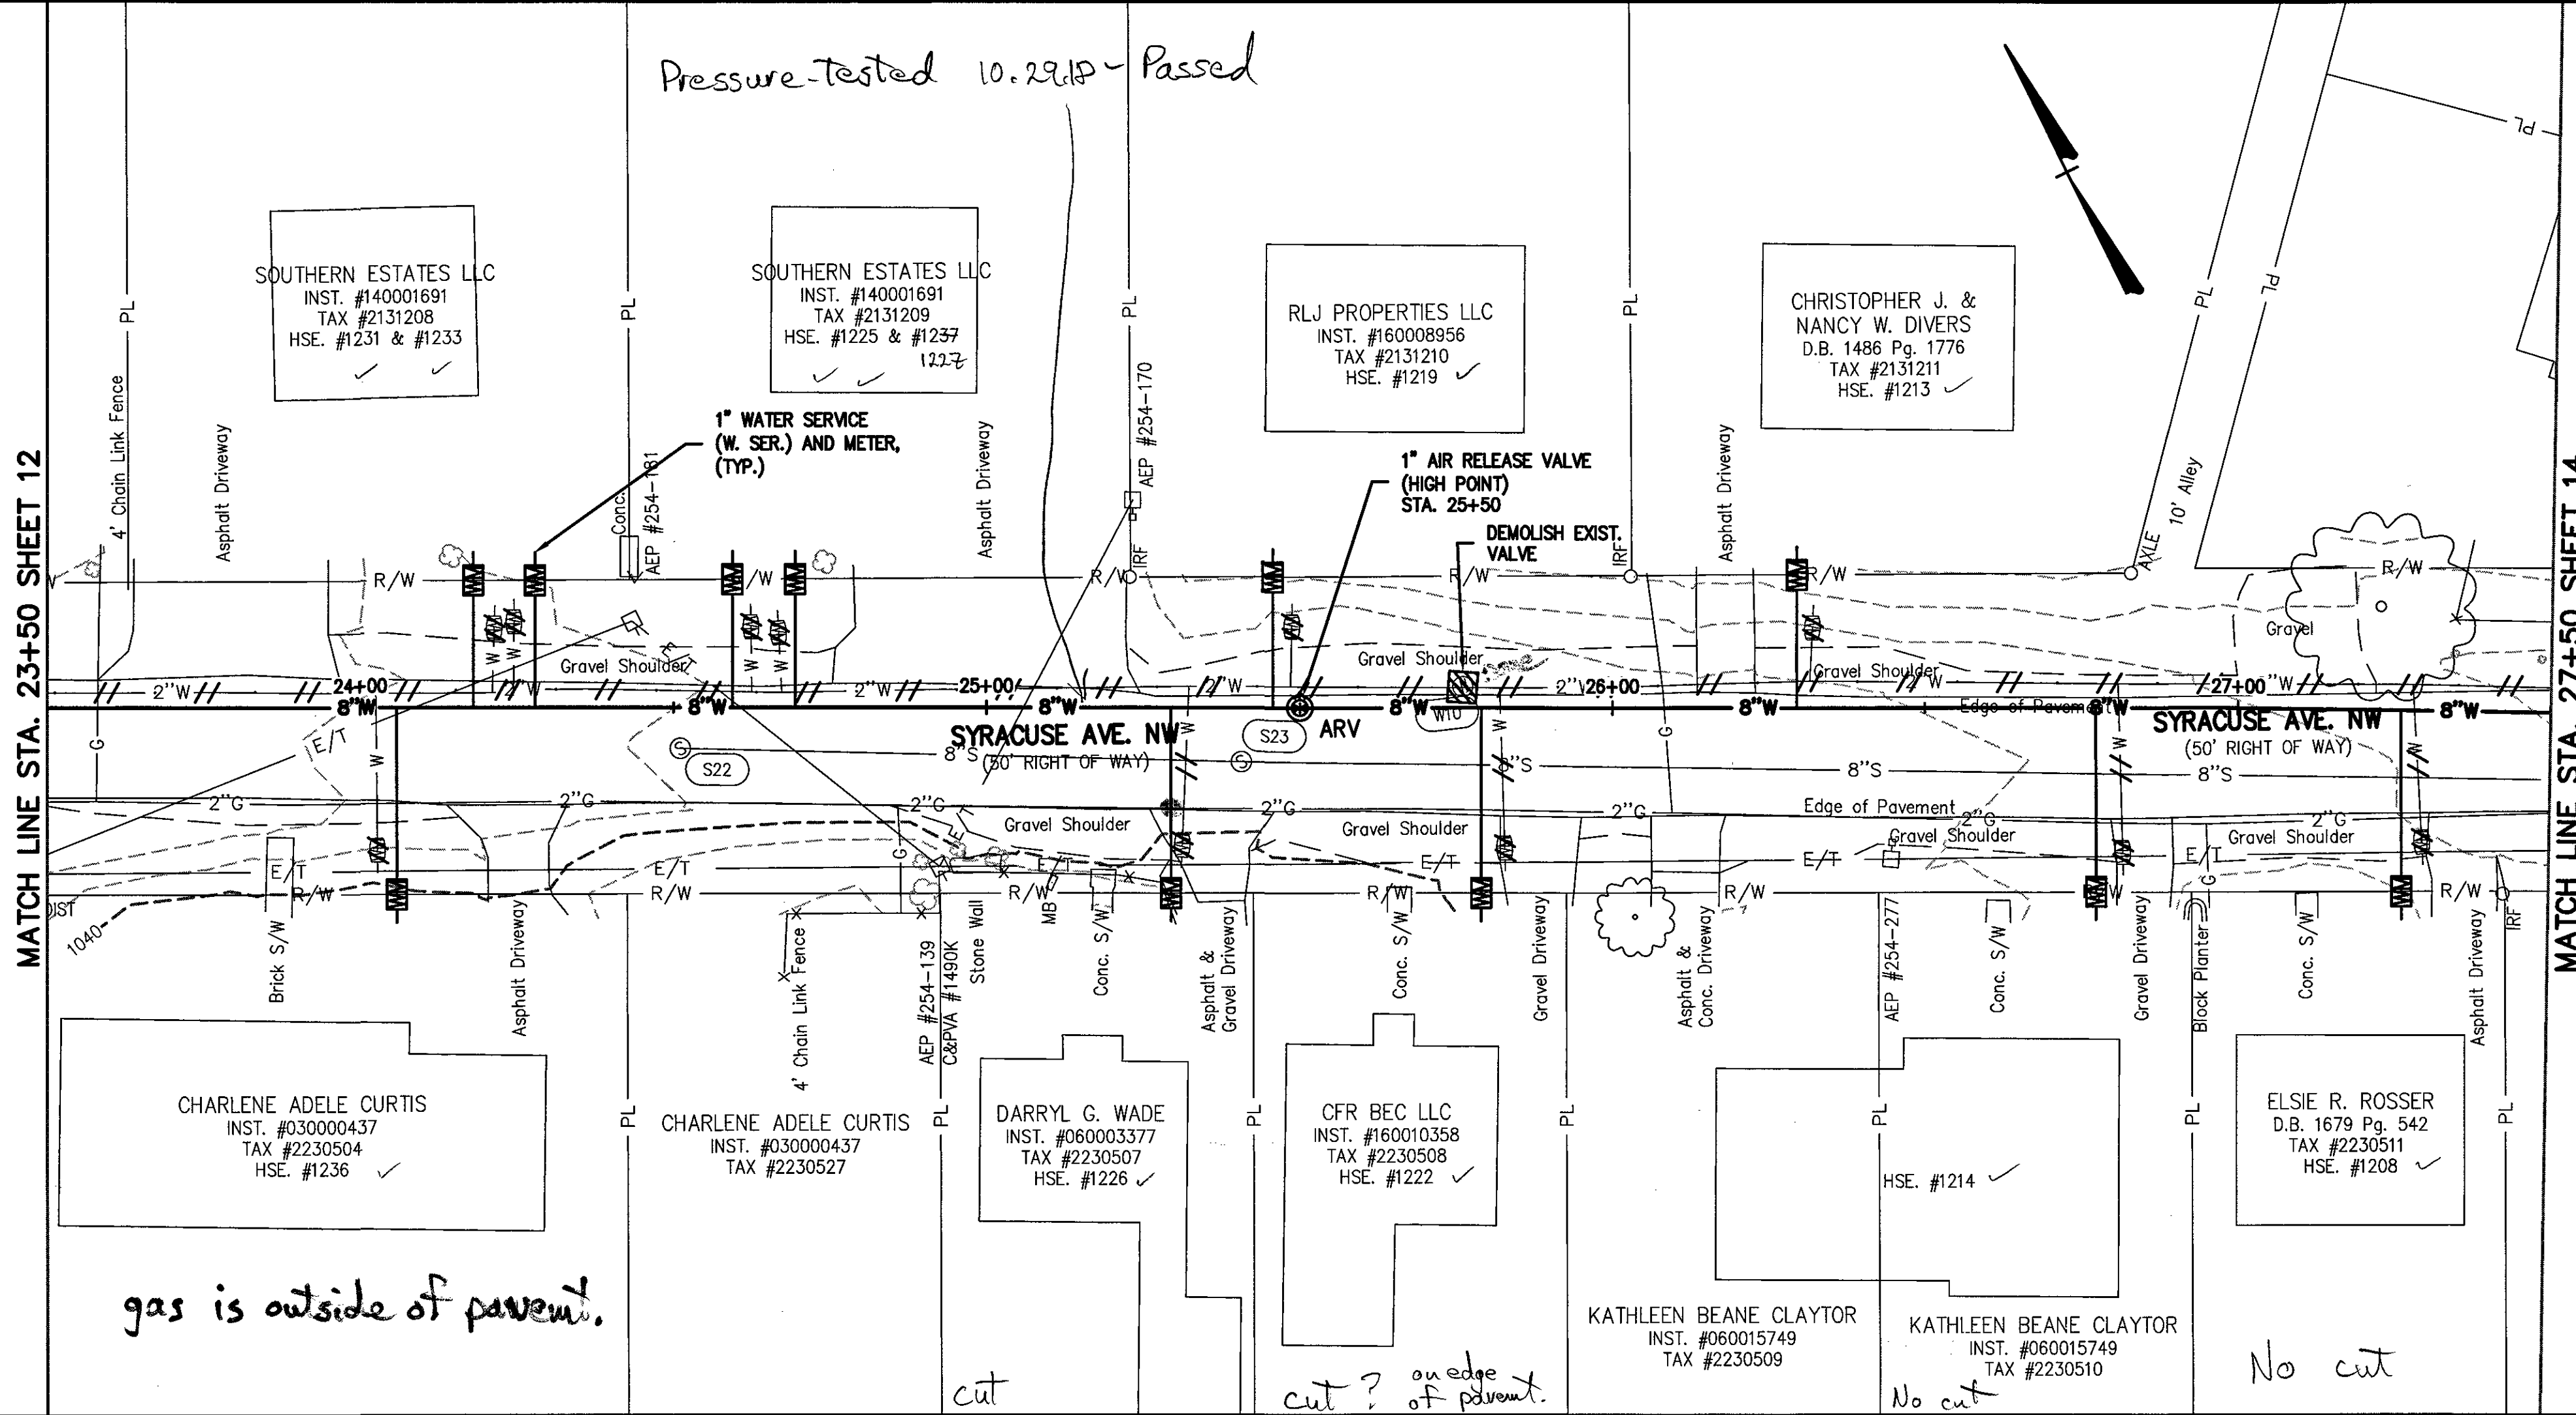


MATCH LINE STA. 23+50 SHEET 12

MATCH LINE STA. 27+50 SHEET 14

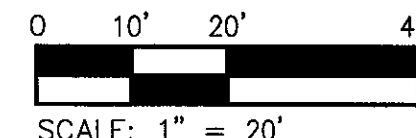

8 INCH WATER MAIN – SYRACUSE AVE. PROFILE

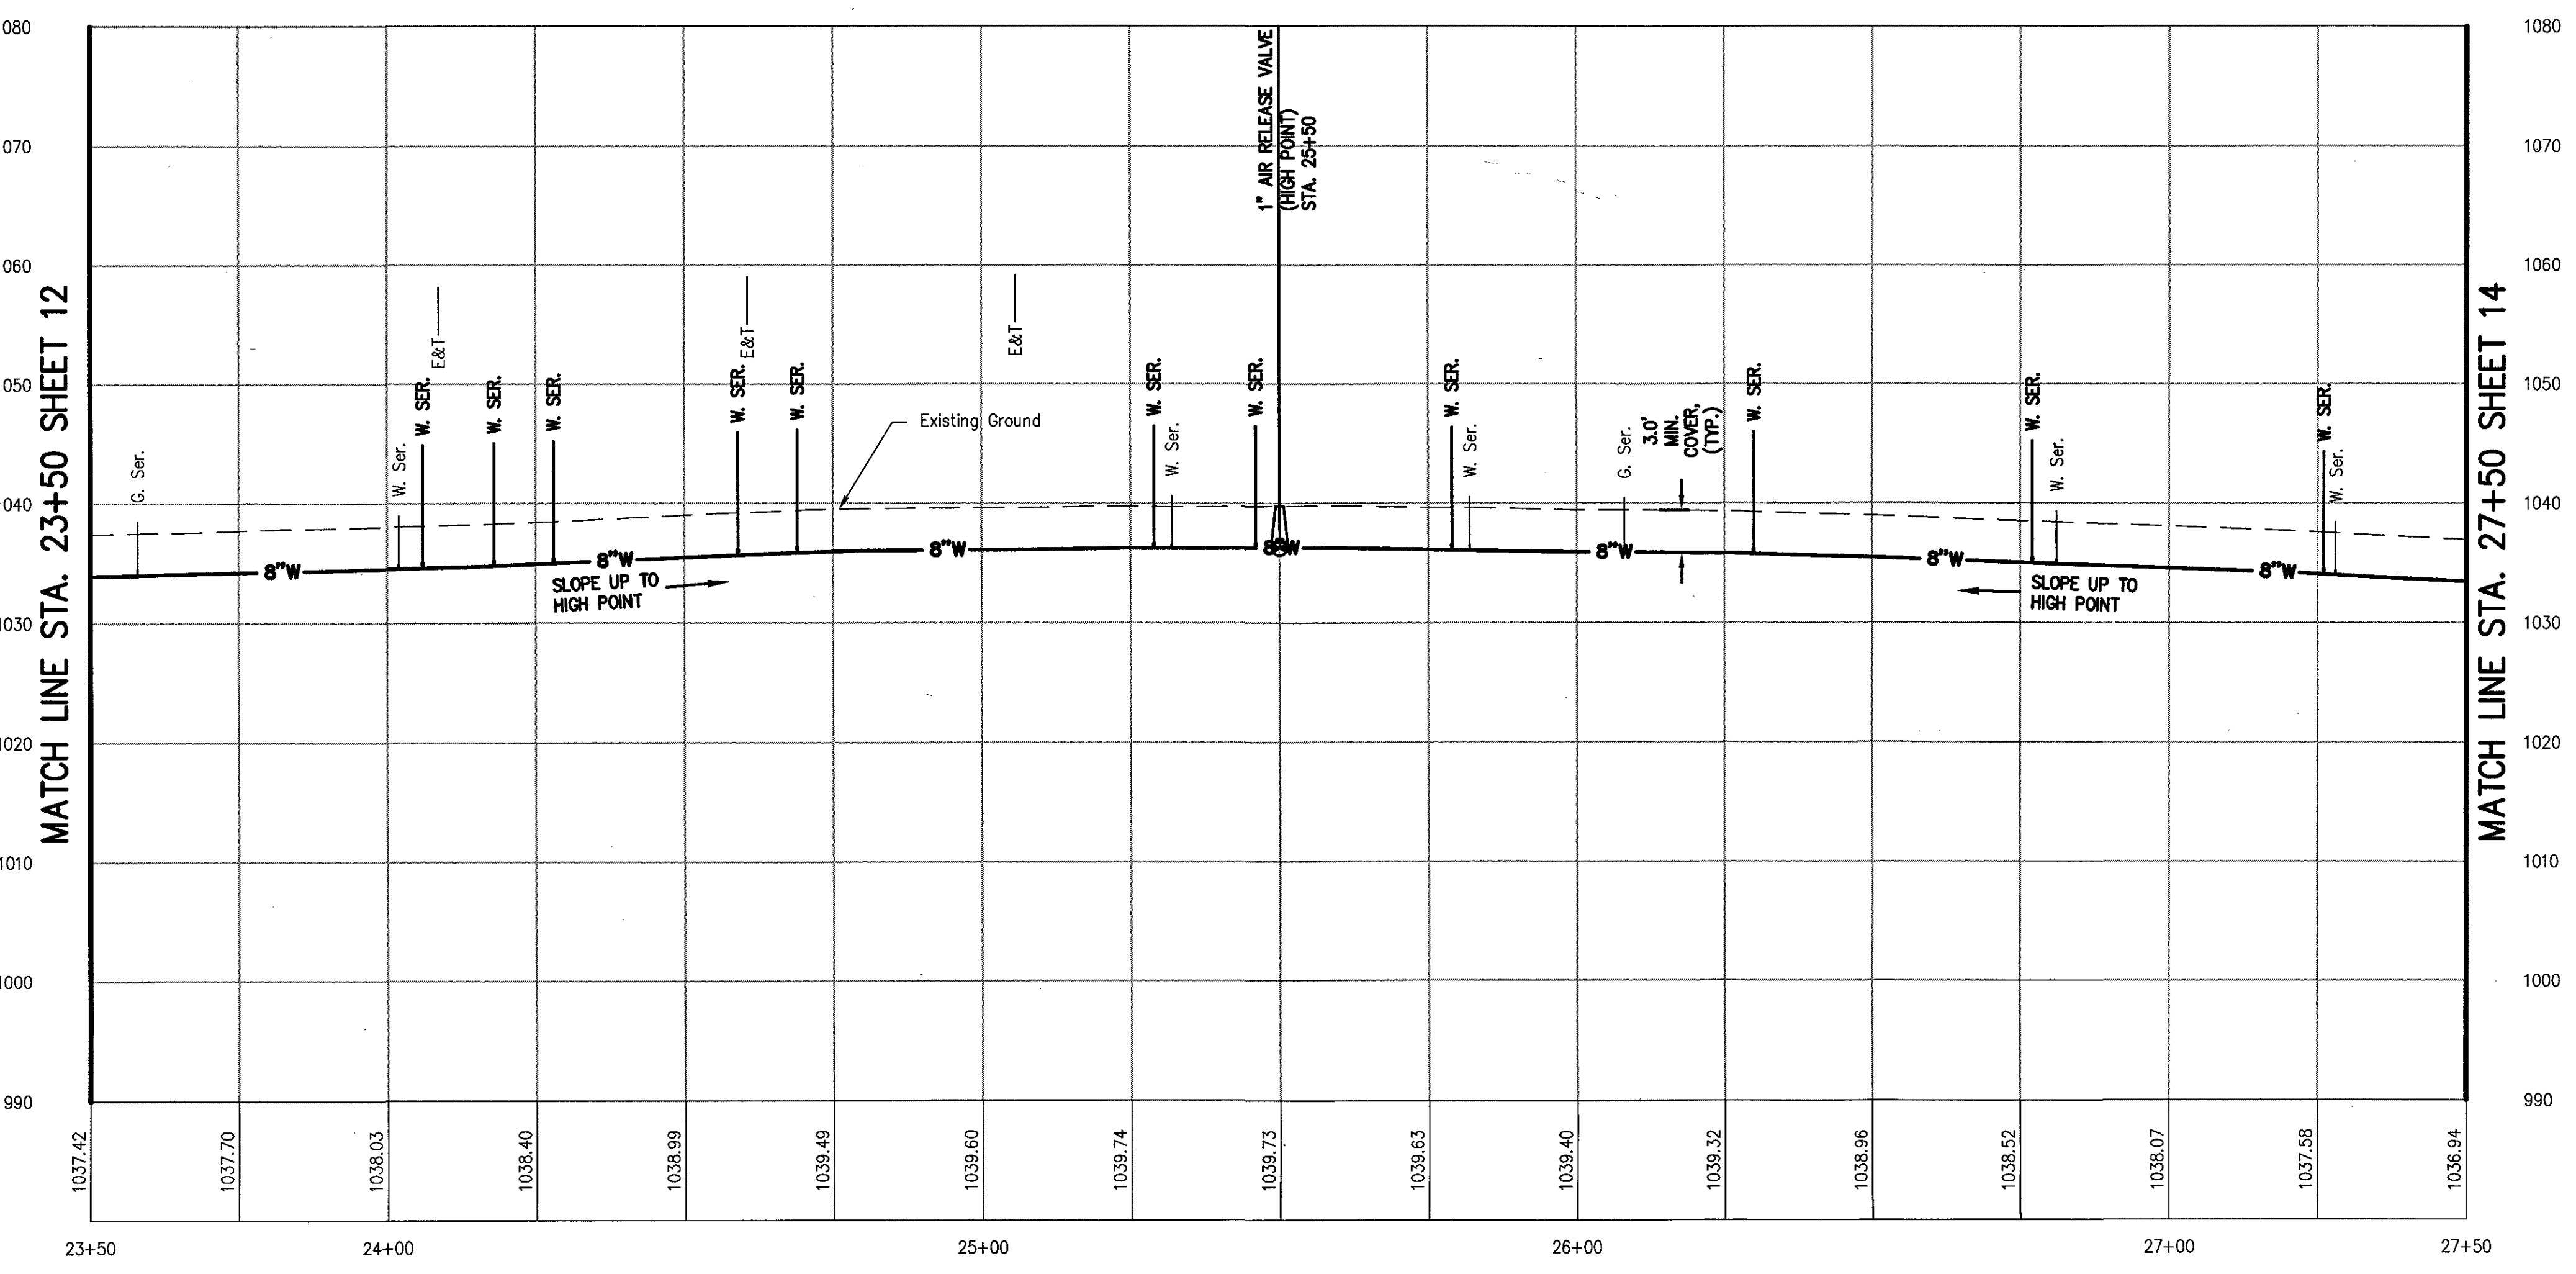

Date	
Revisions	

Issue Date: **JUNE 15, 2018**
Drawn By: DBL/ARB
Designed By: DBL
Checked By: BCC
Date: 06/15/18

Mattern & Craig
ENGINEERS & SURVEYORS
701 FIRST STREET, S.W.
ROANOKE, VIRGINIA 24016
(540) 345-9342
FAX (540) 345-7691

SYRACUSE AVENUE
WATERLINE REPLACEMENT
PLAN AND PROFILE – 8" WATERLINE
WESTERN VIRGINIA WATER AUTHORITY

Vertical Scale:
1" = 10'

Horizontal Scale:
1" = 20'

Commission Number:
3813

Sheet No.:
13