




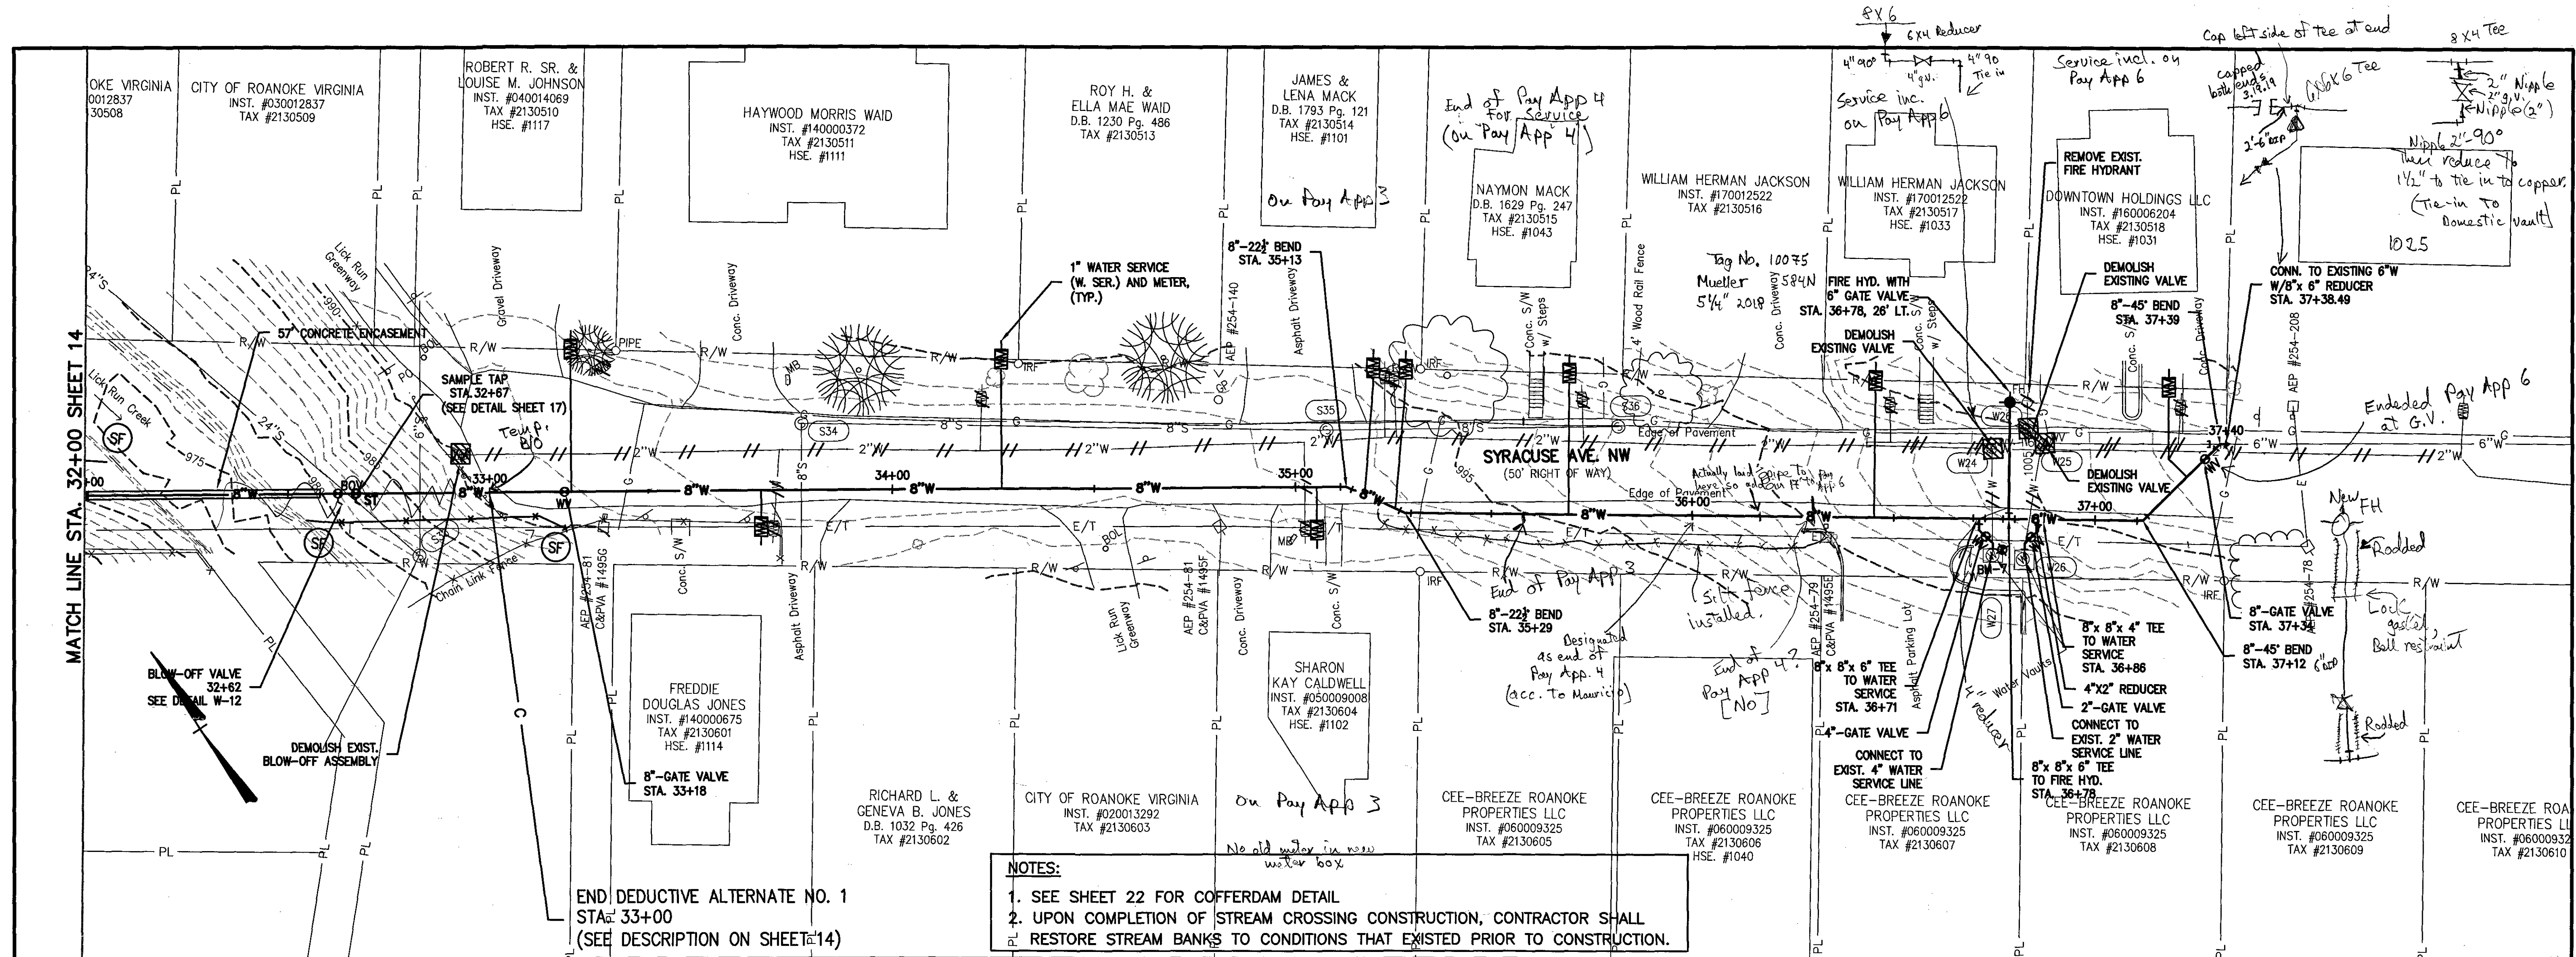

8 INCH WATER MAIN - SYRACUSE AVE. PROFILE

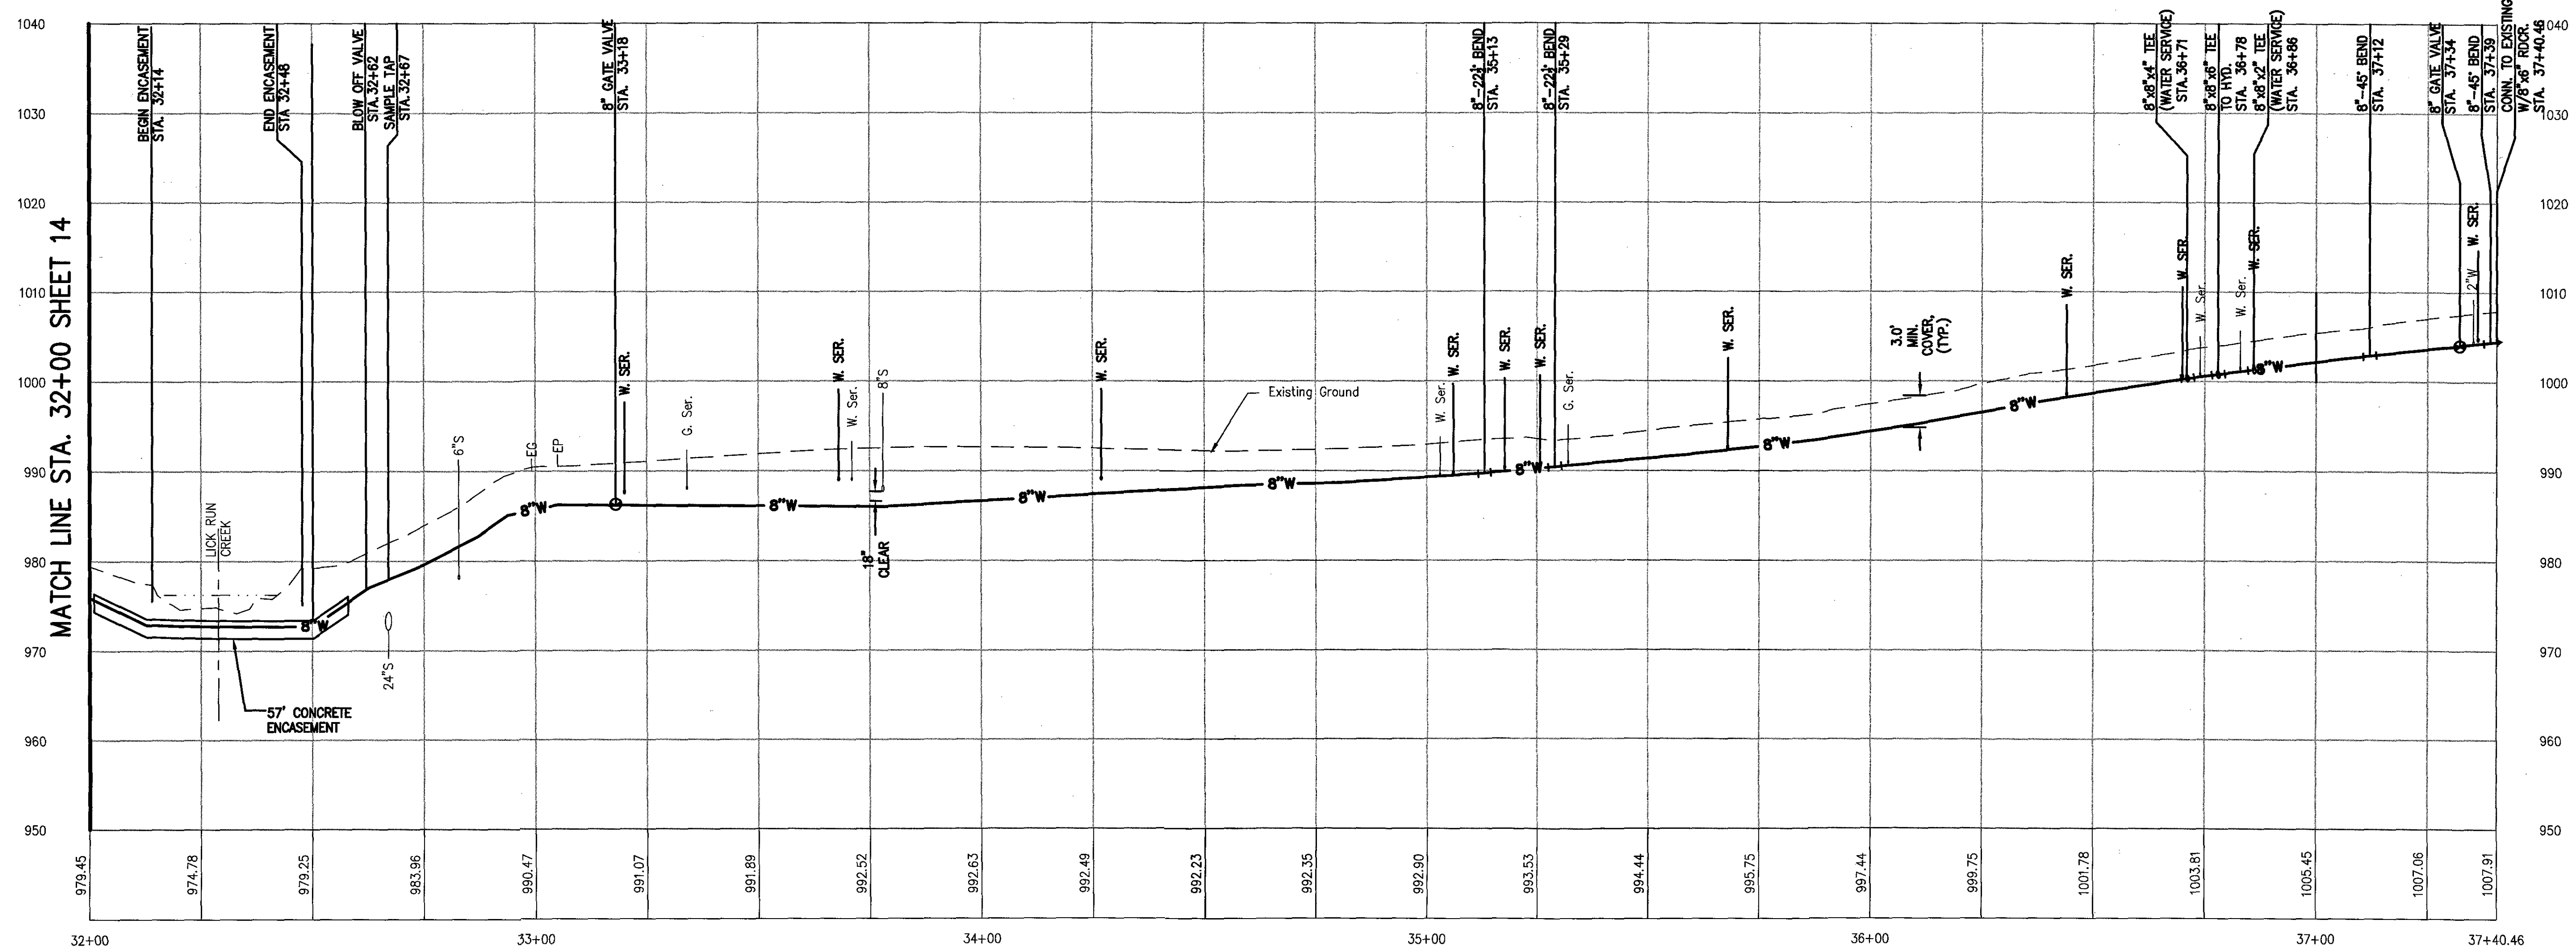

Switch services
Cap the Tee
Schedule outage
for Tuesday 3:19
Friday 3:22

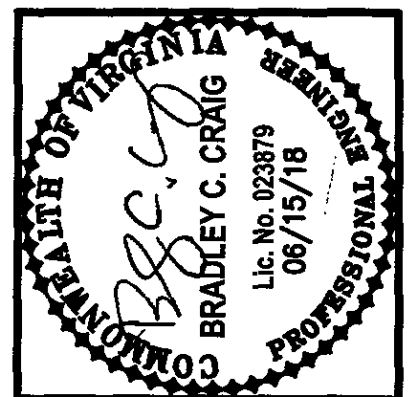

Date	
Revisions	

Issue Date: JUNE 15, 2018
Drawn By: DBL/ARB
Designed By: DBL
Checked By: BCC
Date: 06/15/18

Mattern & Craig
ENGINEERS/SURVEYORS
701 FIRST STREET, S.W.
ROANOKE, VIRGINIA 24015
(540) 345-9342
FAX (540) 345-7691

SYRACUSE AVENUE
WATERLINE REPLACEMENT
PLAN AND PROFILE - 8" WATERLINE
WESTERN VIRGINIA WATER AUTHORITY

Vertical Scale:
1" = 10'
Horizontal Scale:
1" = 20'
Commission Number:
3813

Sheet No.:
15