 



SANITARY SEWER PROJECT

LINDENWOOD SEWER


TOWN OF VINTON, VIRGINIA

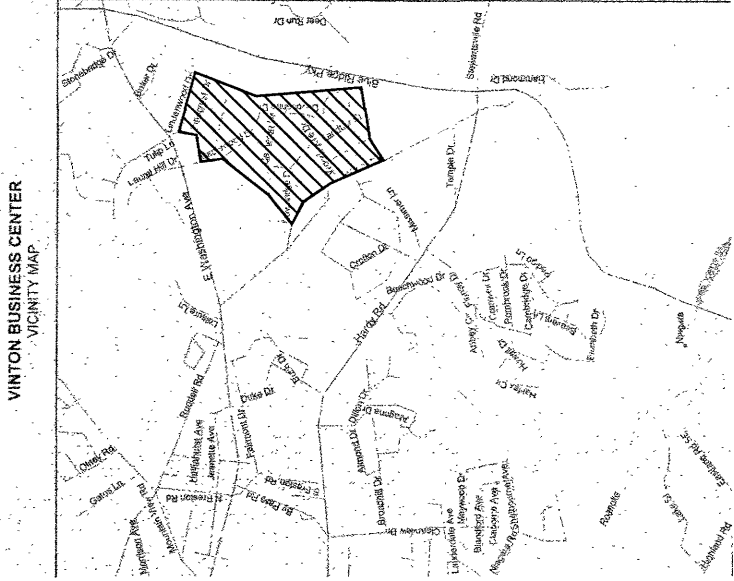

MARYLAND

WEST VIRGINIA

TOWN OF VINTON
PROJECT LOCATION

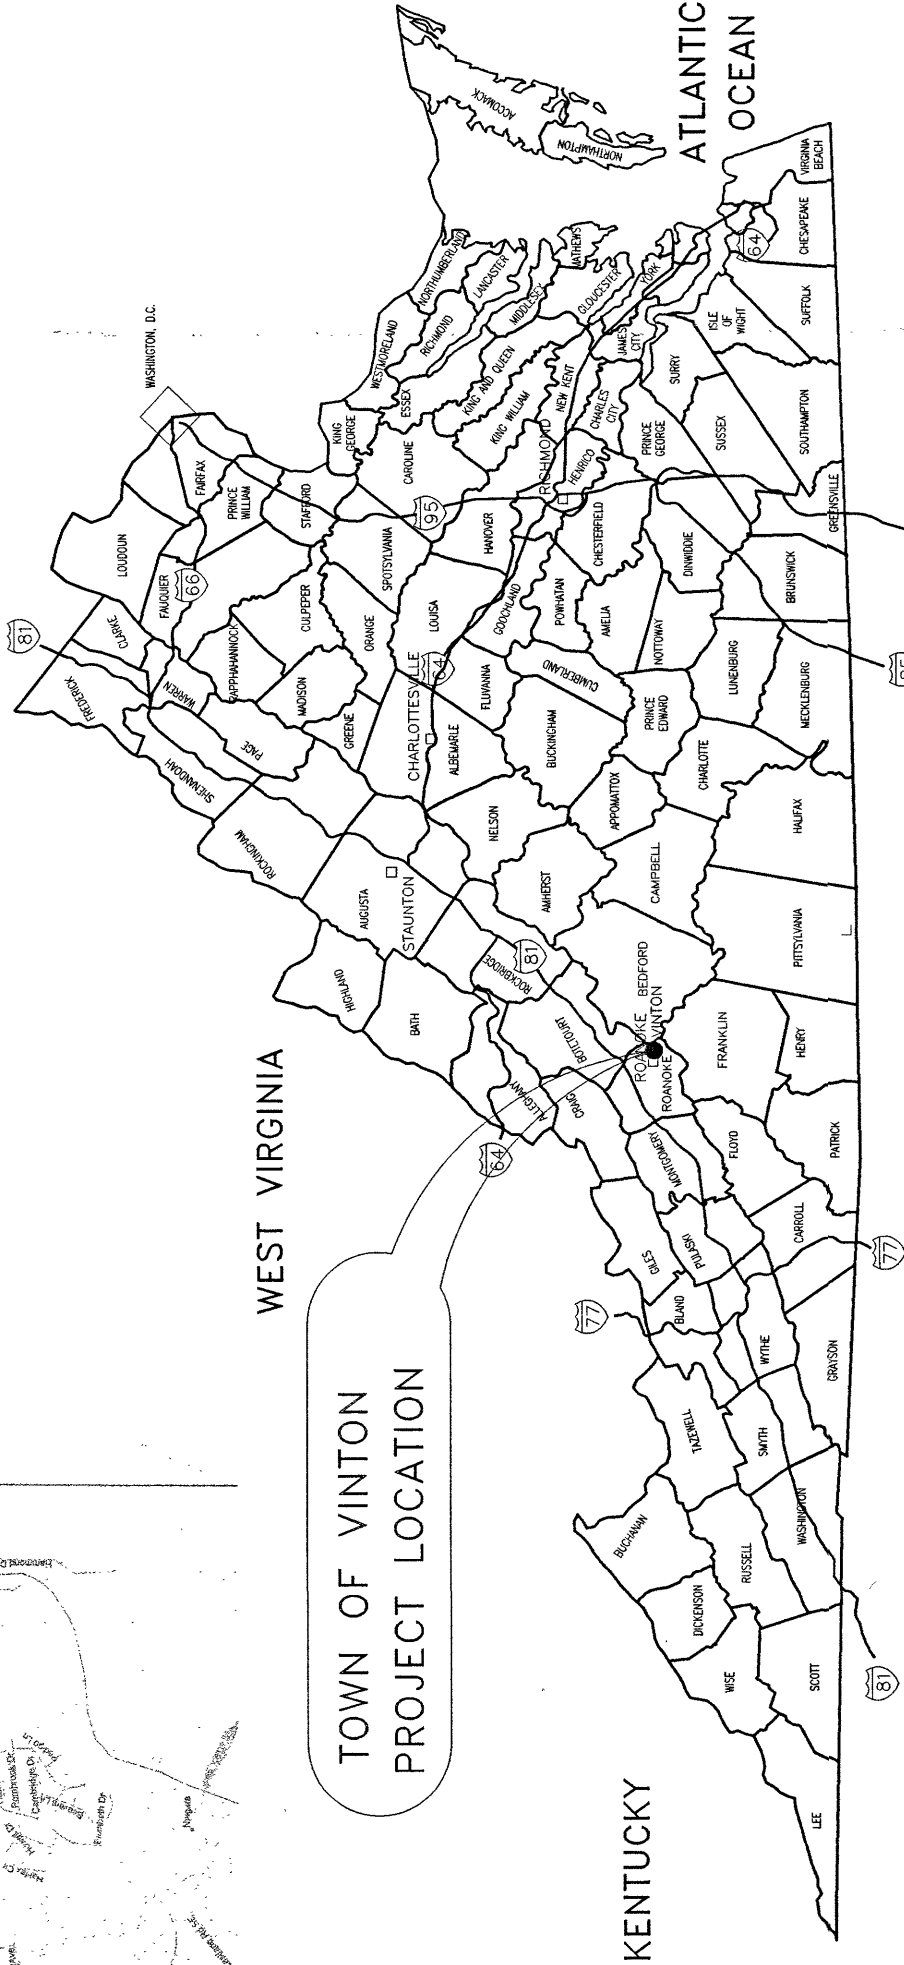

TENNESSEE

NORTH CAROLINA

KENTUCKY

ATLANTIC
OCEAN

SHEET LIST

1. TITLE SHEET
2. ABBREVIATIONS & LEGEND
3. SHEET INDEX
4. PLAN AND PROFILE - 6" AND 10" SANITARY SEWER
5. PLAN AND PROFILE - 8" SANITARY SEWER
6. PLAN - 8" SANITARY SEWER
- 6A. PROFILE - 8" SANITARY SEWER
7. PLAN AND PROFILE - 8" SANITARY SEWER
8. PLAN AND PROFILE - 8" SANITARY SEWER
9. PLAN AND PROFILE - 8" SANITARY SEWER
10. PLAN AND PROFILE - 8" SANITARY SEWER
11. PLAN AND PROFILE - 8" SANITARY SEWER
12. PLAN AND PROFILE - 8" SANITARY SEWER
13. PLAN AND PROFILE - 8" SANITARY SEWER
14. PLAN AND PROFILE - 8" SANITARY SEWER
15. PLAN AND PROFILE - 8" SANITARY SEWER
16. PLAN AND PROFILE - 8" SANITARY SEWER
17. PLAN AND PROFILE - 8" SANITARY SEWER
18. PLAN AND PROFILE - 8" SANITARY SEWER



Date	Revisions

Issue Date: May 2005	Drawn By: JEF	Designed By: SWH	Checked By: SWH	Date: May 2005
----------------------	---------------	------------------	-----------------	----------------

Mattern & Craig
CONSULTING ENGINEERS • SURVEYORS
701 FIRST STREET, S.W.
ROANOKE, VIRGINIA 24016
(540) 345-9342
FAX (540) 345-7691

SANITARY SEWER PROJECT
COVER SHEET
TOWN OF VINTON, VIRGINIA

Vertical Scale: N/A	Horizontal Scale: N/A	Commission Number: 1955-L	Sheet No.: 1
---------------------	-----------------------	---------------------------	--------------

COMM. NO. 1955-L

SET NO. _____

Mattern & Craig, Inc.
CONSULTING ENGINEERS • SURVEYORS
701 FIRST STREET, S.W.
ROANOKE, VIRGINIA 24016
(540) 345-9342
(540) 345-7691 FAX