



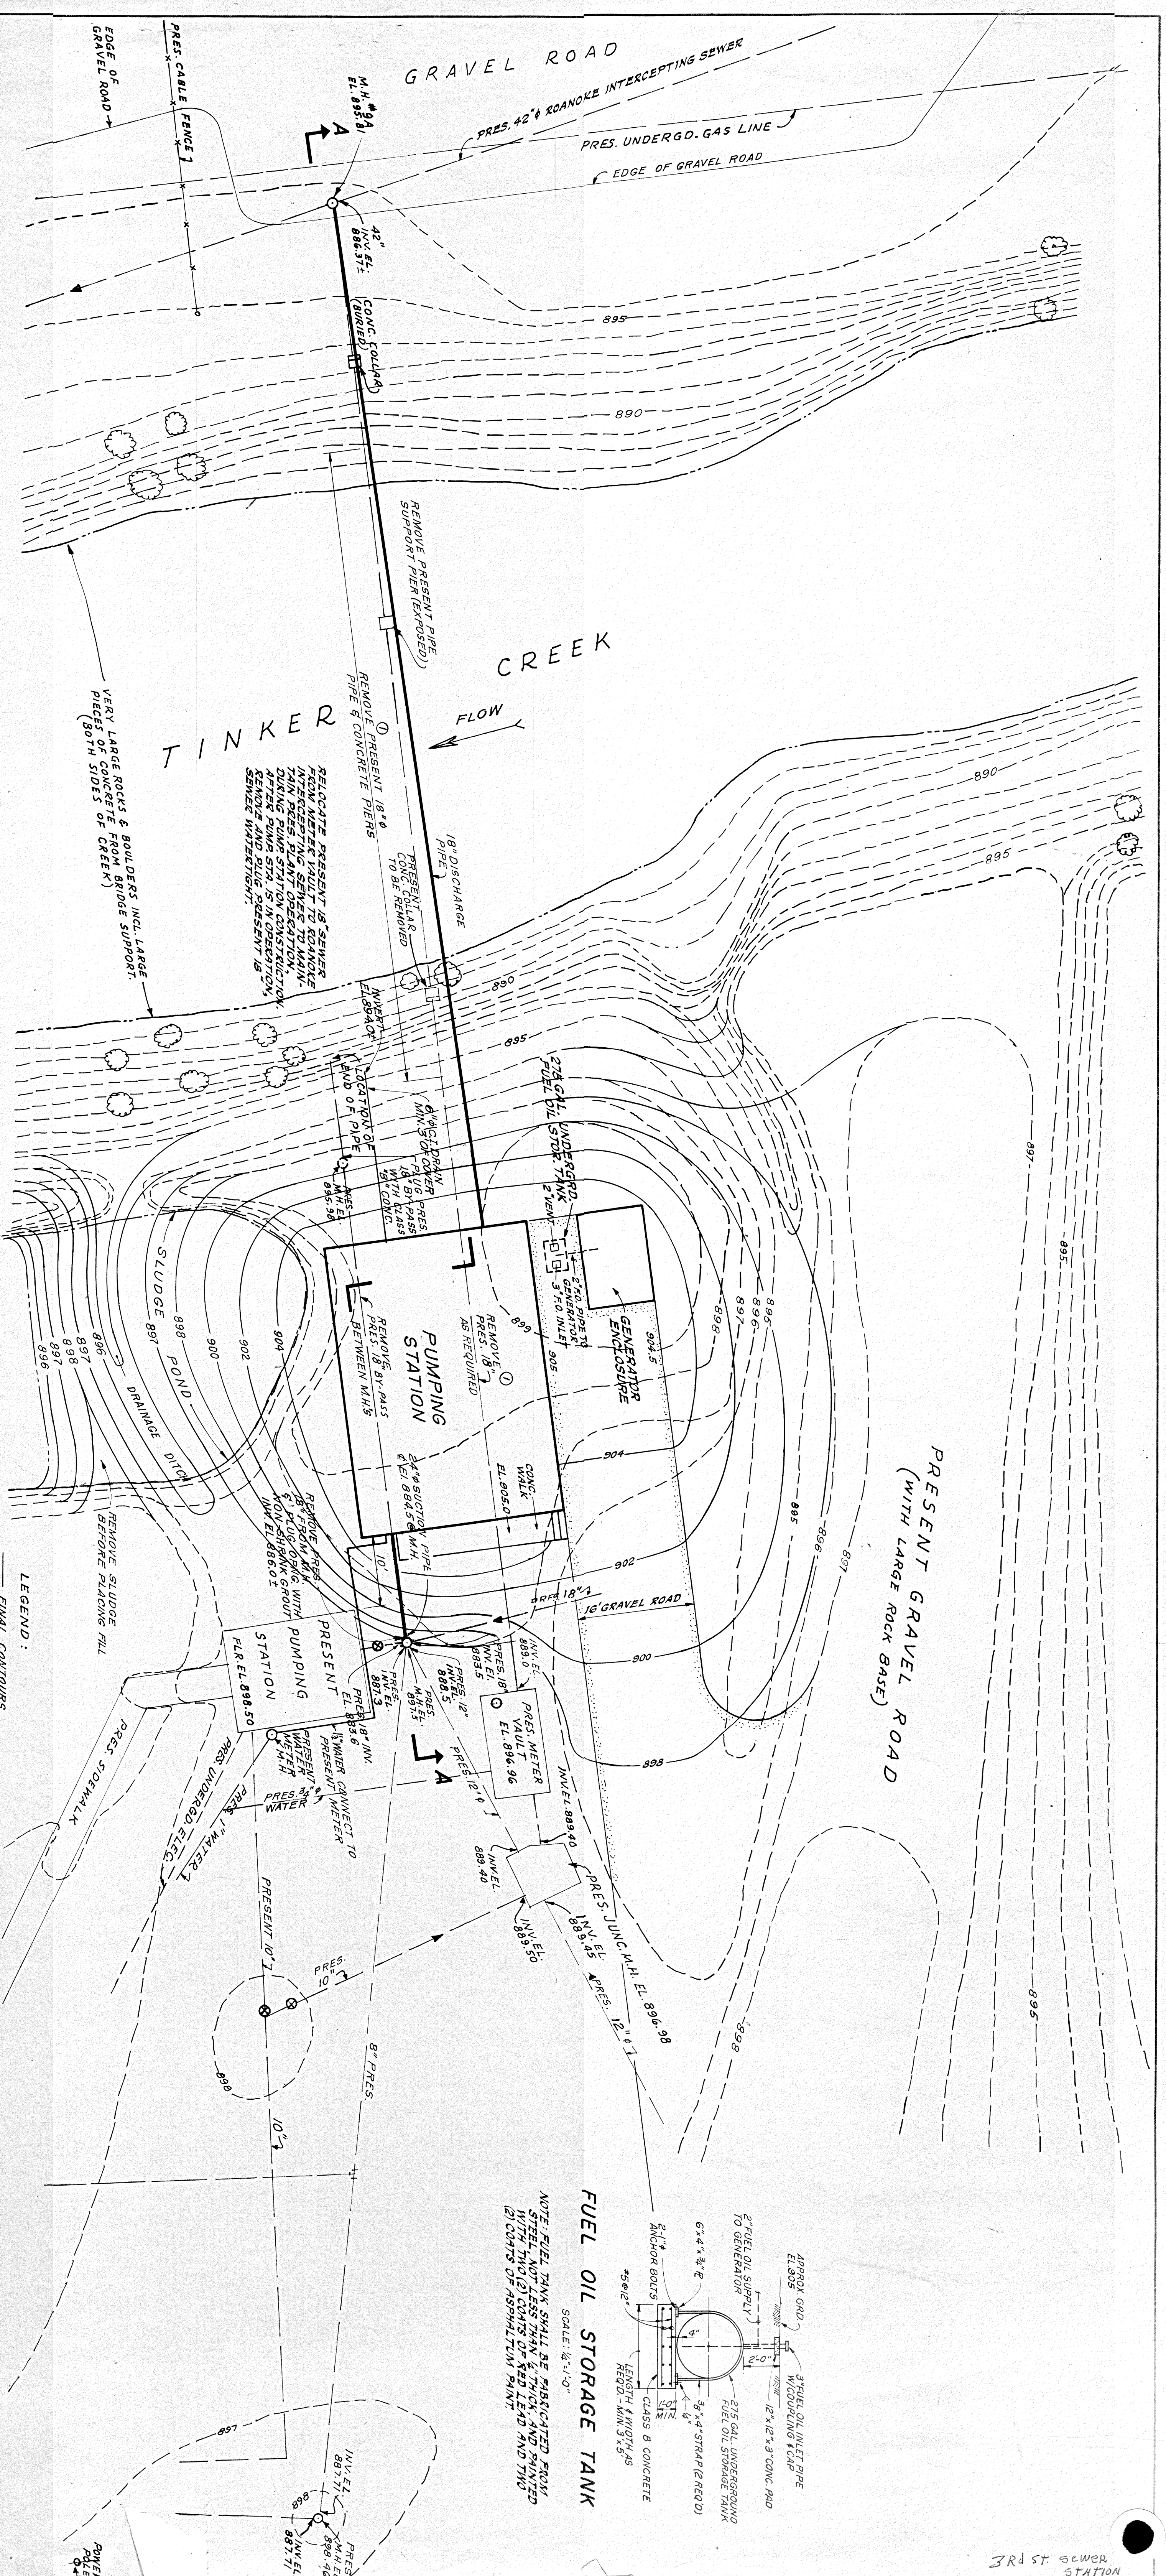

SITE PLAN
SCALE: 1"=10'

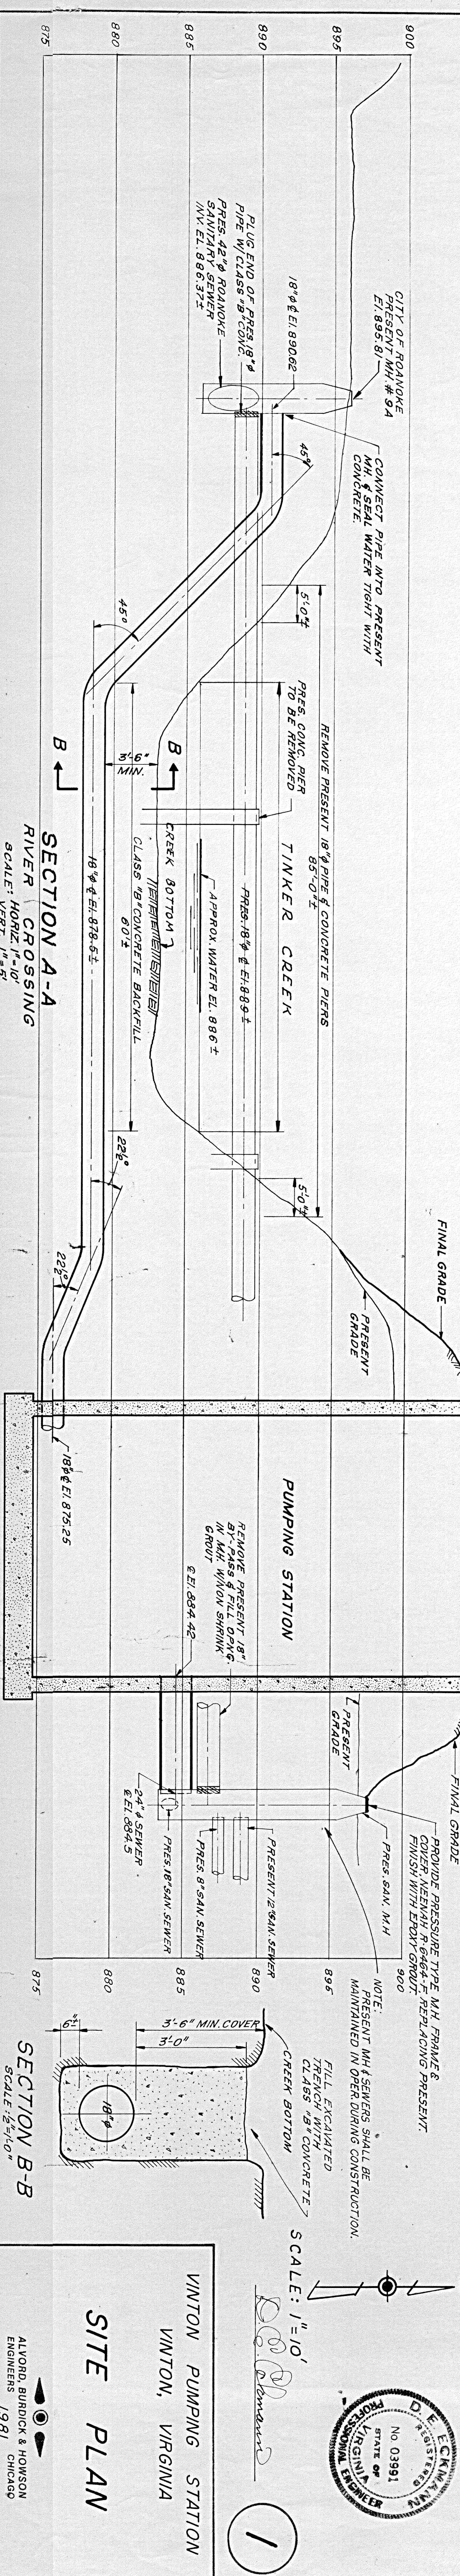

VINTON PUMPING STATION
VINTON, VIRGINIA

SITE PLAN

ALVORD, BURDICK & HOWSON
ENGINEERS
1981

1