
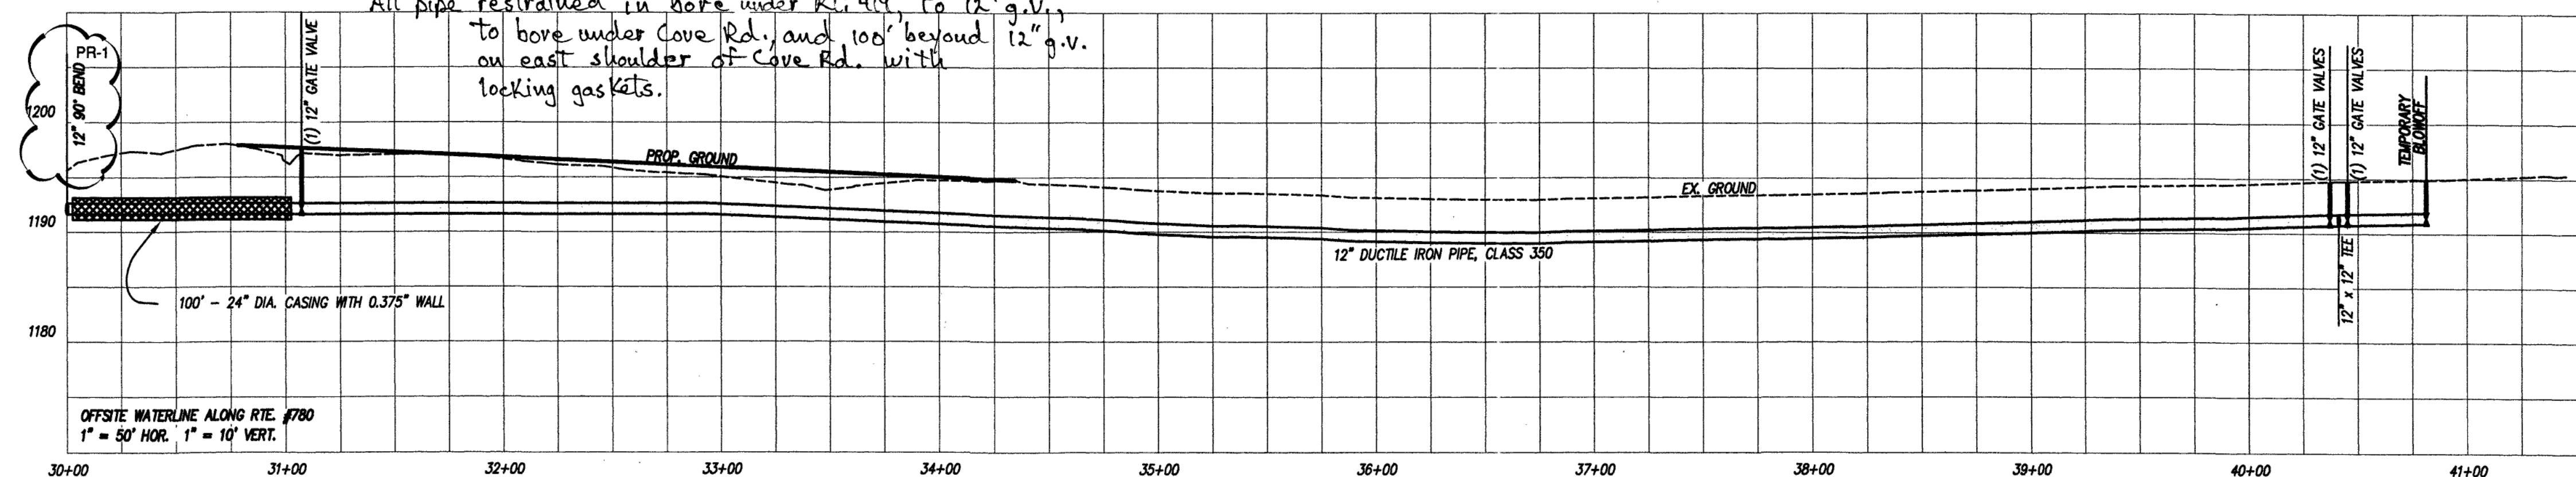
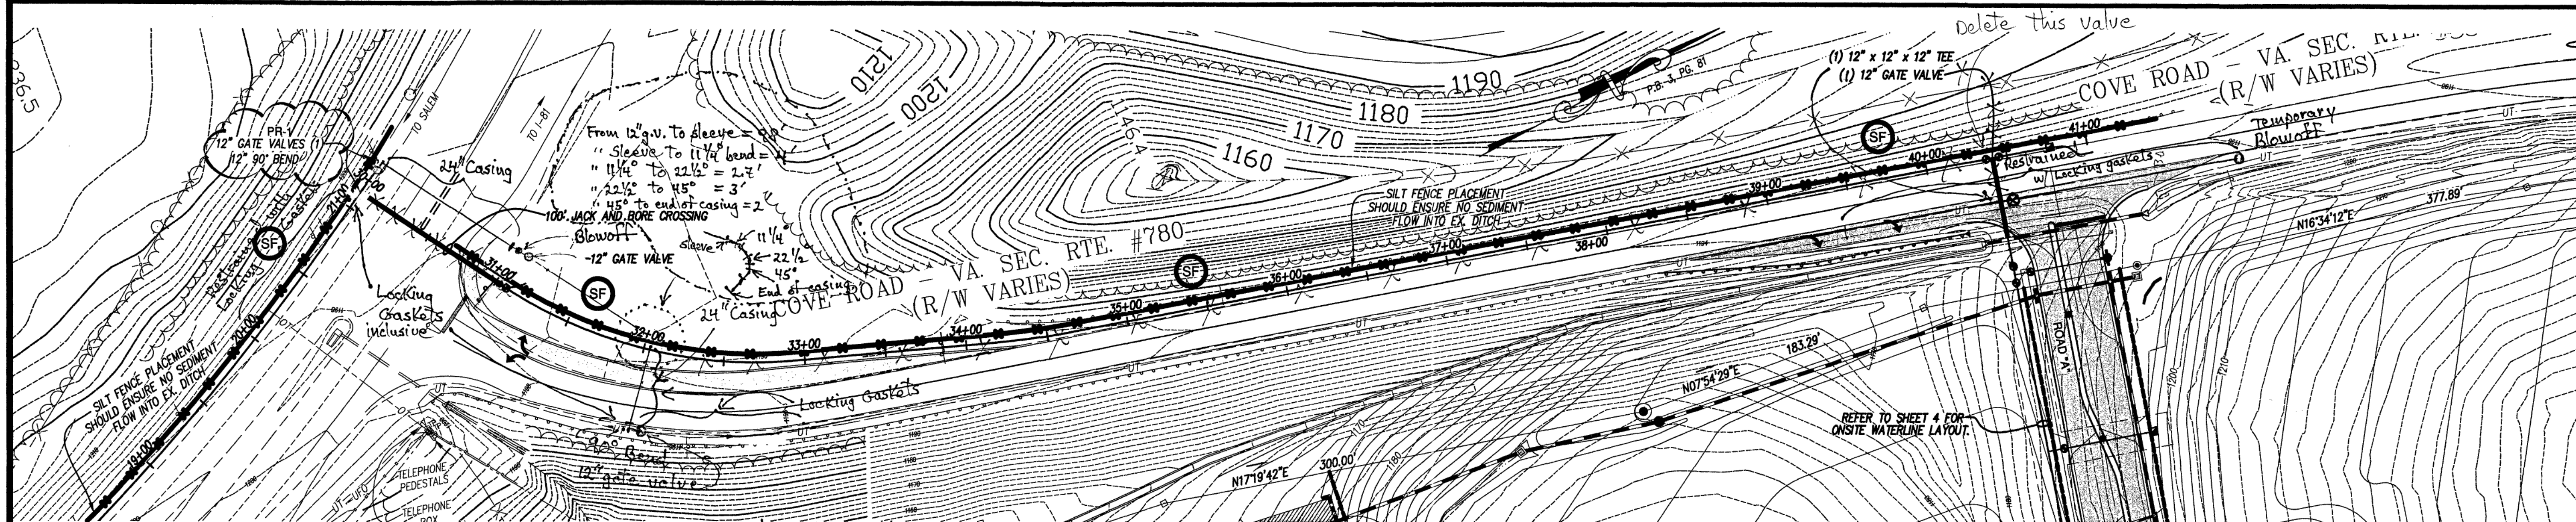
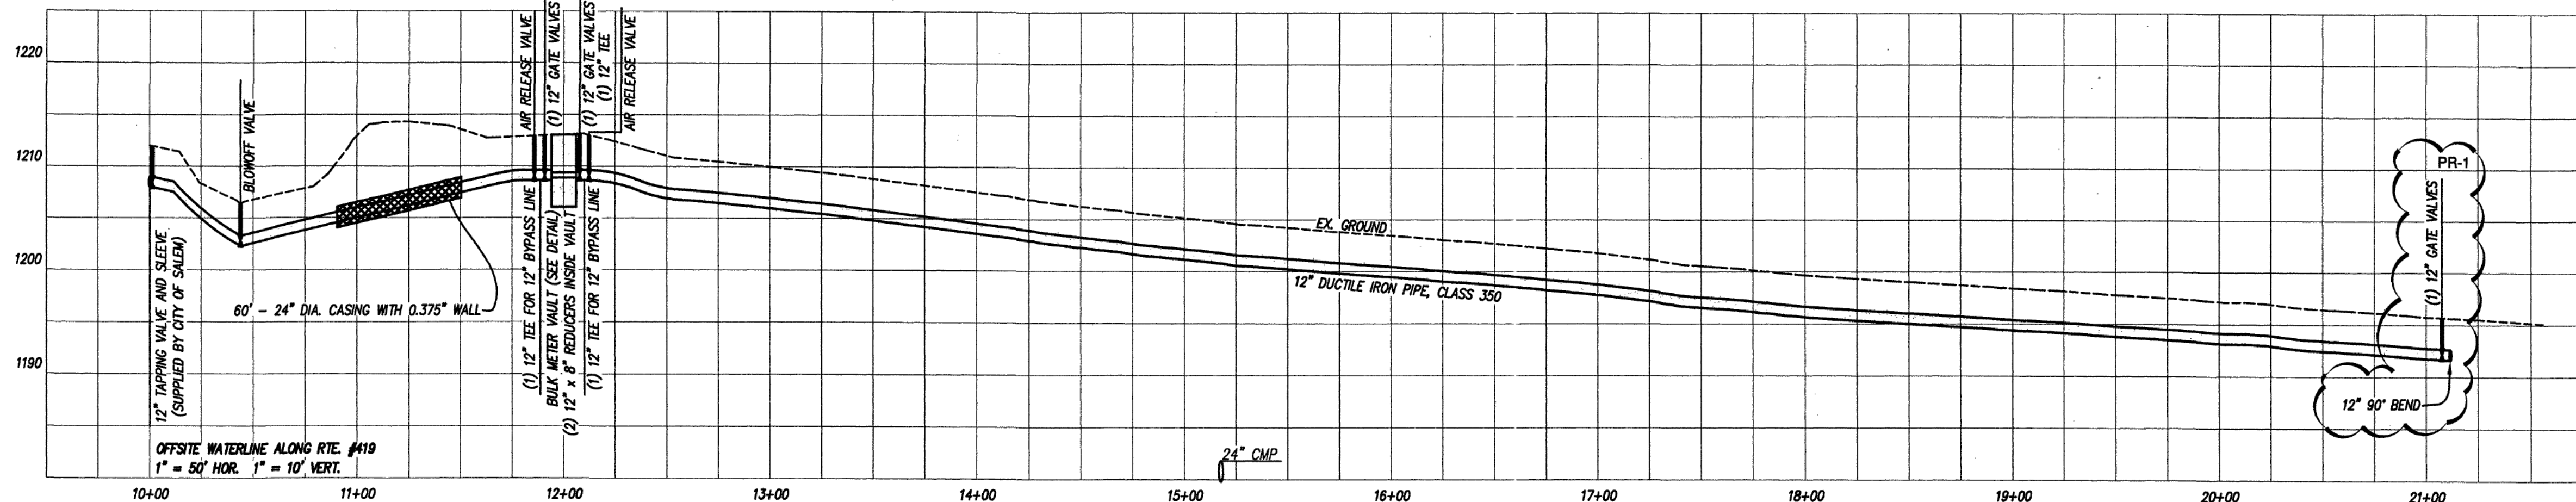


07130comp01-15-w101.dwg
w:\drawings\2007\07130\comp\07130comp01.dwg

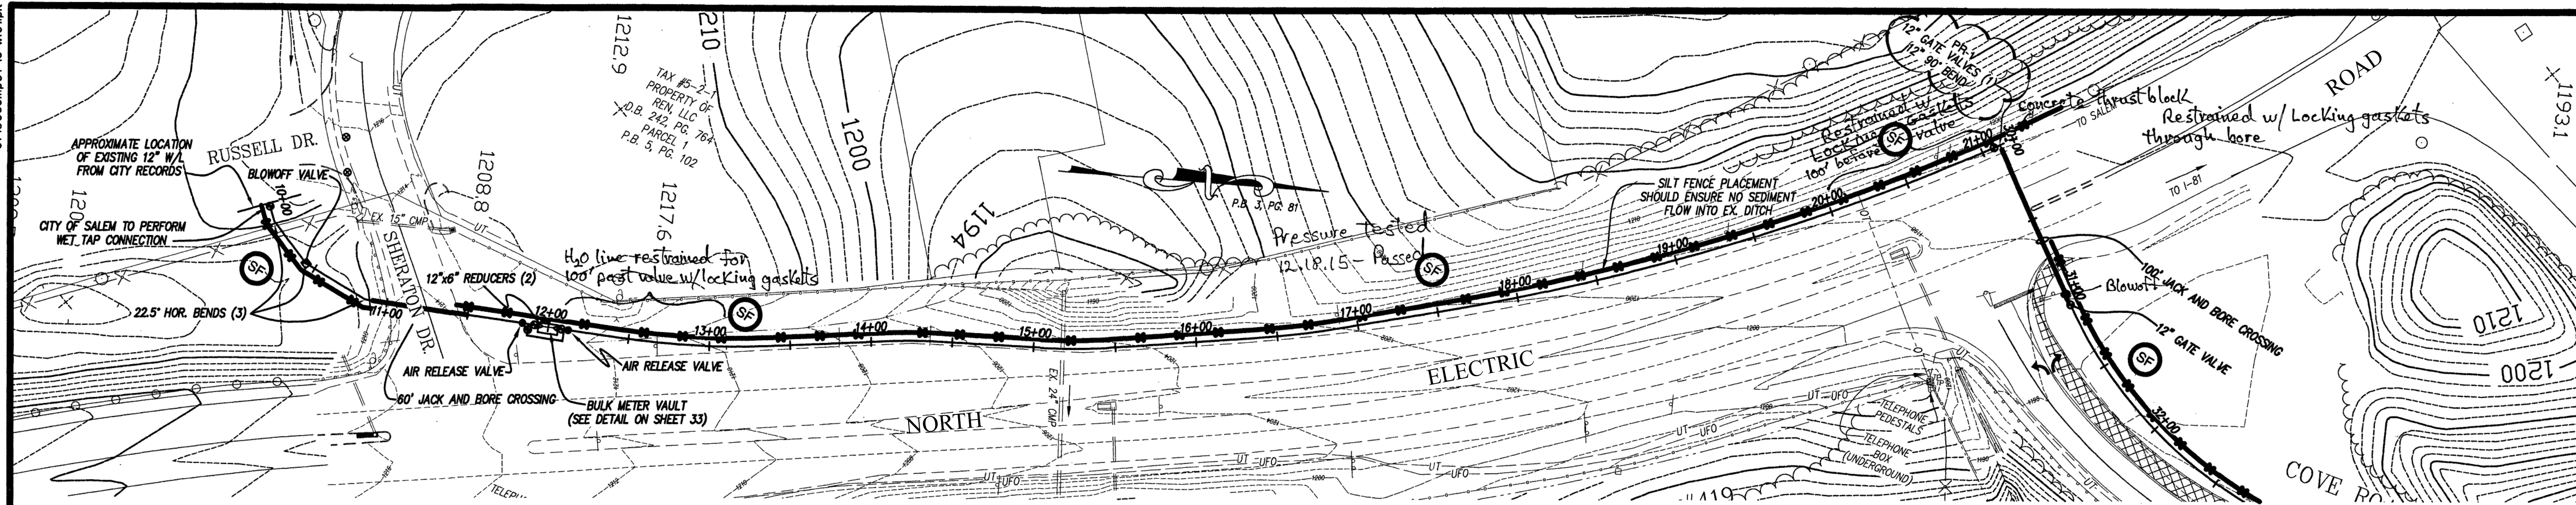

Off-site H₂O Line
pressure-tested 2.2.16
(w/ C. Crush) - passed.

LUMSDEN ASSOCIATES, P.C.
ENGINEERS-SURVEYORS-PLANNERS
ROANOKE, VIRGINIA

LA

COMMONWEALTH OF VIRGINIA
THOMAS C. DALE
Lic. No. 093002
8/24/15
PROFESSIONAL ENGINEER

**OFFSITE WATERLINE
PLAN AND PROFILE**

**DEVELOPMENT PLAN FOR
THE RETREAT**
PREPARED FOR
EDWARD ROSE DEVELOPMENT COMPANY, LLC
CATAWBA MAGISTERIAL DISTRICT
ROANOKE COUNTY, VIRGINIA

NO.	DATE	DESCRIPTION
1	8/24/15	SEE REVISION TABLE ON SHEET NO. 2
2		
3		
4		
5		

DATE: October 10, 2013
SCALE: AS SHOWN
COMMISSION NO.: 07-130
SHEET 15 OF 38