
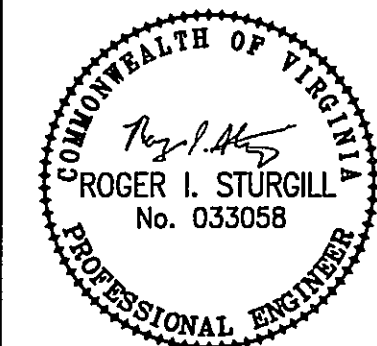


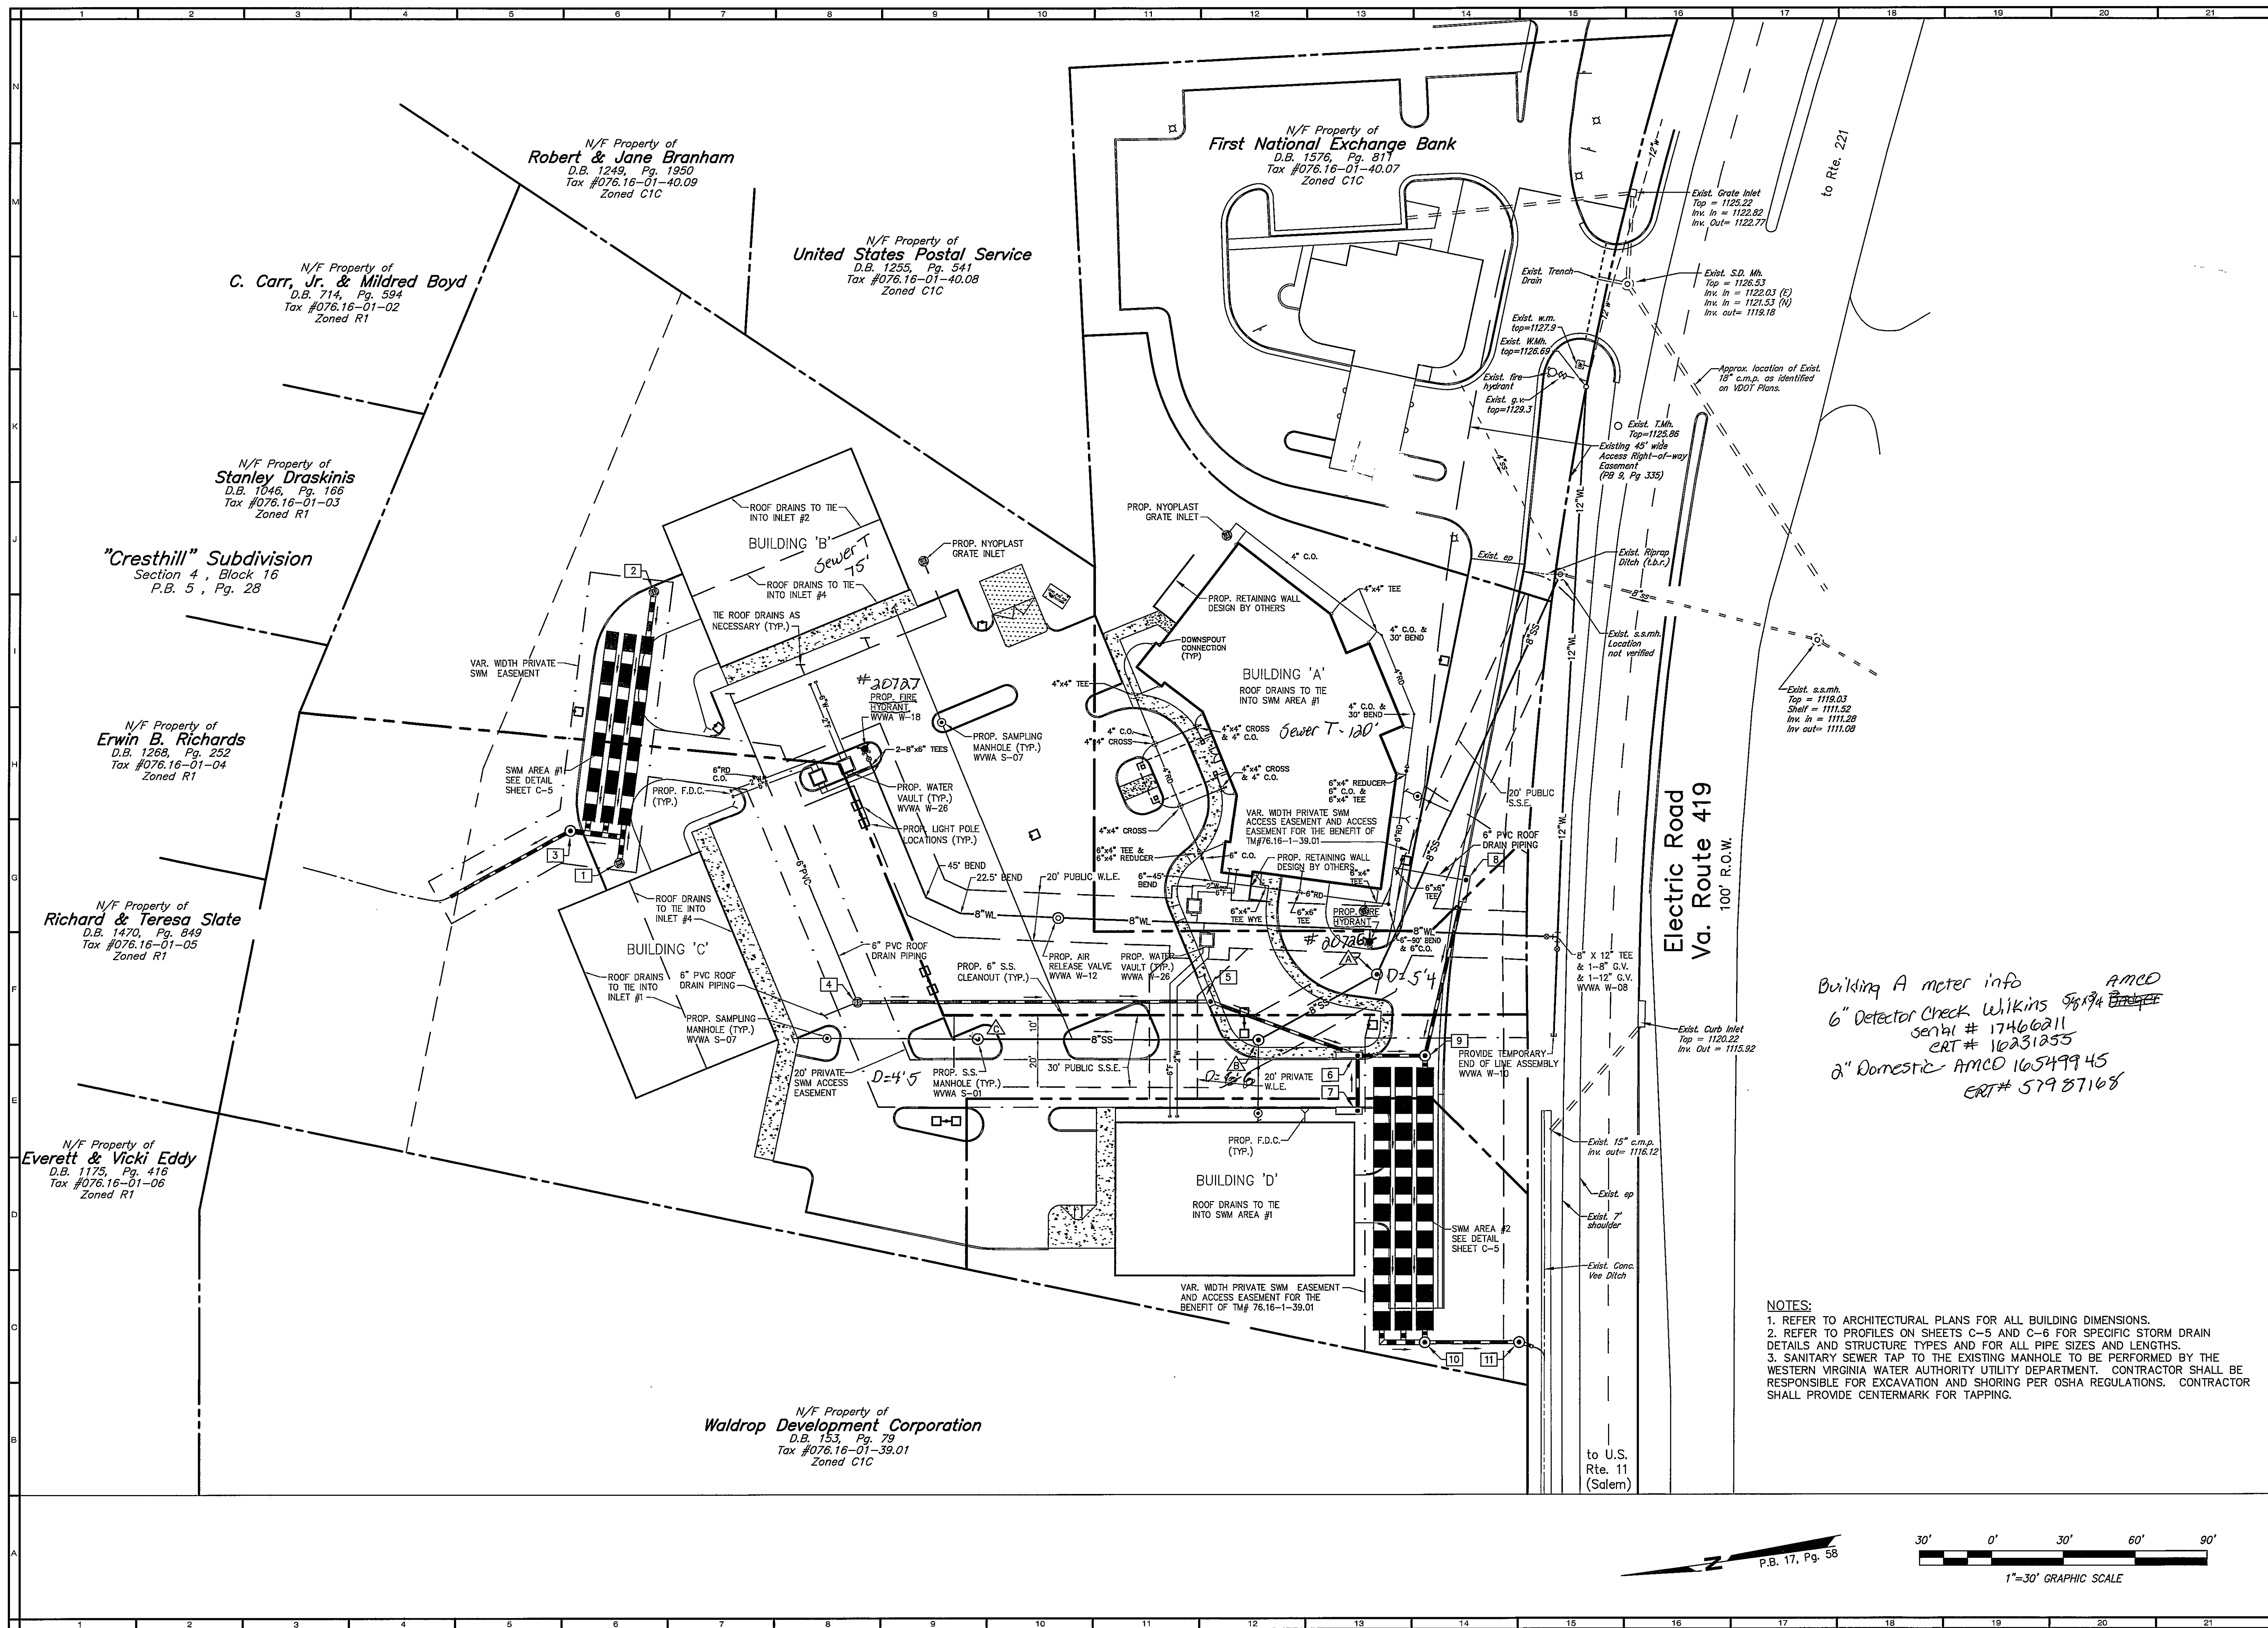

BALZER
AND ASSOCIATES, INC.
BV INC
REFLECTING TOMORROW
www.balzer.cc
PLANNERS • ARCHITECTS
ENGINEERS • SURVEYORS

1208 Corporate Circle
Roanoke, Virginia 24018
Phone: 540/772-9580
FAX: 540/772-8050

501 Branchway Road
Richmond, Virginia 23236
Phone: 804/784-0271
FAX: 804/784-2635

880 Technology Park Drive
Suite 200
Glen Allen, Virginia 23059
Phone: 804/553-0132
FAX: 804/553-0133

448 Peppers Ferry Road
Christiansburg, Virginia 24073
Phone: 540/381-4280
FAX: 540/381-4281

1557 Commerce Road
Suite 201
Vernon, Virginia 24482
Phone: 540/248-3220
FAX: 540/248-3221

TILL OFFICE PARK

UTILITY PLAN

ROANOKE COUNTY, VIRGINIA

DRAWN BY: CPB
DESIGNED BY: CPB
CHECKED BY: JVJ
DATE: 08/02/2006
REVISIONS:
10/12/2006
12/06/2006
01/09/2007
01/22/2007
03/02/2007
04/17/2007

SCALE: 1"=30'
SHEET NO. **C-3**
JOB NO. R0600073.00

Building A meter info
6" Detector Check Wilkins 5/19/04 AMCO
Serial # 17466211
ERT # 10231355
2" Domestic AMCO 10/5/99 45
ERT # 579 87168

NOTES:
1. REFER TO ARCHITECTURAL PLANS FOR ALL BUILDING DIMENSIONS.
2. REFER TO PROFILES ON SHEETS C-5 AND C-6 FOR SPECIFIC STORM DRAIN DETAILS AND STRUCTURE TYPES AND FOR ALL PIPE SIZES AND LENGTHS.
3. SANITARY SEWER TAP TO THE EXISTING MANHOLE TO BE PERFORMED BY THE WESTERN VIRGINIA WATER AUTHORITY UTILITY DEPARTMENT. CONTRACTOR SHALL BE RESPONSIBLE FOR EXCAVATION AND SHORING PER OSHA REGULATIONS. CONTRACTOR SHALL PROVIDE CENTERMARK FOR TAPPING.