



FILE NAME: \\gator\dwg\proj\12\120000\120000.dwg PLOTTED: 0.0000" MONTH DD" YYYY - HAMMAM/PM

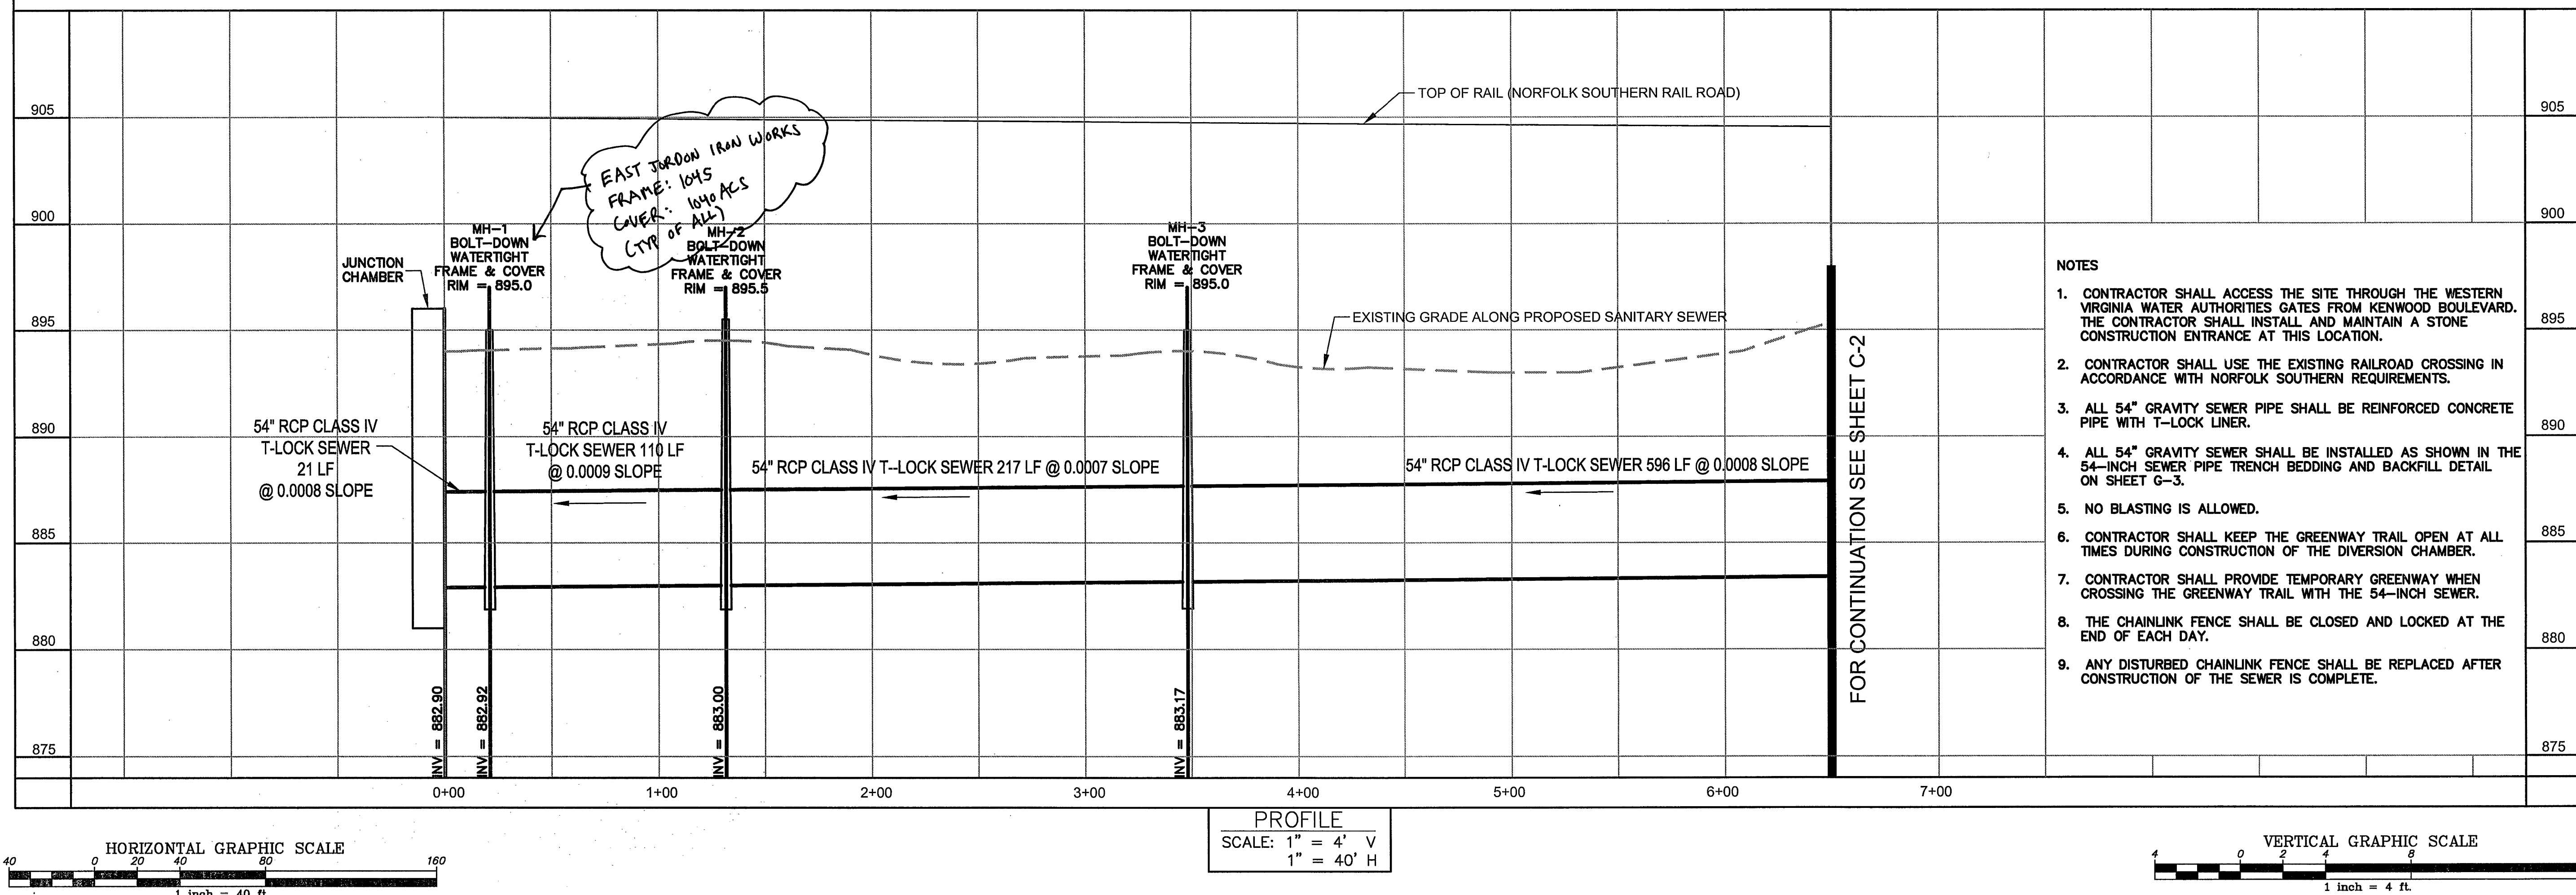

URS
4905 DICKENS ROAD, SUITE 106
RICHMOND, VIRGINIA 23230
(804)965-9000 www.urscorp.com

WESTERN VIRGINIA
WATER AUTHORITY
TINKER CREEK
54-INCH PARALLEL RELIEF SEWER
PLAN AND PROFILE

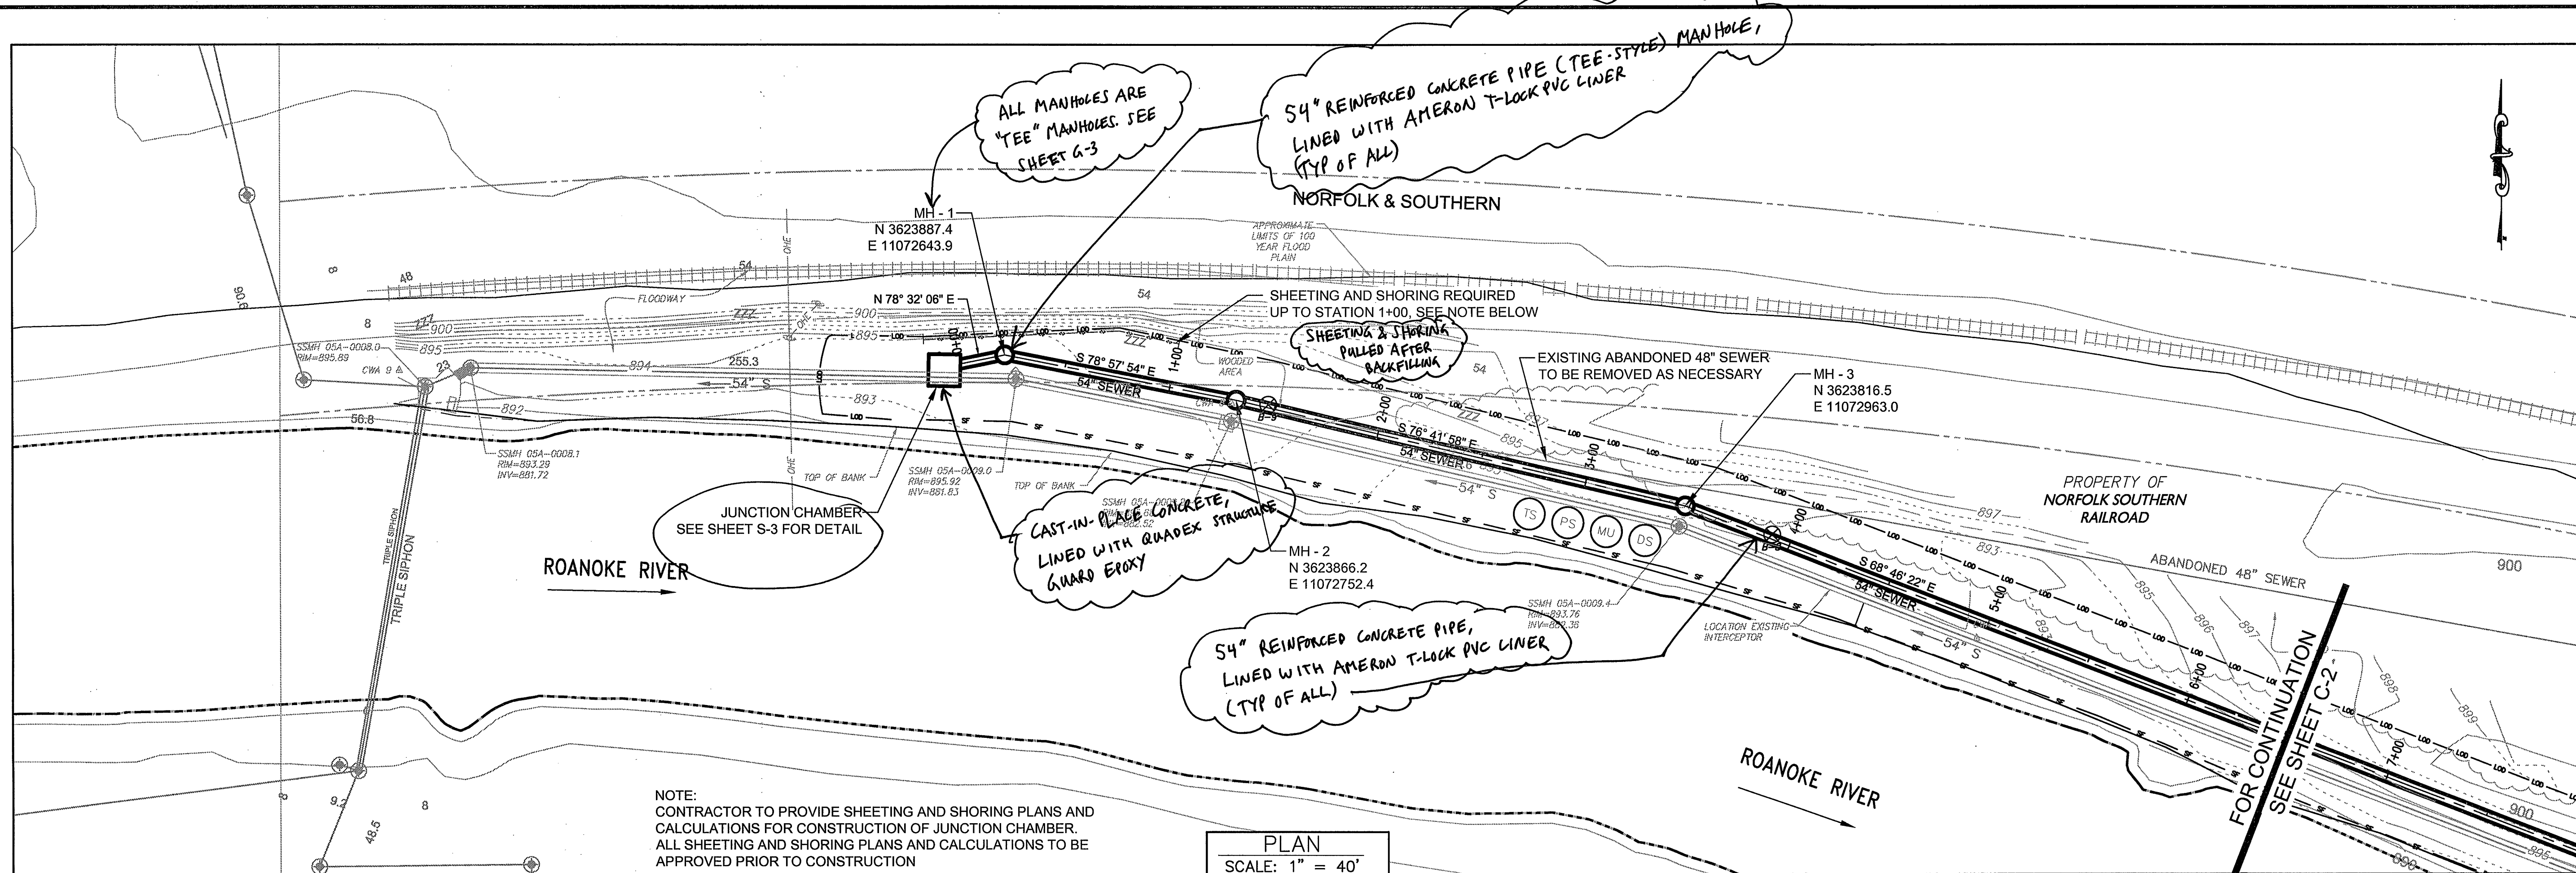

DATE: NOVEMBER 2012
JOB NO.: 11658086
LEAD ENGINEER: tjd
DRAWN BY: wjl
CHECKED: tkf
REVISION:

C-1

SHEET 5 OF 10