
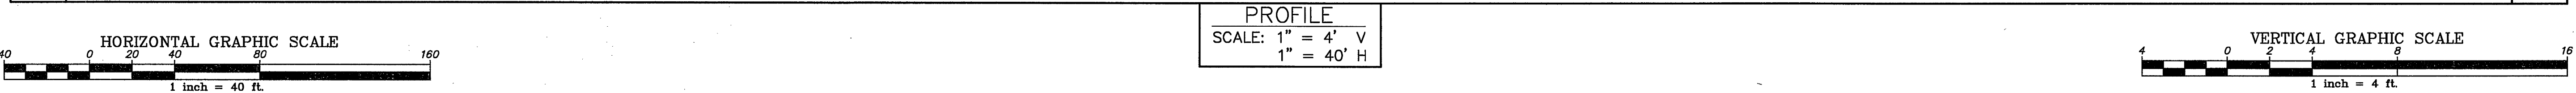
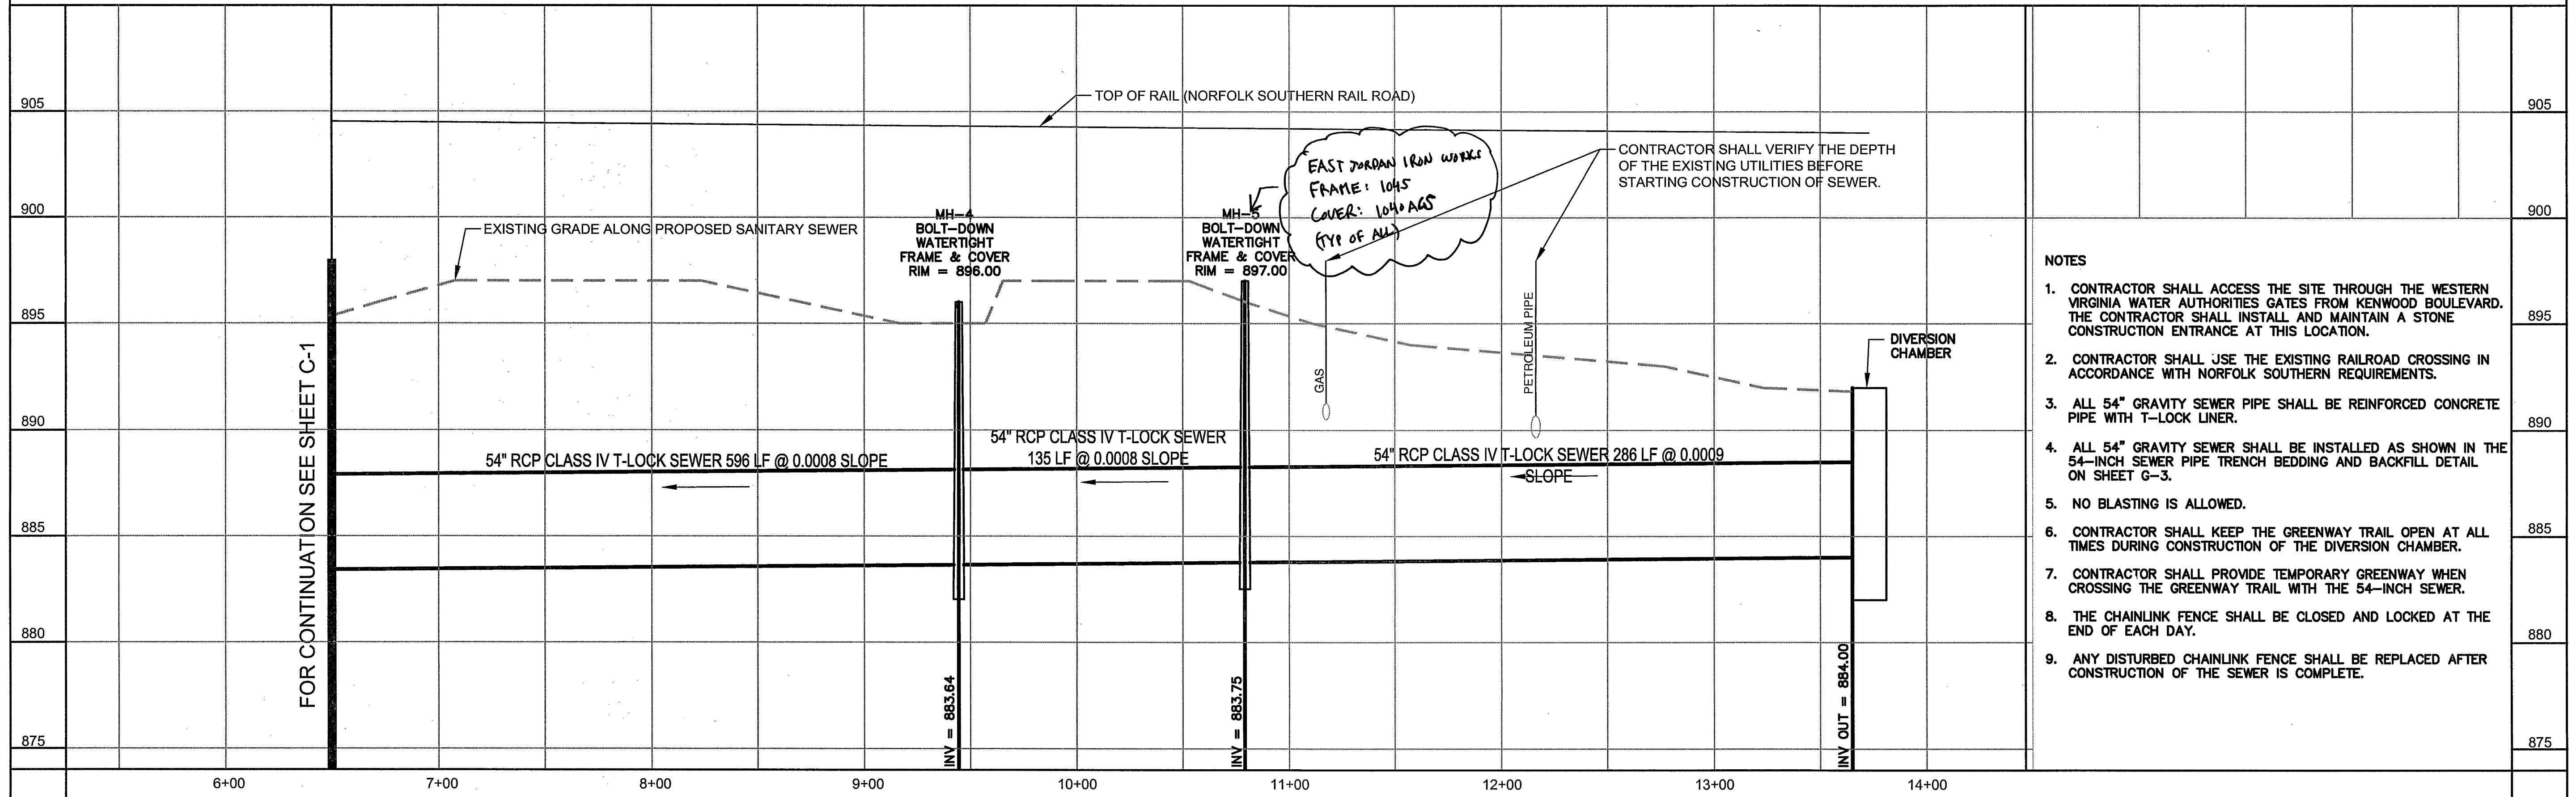


FILE NAME: \\networ... \\\n

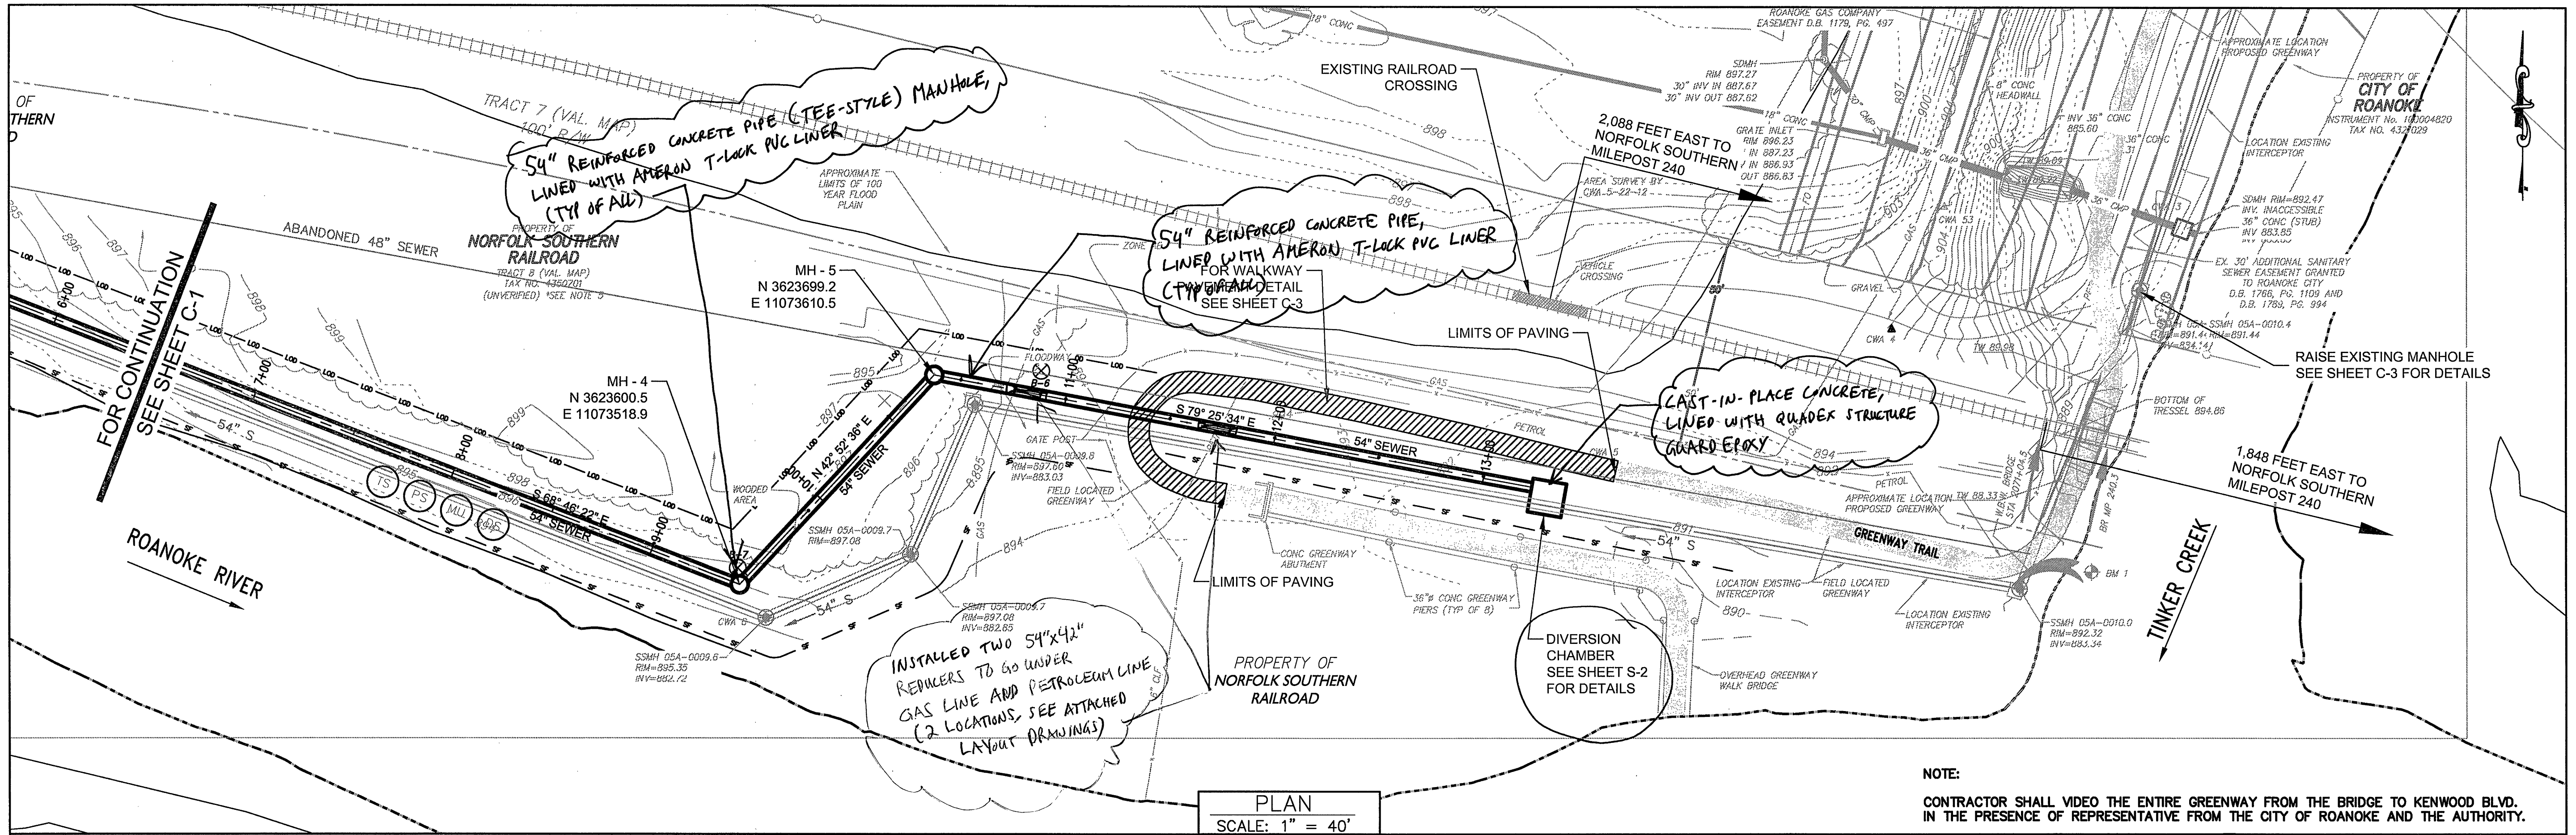

NOTE:
CONTRACTOR SHALL VIDEO THE ENTIRE GREENWAY FROM THE BRIDGE TO KENWOOD BLVD.
IN THE PRESENCE OF REPRESENTATIVE FROM THE CITY OF ROANOKE AND THE AUTHORITY.

- NOTES
1. CONTRACTOR SHALL ACCESS THE SITE THROUGH THE WESTERN VIRGINIA WATER AUTHORITIES GATES FROM KENWOOD BOULEVARD. THE CONTRACTOR SHALL INSTALL AND MAINTAIN A STONE CONSTRUCTION ENTRANCE AT THIS LOCATION.
 2. CONTRACTOR SHALL USE THE EXISTING RAILROAD CROSSING IN ACCORDANCE WITH NORFOLK SOUTHERN REQUIREMENTS.
 3. ALL 54" GRAVITY SEWER PIPE SHALL BE REINFORCED CONCRETE PIPE WITH T-LOCK LINER.
 4. ALL 54" GRAVITY SEWER SHALL BE INSTALLED AS SHOWN IN THE 54-INCH SEWER PIPE TRENCH BEDDING AND BACKFILL DETAIL ON SHEET G-3.
 5. NO BLASTING IS ALLOWED.
 6. CONTRACTOR SHALL KEEP THE GREENWAY TRAIL OPEN AT ALL TIMES DURING CONSTRUCTION OF THE DIVERSION CHAMBER.
 7. CONTRACTOR SHALL PROVIDE TEMPORARY GREENWAY WHEN CROSSING THE GREENWAY TRAIL WITH THE 54-INCH SEWER.
 8. THE CHAINLINK FENCE SHALL BE CLOSED AND LOCKED AT THE END OF EACH DAY.
 9. ANY DISTURBED CHAINLINK FENCE SHALL BE REPLACED AFTER CONSTRUCTION OF THE SEWER IS COMPLETE.

URS
4905 DICKENS ROAD, SUITE 106
RICHMOND, VIRGINIA 23236
(804)965-9000 www.urscorp.com

WESTERN VIRGINIA
WATER AUTHORITY
TINKER CREEK
54-INCH PARALLEL RELIEF SEWER
PLAN AND PROFILE



DATE: NOVEMBER 2012
JOB NO.: 11658086
LEAD ENGINEER: tjd
DRAWN BY: wjl
CHECKED: tkf
REVISION:

C-2

SHEET 6 OF 10