 


MME MORGAN ENGINEERING, LLC
1430 SOMMERVILLE COURT
MIDDLEBURY, VA 22113
TEL: 804.419.2558
FAX: 804.419.2558

29 OF 44

SITE DEVELOPMENT PLAN FOR THE TOWNES AT HIDDEN VALLEY WINDSOR HILLS DISTRICT, ROANOKE COUNTY, VIRGINIA




REVISION
1. PER COUNTY COMMENTS
2. 100307 PER VDOT AND PER COUNTY COMMENTS
3. 110607 PER COUNTY COMMENTS
4. 121107 PER VDOT COMMENTS
5. 112009 ADDED PHASE 1 AND PHASE 2 LINES TO PLAN
6. 081213 PHASE 2






2006-125	CHECK BY:
DLC	MDM
03/21/07	01/20/10

WATERLINE E
PLAN AND PROFILE

SHEET NO.

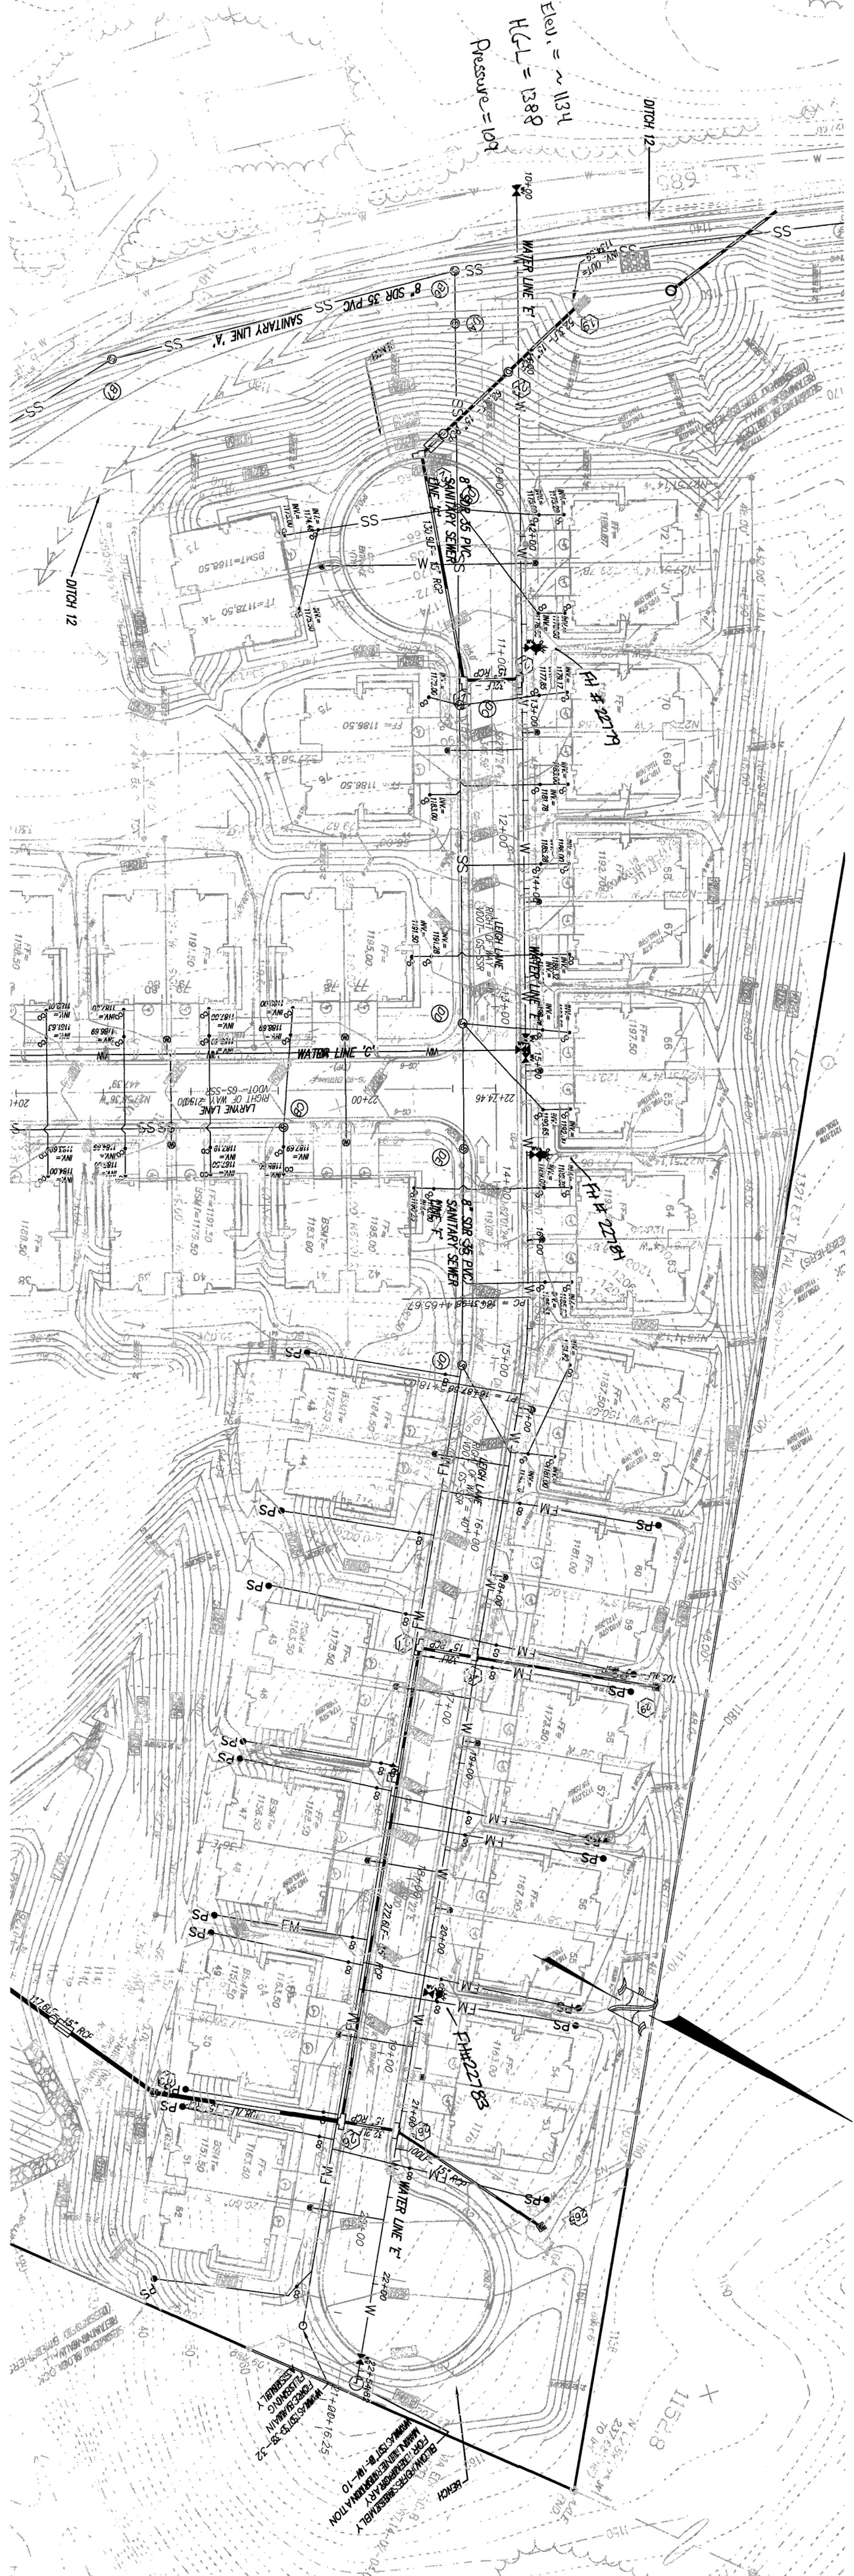

WATER LINE 'E'
8" CLASS 50 DI PIPE

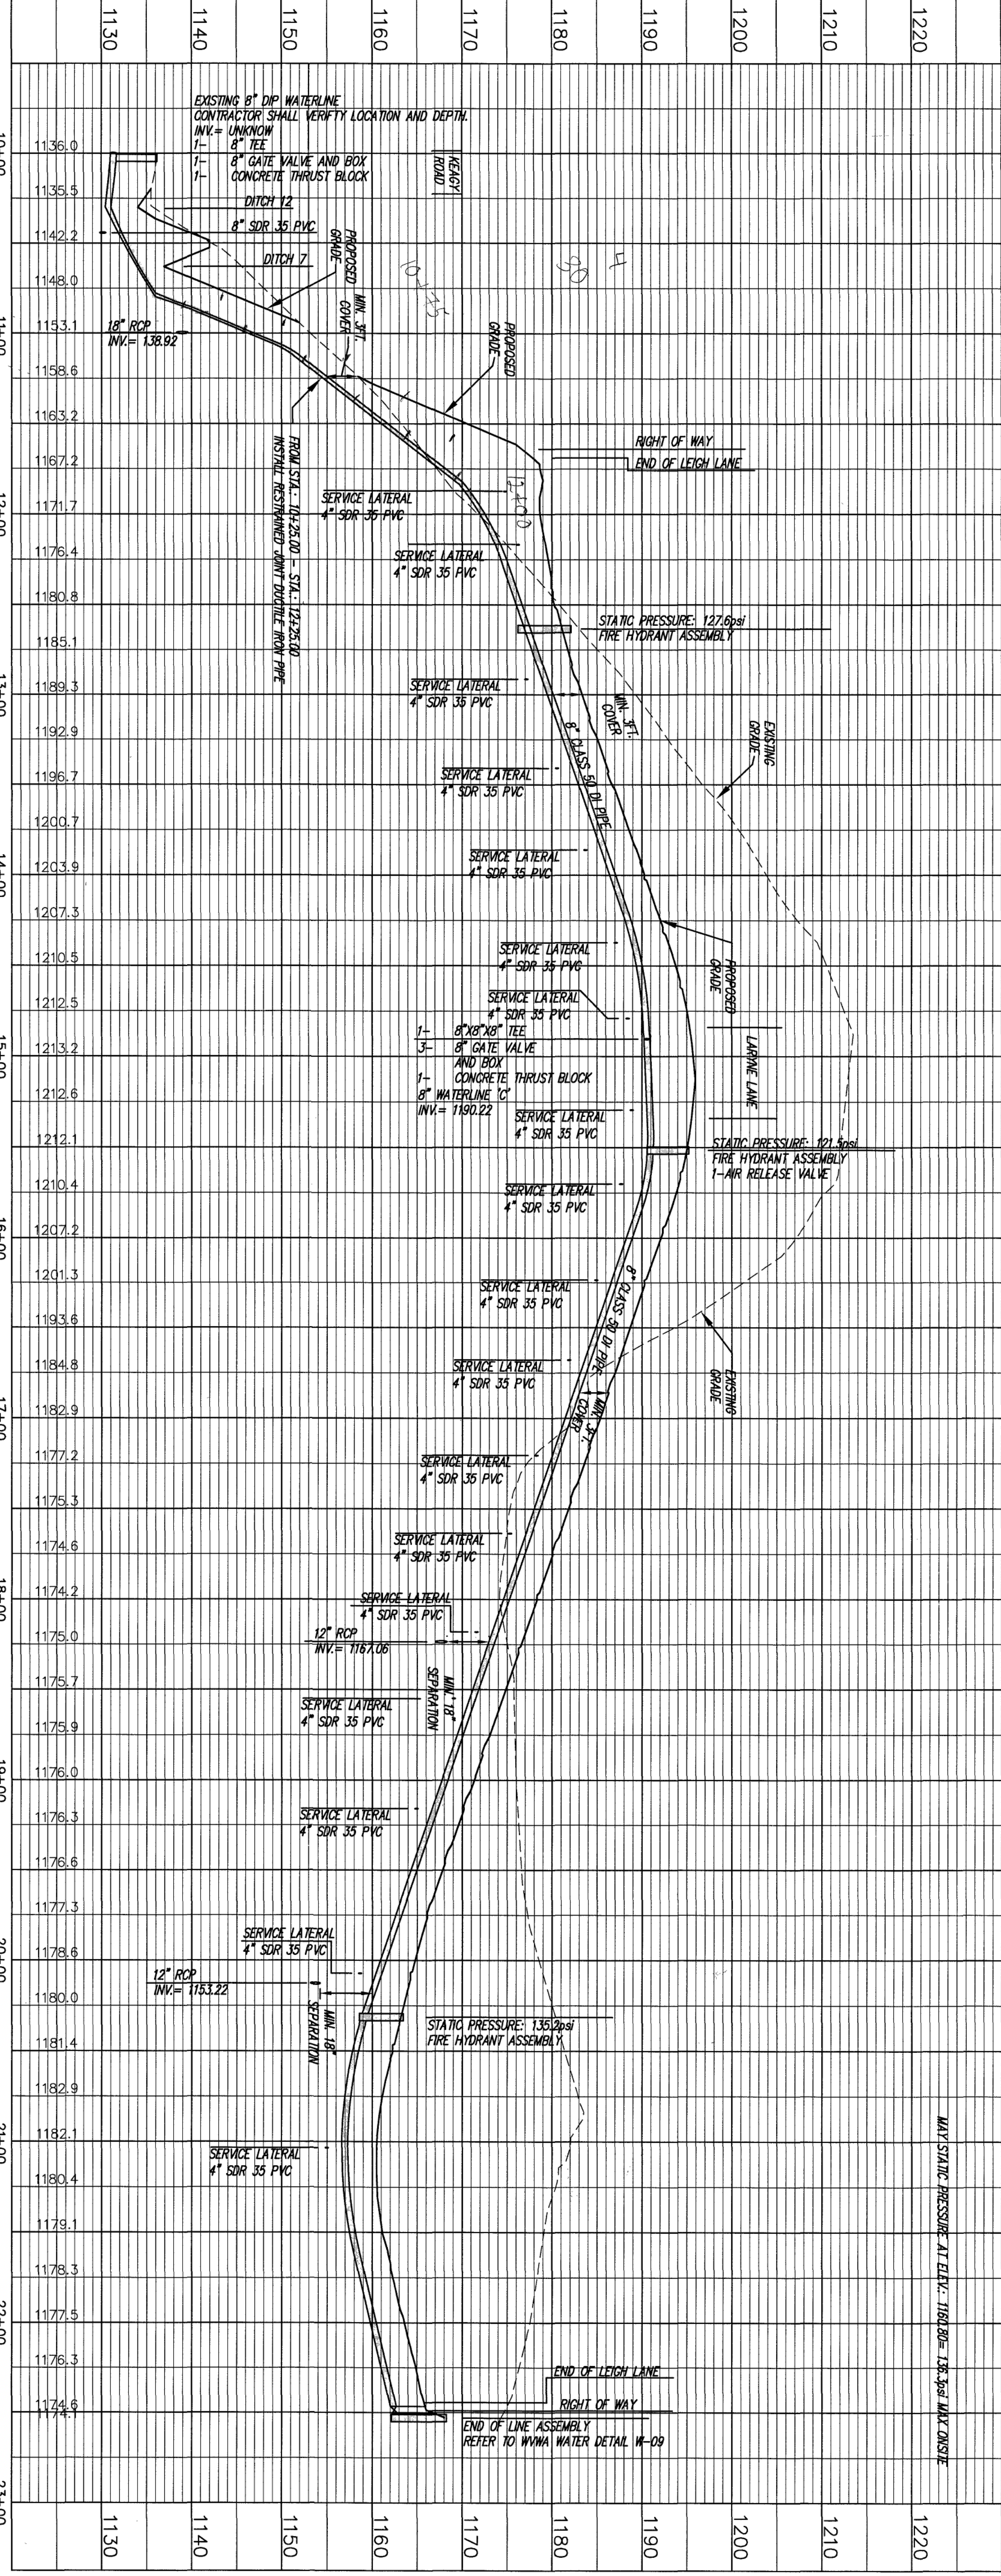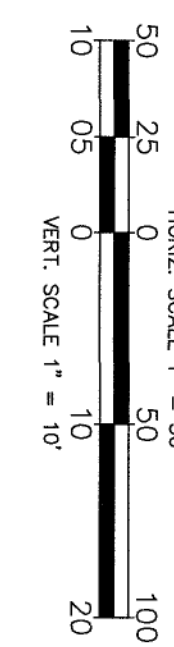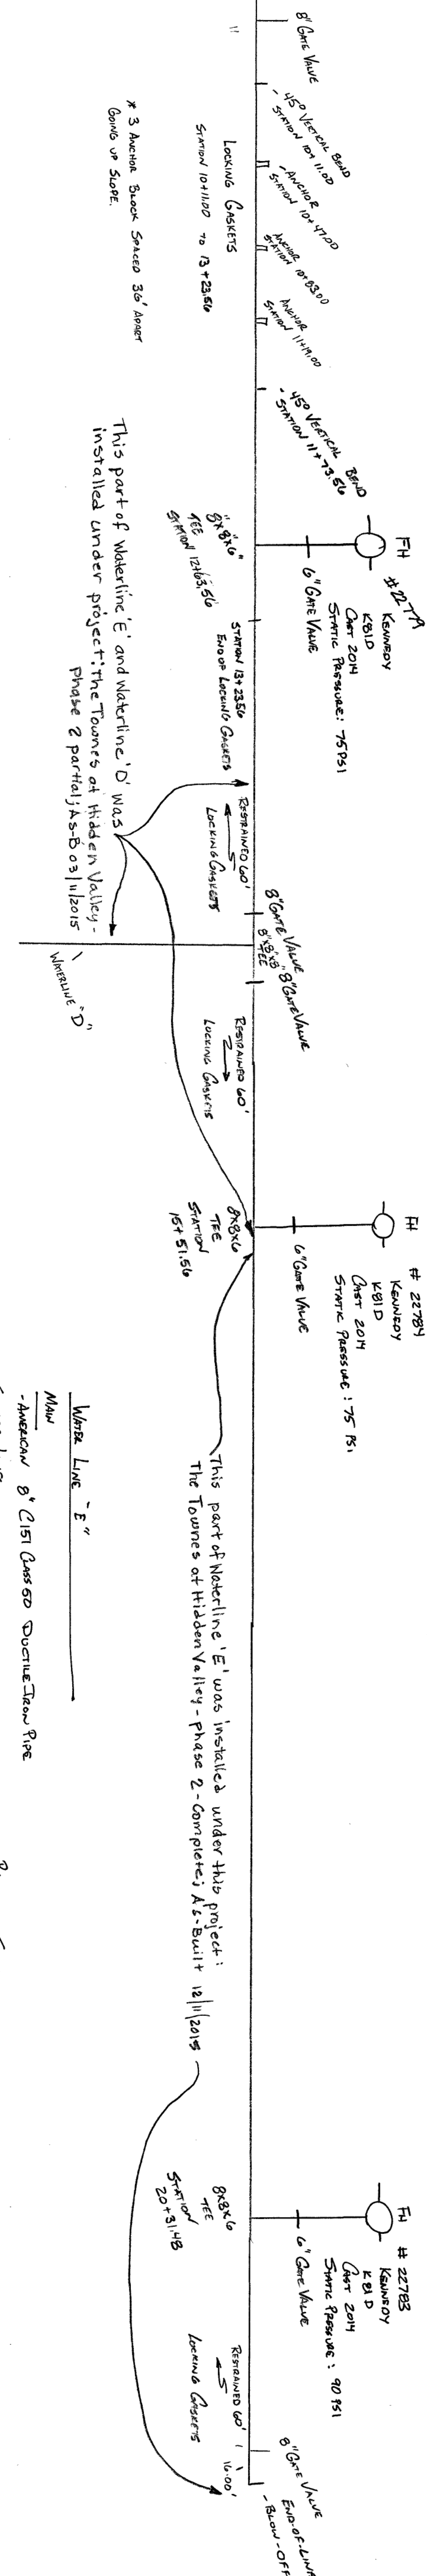

GENERAL WATER LINE NOTES
1. ALL WATER SERVICE LATERALS WILL REQUIRE PRESSURE REDUCING VALVES.