

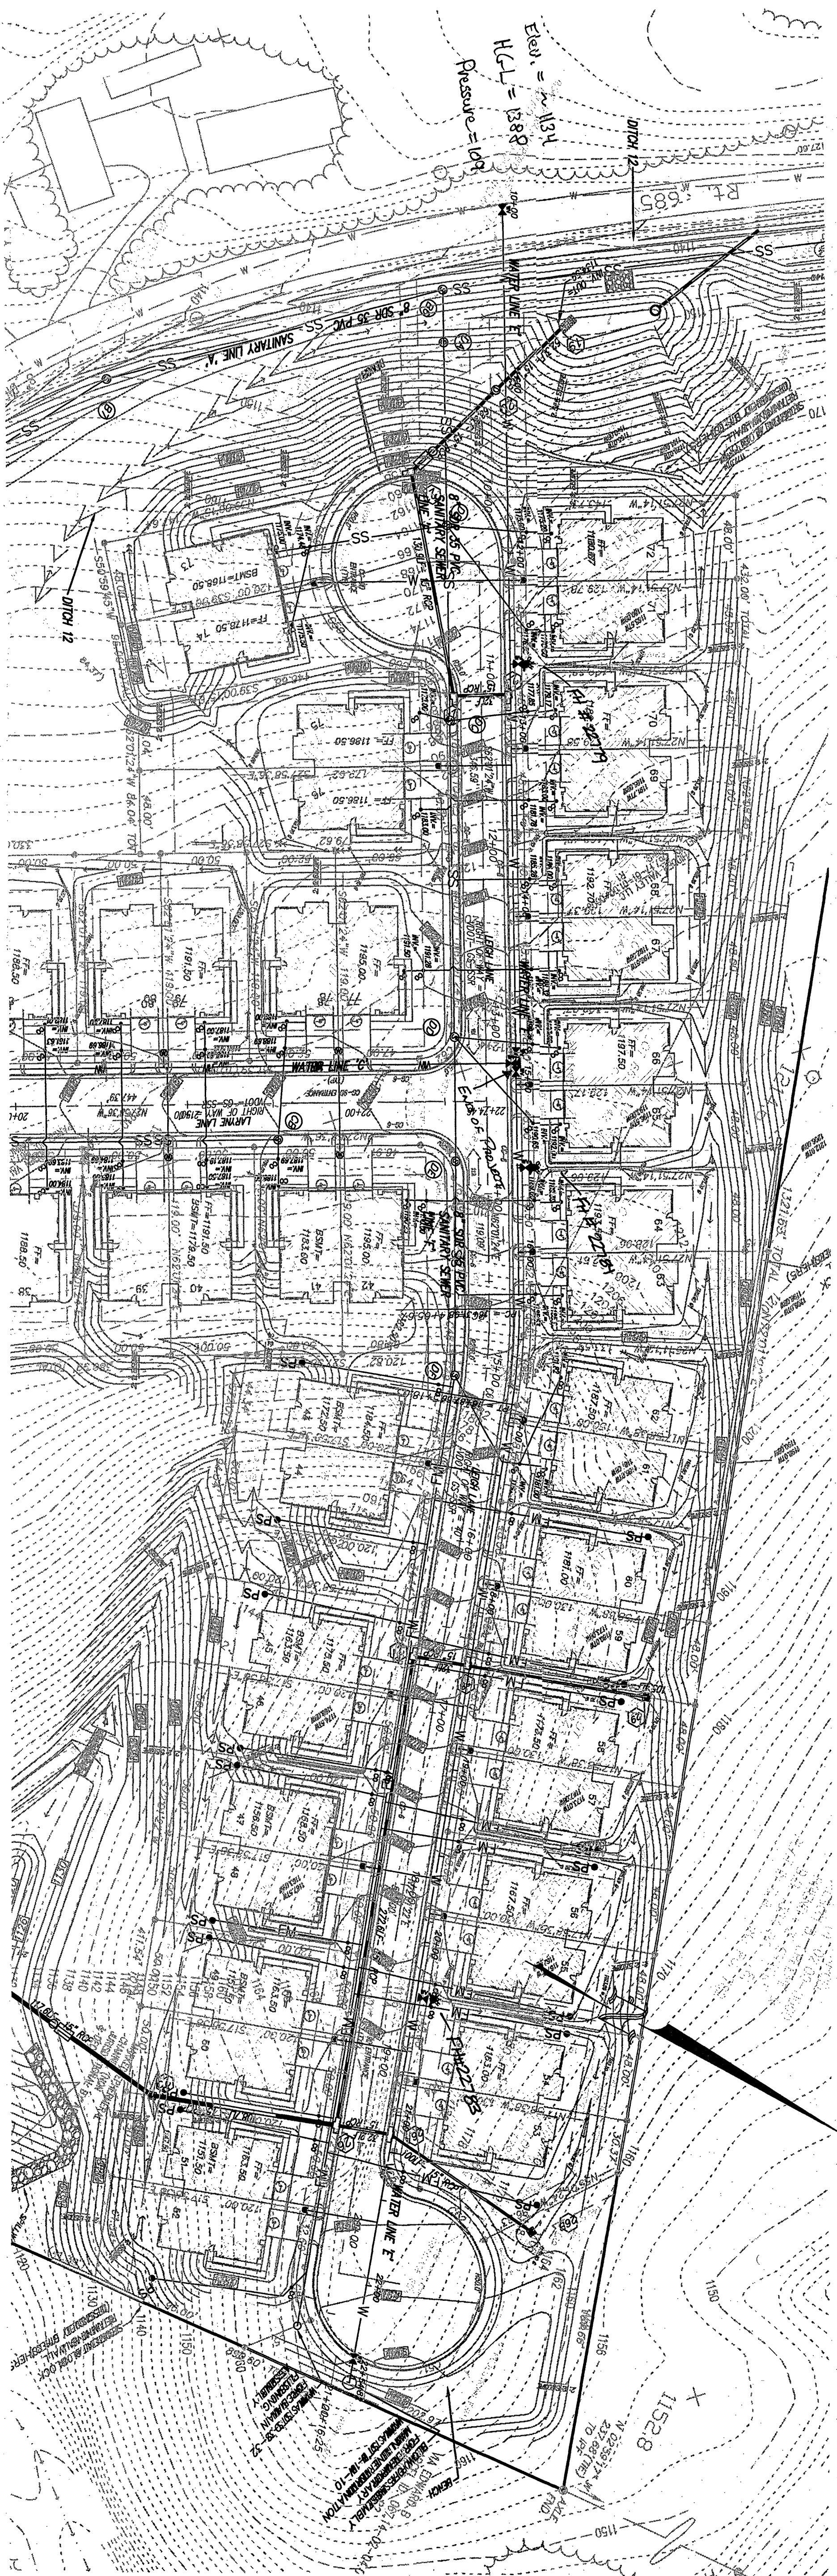


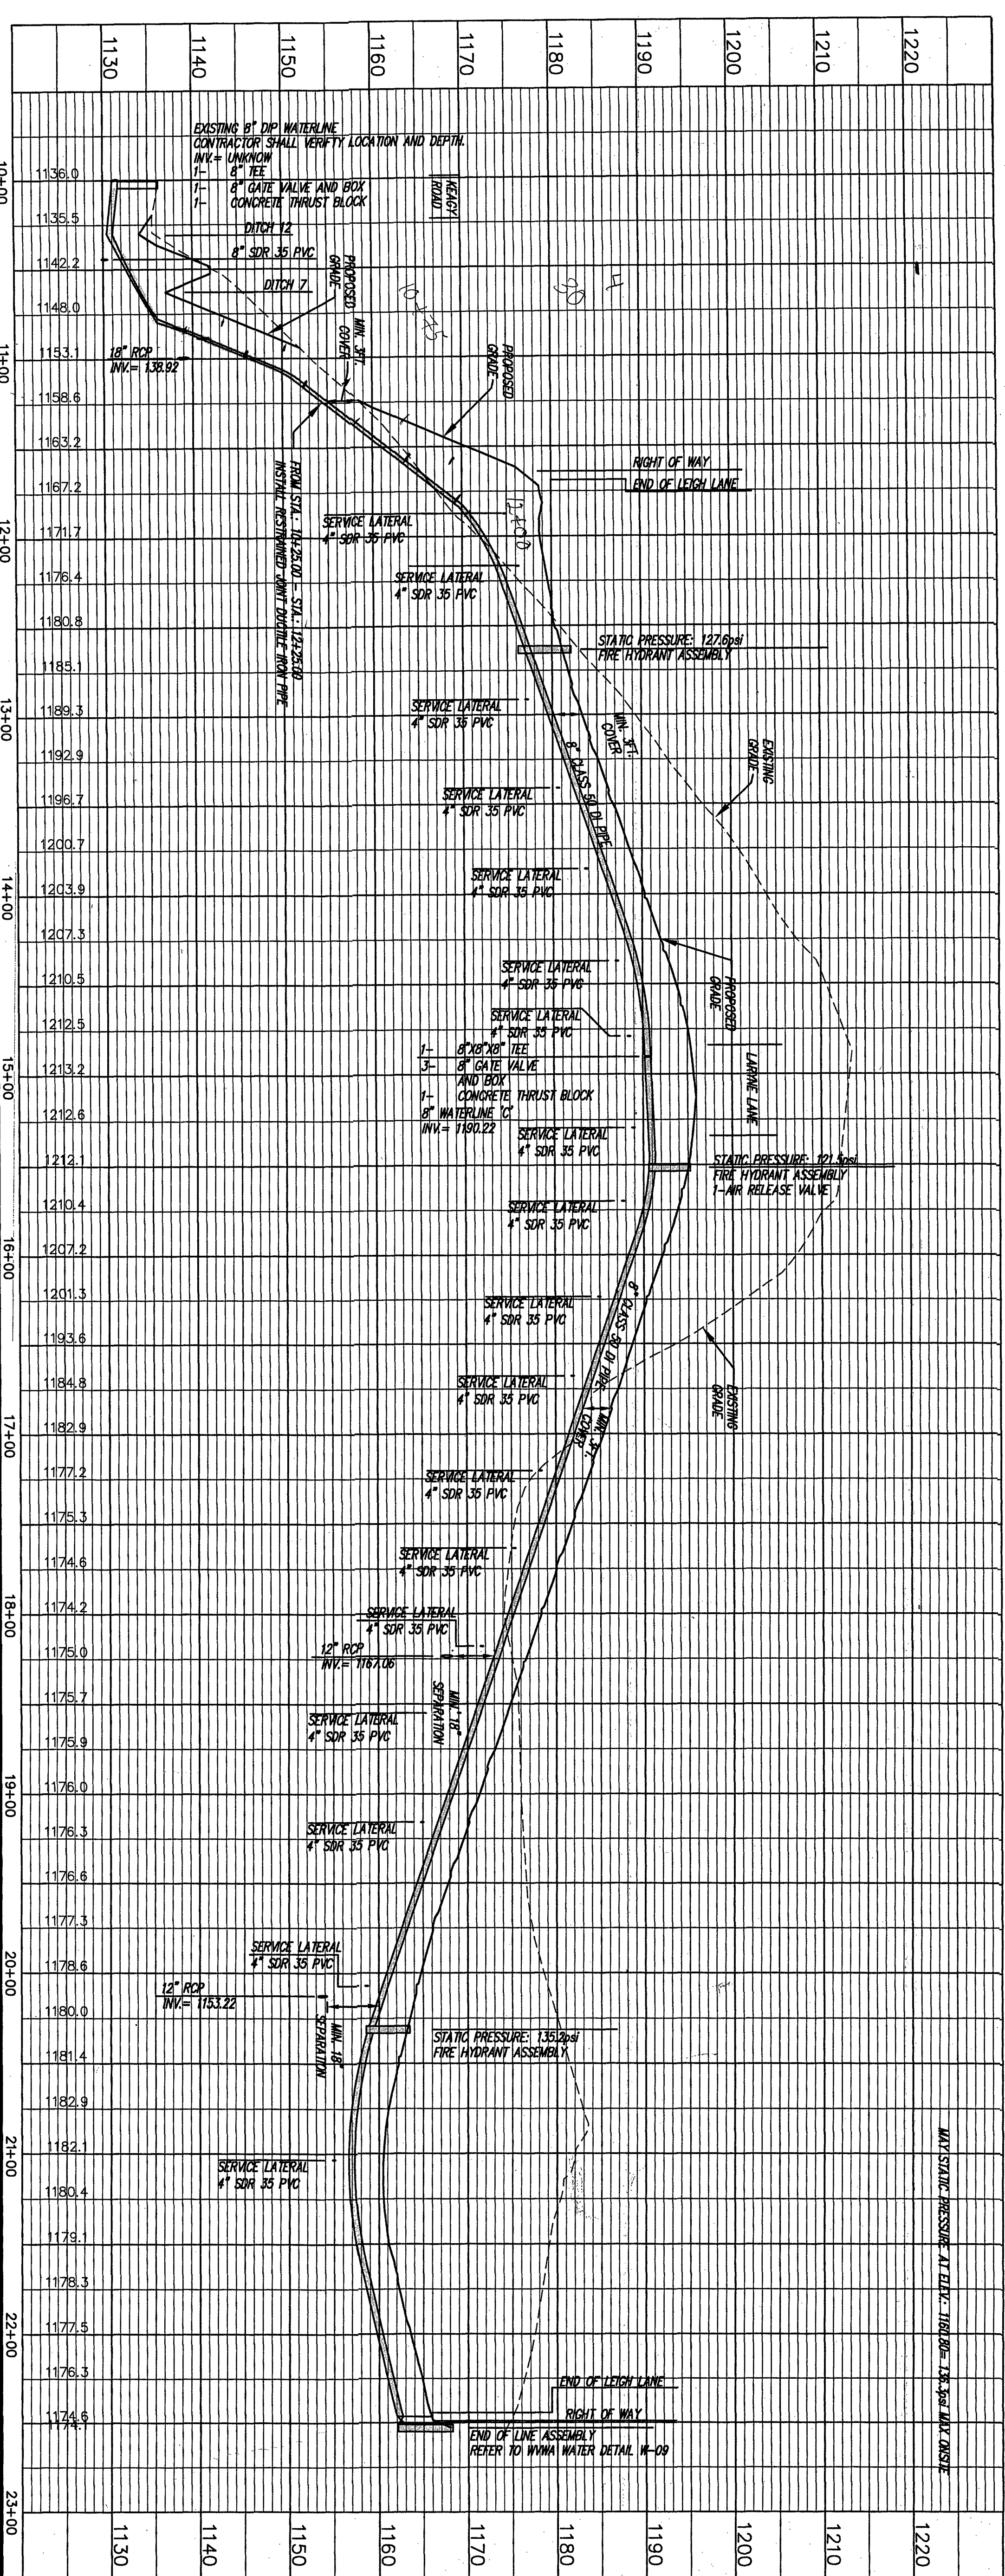


WATER LINE 'E'
8" CLASS 50 DI PIPE

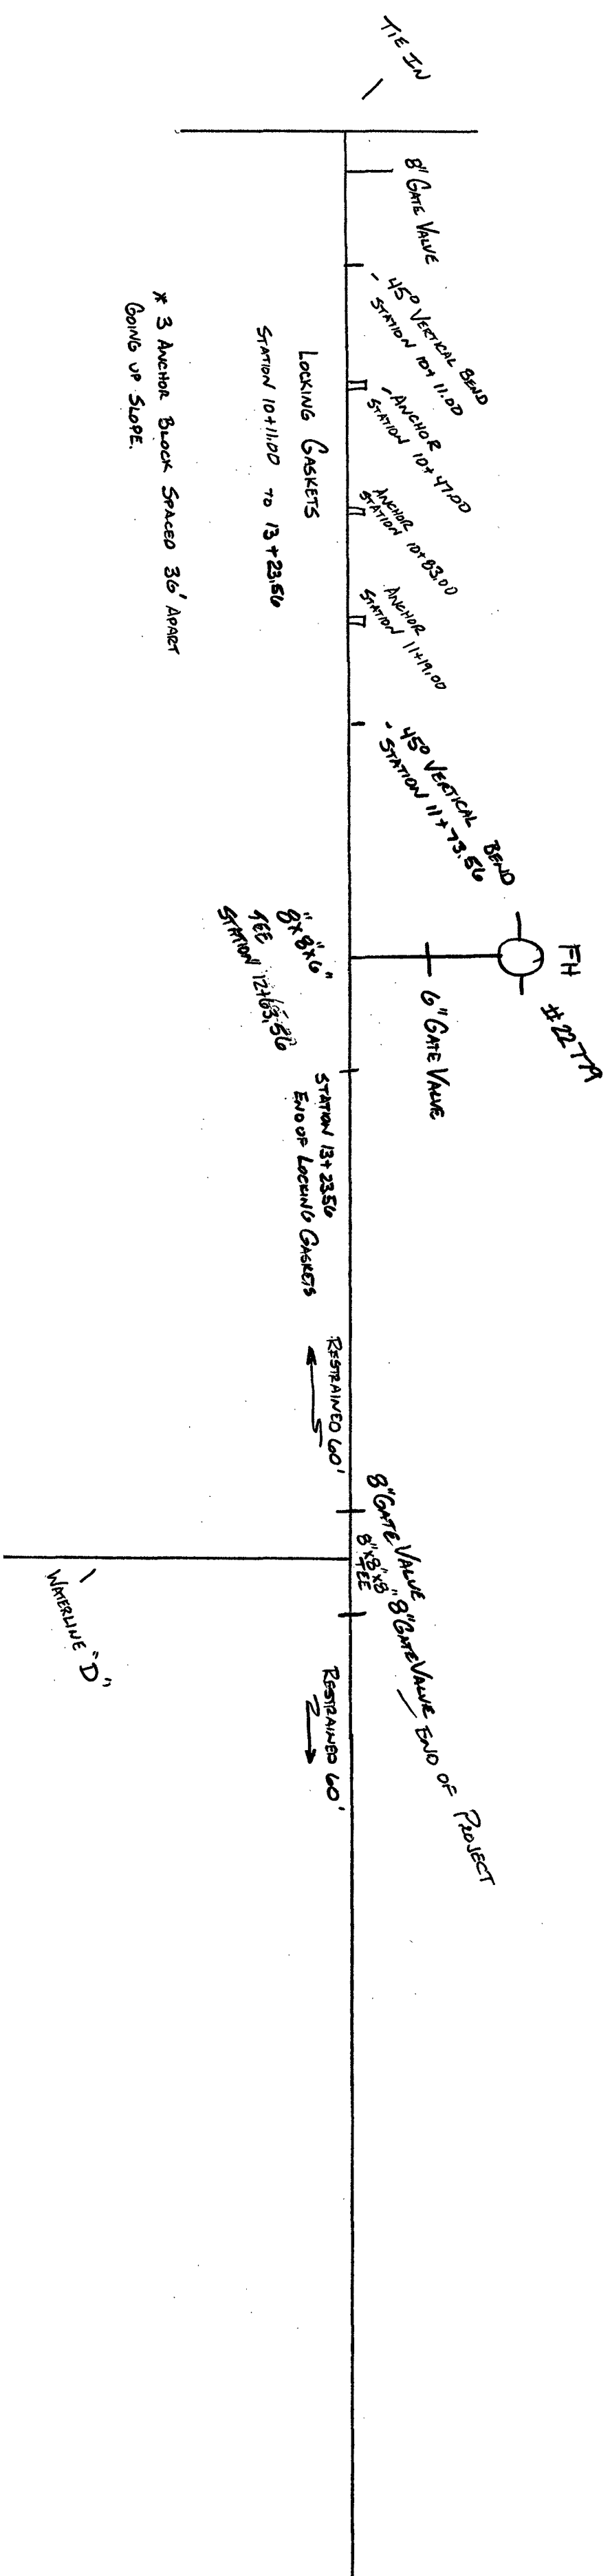


TESTED FROM 8° GAZE VALUE AT STA. 10+00.00 TO 8° GAZE VALUE AT STA. 14+90.86 ON 07-07-14. LANE POSTED, WARNING E."

GENERAL WATER LINE NOTES:
1. ALL WATER SERVICE LATERALS WILL REQUIRE PRESSURE REDUCING VALVES.

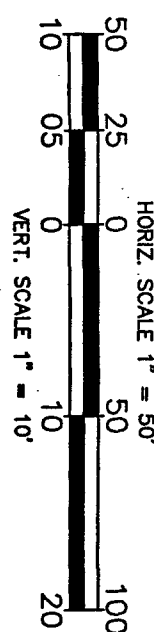

PROVE

- REVISION
1. PER COUNTY COMMENTS
2. 10/03/07, PER VDOT AND
PER COUNTY COMMENTS
3. 11/06/07, PER COUNTY
COMMENTS
4. 12/14/07, PER VDOT
COMMENTS
5. 11/20/09, ADDED PHASE 1
AND PHASE 2 LINES TO PLAN
6. 08/12/13, PHASE 2

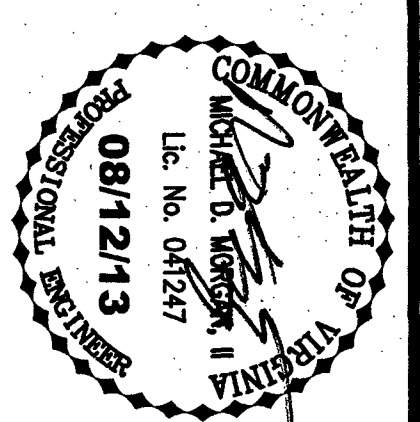

MME PROJECT NUMBER
2006-125


DRAWN BY:	CHECK BY:
DLC	MDM
DATE	ISSUE
02/03/2017	04/03/2017

SHEET TITLE
WATERLINE E
PLAN AND PROFILE

SHEET NO.

29 OF 44

MIKE MORGAN ENGINEERING, LLC.
14350 SOMMERVILLE COURT
MIDLOTHIAN, VA 23113
Office: 804.419.2559
Fax: 804.419.2558

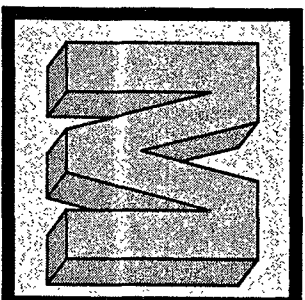

**SITE DEVELOPMENT PLAN
FOR
THE TOWNES AT HIDDEN VALLEY
WINDSOR HILLS DISTRICT, ROANOKE COUNTY, VIRGINIA**