



PROJECT MANAGER Brian Becker, P.E. (540) 387-5049
SURVEYED BY DATE Christopher B. Kokins, L.S. (540) 552-5592 (Hurtland, Prof. III)
ROADWAY DESIGN BY Brett Elledge, P.E. (540) 375-3580
HYDRAULICS DESIGN BY Ryan Fedak, P.E. (540) 857-3349 (AECOM)
SUBSURFACE UTILITY BY DATE Gary Campbell, P.E. (757) 499-1895 (JMT, Inc.)
UTILITY DESIGN BY Whitman Requardt & Associates, LLP (540) 951-3727

UTILITY PLAN, WATER

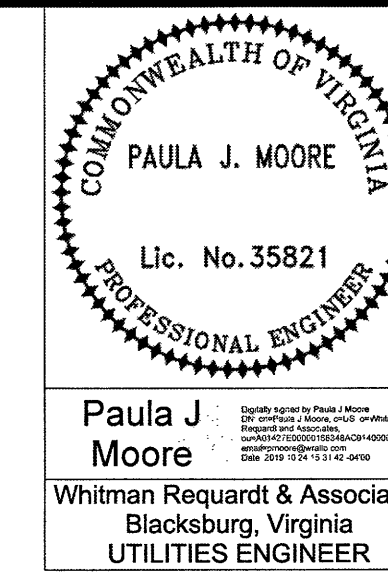

REVISED	STATE	ROUTE	PROJECT	SHEET NO.
	VA.	419	0419-080-876, C501	8(3)

DESIGN FEATURES RELATING TO CONSTRUCTION OR TO REGULATION AND CONTROL OF TRAFFIC MAY BE SUBJECT TO CHANGE AS DEEMED NECESSARY BY THE DEPARTMENT

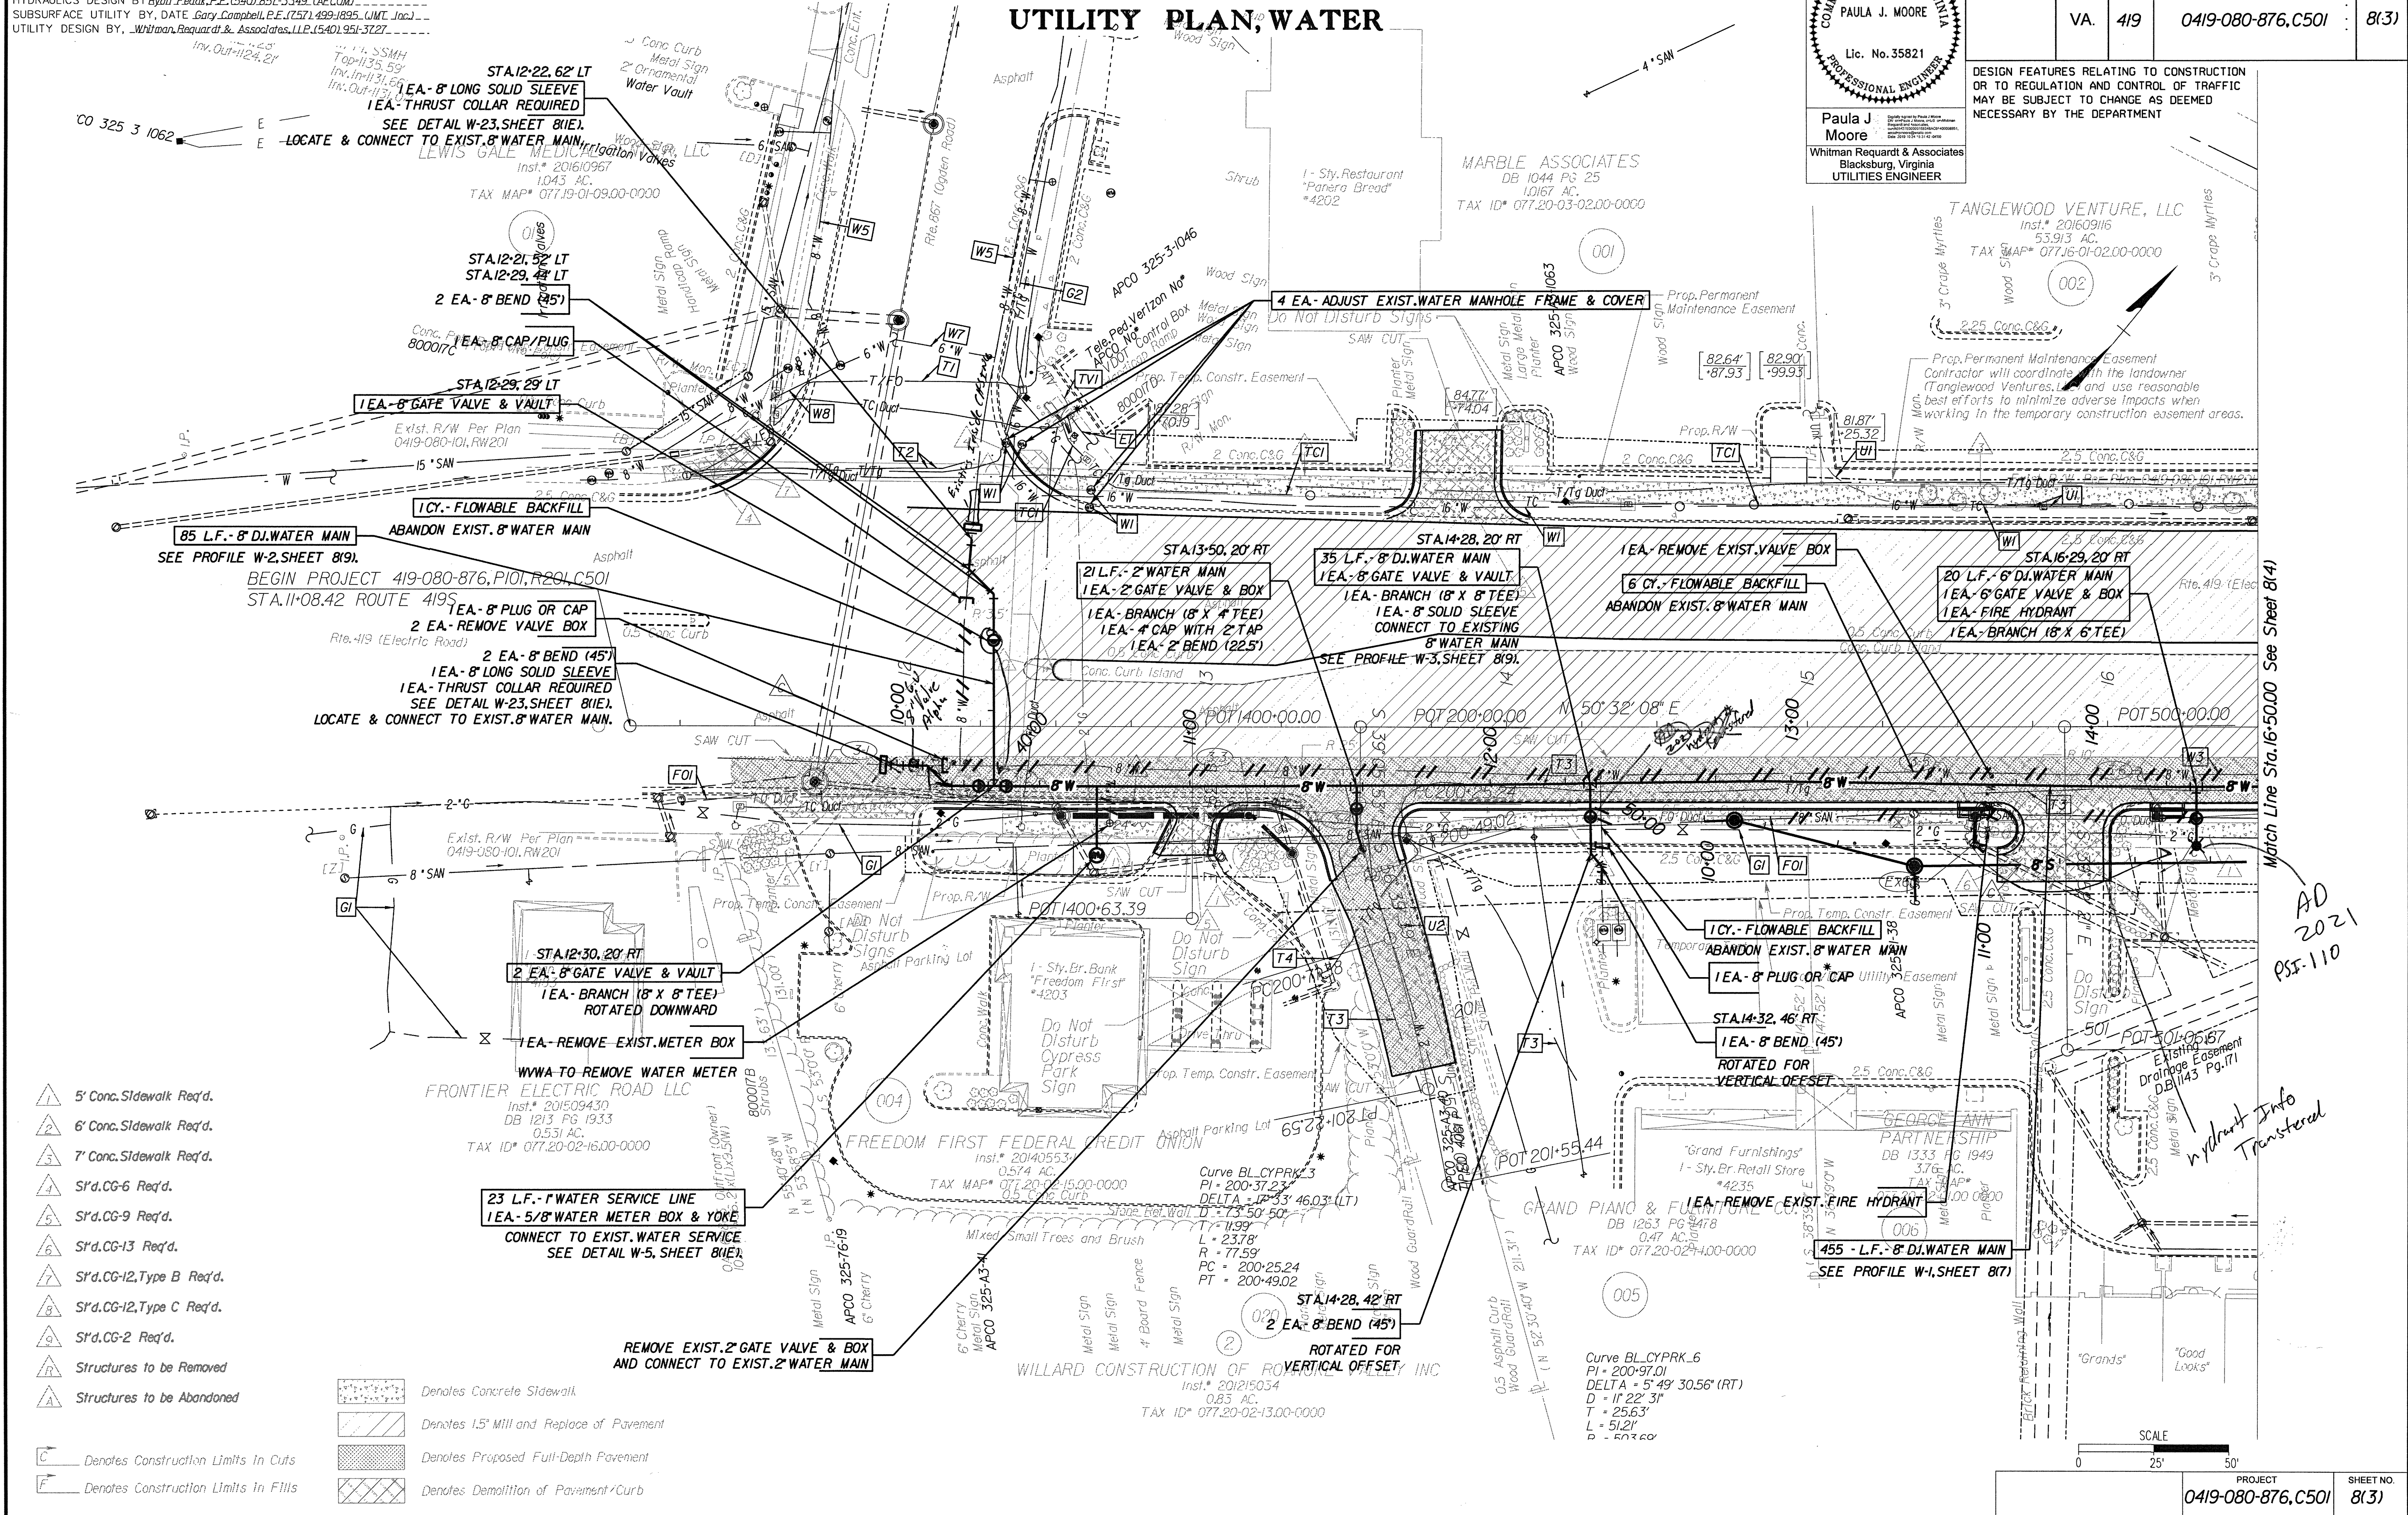

THIS SHEET FOR UTILITY ADJUSTMENT/RELOCATION ONLY