


PROJECT MANAGER: Brian Becker, P.E. (540) 387-5049
SURVEYED BY: DATE: Christopher B. Kohns, L.S. (540) 552-5592 (Hurtland Prof'l)
ROADWAY DESIGN BY: DATE: Christopher B. Kohns, P.E. (540) 552-5592
HYDRAULICS DESIGN BY: DATE: Fredrick P.E. (540) 857-3349 (AFCCOM)
SUBSURFACE UTILITY BY: DATE: Gary Campbell, P.E. (757) 499-1836 (UMT Inc.)
UTILITY DESIGN BY: Whitman Requaardt & Associates, LLP (540) 951-3127

Line Table		
L9	S 40°18'5" E	45.00'
L10	S 49°40'55" W	40.00'
L11	N 40°19'5" W	45.00'


UTILITY PLAN, SANITARY SEWER

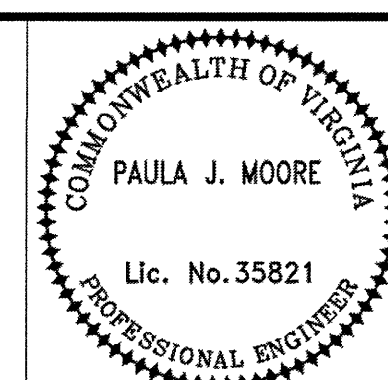

Paula J. Moore
Whitman Requaardt & Associates
Blacksburg, Virginia
UTILITIES ENGINEER

REVISED	STATE	ROUTE	PROJECT	SHEET NO.
03/31/2020	VA.	419	0419-080-876.C501	8(4A)

DESIGN FEATURES RELATING TO CONSTRUCTION OR TO REGULATION AND CONTROL OF TRAFFIC MAY BE SUBJECT TO CHANGE AS DEEMED NECESSARY BY THE DEPARTMENT

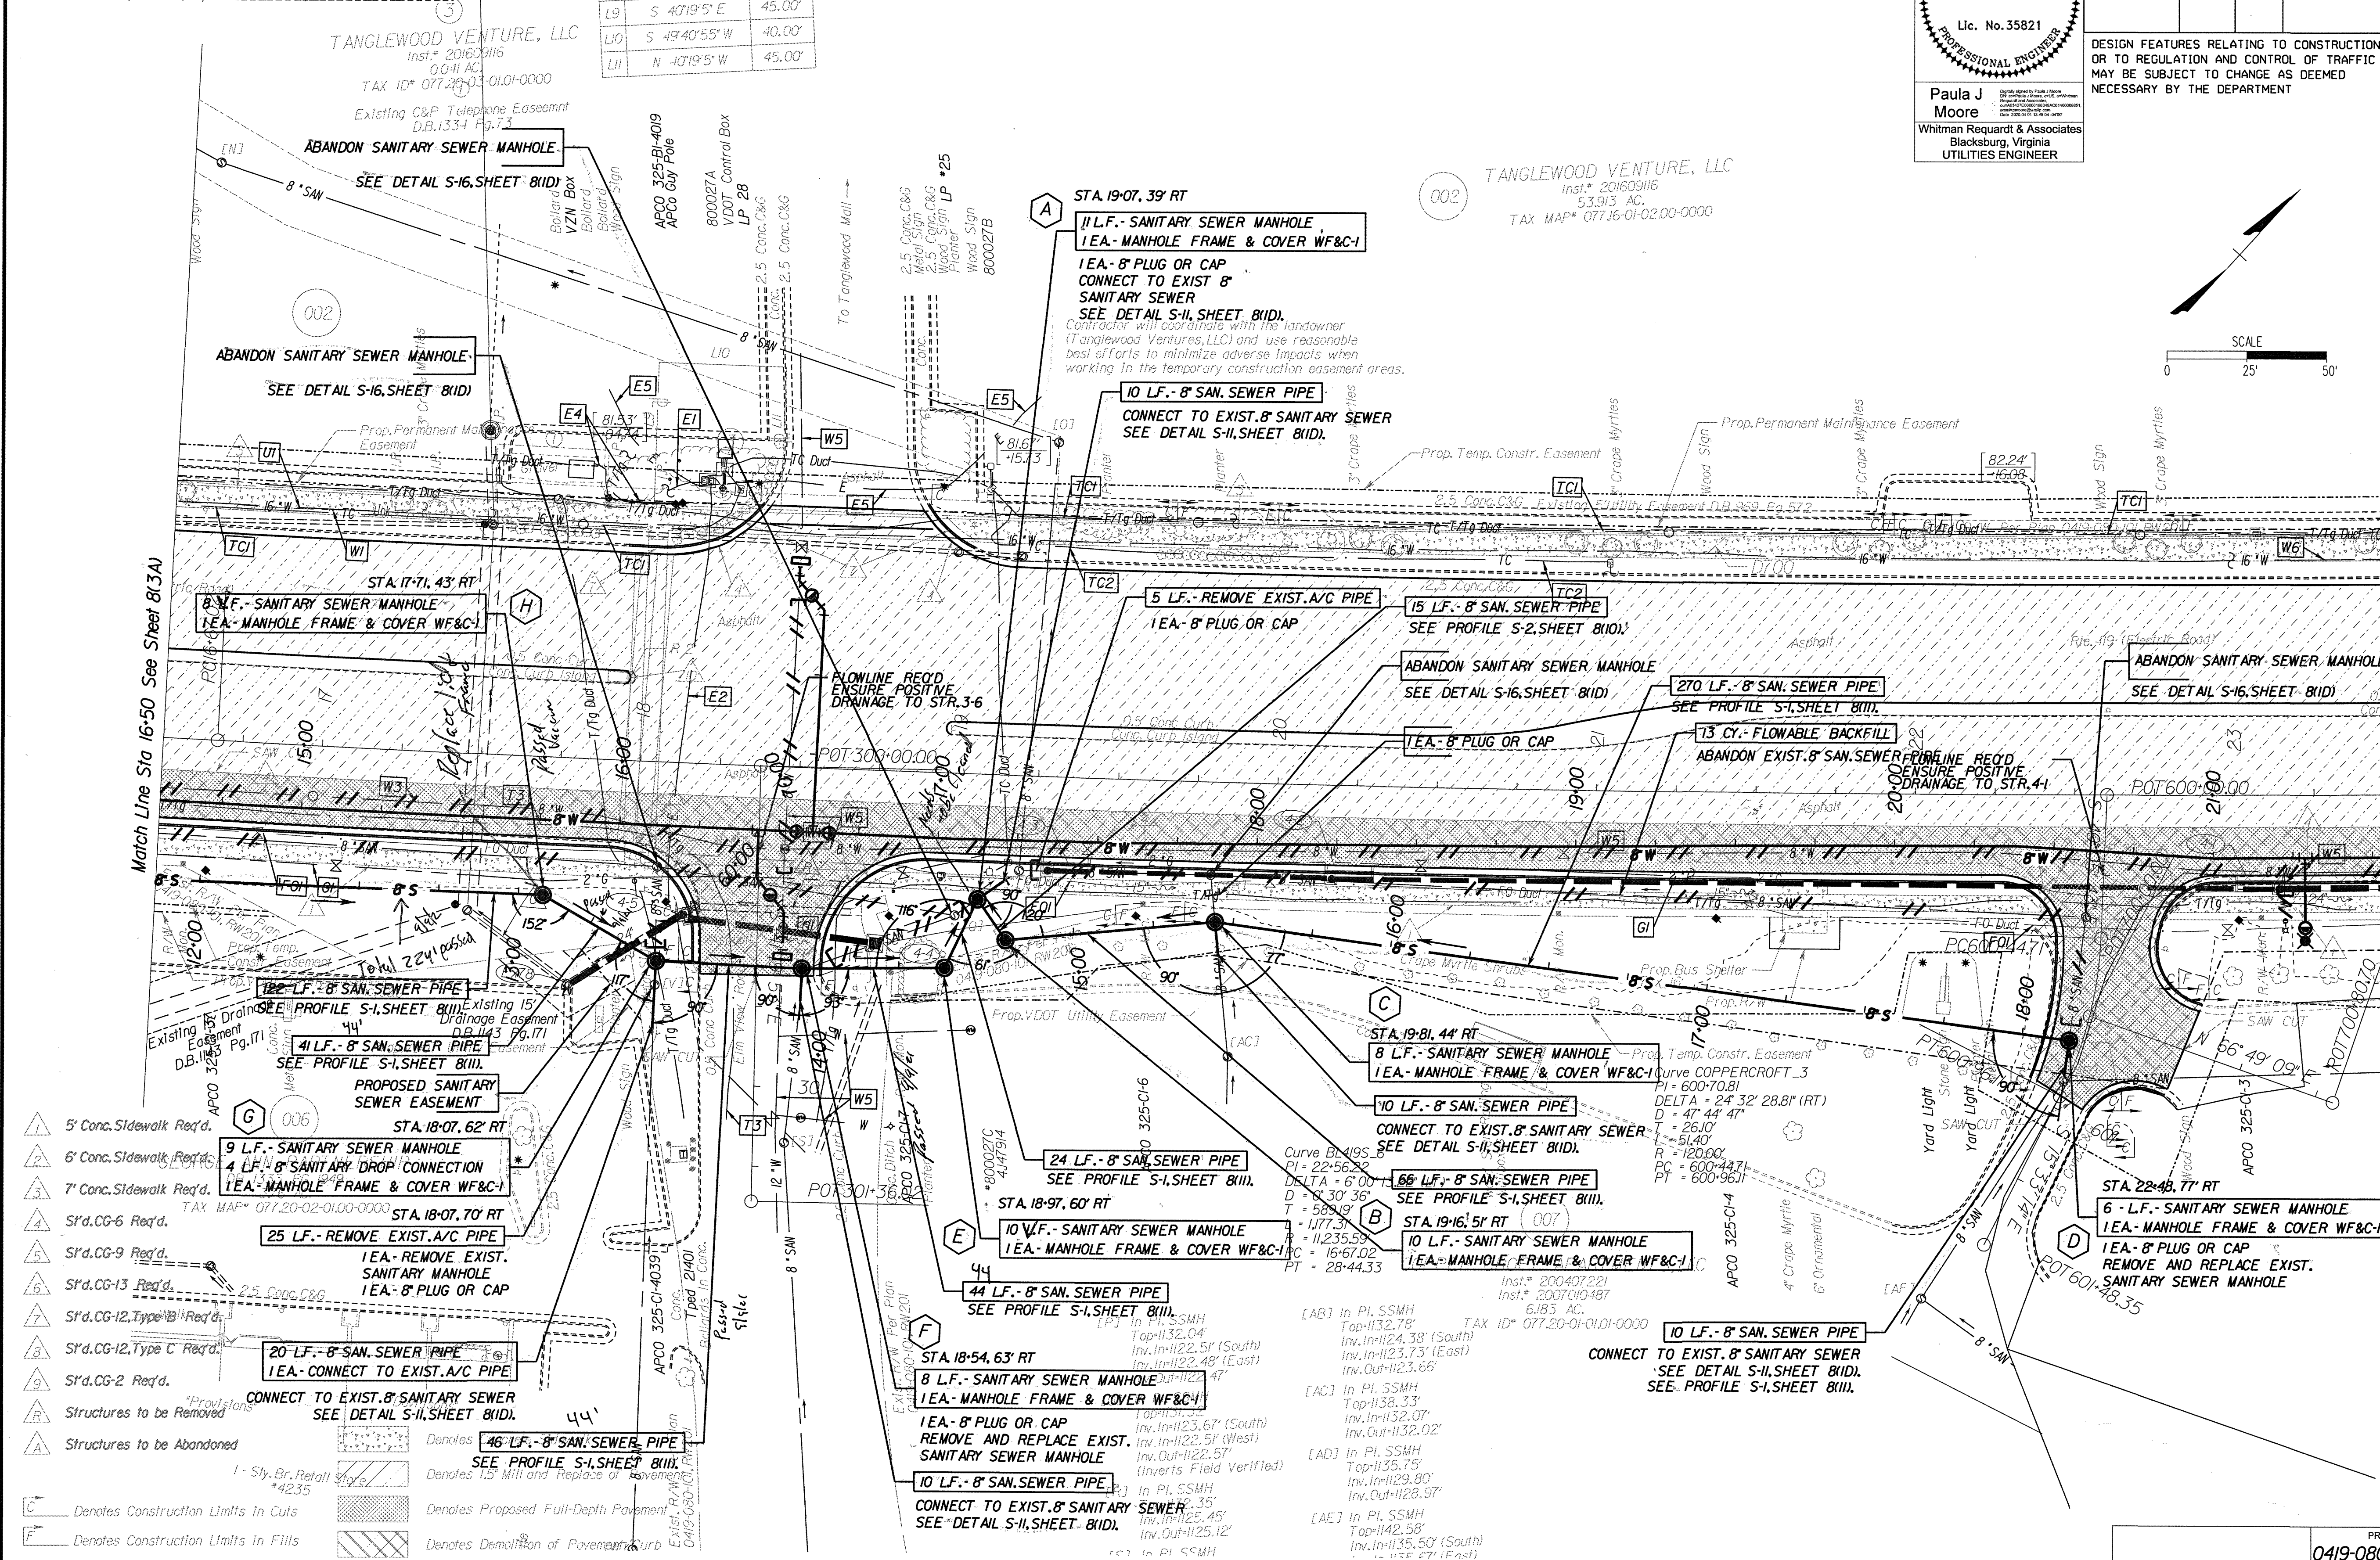

Match Line Sta 16+50 See Sheet 5

Match Line Sta 23+50 See Sheet 5

PROJECT	SHEET NO.
0419-080-876.C501	8(4A)

THIS SHEET FOR UTILITY ADJUSTMENT/RELOCATION ONLY