


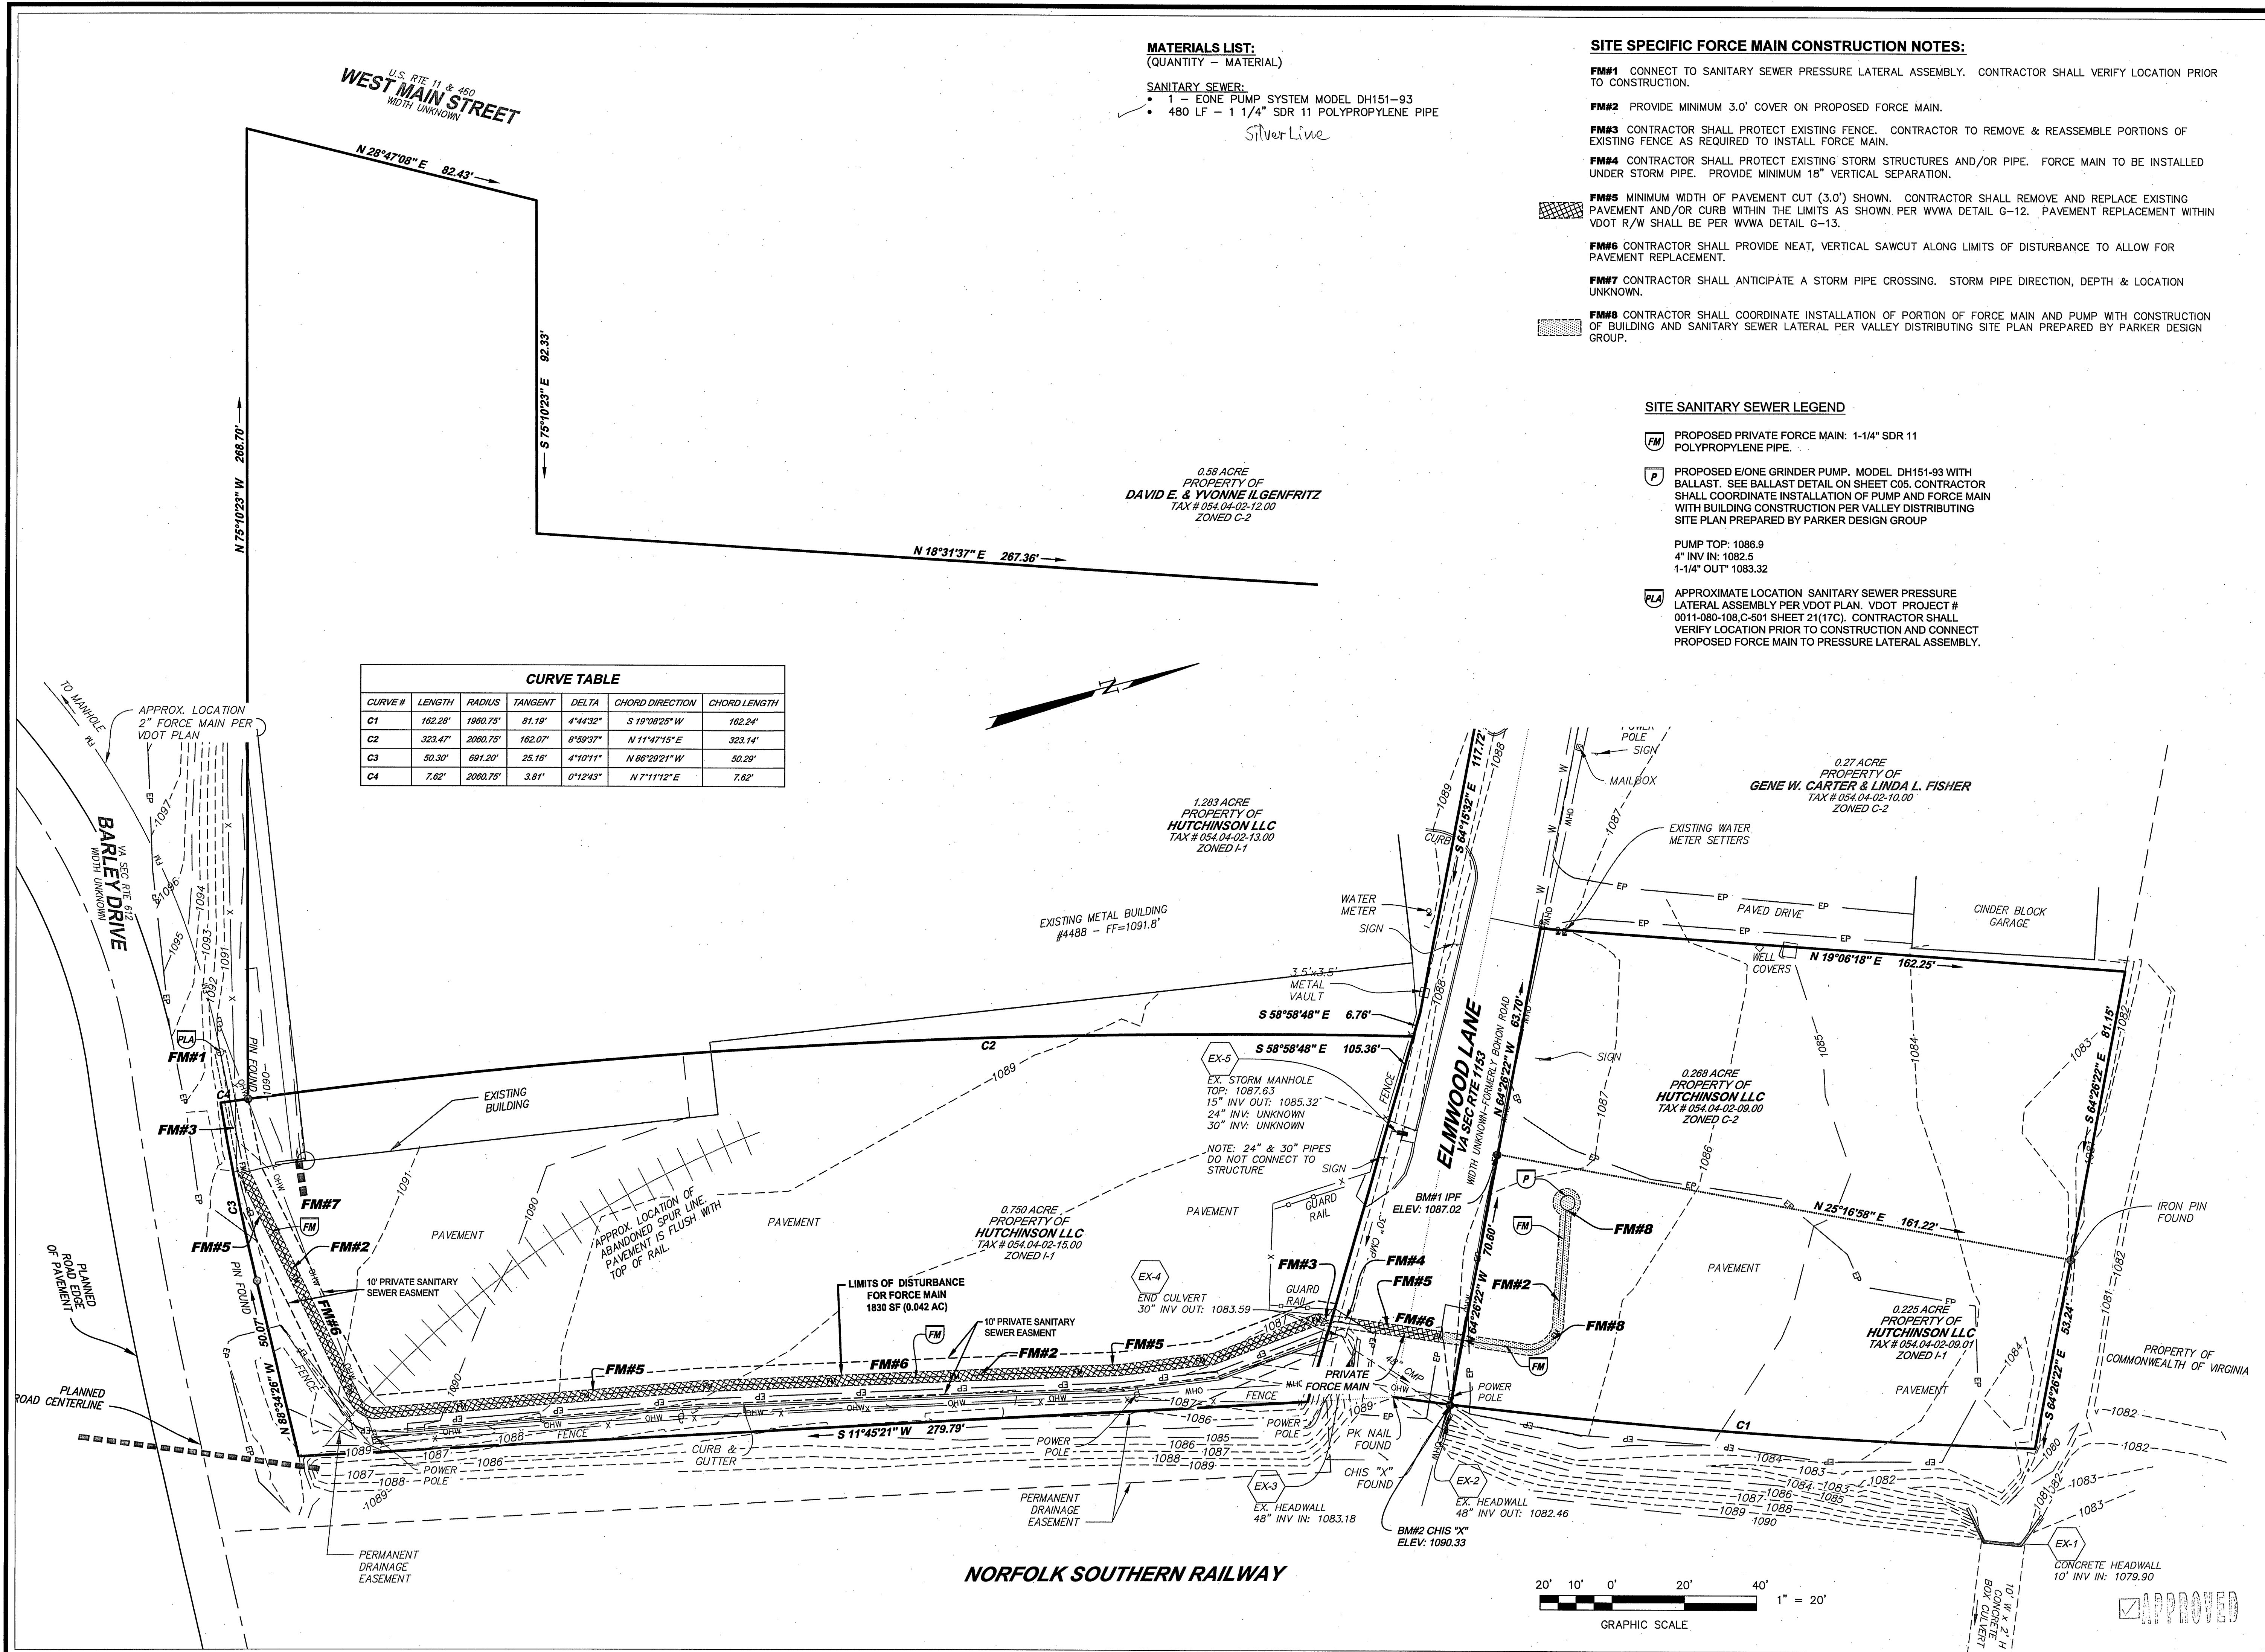

**parker**  
DESIGN GROUP

ENGINEERS & SURVEYORS & PLANNERS & LANDSCAPE ARCHITECTS

816 Boulevard  
Salem, VA 24153  
Ph: 540-387-1153  
Fax: 540-389-5767

9 South Harvie Street  
Richmond, VA 23220  
Phone: 804-358-2947  
Fax: 804-359-9645

www.parkergd.com

These documents are the property of Parker Design Group (PDG) and may not be reproduced or used without the express permission of PDG. Any reuse of these documents without authorization of PDG will be at the sole risk of the individual or entity utilizing said documents.

**Simon L. Rutledge**  
Lic. No. 050774  
2/19/2013  
PROFESSIONAL ENGINEER

**Valley Distributing Offsite Utility Plan**  
**4479 Elmwood Lane**  
**Prepared for Interactive Design Group**  
Tax No. 054.04-02-09.00 & 054.04-02-09.01  
Catawba Magisterial District, Roanoke County, Virginia

**REVISIONS:**

| NO. | DESCRIPTION                     | DATE             |
|-----|---------------------------------|------------------|
| 1   | Per County, WWA & VDOT Comments | 18 February 2013 |

**DESIGNED BY:** SLR

**DRAWN BY:** SLR

**CHECKED BY:** SRB

**SCALE:** 1" = 20'

**DATE:** 18 January 2013

**SHEET TITLE:**

**Sanitary Sewer Force Main**

**C04**  
04 OF 06  
PROJECT NUMBER:  
12-0079-03