


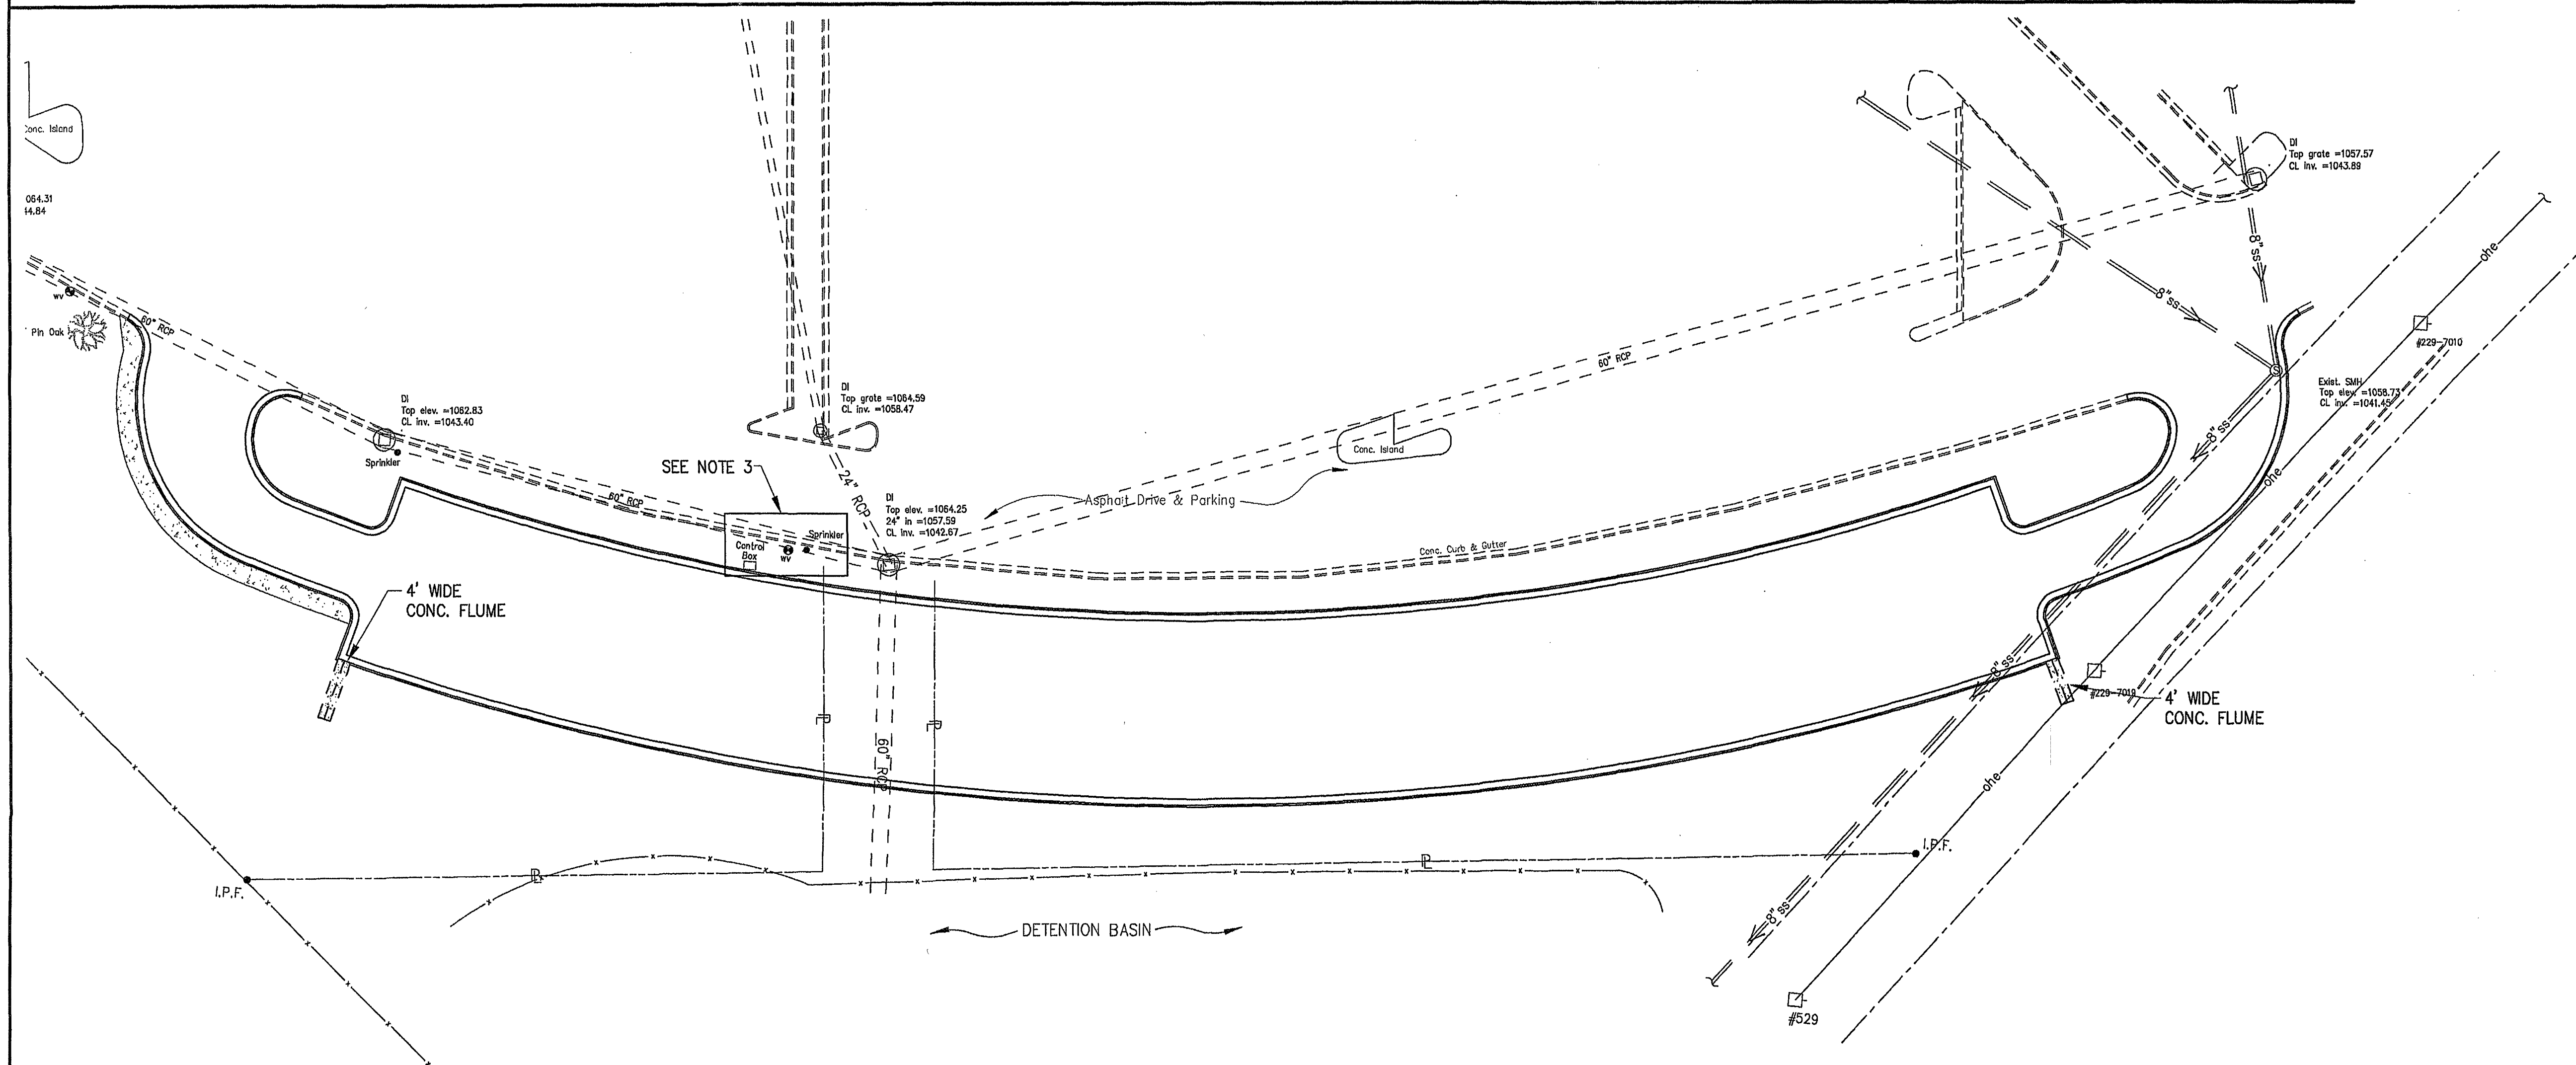

- [1]** EXISTING UNDERGROUND ELECTRICAL LINES (PRIMARY SERVICE) TO BE RELOCATED BY A.E.P.
- [2]** SITE CONTRACTOR TO LOCATE EXISTING 10" RL AND RE-ROUTE/ CONSTRUCT THE NEW LINE AS SHOWN.
- [3]** SITE CONTRACTOR SHALL CONSTRUCT NEW LIGHT FOUNDATION & ERECT EXISTING POLES & FIXTURES, AND REWIRE LIGHTING CIRCUITS TO PROVIDE POWER TO RELOCATED LIGHTS.

Commission No.: 1912	Drawn By: MRL/ARB Designed By: MRL	Checked By: WTA Date:
-------------------------	---------------------------------------	--------------------------

Mattern & Craig
CONSULTING ENGINEERS • SURVEYORS

701 FIRST STREET, S.W.
ROANOKE, VIRGINIA 24016
(540) 345-9342
FAX (540) 345-7891

BELK EXPANSION AND PARKING ADDITION
UTILITY PLAN
VALLEY VIEW MALL, ROANOKE, VIRGINIA

Vertical Scale:

Horizontal Scale:

1"=30'

Issue Date:

NOVEMBER, 2000

Sheet No.:

C-5