


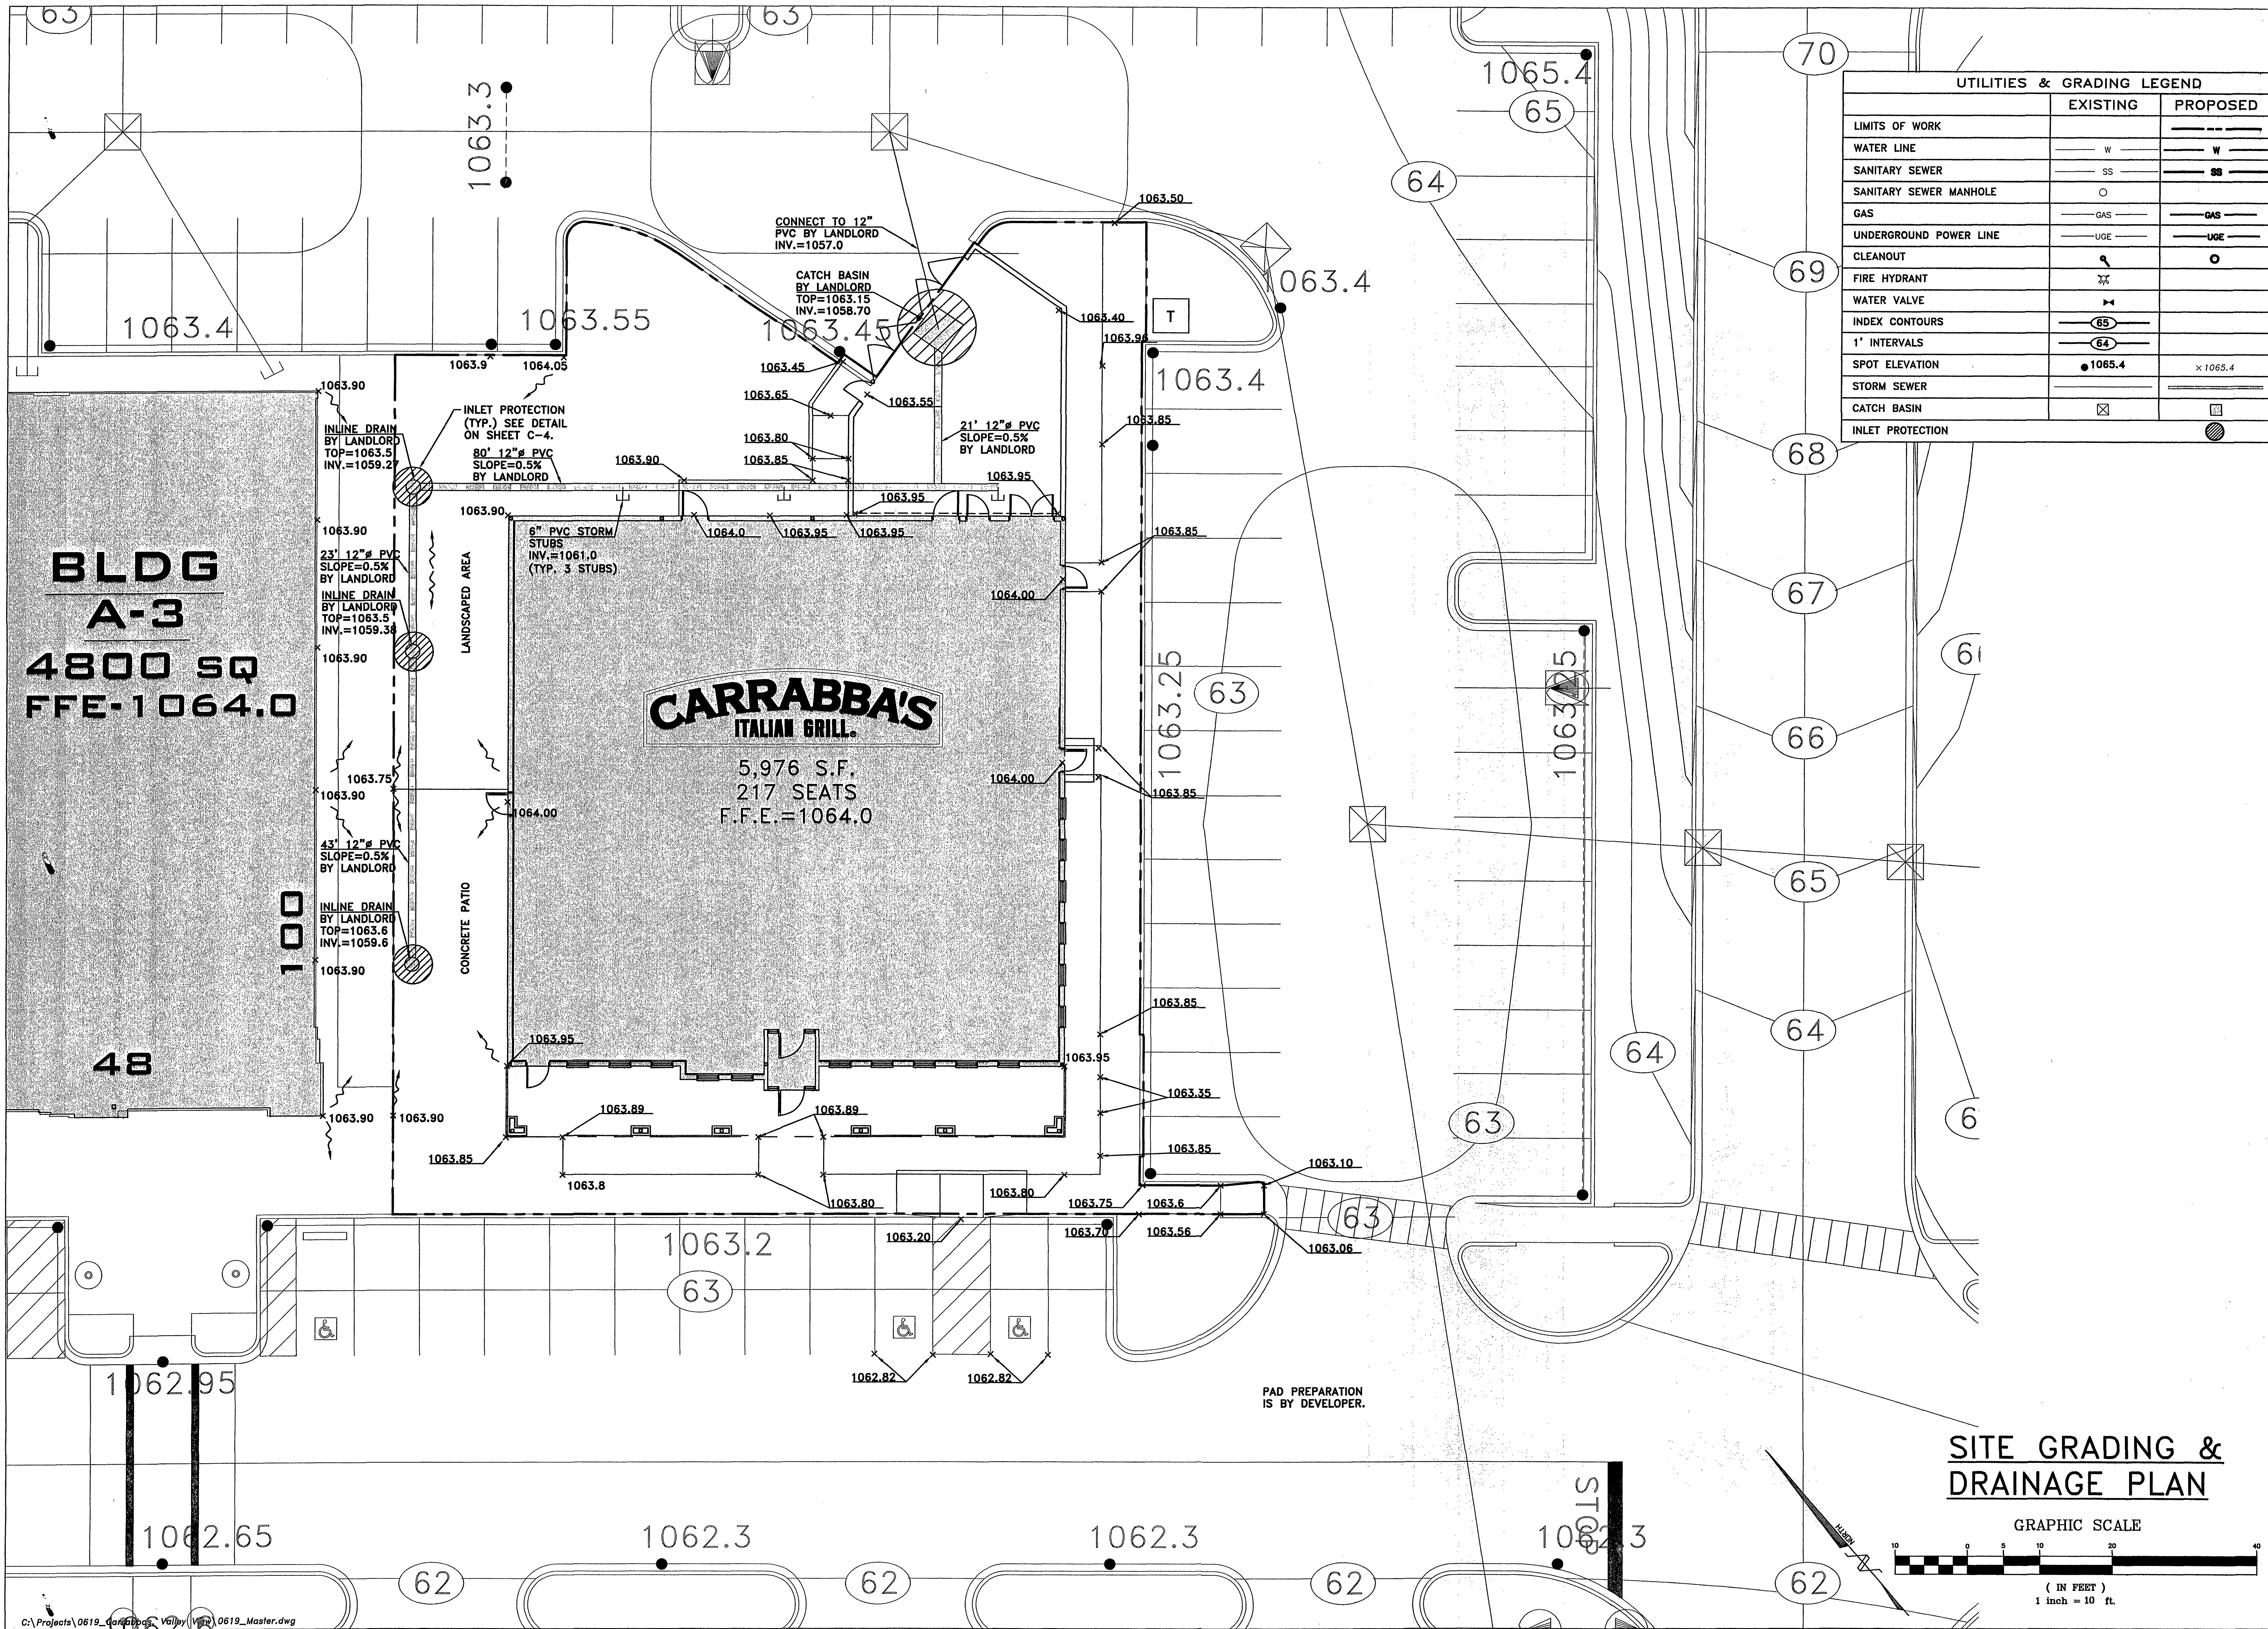

CIVIL ENGINEER:

MILLER & MCCOY, INC.
CONSULTING ENGINEERS
CORPORATE OFFICE: CHATTANOOGA, TN 37406
PHONE: (423) 688-2861

ARCHITECT:

CARRABBA'S ITALIAN GRILL
THE DISTRICT AT VALLEY VIEW MALL
ROANOKE, VIRGINIA

PROJECT:

OUTBACK STEAKHOUSE
STACY MILLER
2202 NORTH WEST SHORE BLVD
5TH FLOOR
TAMPA, FL 33607
813-282-1225

UTILITIES & GRADING LEGEND		
LIMITS OF WORK	EXISTING	PROPOSED
WATER LINE	— W —	— W —
SANITARY SEWER	— SS —	— SS —
SANITARY SEWER MANHOLE	○	○
GAS	— GAS —	— GAS —
UNDERGROUND POWER LINE	— UGE —	— UGE —
CLEANOUT	— C —	— C —
FIRE HYDRANT	— FH —	— FH —
WATER VALVE	— W —	— W —
INDEX CONTOURS	— 65 —	— 65 —
1' INTERVALS	— 64 —	— 64 —
SPOT ELEVATION	● 1065.4	× 1065.4
STORM SEWER	— S —	— S —
CATCH BASIN	— CB —	— CB —
INLET PROTECTION	— IP —	— IP —

REVISIONS

NO.	CITY COMMENTS	DATE
1		06/12/06
2		
3		
4		
5		
6		
7		
8		
9		
10		

SHEET NAME:
SITE GRADING & DRAINAGE PLAN

DATE: 05/08/06
DRAWN BY: BMB
CHECKED BY: RWM
PROJECT NO.: 0619
SHEET NUMBER:
C-2