




SITE UTILITY NOTES

1. THE SITE UTILITY PLAN: GAS, ELECTRICITY, & TELEPHONE COORDINATION IS TO AID IN DRY UTILITY COORDINATION ONLY. THIS PLAN IS NOT FOR CONSTRUCTION. EACH UTILITY COMPANY SHALL BE CONTACTED FOR THE CONSTRUCTION INFORMATION FOR THEIR RESPECTIVE UTILITY.
2. SEE SITE ELECTRICAL PLANS FOR SITE LIGHTING, CIRCUITING, ELECTRICAL CONDUIT, AND TELEPHONE CONDUIT INFORMATION.
3. UTILITY RELOCATIONS ARE TO BE MADE IN A WAY AS TO NOT INTERRUPT EXISTING SERVICES. IF SERVICES MUST BE INTERRUPTED, COORDINATE THE CONNECTION TIME WITH THE CITY, UTILITY COMPANY, AND MALL MANAGEMENT.
4. ALL EXISTING MANHOLE TOPS, CLEANOUT COVERS, VALVE COVERS, ETC. SHALL BE ADJUSTED TO MATCH FINISHED GRADE.
5. ELECTRIC PRIMARY ROUTING HAS BEEN DESIGNED AND APPROVED BY APPALACHIAN ENERGY COMPANY.

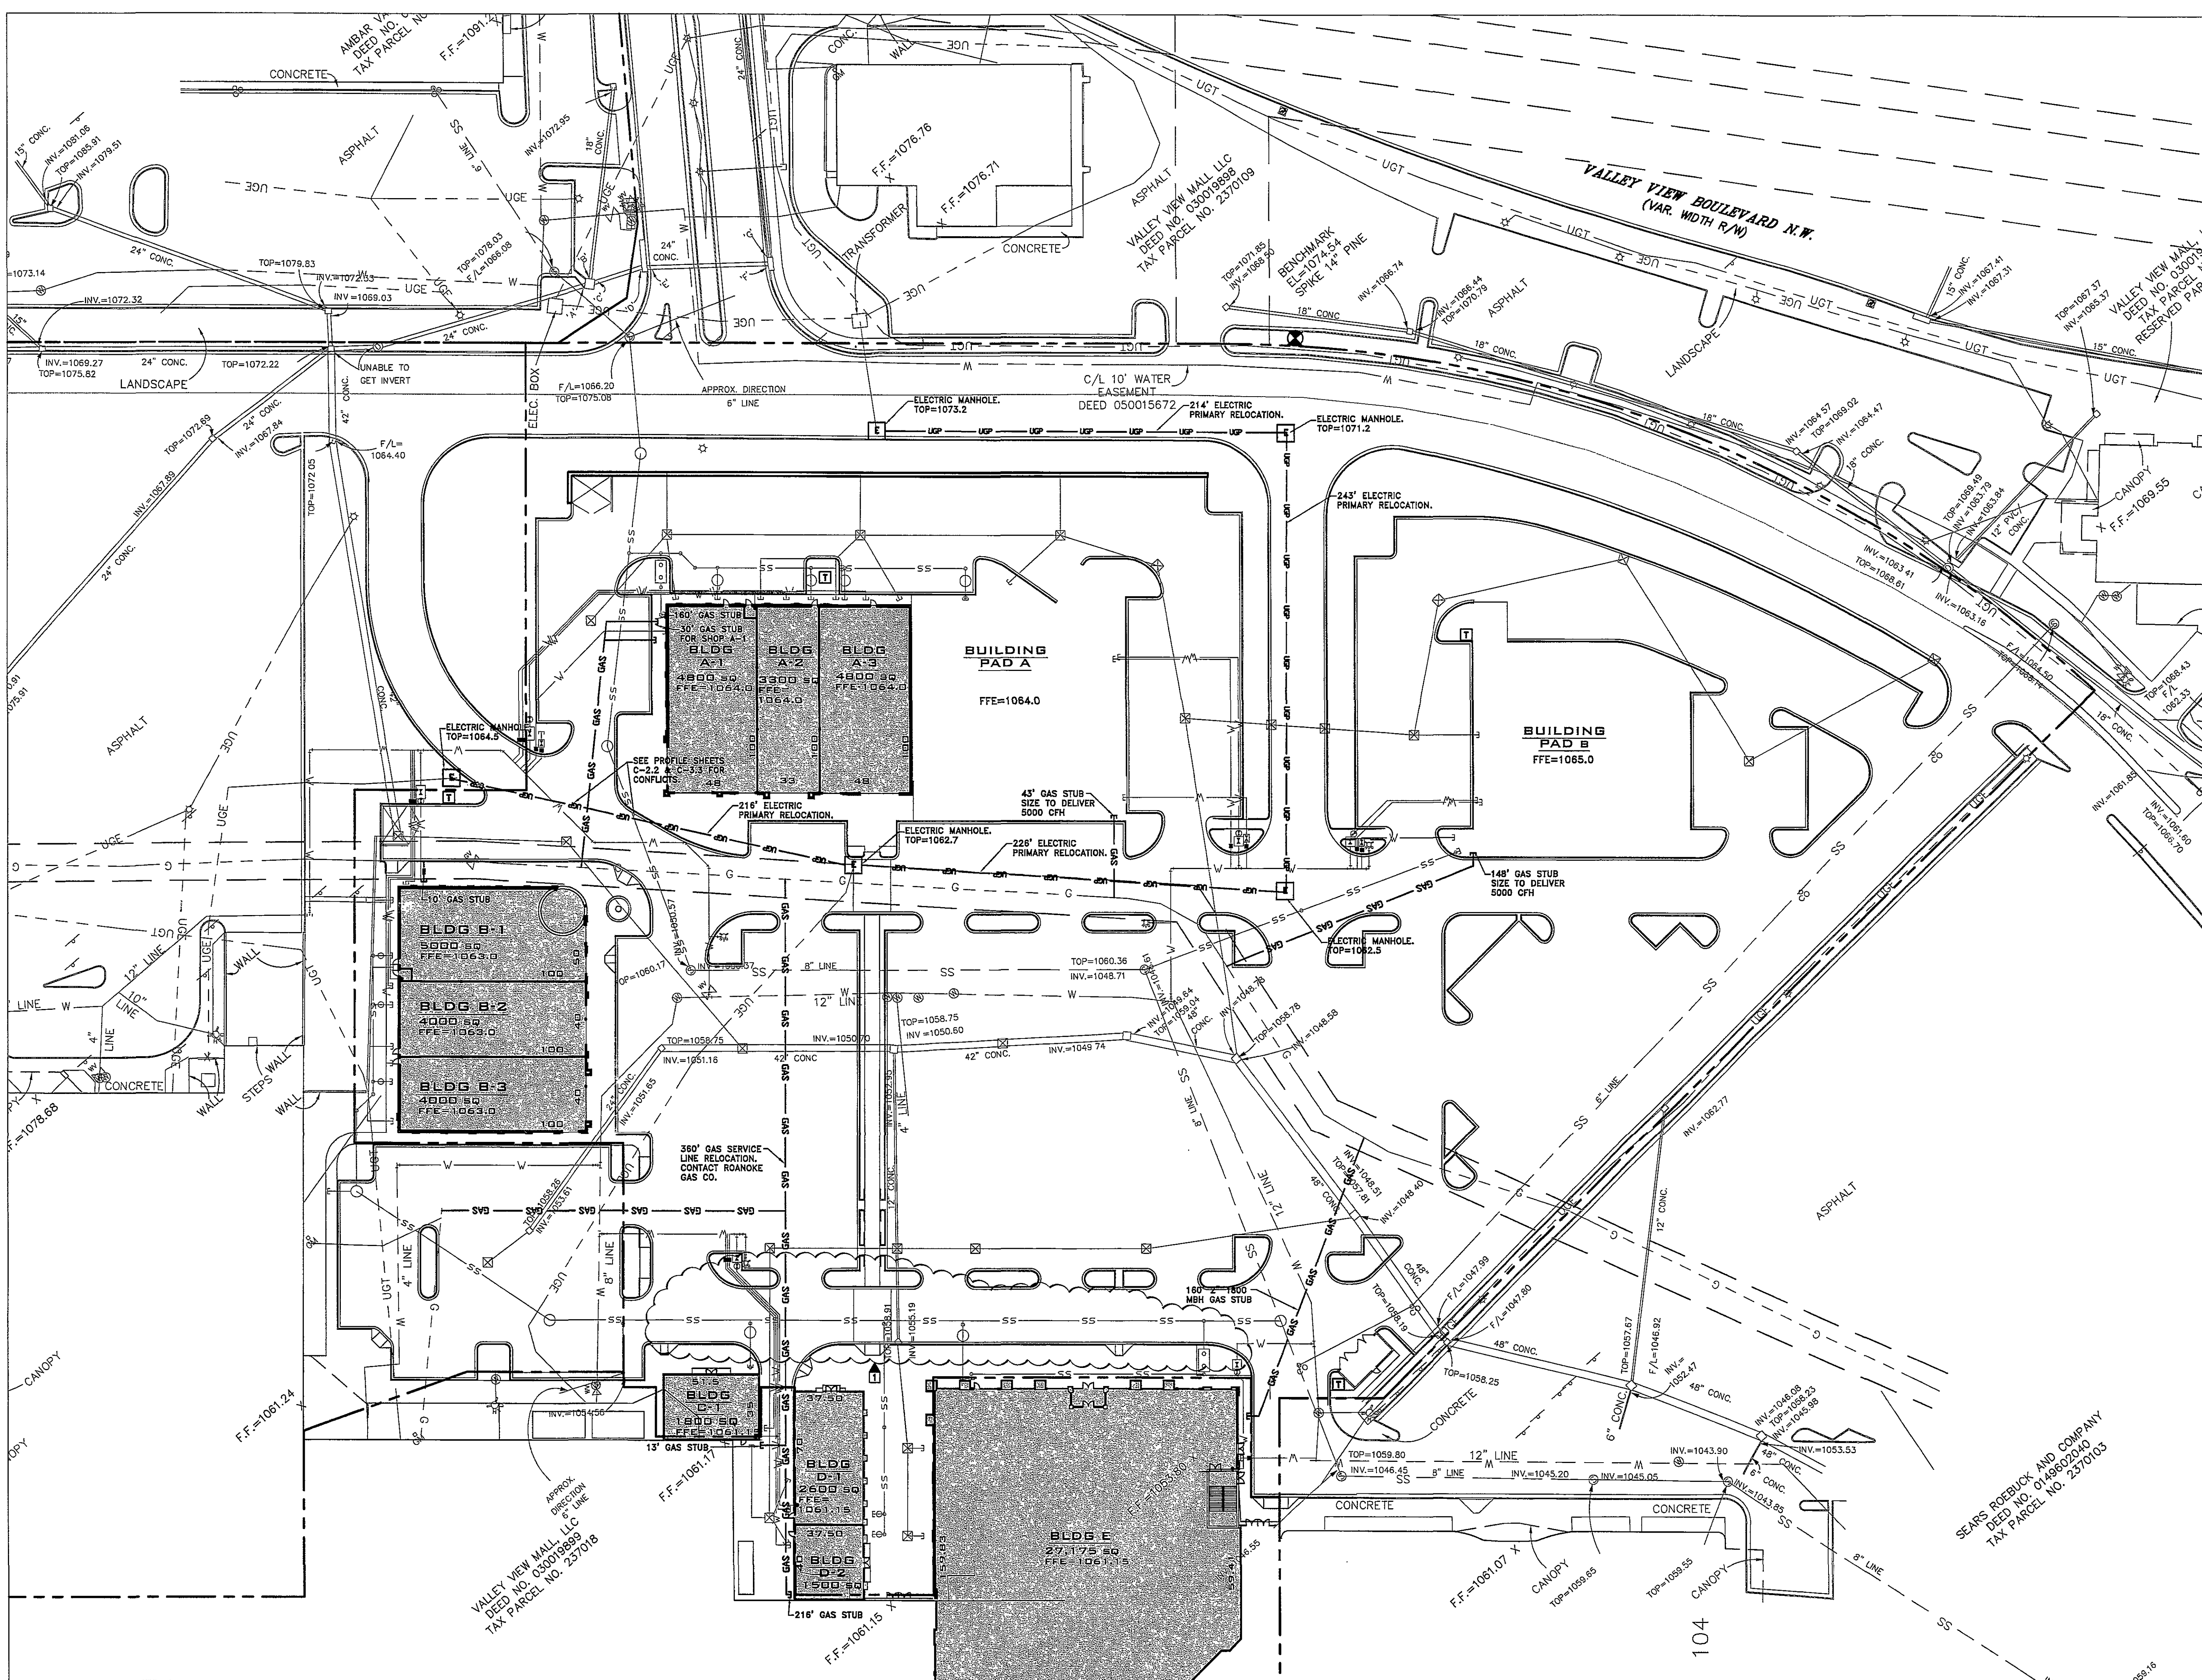

MSTSD

MSTSD, INC.
1776 Peachtree Road, N.W.
Suite 180
Atlanta, Georgia 30309
404 962 9680


this drawing is the property of the architect and may not be reproduced or used without his written permission.

issue date\revisions
1) ADDENDUM #1 - 03/17/06




CBL & ASSOCIATES PROPERTIES, INC.

key plan

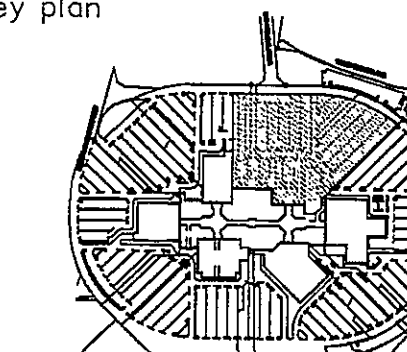

seal

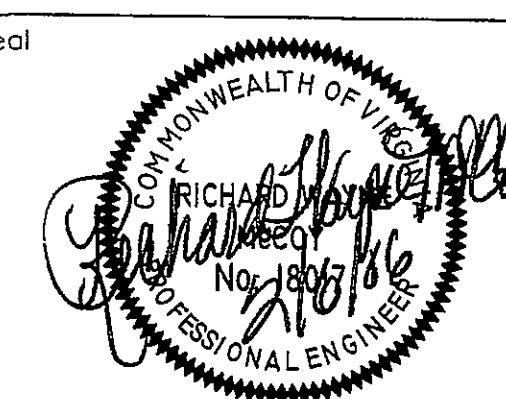

project name

**THE DISTRICT
AT VALLEY VIEW
MALL**

ROANOKE, VIRGINIA

sheet title

**SITE UTILITIES:
GAS & ELECTRIC
COORDINATION**

drawn

BMB

checked

RWM

project no.

0536

date

02/06/06


sheet no.

C-3.4

UTILITIES & GRADING LEGEND

	EXISTING	PROPOSED
RIGHT-OF-WAY/PROPERTY LINE	---	---
WATER LINE	W	W
SANITARY SEWER	SS	SS
SANITARY SEWER MANHOLE	⊙	⊙
GAS	G	GAS
OVERHEAD POWER LINE	OHE	OHE
UNDERGROUND POWER LINE	UGP	UGP
UNDERGROUND TELEPHONE LINE	UGT	UGT
BACKFLOW PREVENTOR		⊠
CLEANOUT	⊙	C.O.
FIRE HYDRANT	⊙	⊙
WATER VALVE	⊙	⊙
INDEX CONTOURS	1055	65
1" INTERVALS	1064	64
SPOT ELEVATION		1064.5
STORM SEWER		
CATCH BASIN	⊠	⊠

CALL BEFORE YOU DIG
UTILITIES PROTECTION CENTER

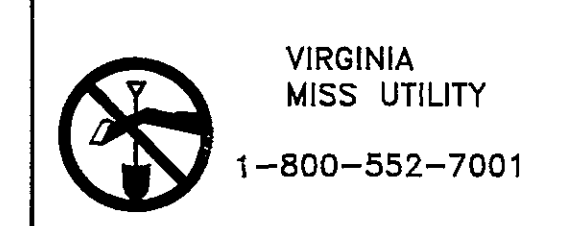


VIRGINIA
MISS UTILITY
1-800-552-7001

THREE WORKING DAYS BEFORE YOU DIG

IT IS THE CONTRACTOR'S RESPONSIBILITY TO CONTACT UTILITY COMPANIES PRIOR TO ANY CONSTRUCTION AS THE LOCATION OF UTILITIES SHOWN ON THIS PLAN ARE APPROXIMATE AND POSSIBLY INCOMPLETE. THEREFORE CERTIFICATION TO THE LOCATION OF ALL UNDERGROUND UTILITIES IS WITHHELD.

GAS & ELECTRIC PRIMARY COORDINATION

GRAPHIC SCALE

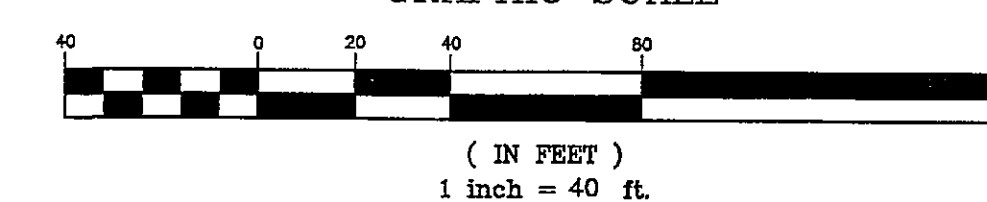

MILLER-McCOY, INC.
CONSULTING ENGINEERS
915 CREEKSIDE ROAD CHATTANOOGA, TENNESSEE 37406
PHONE (423) 698-2661 FAX (423) 698-2664