


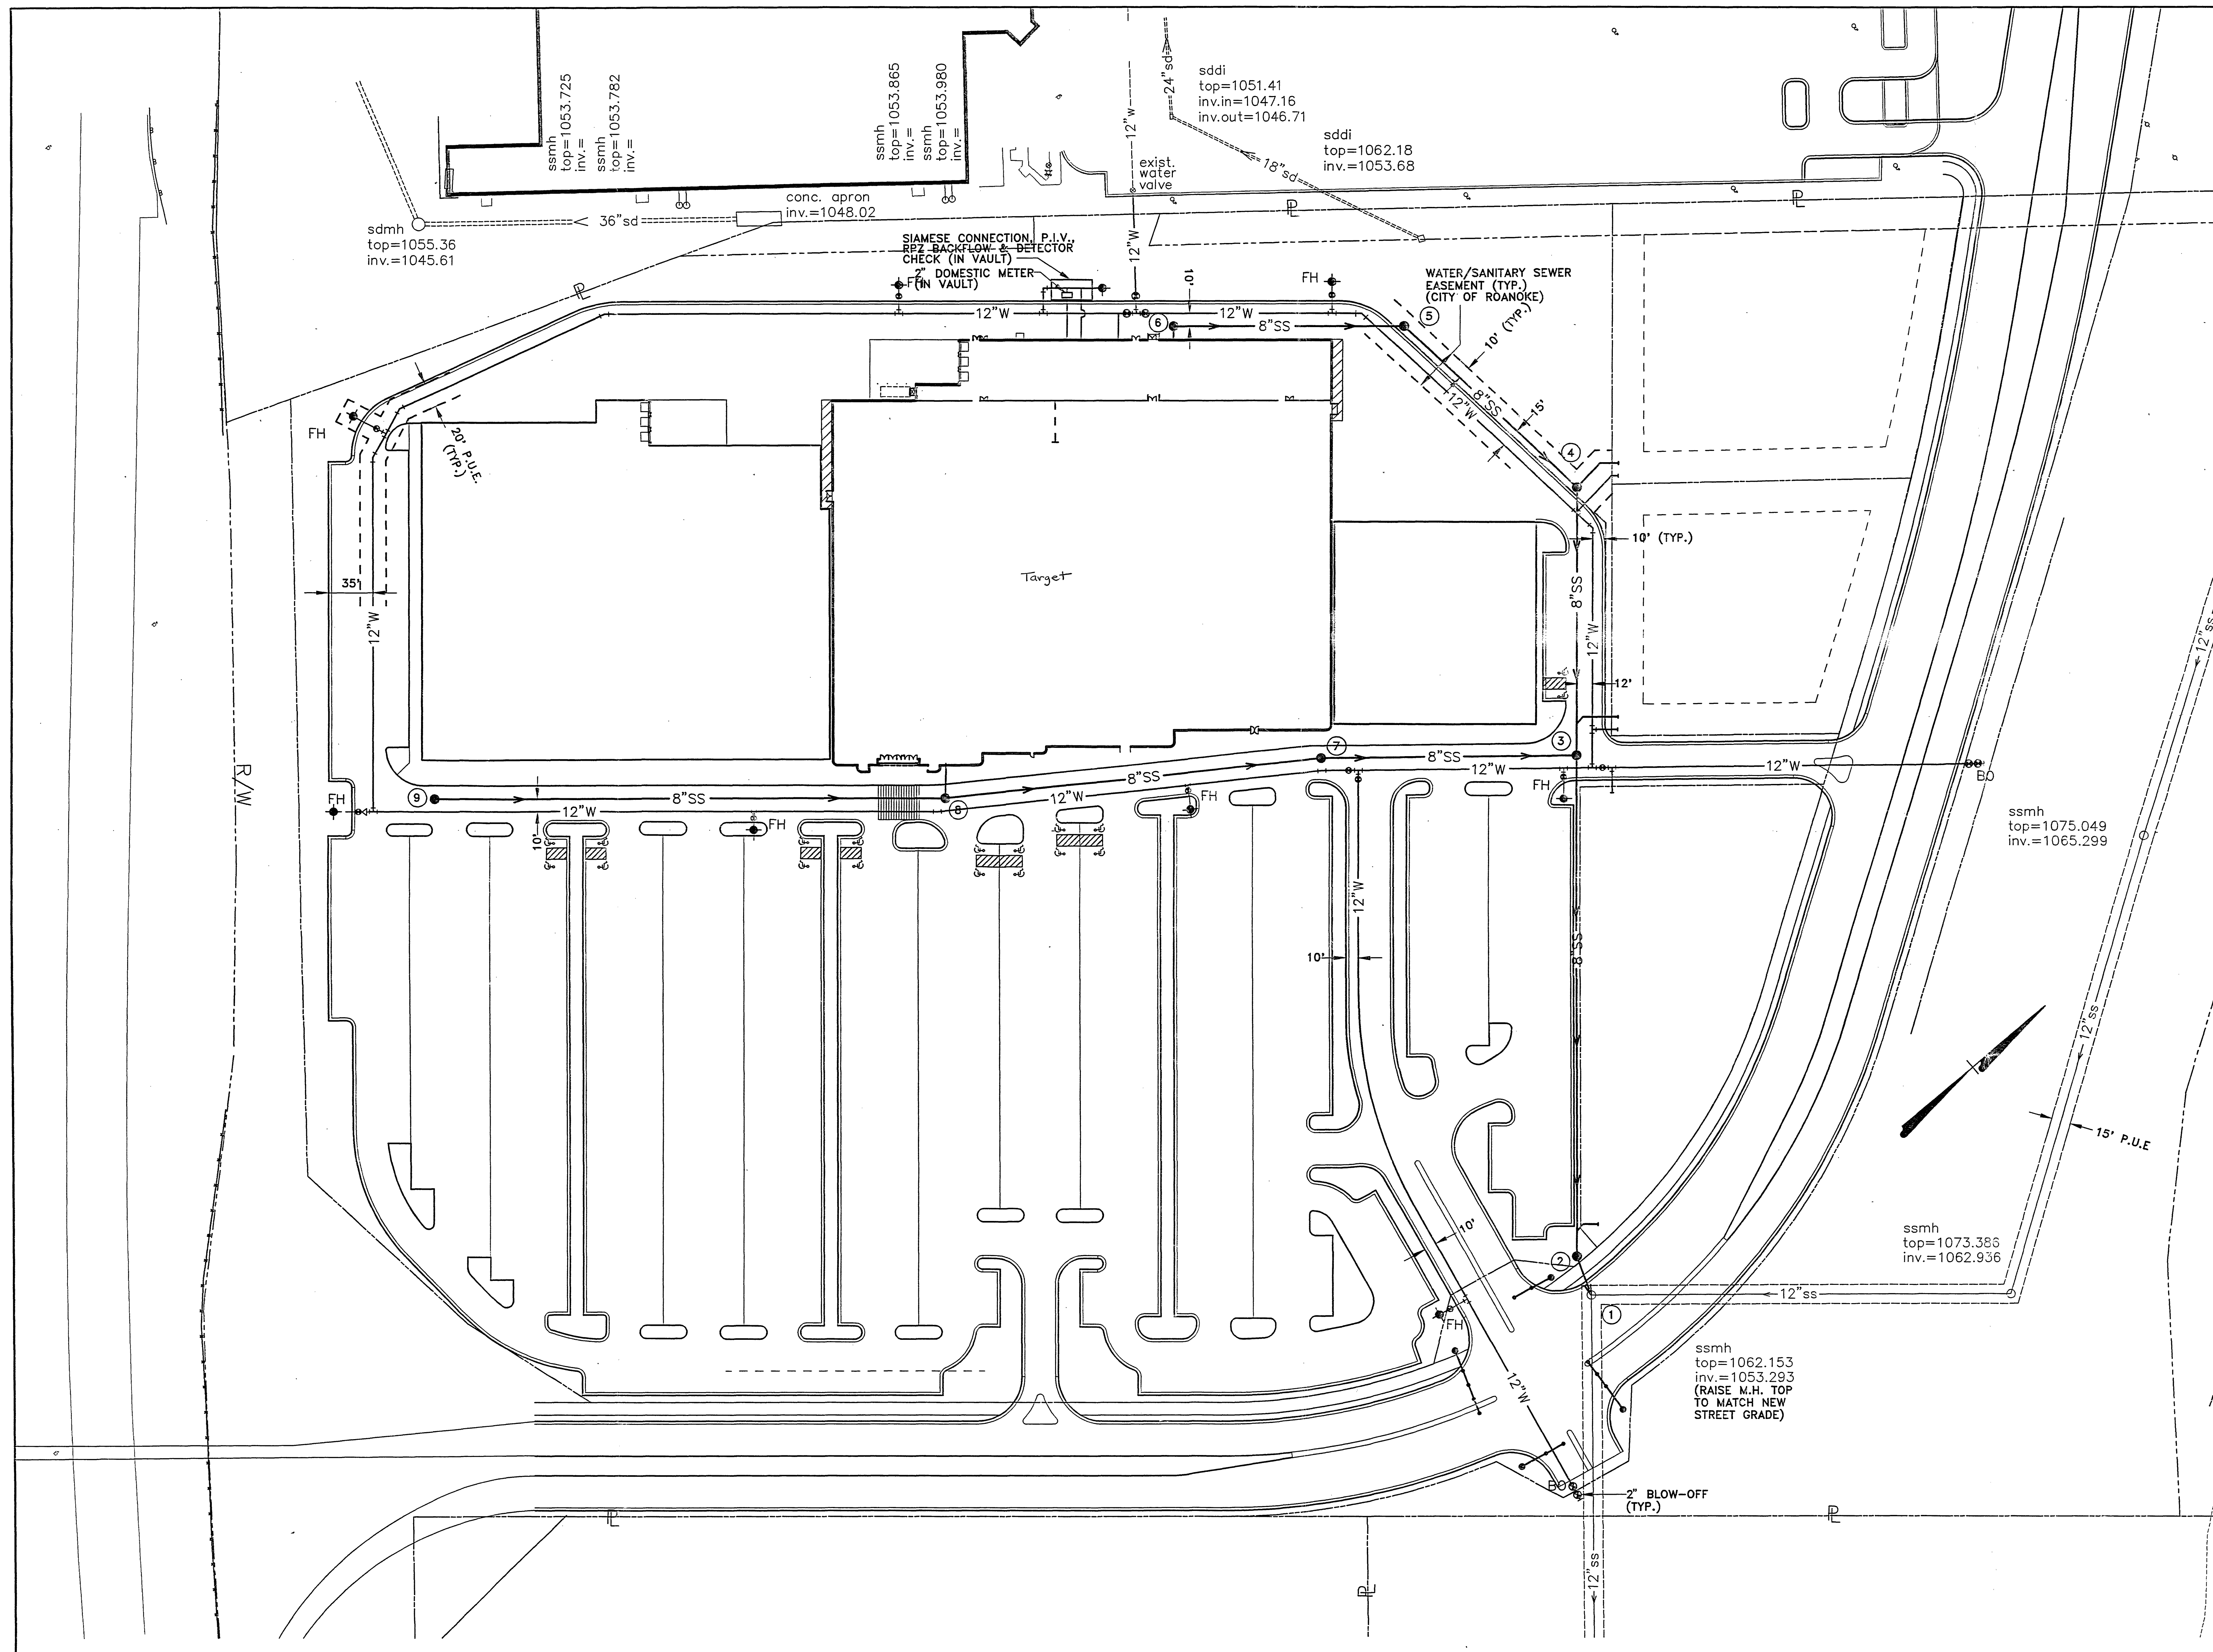

- LEGEND**
- FIRE HYDRANT
 - WATER VALVE
 - ▷ REDUCER
 - SANITARY SEWER MANHOLE

COORDINATE LIST

SMH#	NORTHING	EASTING
2	3636104.6027	11059319.1507
3	3636362.2981	11059013.2209
4	3636498.7524	11058851.2257
5	3636477.6762	11058667.4356
6	3636539.1258	11058550.7298
7	3636209.7005	11058887.6201
8	3635981.8512	11058719.9228
9	3635655.6909	11058462.5012


SCALE IN FEET
0 50 100

WWW.DFG.BVALWX

Mattern & Craig, Inc.
CONSULTING ENGINEERS - SURVEYORS
701 FIRST STREET, S.W.
ROANOKE, VIRGINIA 24016
(540) 345-9342
(540) 345-7691 FAX

DSGN	REV	DATE	DESCRIPTION	BY	APP
LDL, WTA					
DRAWN LDL, JMC					
CHKD WTA					

VALLEY VIEW CROSSING
UTILITY PLAN
ROANOKE, VIRGINIA

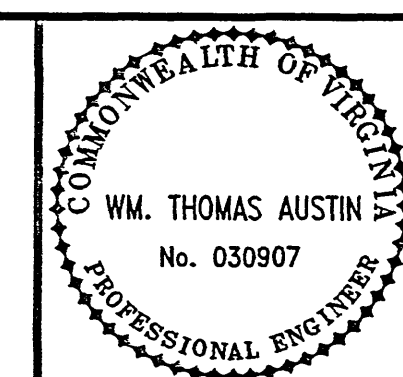

FOR REVIEW ONLY

SCALE: 1"=50'
COMM. NO. 1535
DATE: JUNE, 1997
SHEET C-4

24/06/97, 1535, C-4.DWG