



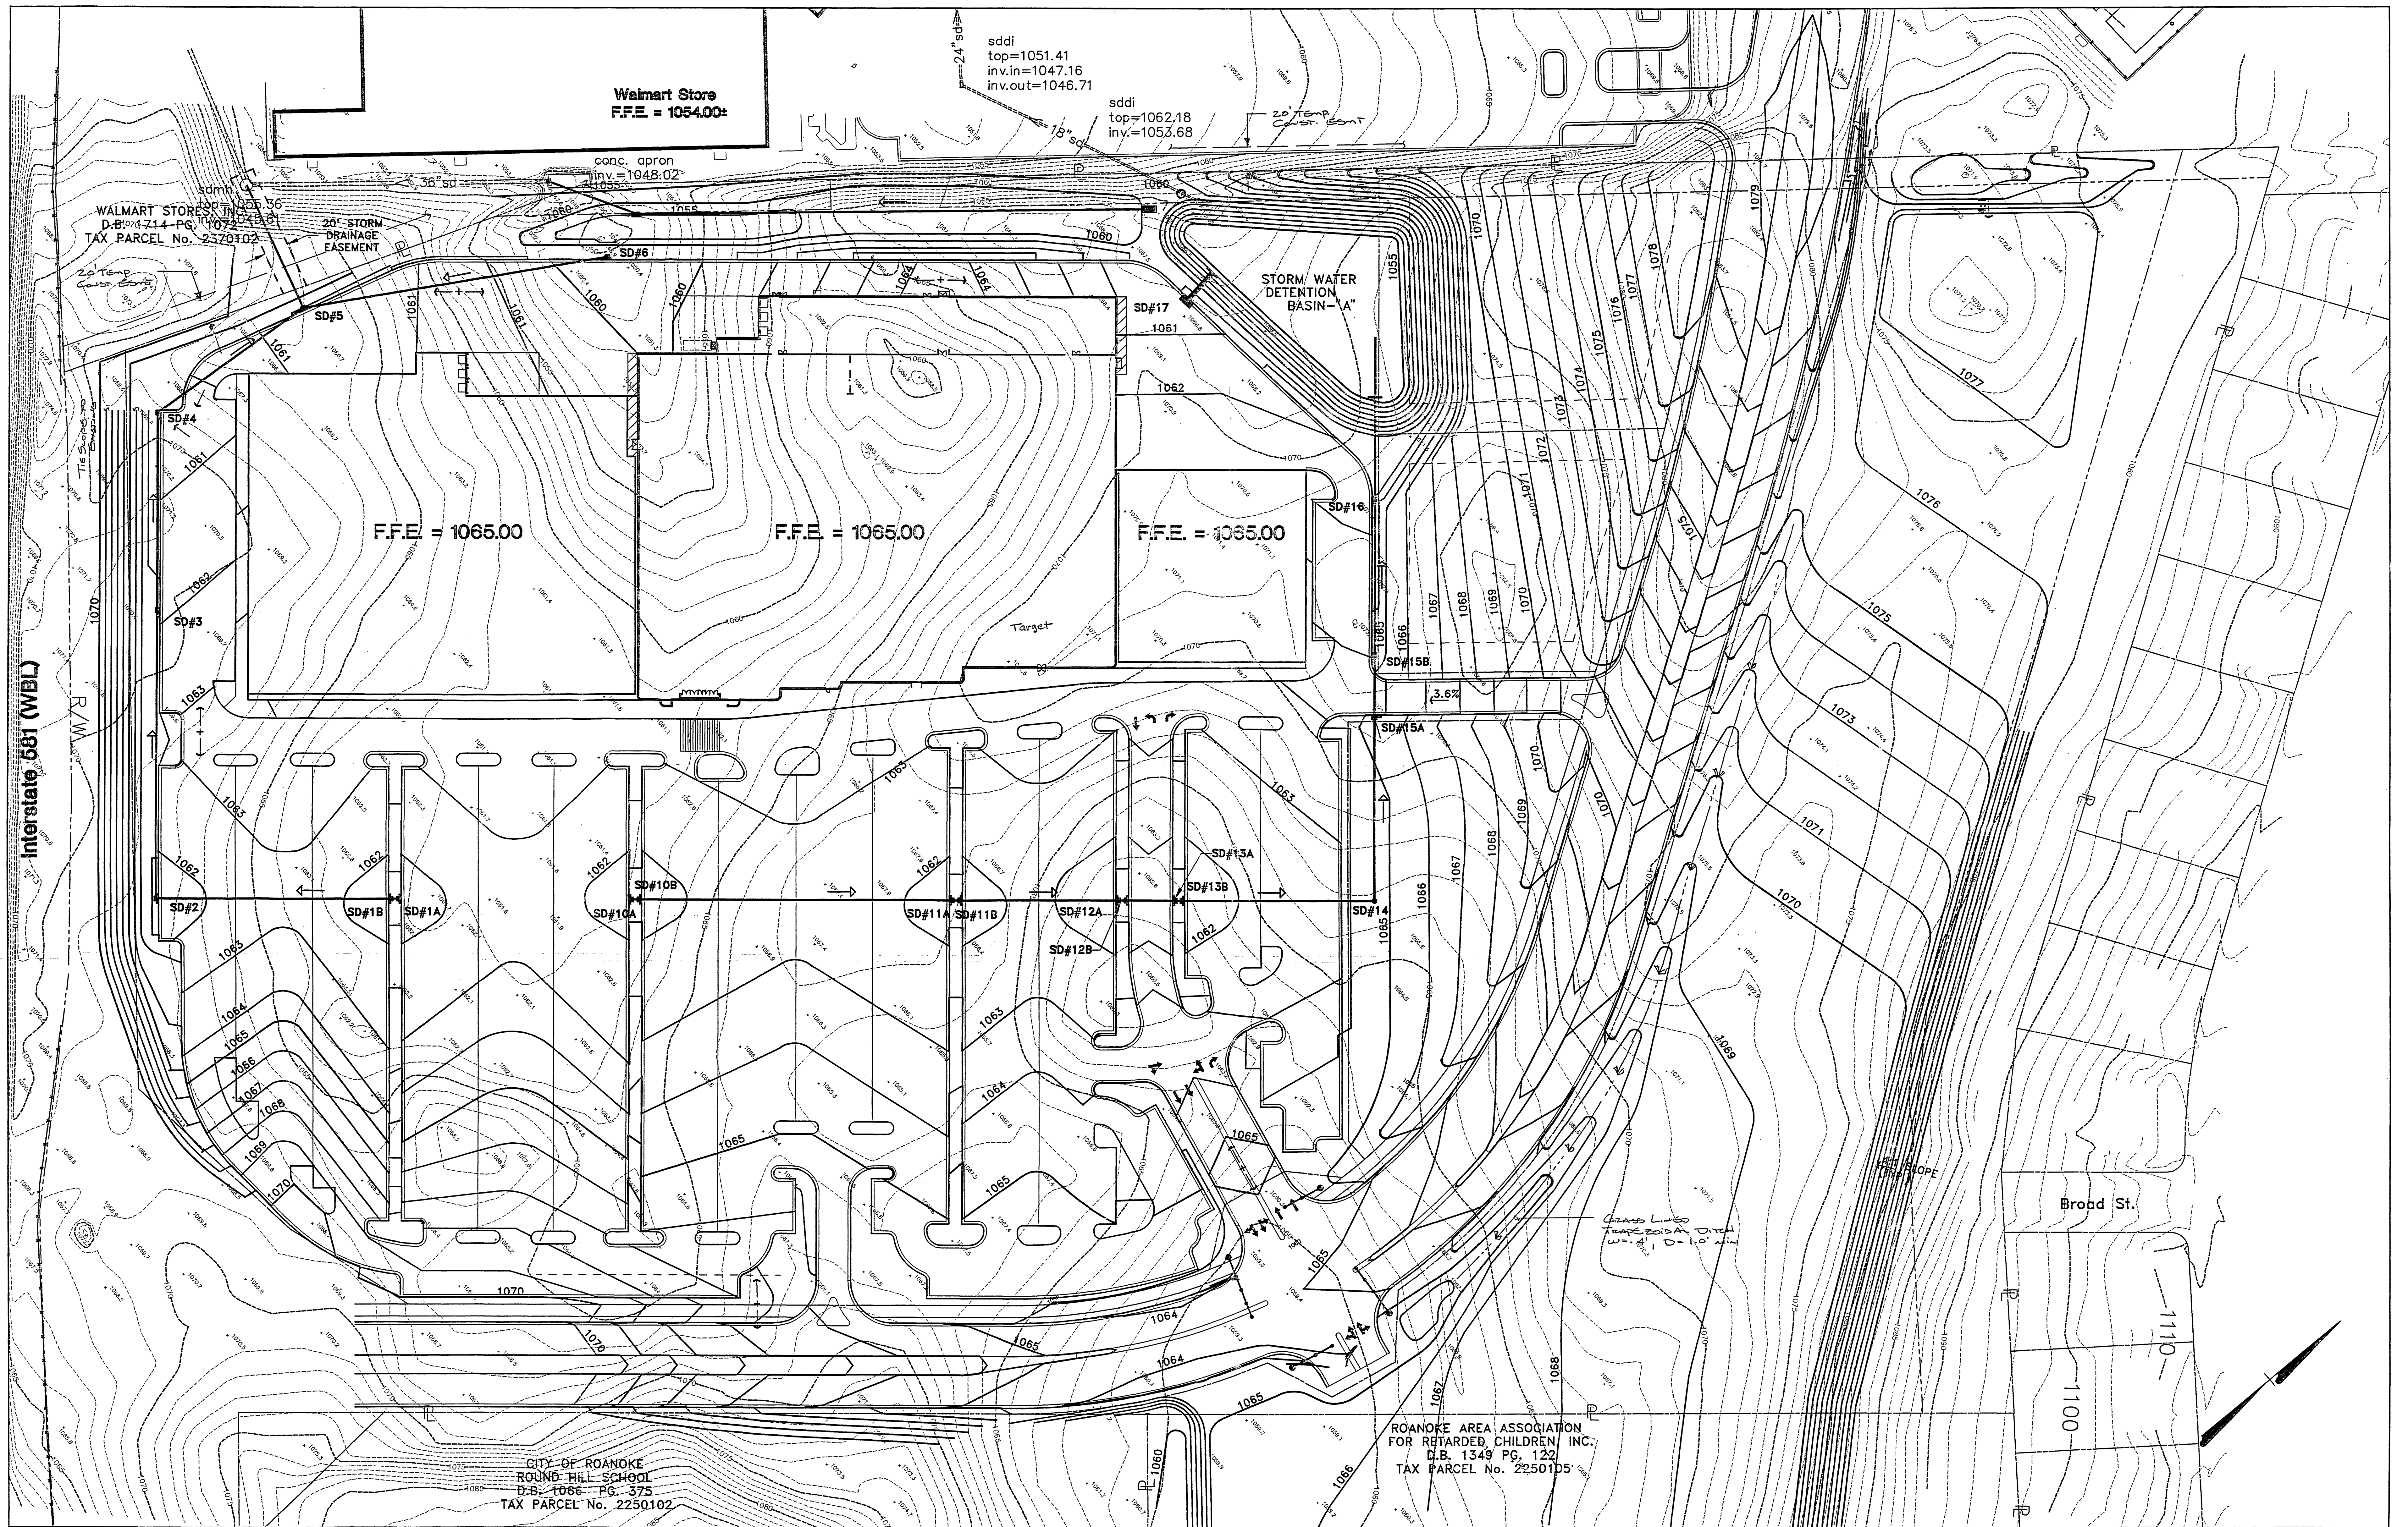

Mattern & Craig, Inc.
CONSULTING ENGINEERS - SURVEYORS
701 FIRST STREET, S.W.
ROANOKE, VIRGINIA 24016
(540) 345-9342
(540) 345-7691 FAX

DSGN	LDL, WTA	REV	DATE	DESCRIPTION	BY	APP
DRAWN	LDL, ARB					
CHKD	WTA, SWH					

VALLEY VIEW CROSSING
GRADING AND DRAINAGE PLAN
ROANOKE, VIRGINIA

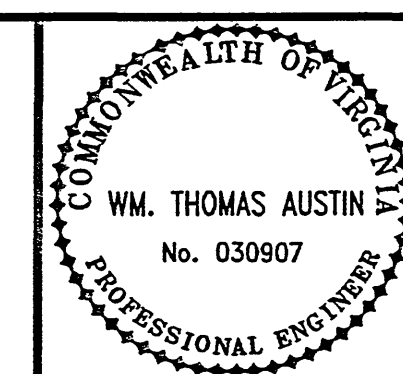

**FOR
REVIEW
ONLY**

SCALE: 1" = 50'
COMM. NO. 1535
DATE: JUNE, 1997
SHEET C-5