



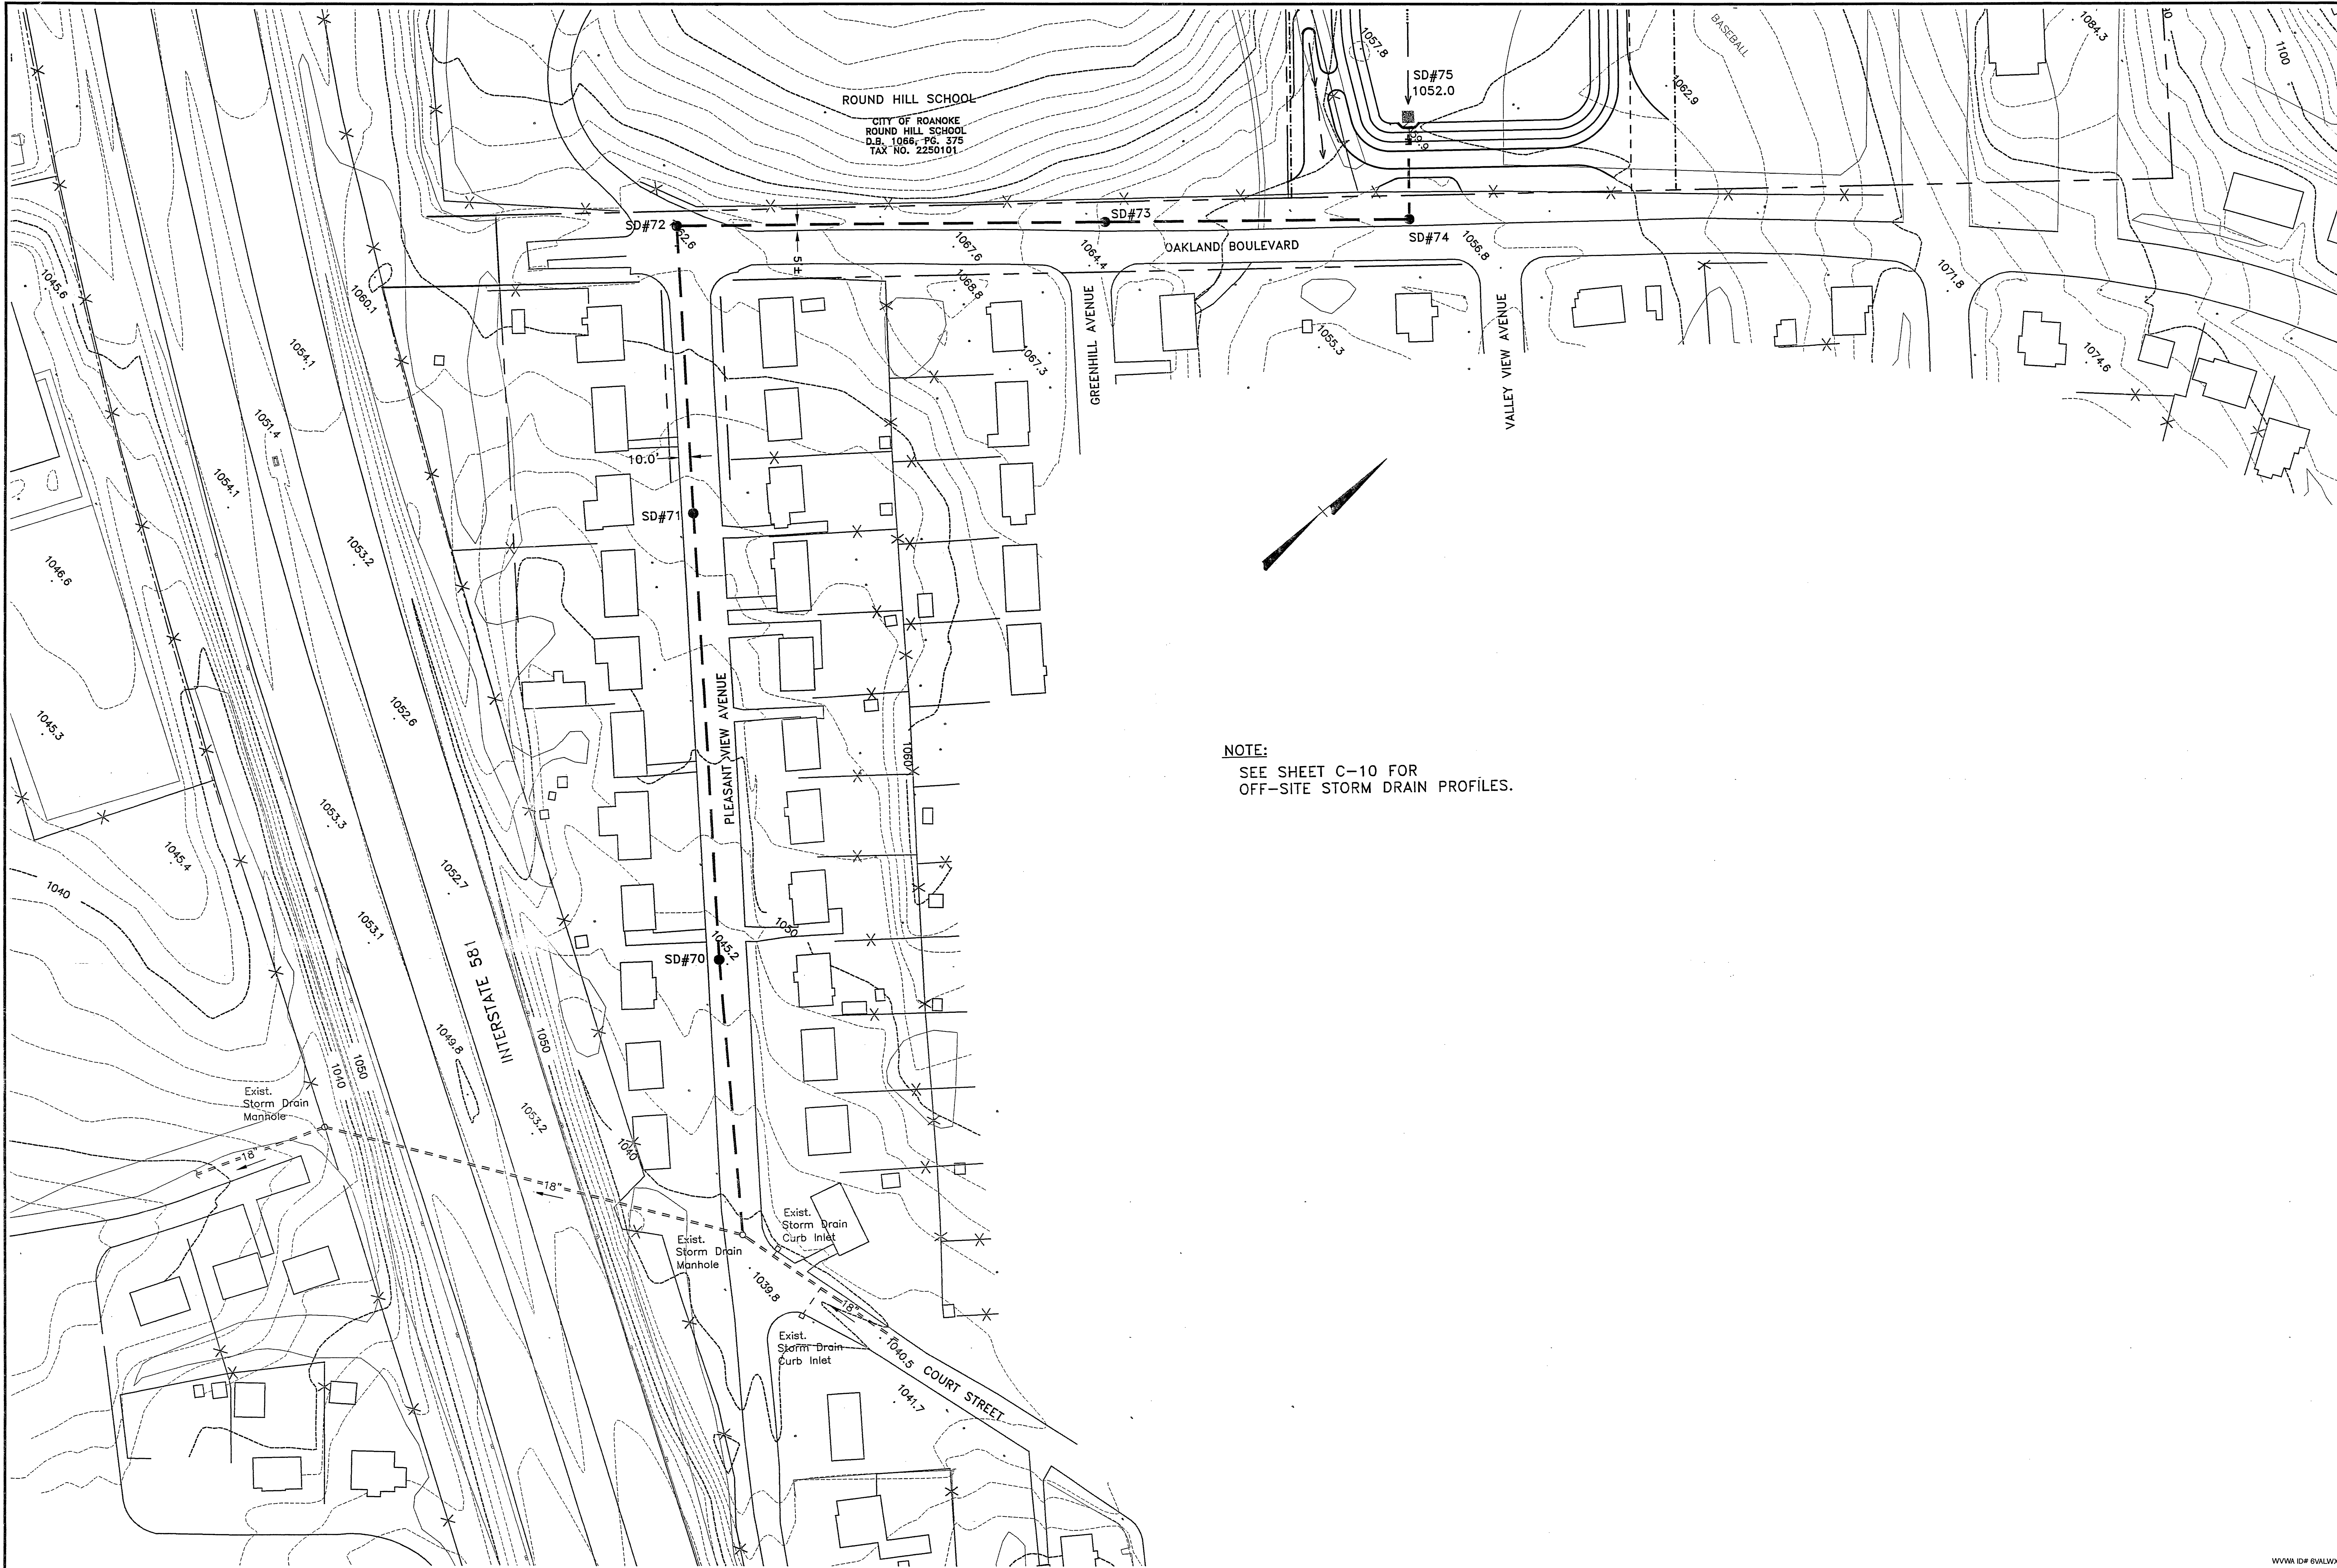

NOTE:
SEE SHEET C-10 FOR
OFF-SITE STORM DRAIN PROFILES.

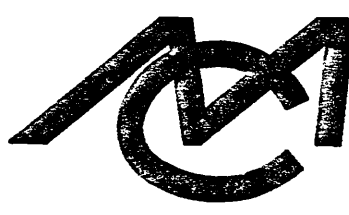


Mattern & Craig, Inc.
CONSULTING ENGINEERS - SURVEYORS
701 FIRST STREET, S.W.
ROANOKE, VIRGINIA 24016
(540) 345-9842
(540) 345-7691 FAX

DSGN	REV	DATE	DESCRIPTION	BY	APP
BCC, WTA					
JMC, ARS					
WTA, SWH					

VALLEY VIEW CROSSING

OFF-SITE STORM DRAINAGE PLAN

ROANOKE, VIRGINIA

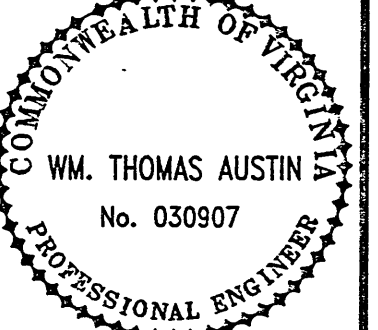

FOR REVIEW ONLY

SCALE: 1"=50'
COMM. NO. 1535
DATE: JUNE, 1997
SHEET C-9