


Interstate 581 (NBL)

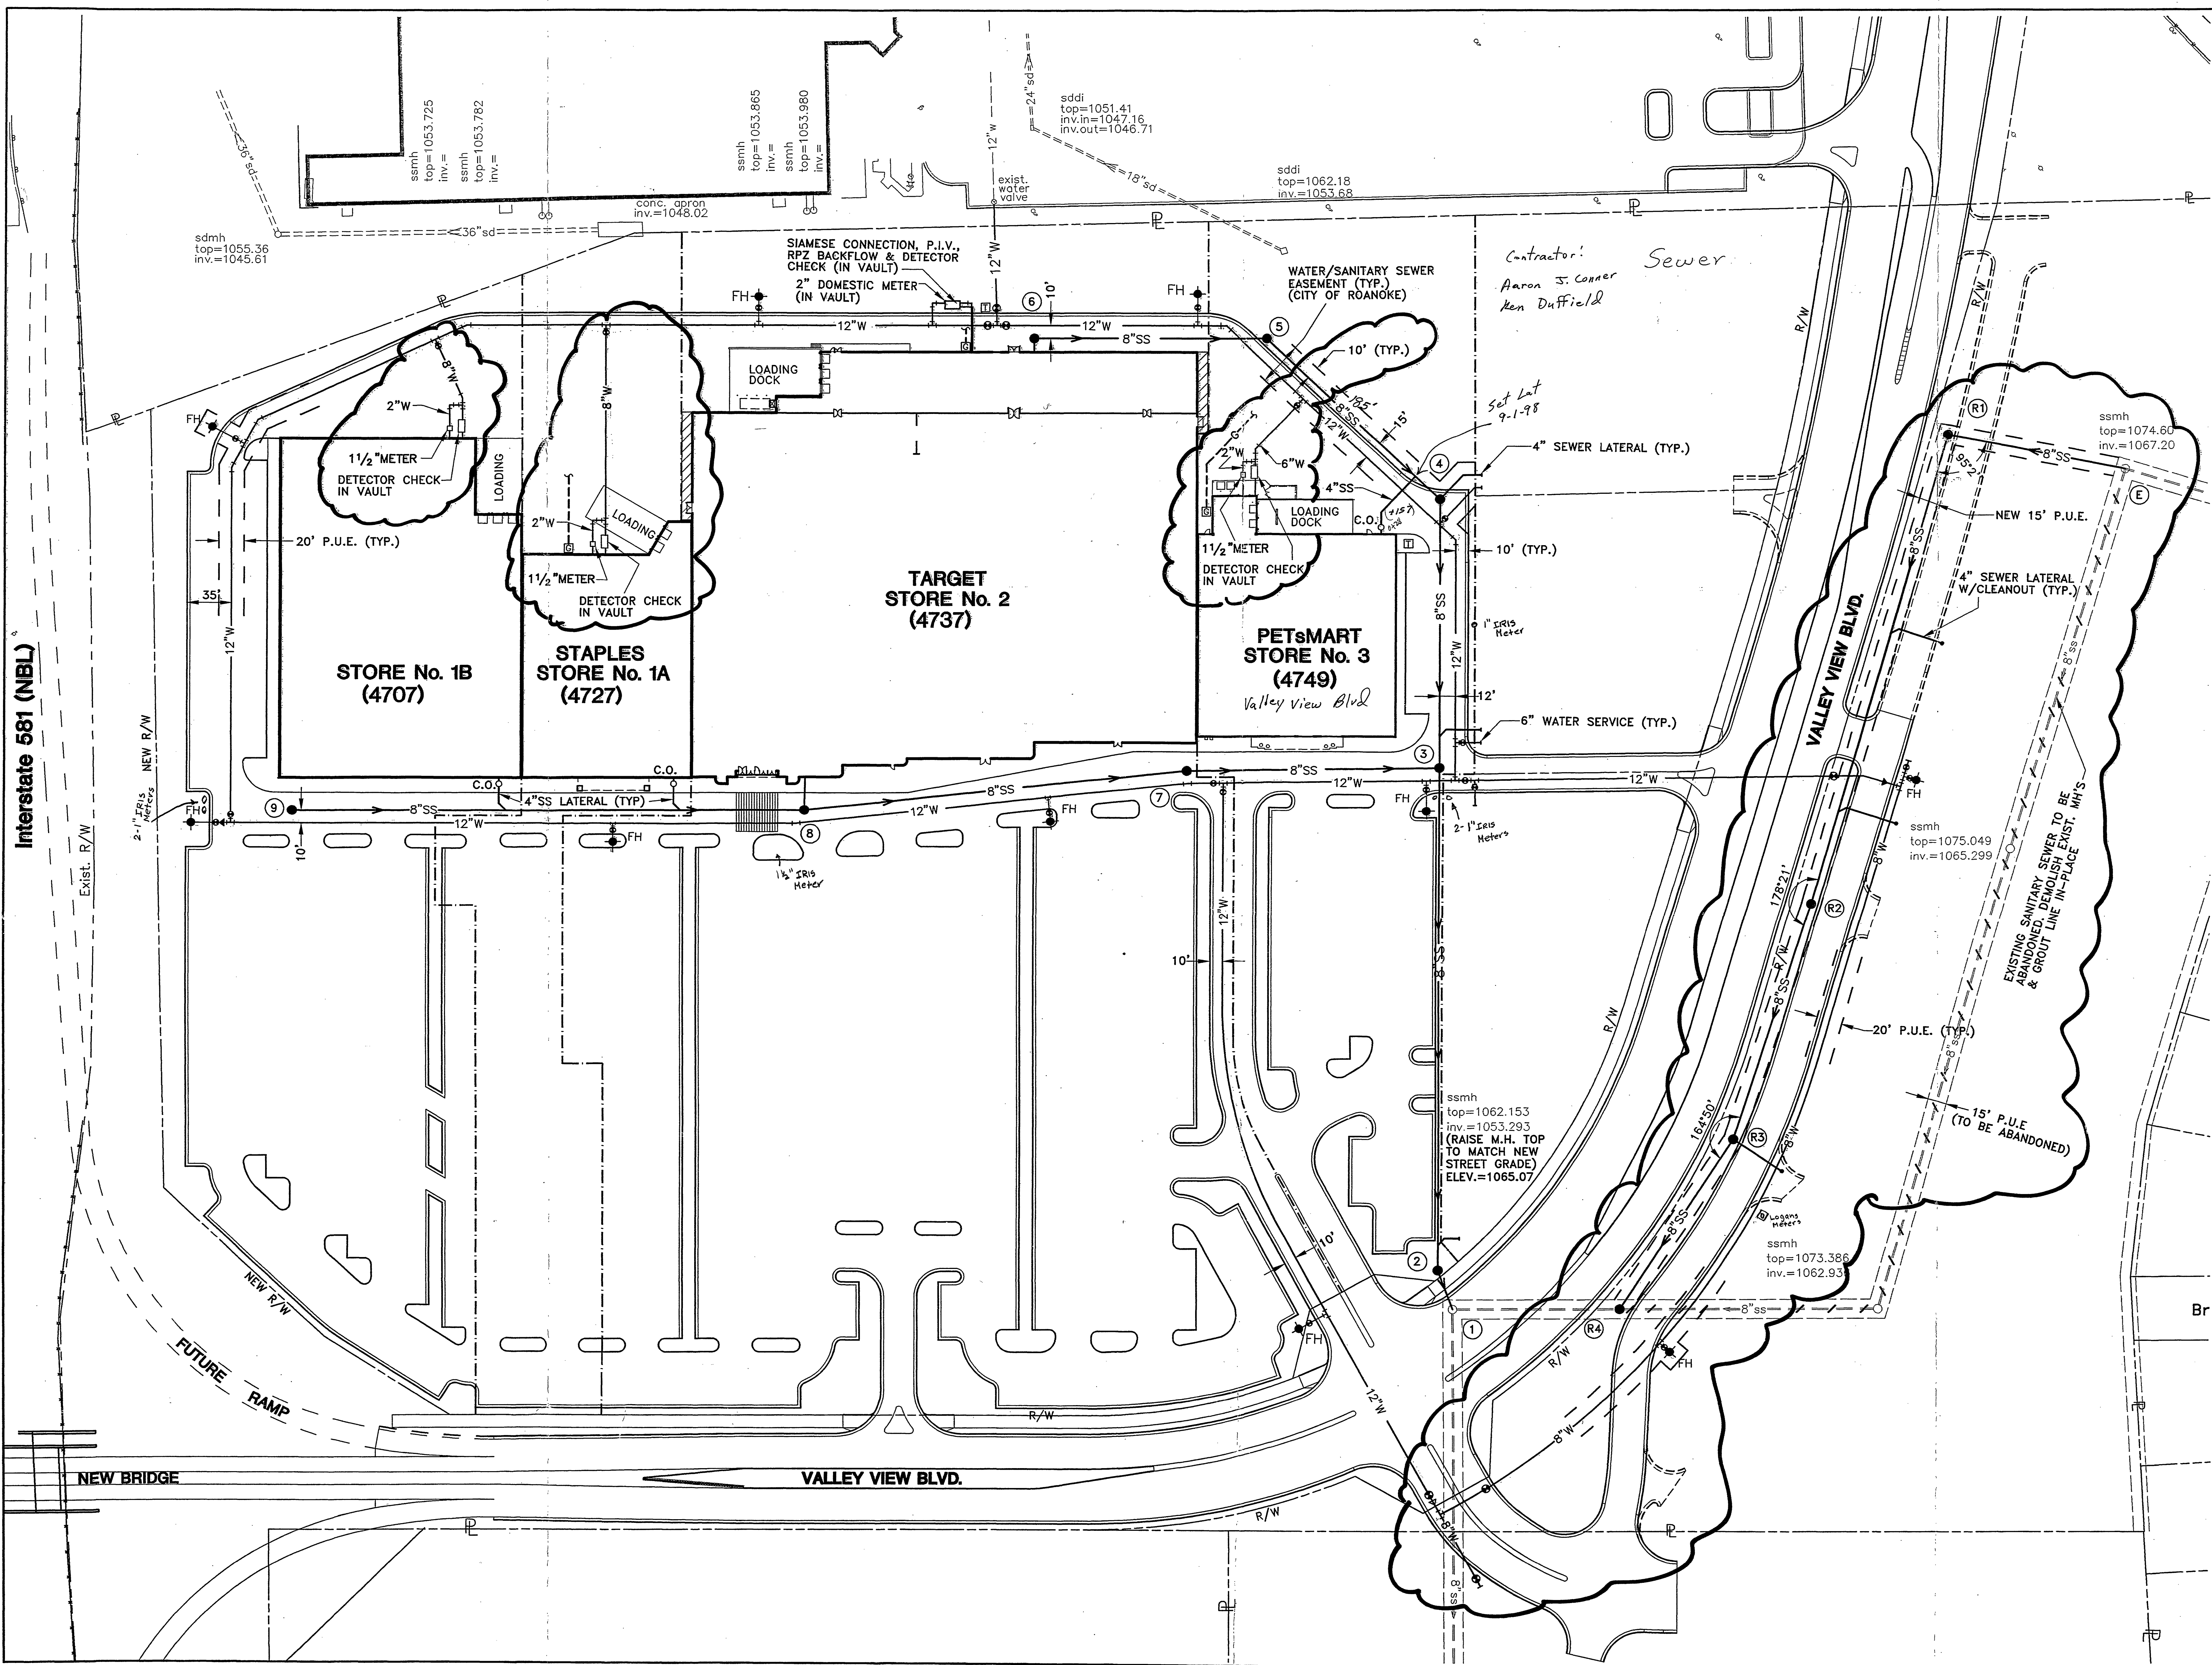

LEGEND

- FIRE HYDRANT
- WATER VALVE
- REDUCER
- SANITARY SEWER MANHOLE
- GAS METER
- TRANSFORMER (PAD MOUNTED)

NOTES:

- REFER TO SHEETS C-12 & C-12A FOR SANITARY SEWER PROFILES.
- SCOPE OF WORK INCLUDES WATER & SEWER SERVICE TO WITHIN 5- FEET OF BUILDING.
- SEE SHEET C-32 FOR VALVE VAULT DETAILS.
- WATER & SEWER SERVICE CONNECTIONS ARE TO BE VERIFIED WITH INDIVIDUAL STORE DESIGNS.

COORDINATE LIST

SMH#	NORTHING	EASTING
2	3636106.9352	11059316.3816
3	3636362.2981	11059013.2209
4	3636498.7524	11058851.2257
5	3636477.6762	11058667.4356
6	3636339.1258	11058550.7298
7	3636209.7005	11058887.6201
8	3635961.8512	11058719.9228
9	3635655.6909	11058462.5012
E	3636923.9889	11059178.2880
R1	3636842.6291	11059062.9578
R2	3636515.6155	11059282.5418
R3	3636349.2659	11059385.4636
R4	3636196.1215	11059431.0468

SCALE IN FEET
0 50 100

Mattern & Craig, Inc.
CONSULTING ENGINEERS - SURVEYORS
701 FIRST STREET, S.W.
ROANOKE, VIRGINIA 24016
(540) 345-9942
(540) 345-7691 FAX

DSGN	LDL, WTA	REV	DATE	DESCRIPTION	BY	APP
		1	05 AUG 97	REVISED PER ADDENDUM #2	LDL	WTA
		2	17 APR 98	RELOCATED SEWER & OTHER MISC. REV.	LDL	WTA
CHKD	WTA, SWH					

VALLEY VIEW CROSSING

UTILITY PLAN

ROANOKE, VIRGINIA

WATER DEPT PLAN NO. 98-07
Out-Parcel Service Road

WM. THOMAS AUSTIN
No. 030907
PROFESSIONAL ENGINEER

SCALE: 1"=50'
COMM. NO. 1535
DATE: JULY, 1997
SHEET C-2