



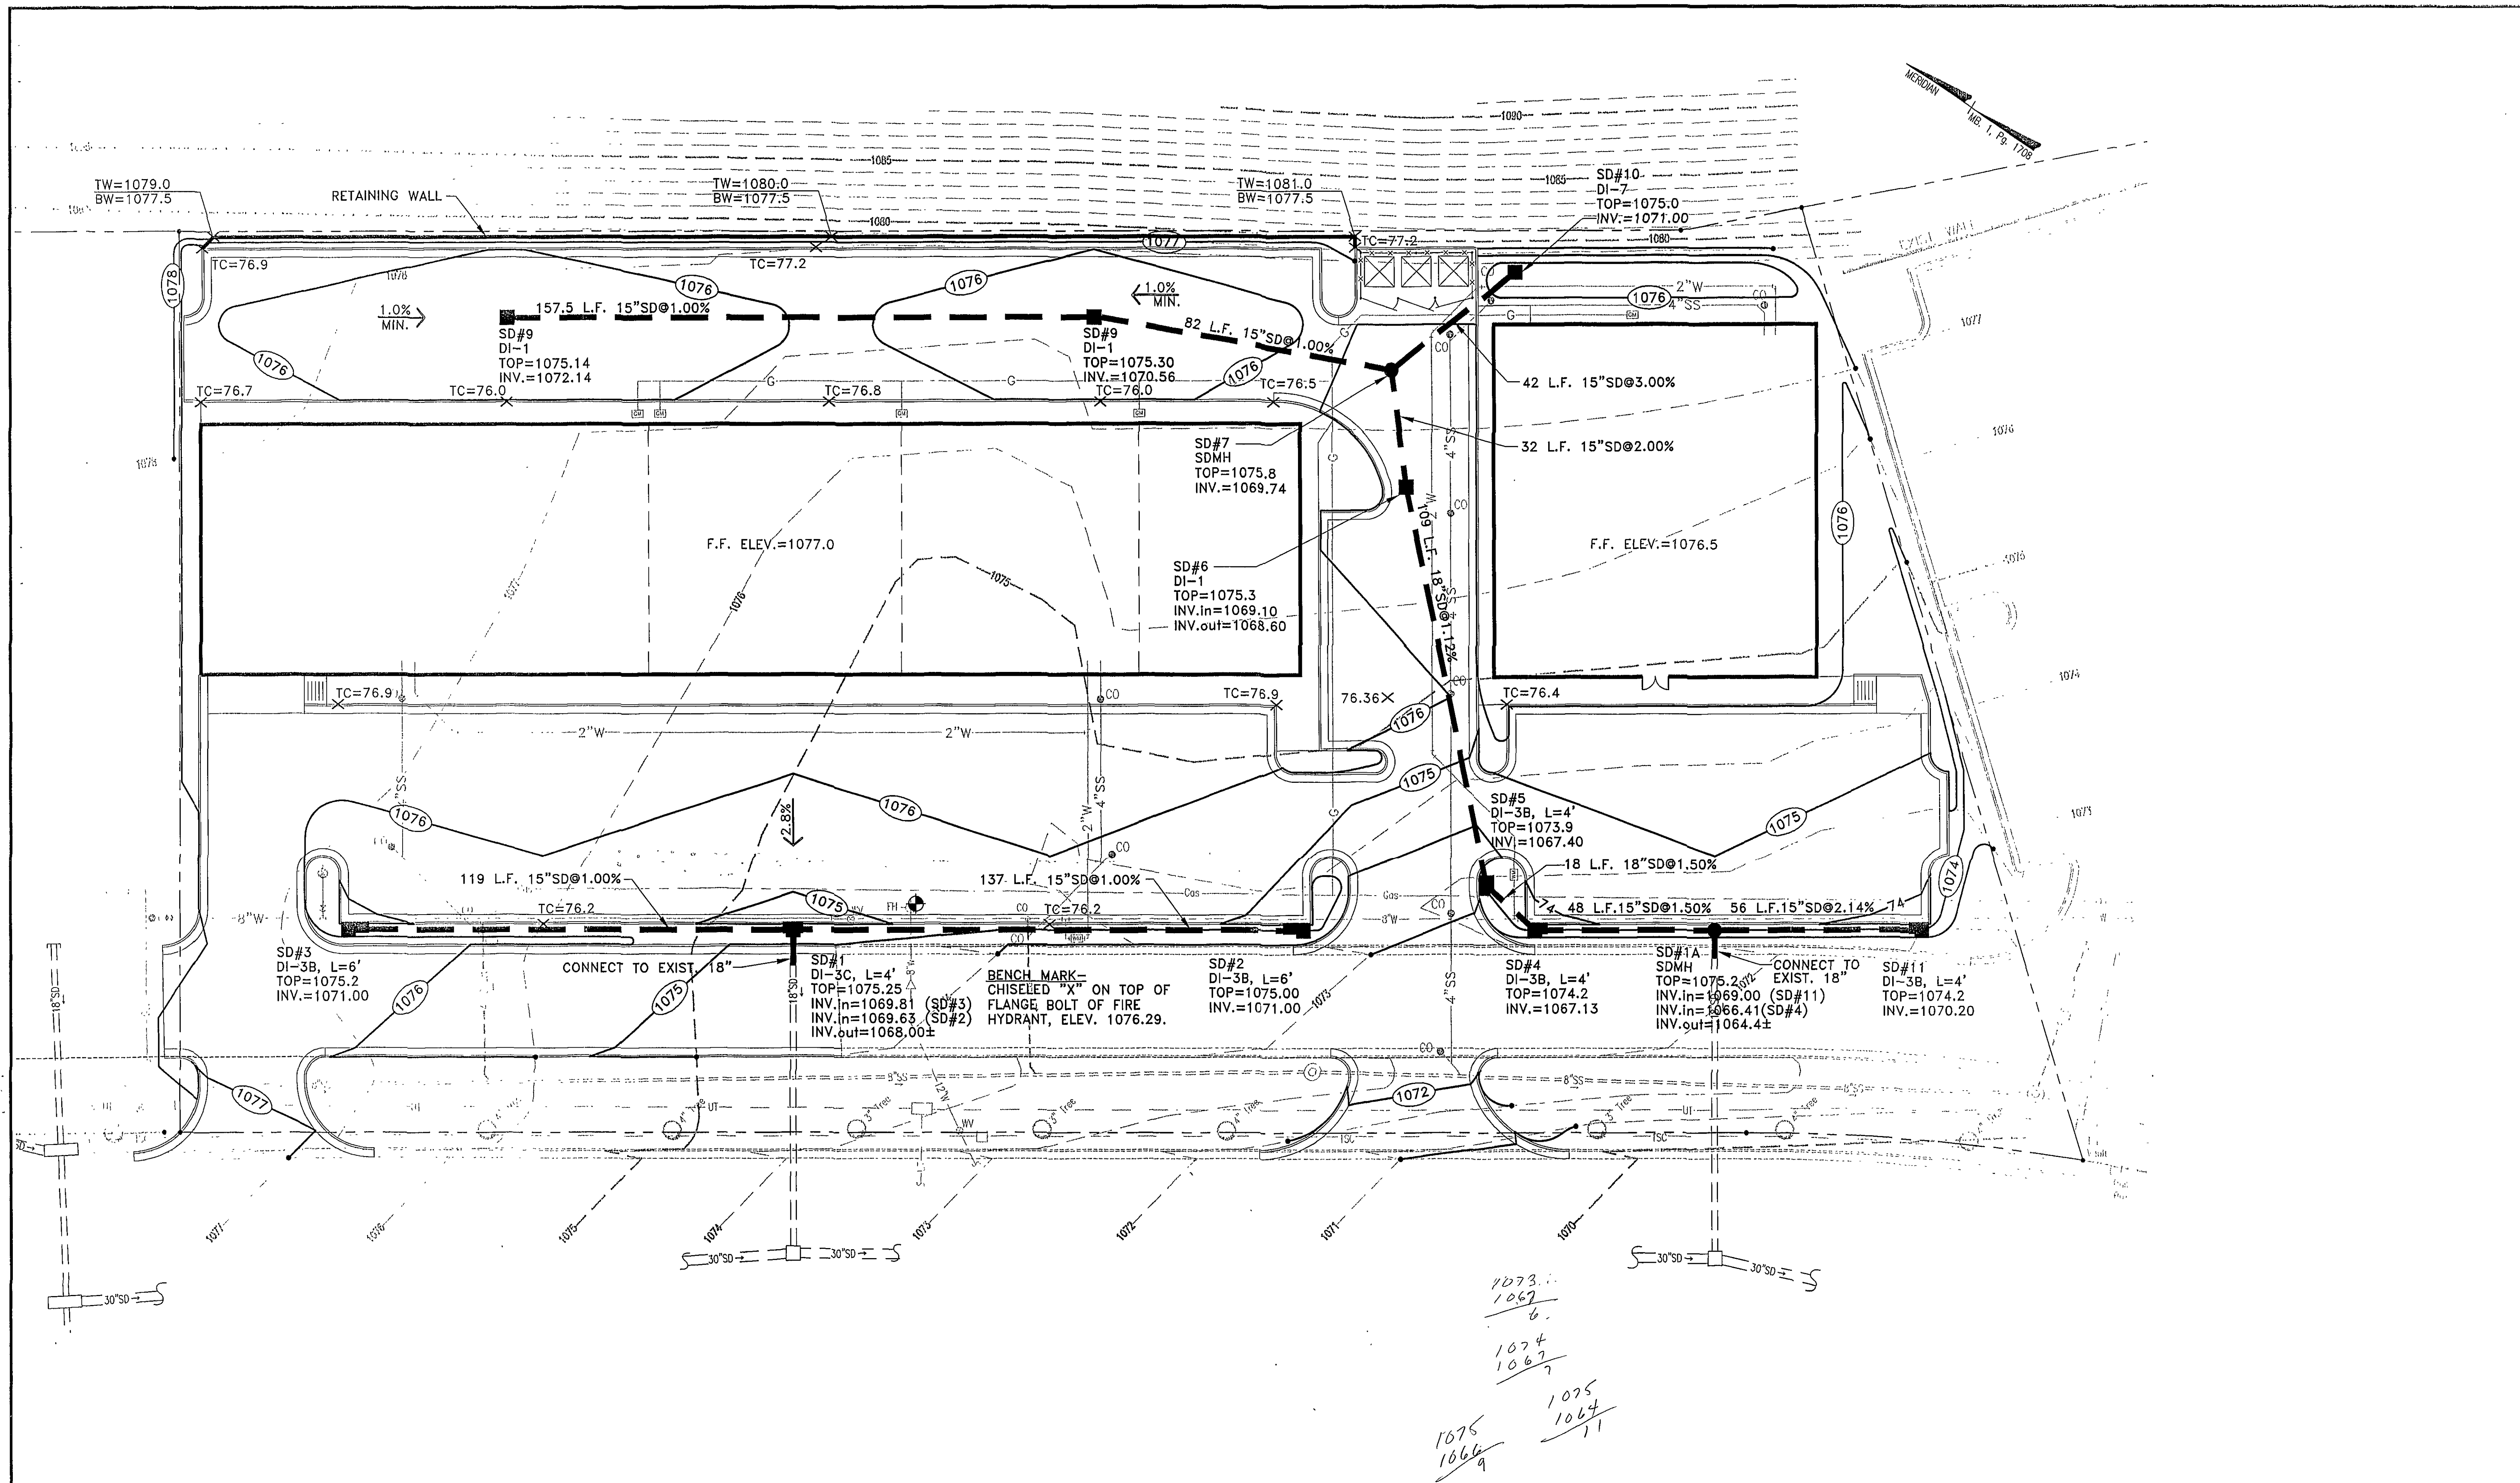

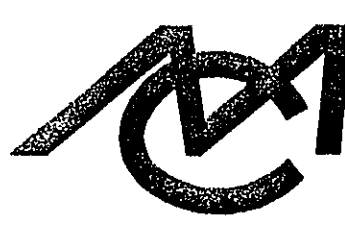

Mattern & Craig, Inc.
CONSULTING ENGINEERS • SURVEYORS
701 FIRST STREET, S.W.
ROANOKE, VIRGINIA 24016
(540) 345-9342
(540) 345-7691 FAX

REV	DATE	DESCRIPTION	BY	APP

VALLEY VIEW STATION

GRADING AND DRAINAGE PLAN

ROANOKE, VIRGINIA

SCALE: 1"=20'

COMM. NO. 1742

DATE: JULY, 1999

SHEET 5

