

Luminaire Schedule						POLES MOUNTED AT 25'±
Symbol	Qty	Label	Arrangement	Total Lamp Lumens	LLF	Description
	3	EWNB	SINGLE	N.A.	1.000	1-EWNB0A47301NBLCCKD
	1	SC5	SINGLE	N.A.	0.855	1-EALP012C5SM750NDD1BLCKF
	1	SF4_BS	SINGLE	N.A.	0.855	1-EALP012F4AF750NDD1BLCKF with 1-ELS-EAL-RBL-BLCK
	1	SF5	SINGLE	N.A.	0.855	1-EALP012F5SM750NDD1BLCKF

Luminaire Schedule						POLES MOUNTED AT 25'±
Symbol	Qty	Label	Arrangement	Total Lamp Lumens	LLF	Description
	3	EWNB	SINGLE	N.A.	1.000	1-EWNB0A47301NBLCCKD
	1	SC5	SINGLE	N.A.	0.855	1-EALP012C5SM750NDD1BLCKF
	1	SF4_BS	SINGLE	N.A.	0.855	1-EALP012F4AF750NDD1BLCKF with 1-ELS-EAL-RBL-BLCK
	1	SF5	SINGLE	N.A.	0.855	1-EALP012F5SM750NDD1BLCKF


[illegible]

PE Accessories (to be ordered separately)		
Accessories	ANSI C136.41	ANSI C136.41
93029237	PE-MW-LED-7	ANSI C136.41 Dimming PE, 120-277V
93029238	PE-347-LED-7	ANSI C136.41 Dimming PE, 347V
93029239	PE-480-LED-7	ANSI C136.41 Dimming PE, 480V

PE Cables		
Accessories	ANSI C136.41	ANSI C136.41
26299	PECOLT	STANDARD 120-277V
26294	PECOLT	STANDARD 480V
80436	PECOLT	STANDARD 347V
	PECOLT	Standard 079

va811.com Dig With CARE


FORTY-EIGHT (48) HOURS BEFORE
 DIGGING IS TO COMMENCE, THE
 CONTRACTORS SHALL NOTIFY THE
 FOLLOWING AGENCIES: VIRGINIA ONE
 CALL AT 811 OR (800) 552-7001 AND
 ALL OTHER AGENCIES WHICH MIGHT
 HAVE UNDERGROUND UTILITIES
 INVOLVING THIS PROJECT AND ARE
 NONMEMBERS OF VIRGINIA ONE CALL.

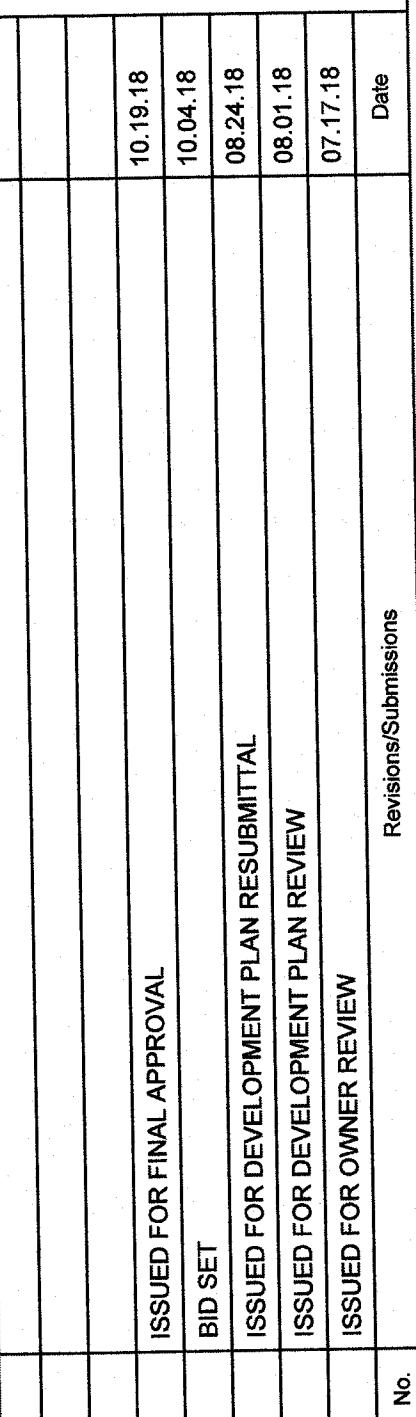

VALVOLINE INSTANT OIL CHANGE
4025 CHALLENGER AVE. NE
ROANOKE VA



© 2018 CESO, INC

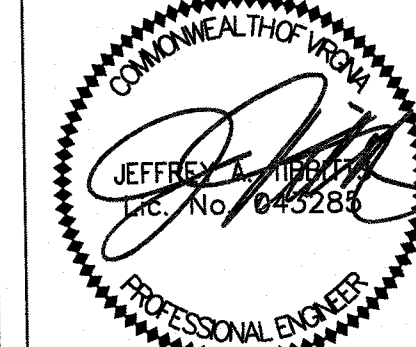

Project No.	755208
Scale	AS NOTED
Drawn	JJL
Checked	EJE
Date	07/17/18
Drawing Title	

PHOTOMETRIC PLAN

Drawing No. **C8.0**