




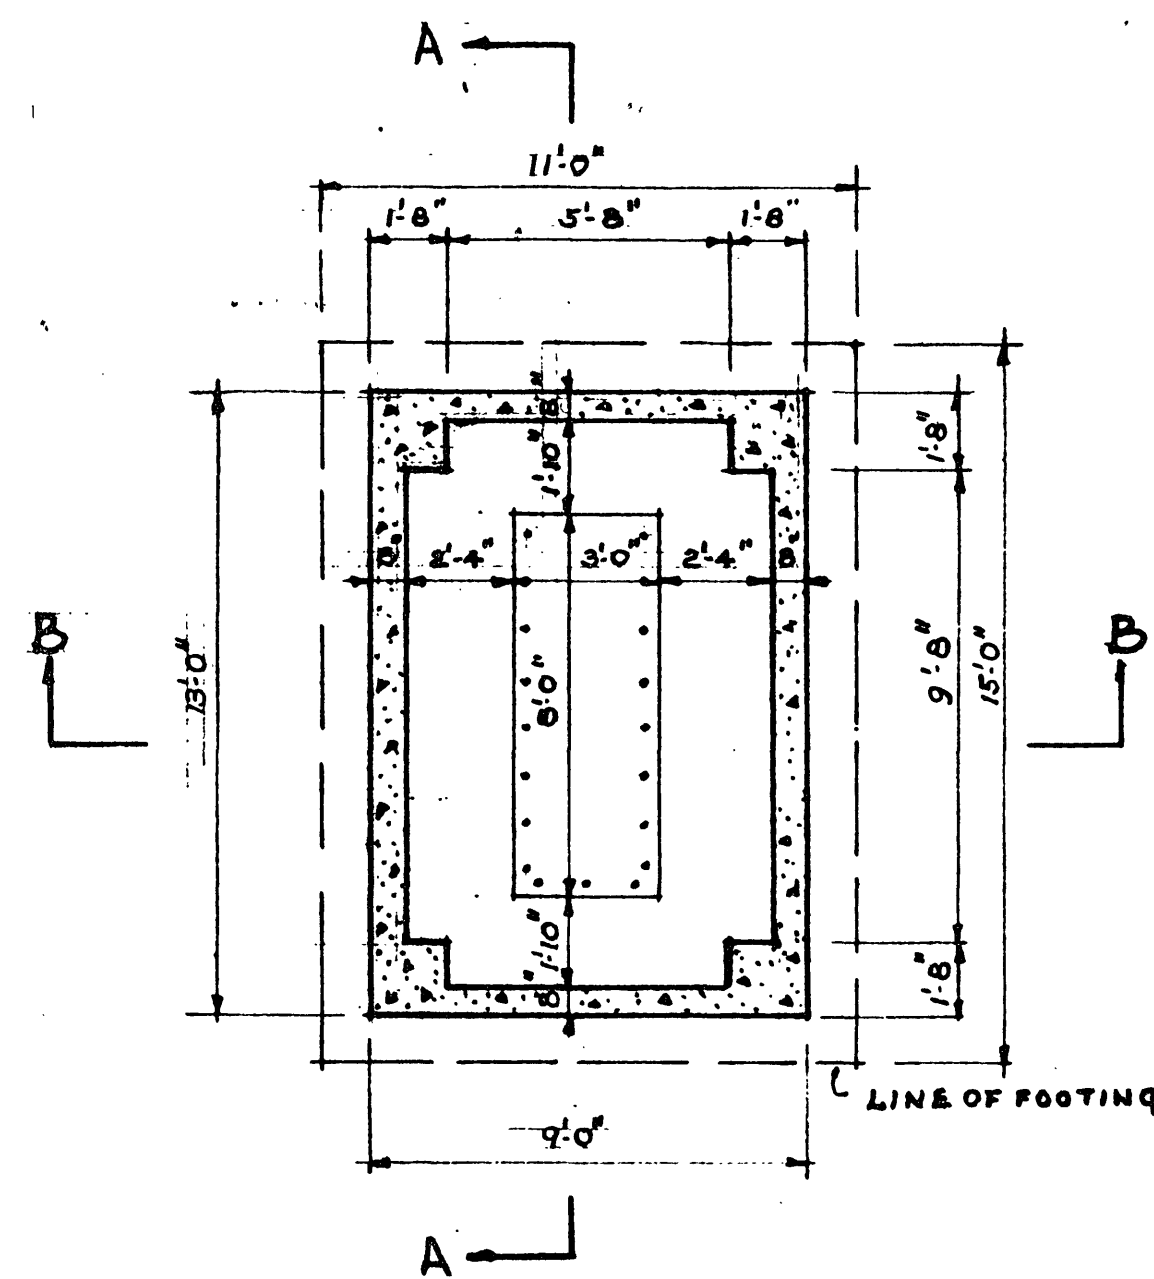


FOUNDATION PLAN
SCALE 1/4" = 1'-0"

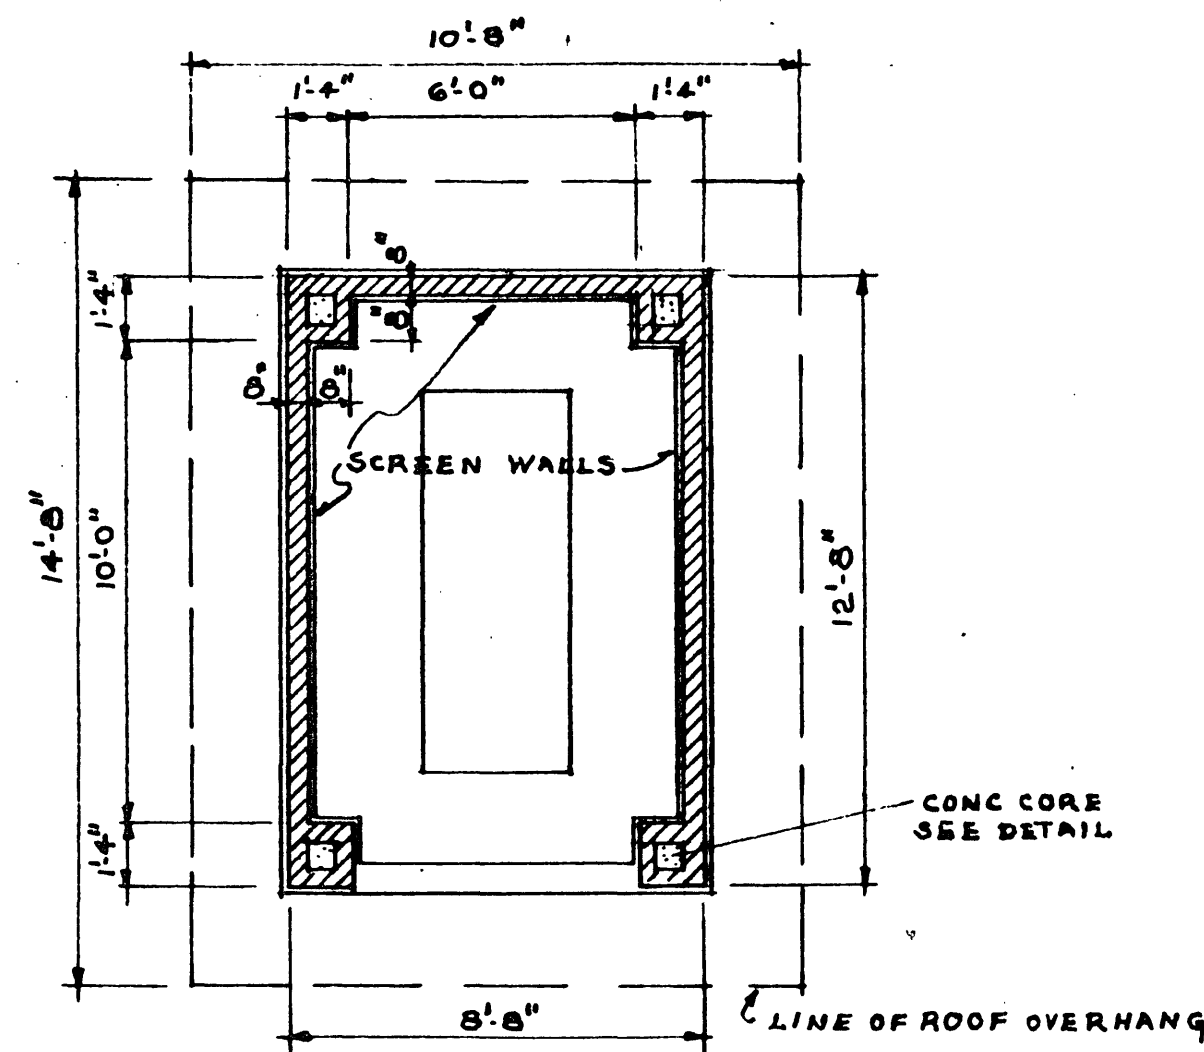


FLOOR PLAN
SCALE 1/4" = 1'-0"

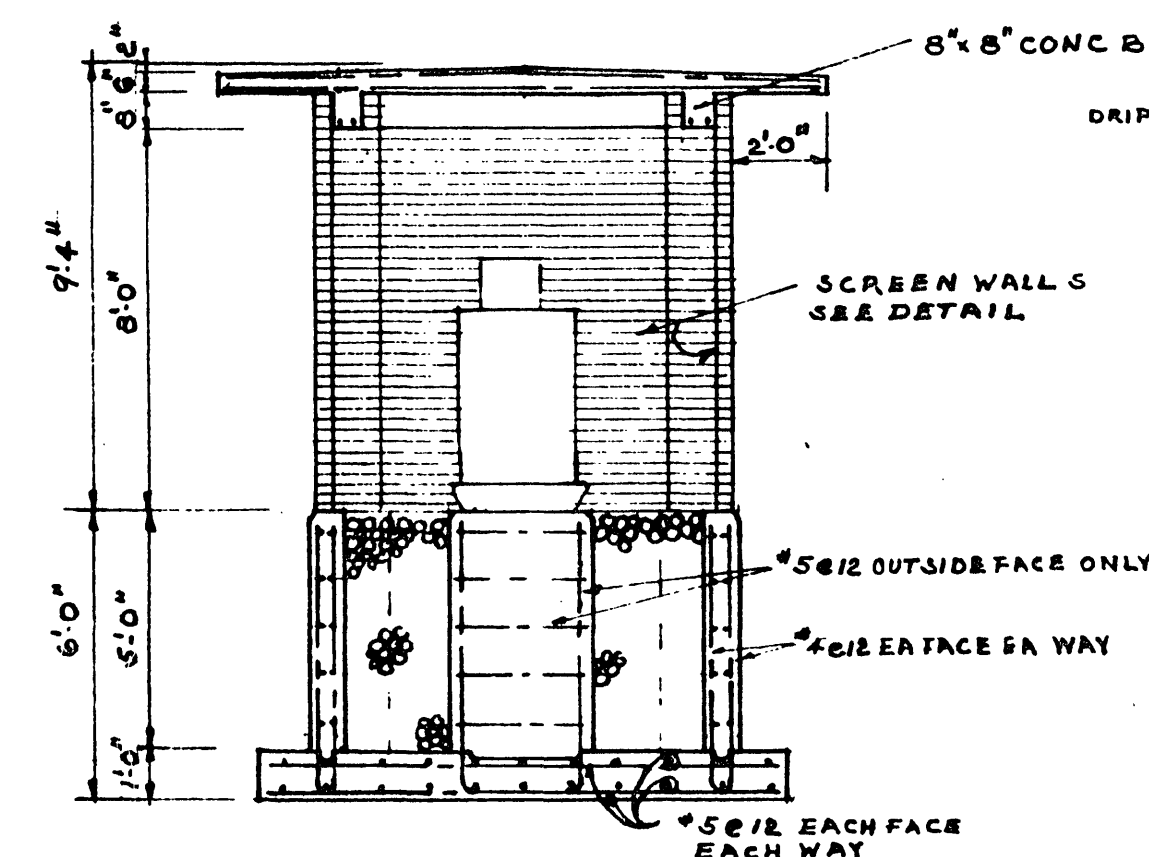


SECTION B-B
SCALE 1/4" = 1'-0"

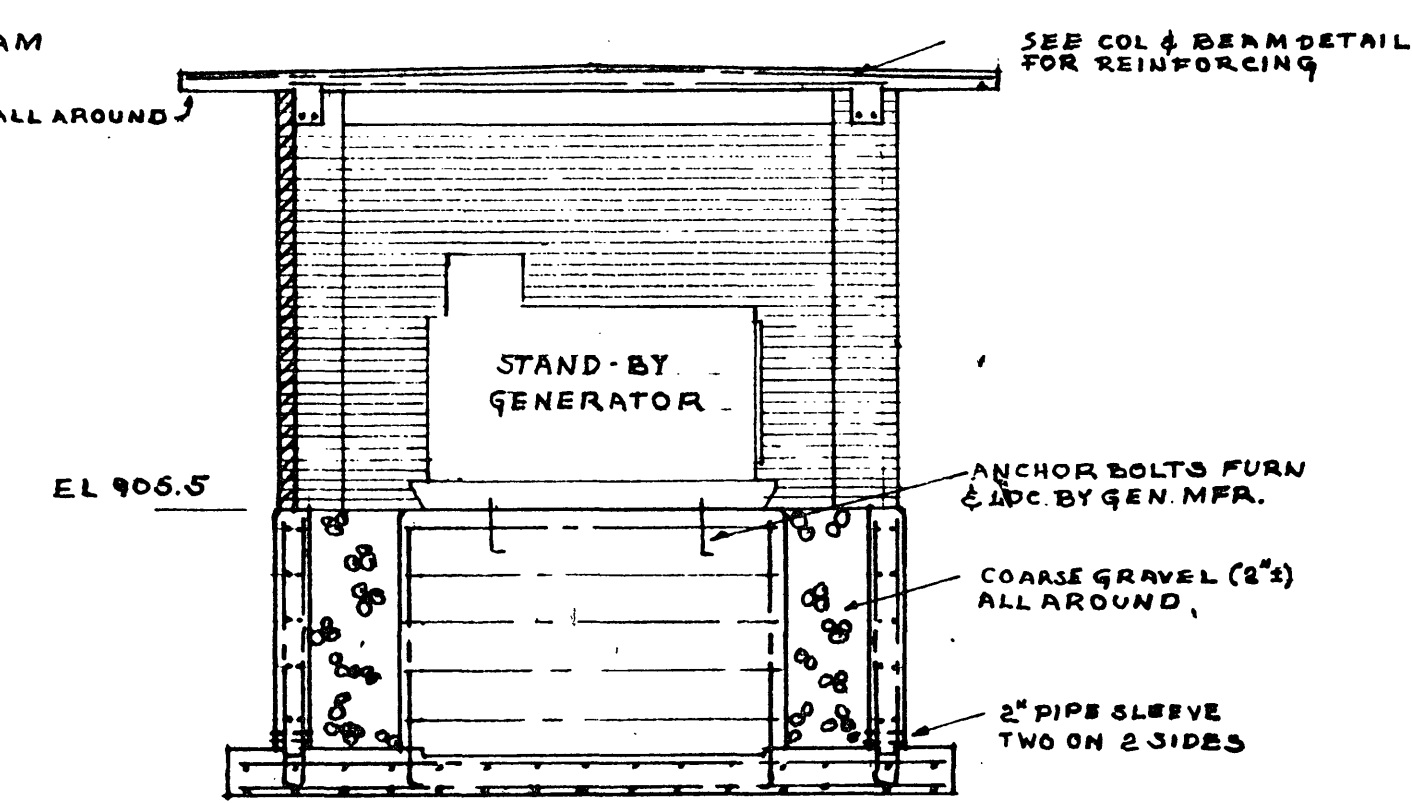


SECTION A-A
SCALE 1/4" = 1'-0"

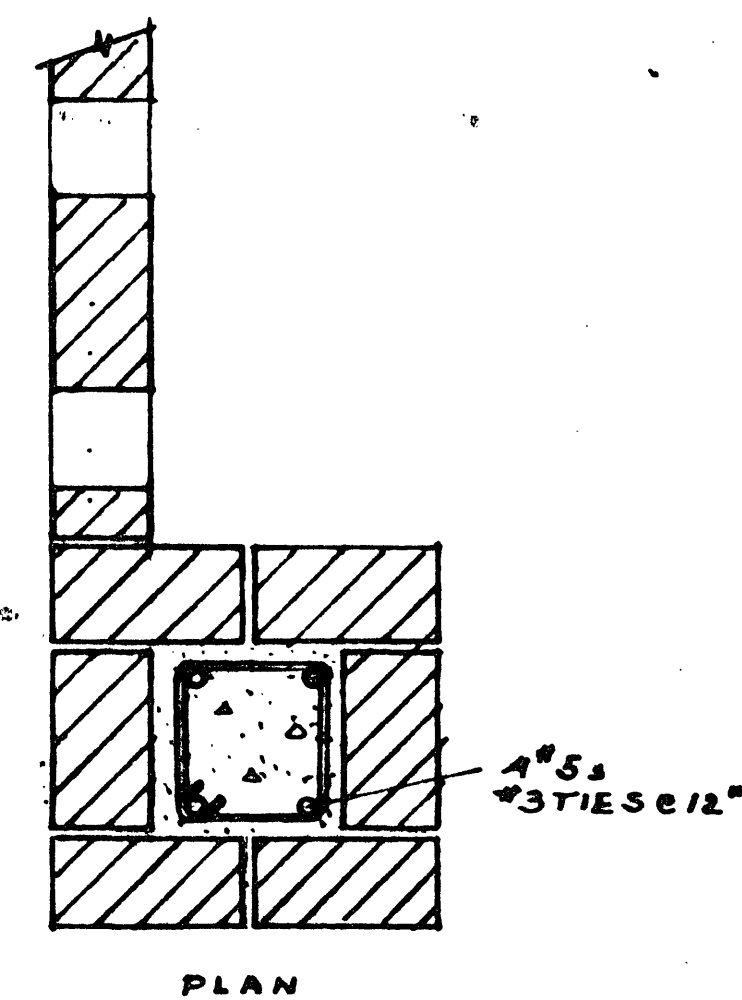


CORNER COLUMN DETAIL
SCALE 1/2" = 1'-0"

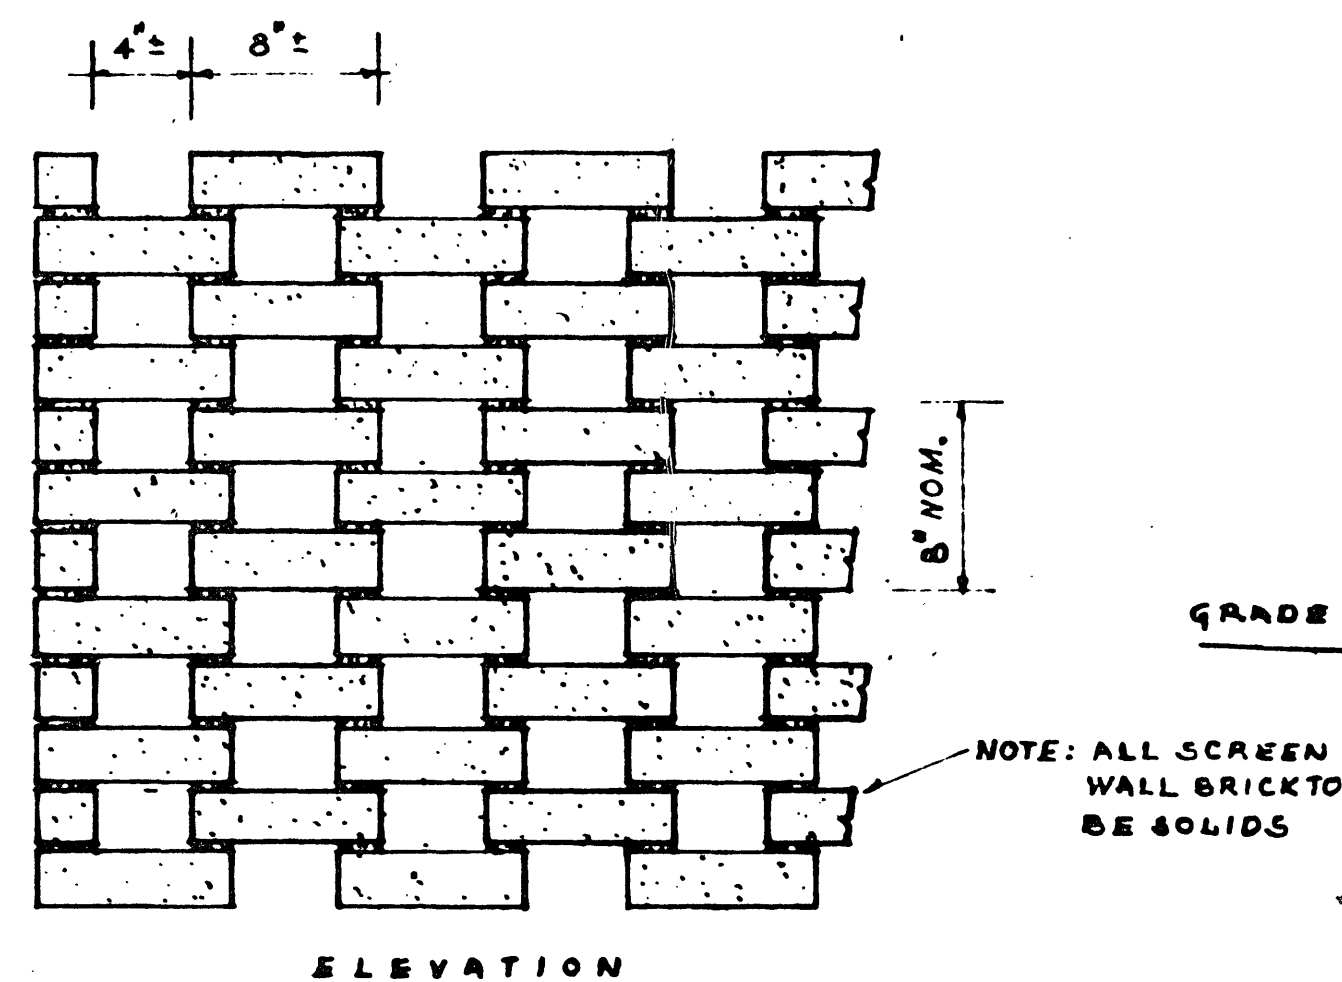


TYP. SCREEN WALL DETAIL
SCALE 1/2" = 1'-0"

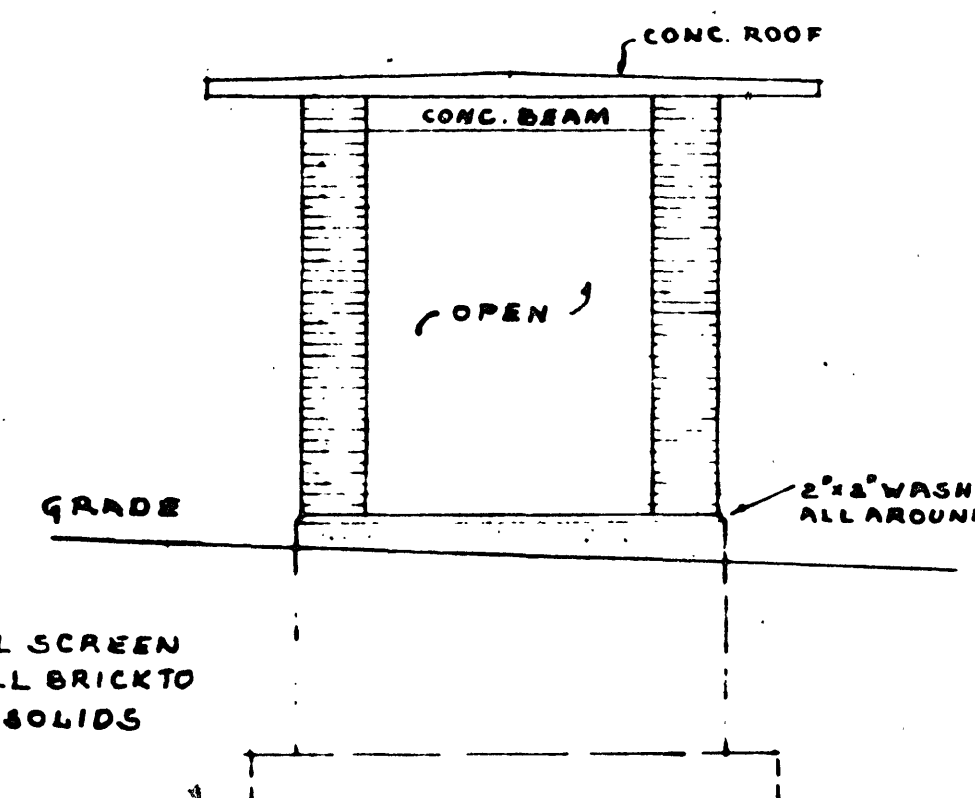


EAST ELEVATION
SCALE 1/4" = 1'-0"

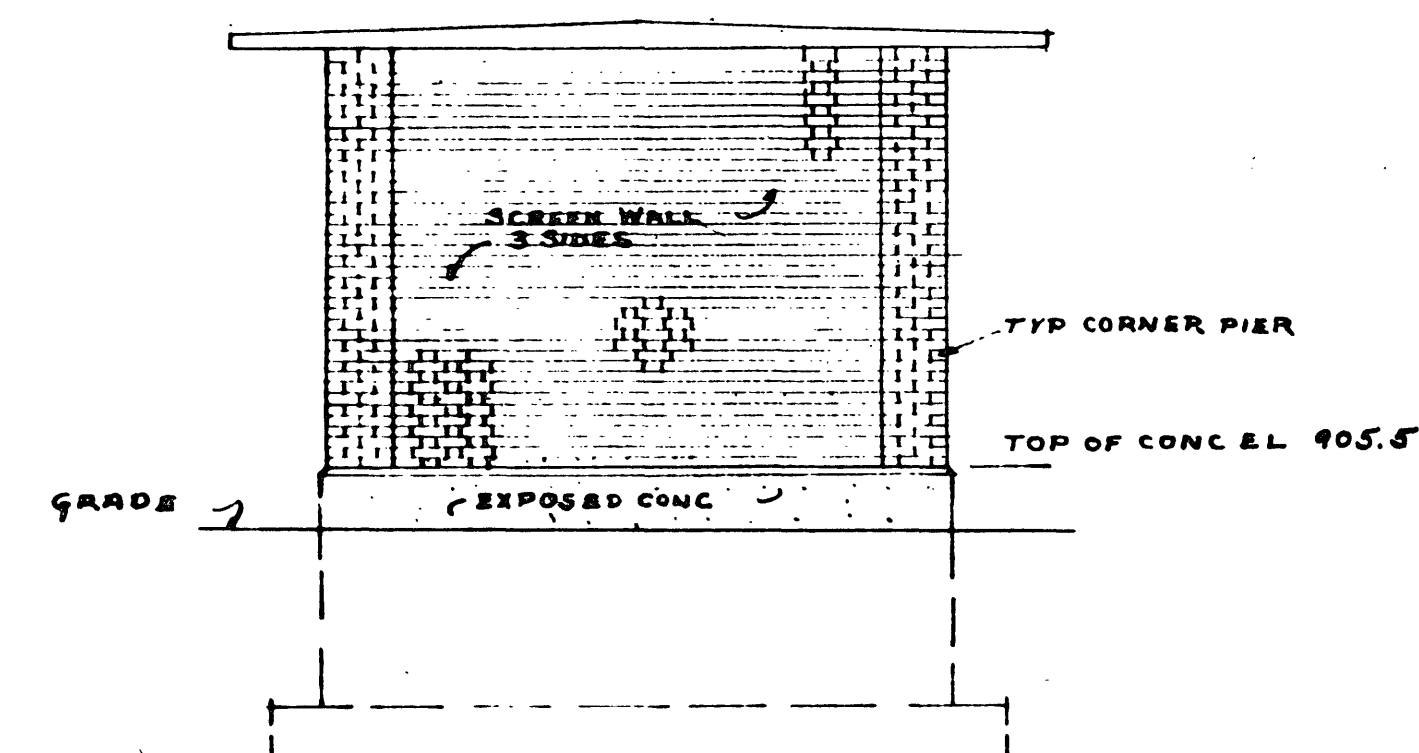


NORTH ELEVATION
SCALE 1/4" = 1'-0"

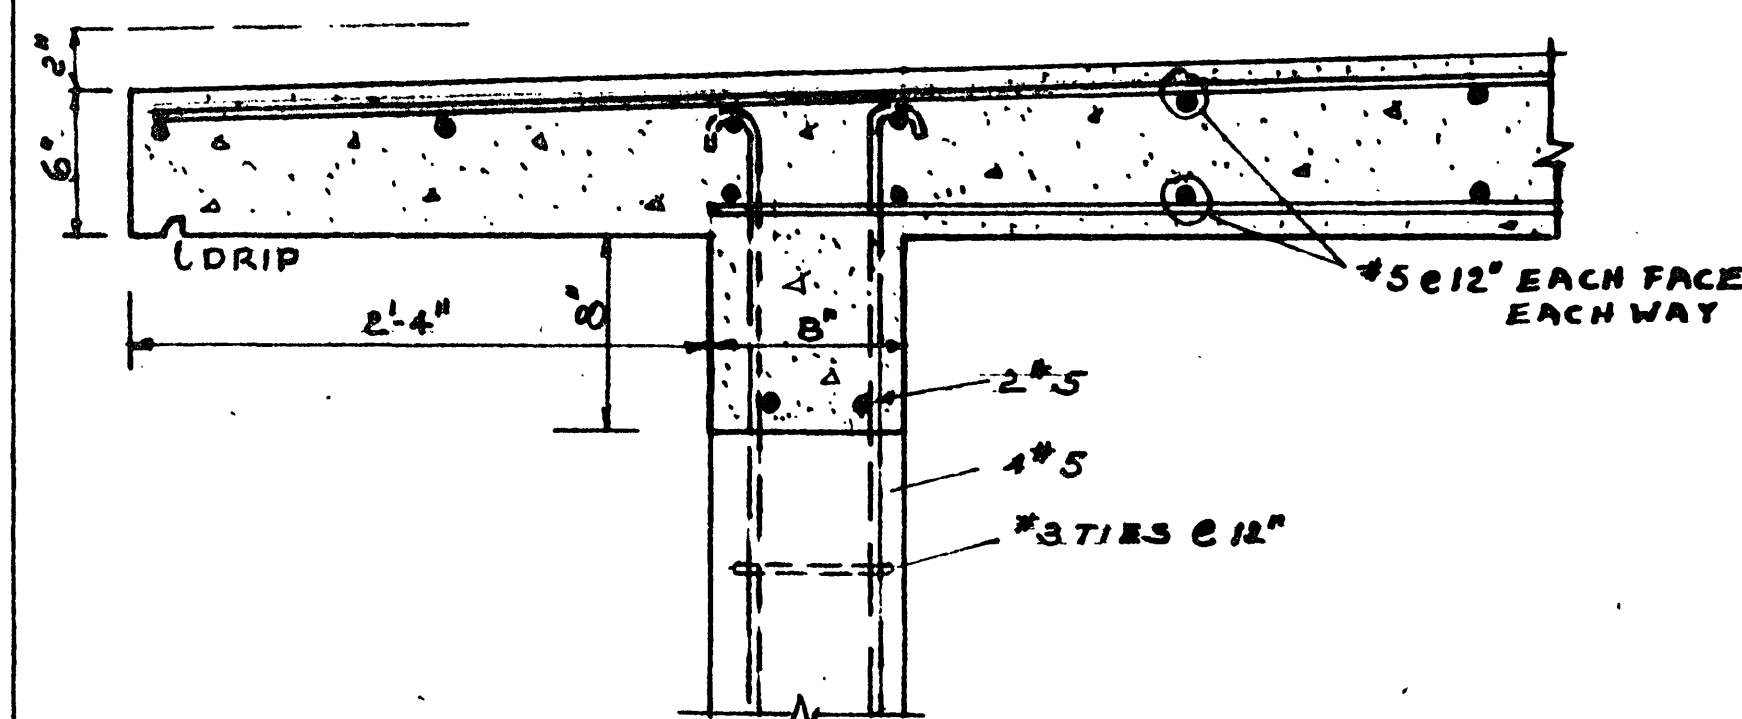

CONC. COLUMN & BEAM DETAIL
SCALE 1/2" = 1'-0"

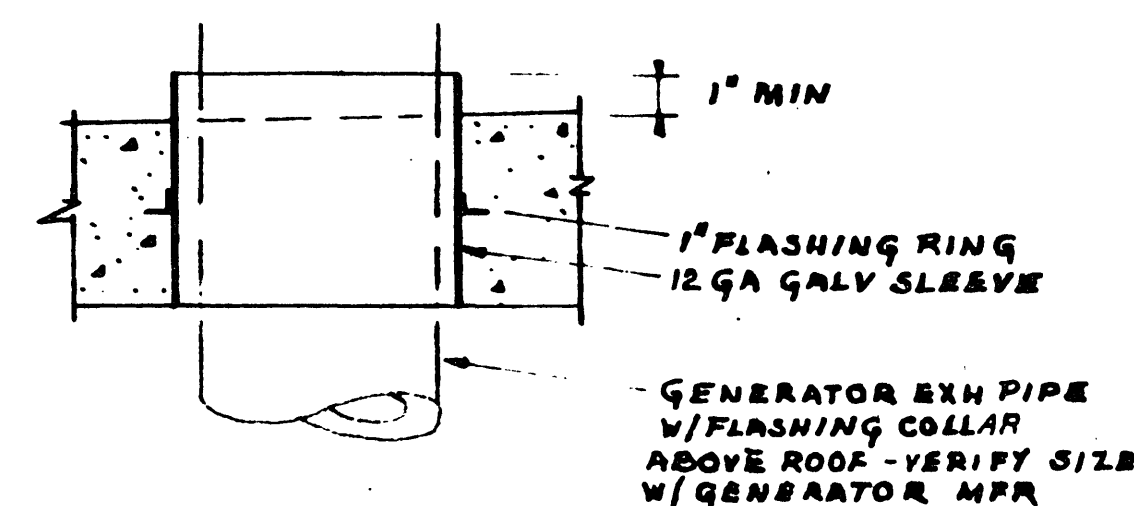

ROOF OPNG DETAIL
SCALE 1/2" = 1'-0"

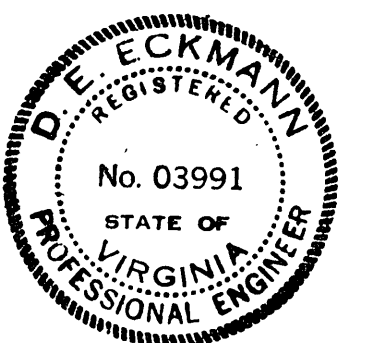

VINTON PUMPING STATION
VINTON, VIRGINIA

GENERATOR ENCLOSURE

ALYDOR, BURDICK & HOWSON
ENGINEERS - 1981 CHICAGO