


MECHANICAL ROOM

SEE ISOMETRIC DETAIL THIS SH.

1 CONNECT TO EXISTING 4" DOMESTIC COLD WATER PIPING AT CEILING.

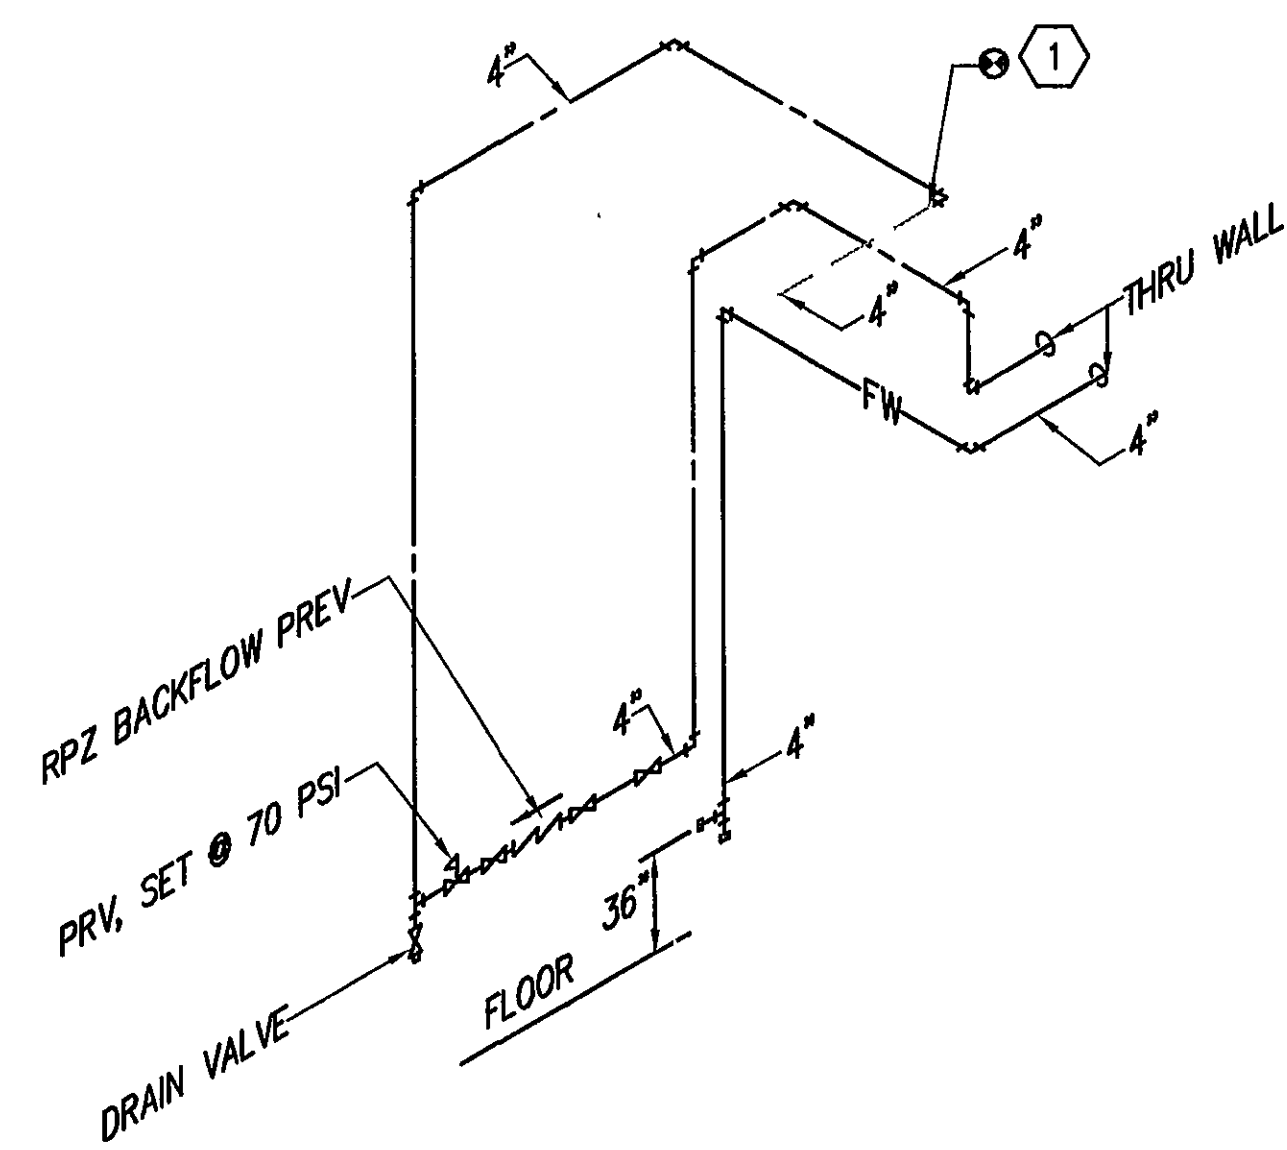

1/4" = 1'-0"

A horizontal graphic scale bar. It is divided into four equal segments. The first segment is white, the second is black, the third is white, and the fourth is black. Above the bar, the number '0' is centered over the first segment, and '5'' is placed at the right end of the bar.

COMMONWEALTH OF VIRGINIA
STEPHEN R. FORKNER
Lic. No. 018849
2/26/08
PROFESSIONAL ENGINEER

OVPR
ARCHITECTS AND ENGINEERS

220 Country Club Dr. SW
Plaza One, Building E
Blacksburg, Virginia 24060

P: 540-652-2161
F: 540-981-0219
www.ovpr.com

VWCC – WATER LINE
 IMPROVEMENTS
 PC# 260-05260-033
 VIRGO
 ROANOKE

Comm. No. 0473	Date 20 FEB 08
-------------------	-------------------

Designed:	RLW
Drawn:	RLW
Checked:	SRF
Approved:	

ANDERSON HALL & PHYS.ED.
PLUMBING PLANS

P1.2