



Rawlence - 75plundg - Tuesday, February 26, 2008 - 2:36 PM

① DISCONNECT AND REMOVE EXISTING PIPING AT ELL, CAP REMAINING PIPING THRU WALL.


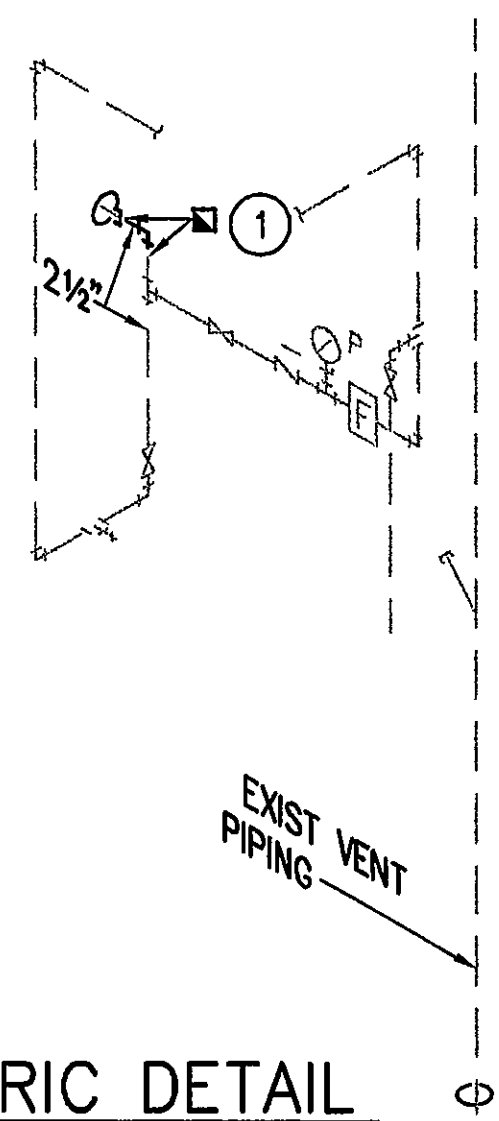


ISOMETRIC DETAIL
NO SCALE

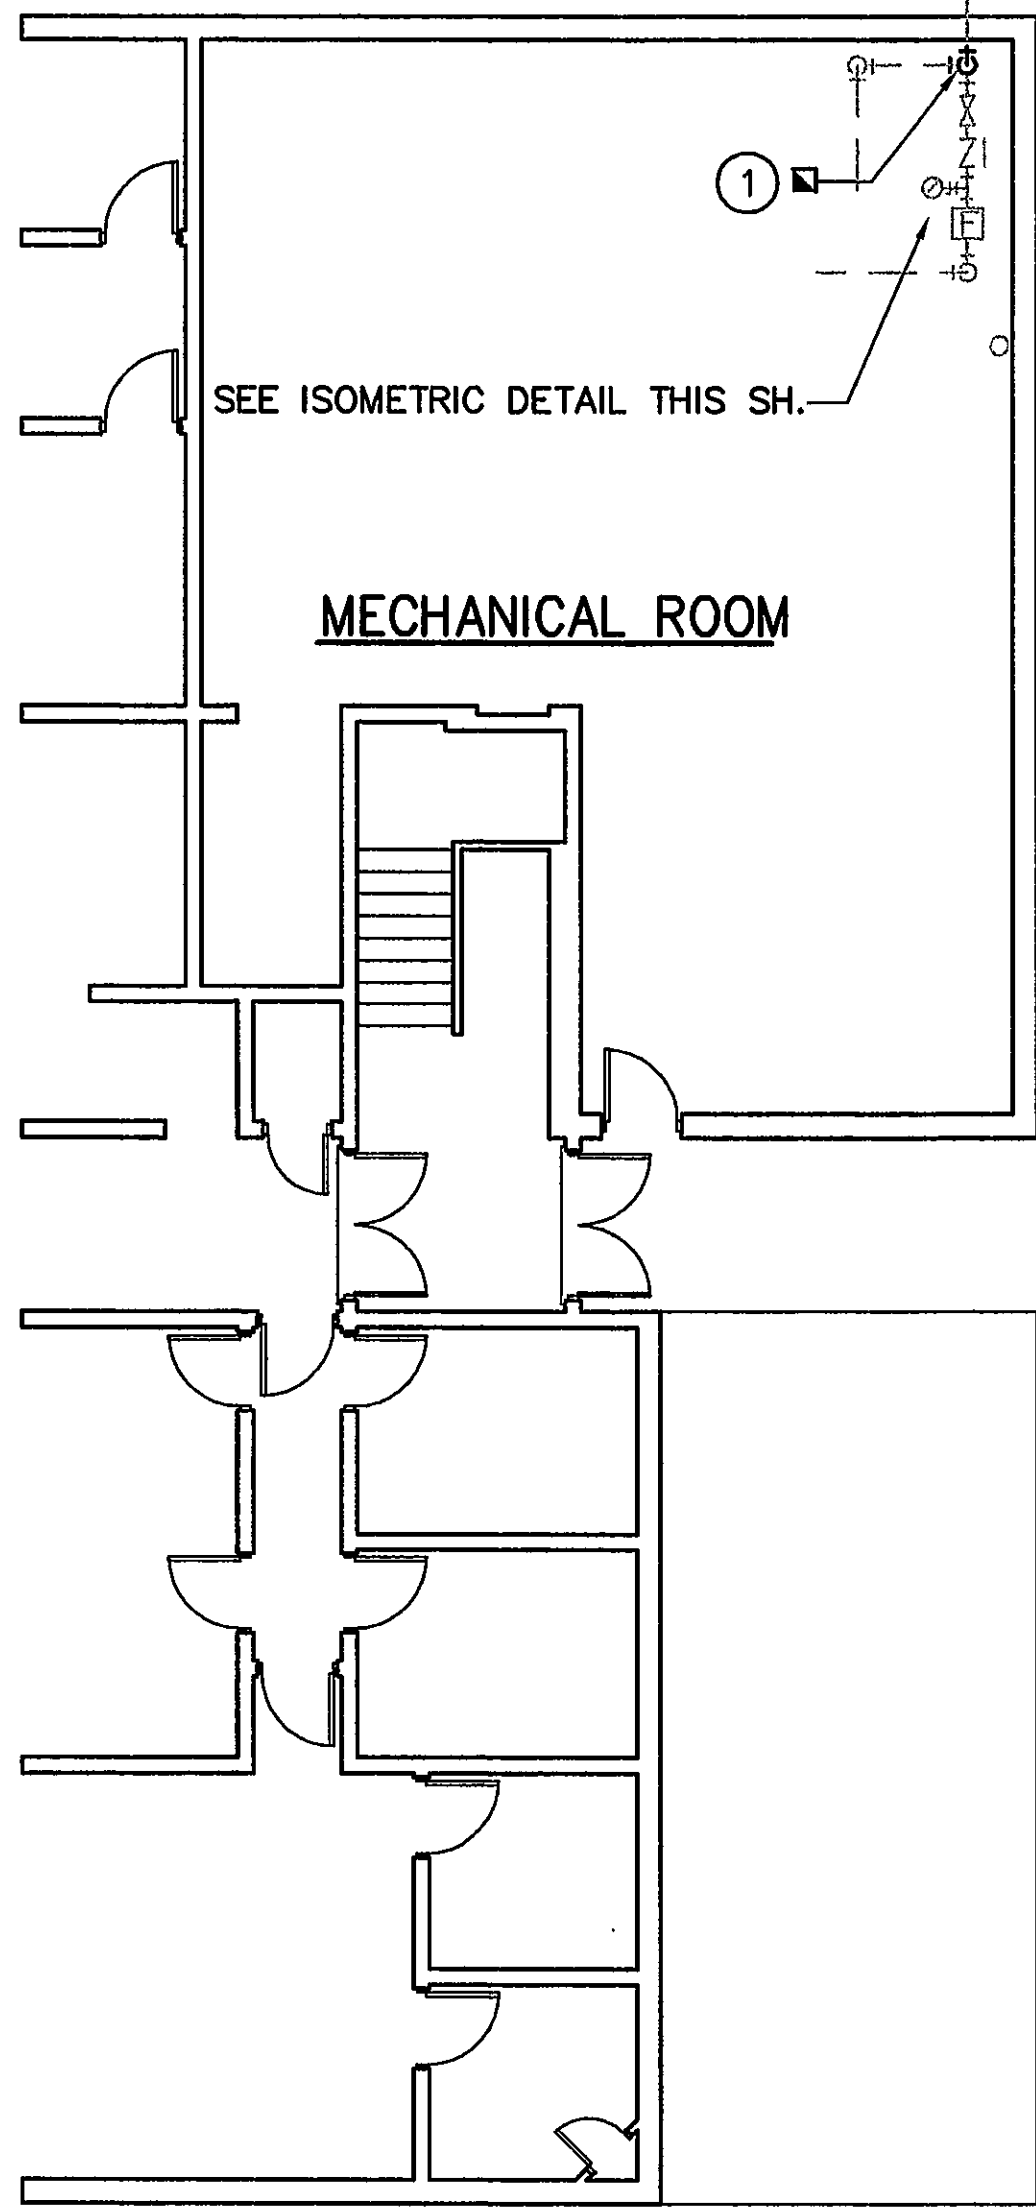


DEMOLITION PLAN

FISHBURN HALL
1/8"=1'-0"

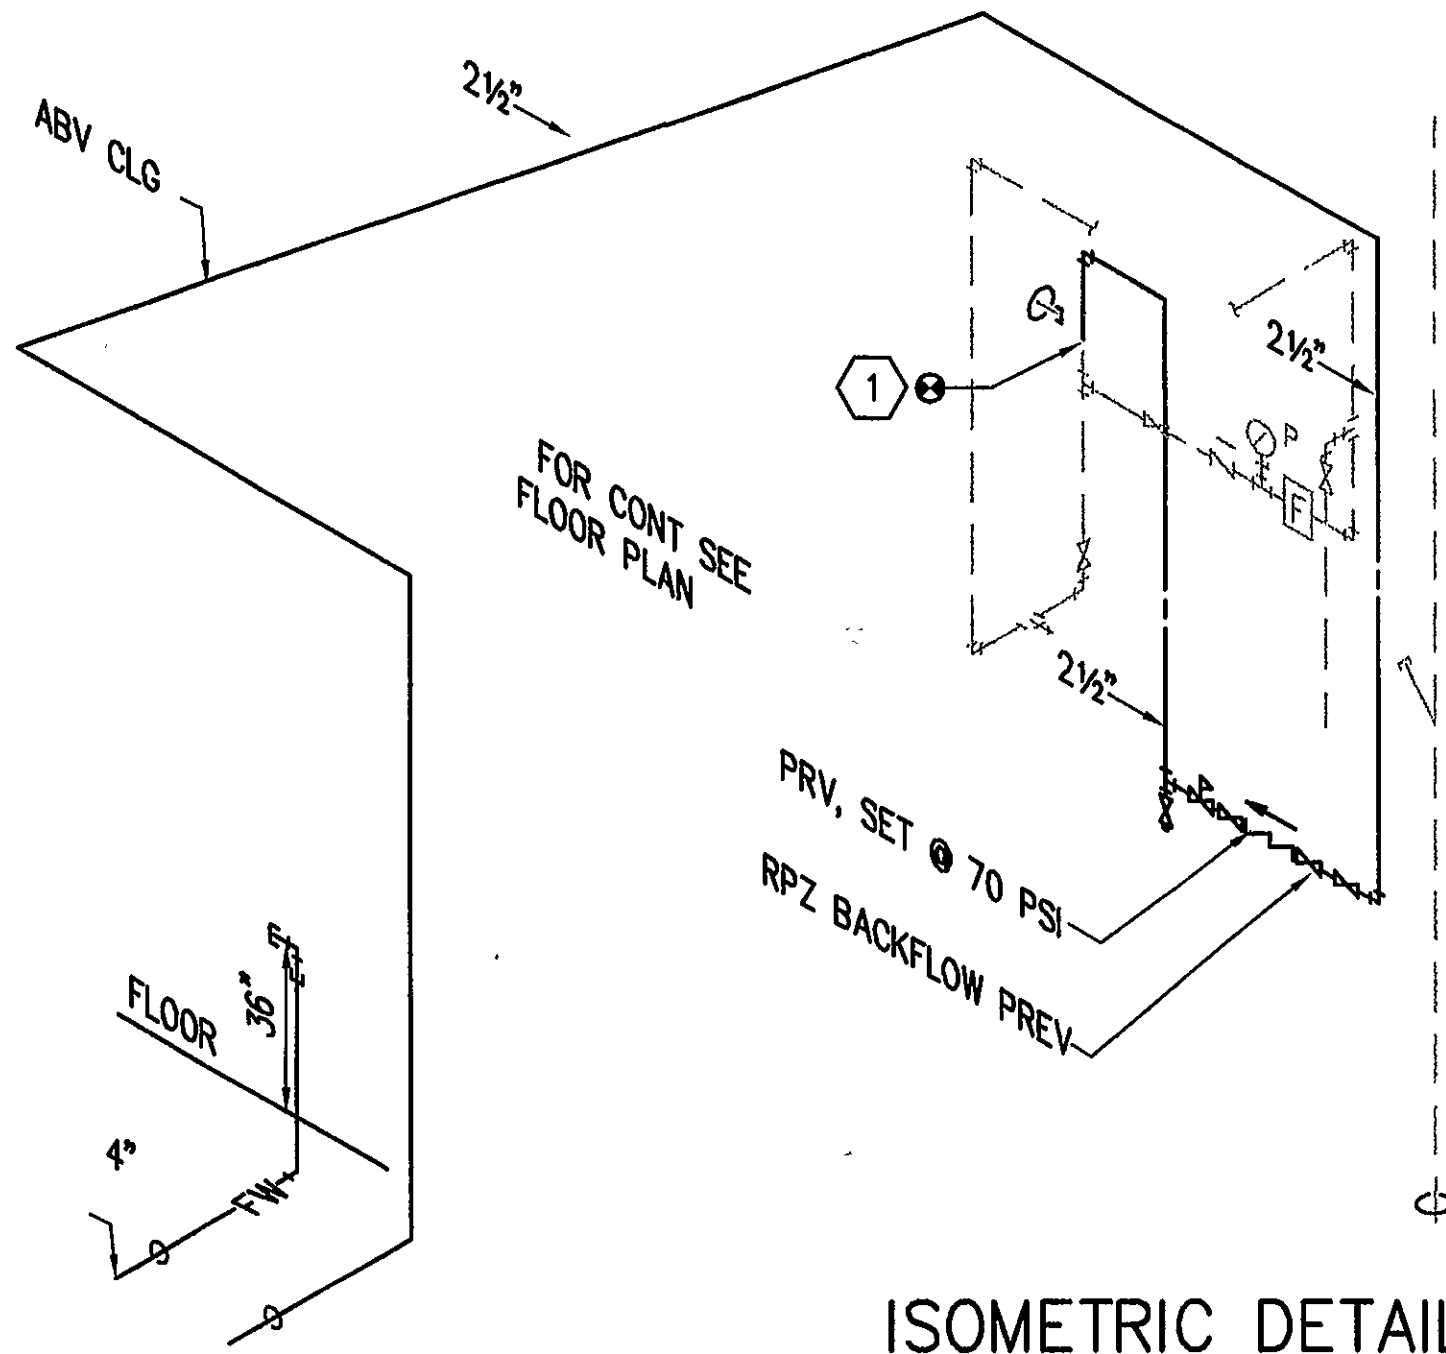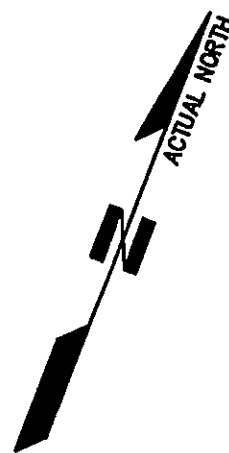


ISOMETRIC DETAIL
NO SCALE

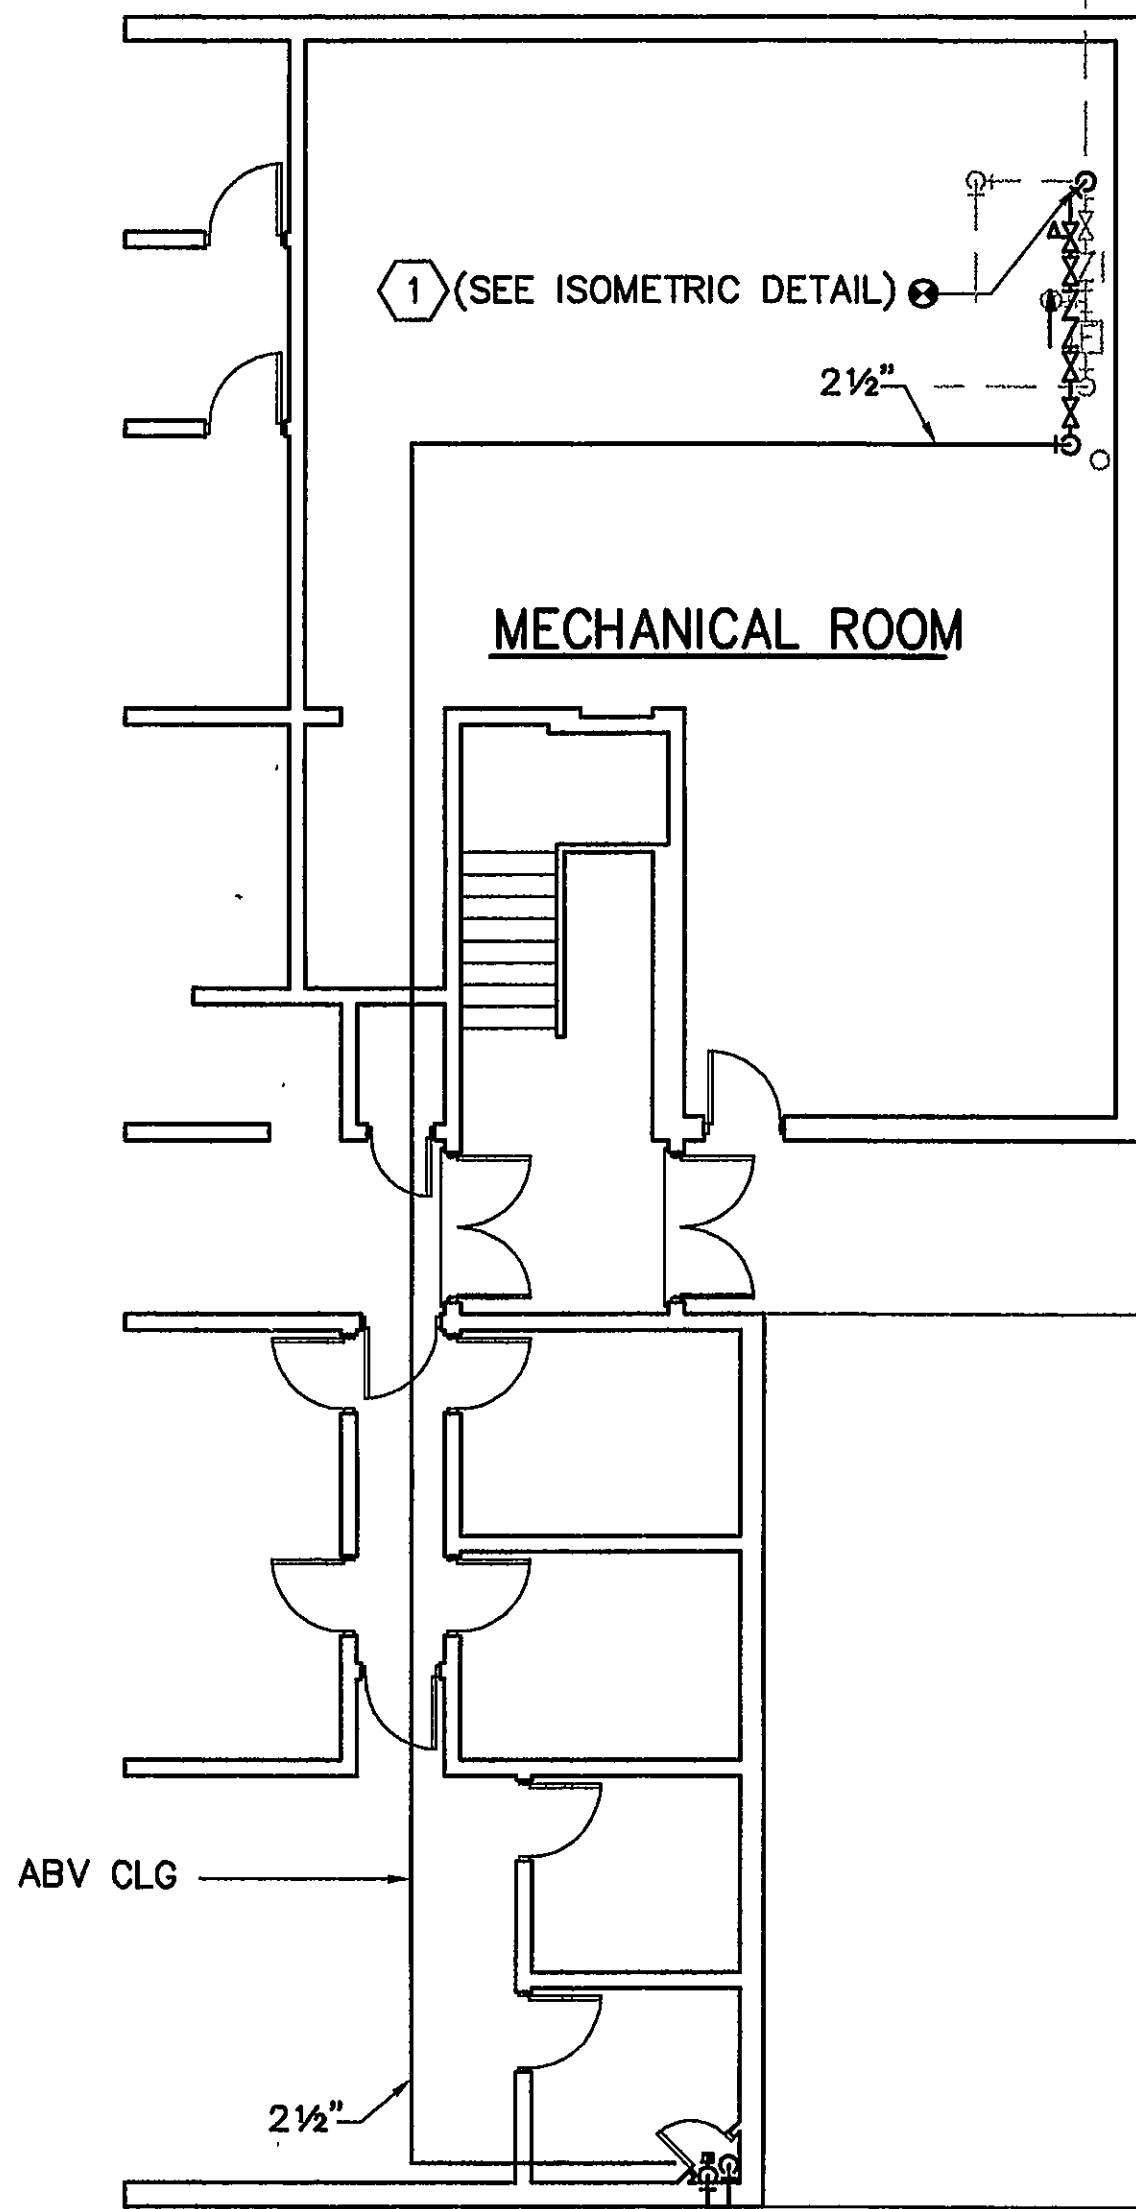



NEW WORK PLAN

① CONNECT TO EXISTING 2 1/2" COLD WATER PIPING AT WALL.

 1/8" = 1'-0"



△		
△		
△		
No.	Description	Date
Revisions		

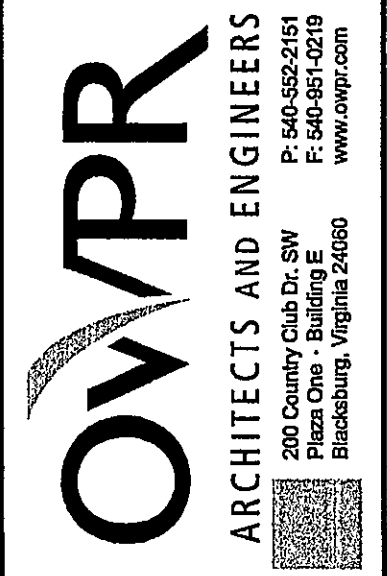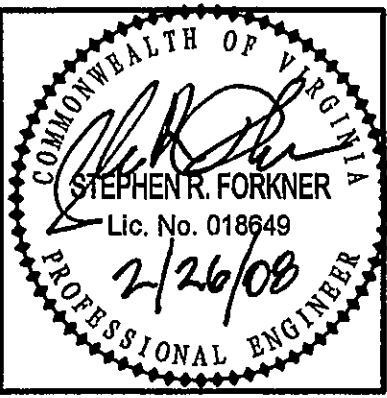

VWCC - WATER LINE
IMPROVEMENTS
PC# 260-05260-033

ROANOKE VIRGINIA

Comm. No.
0473

Date
20 FEB 08

Designed: RLW
Drawn: RLW
Checked: SRF
Approved:

FISHBURN HALL
PLUMBING PLANS

P1.3