
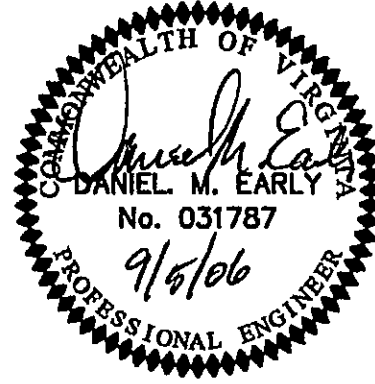
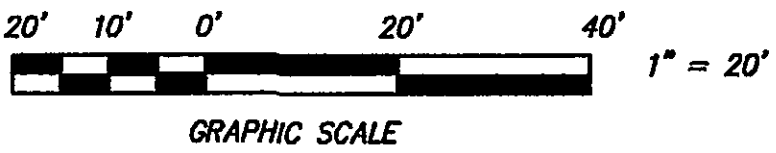


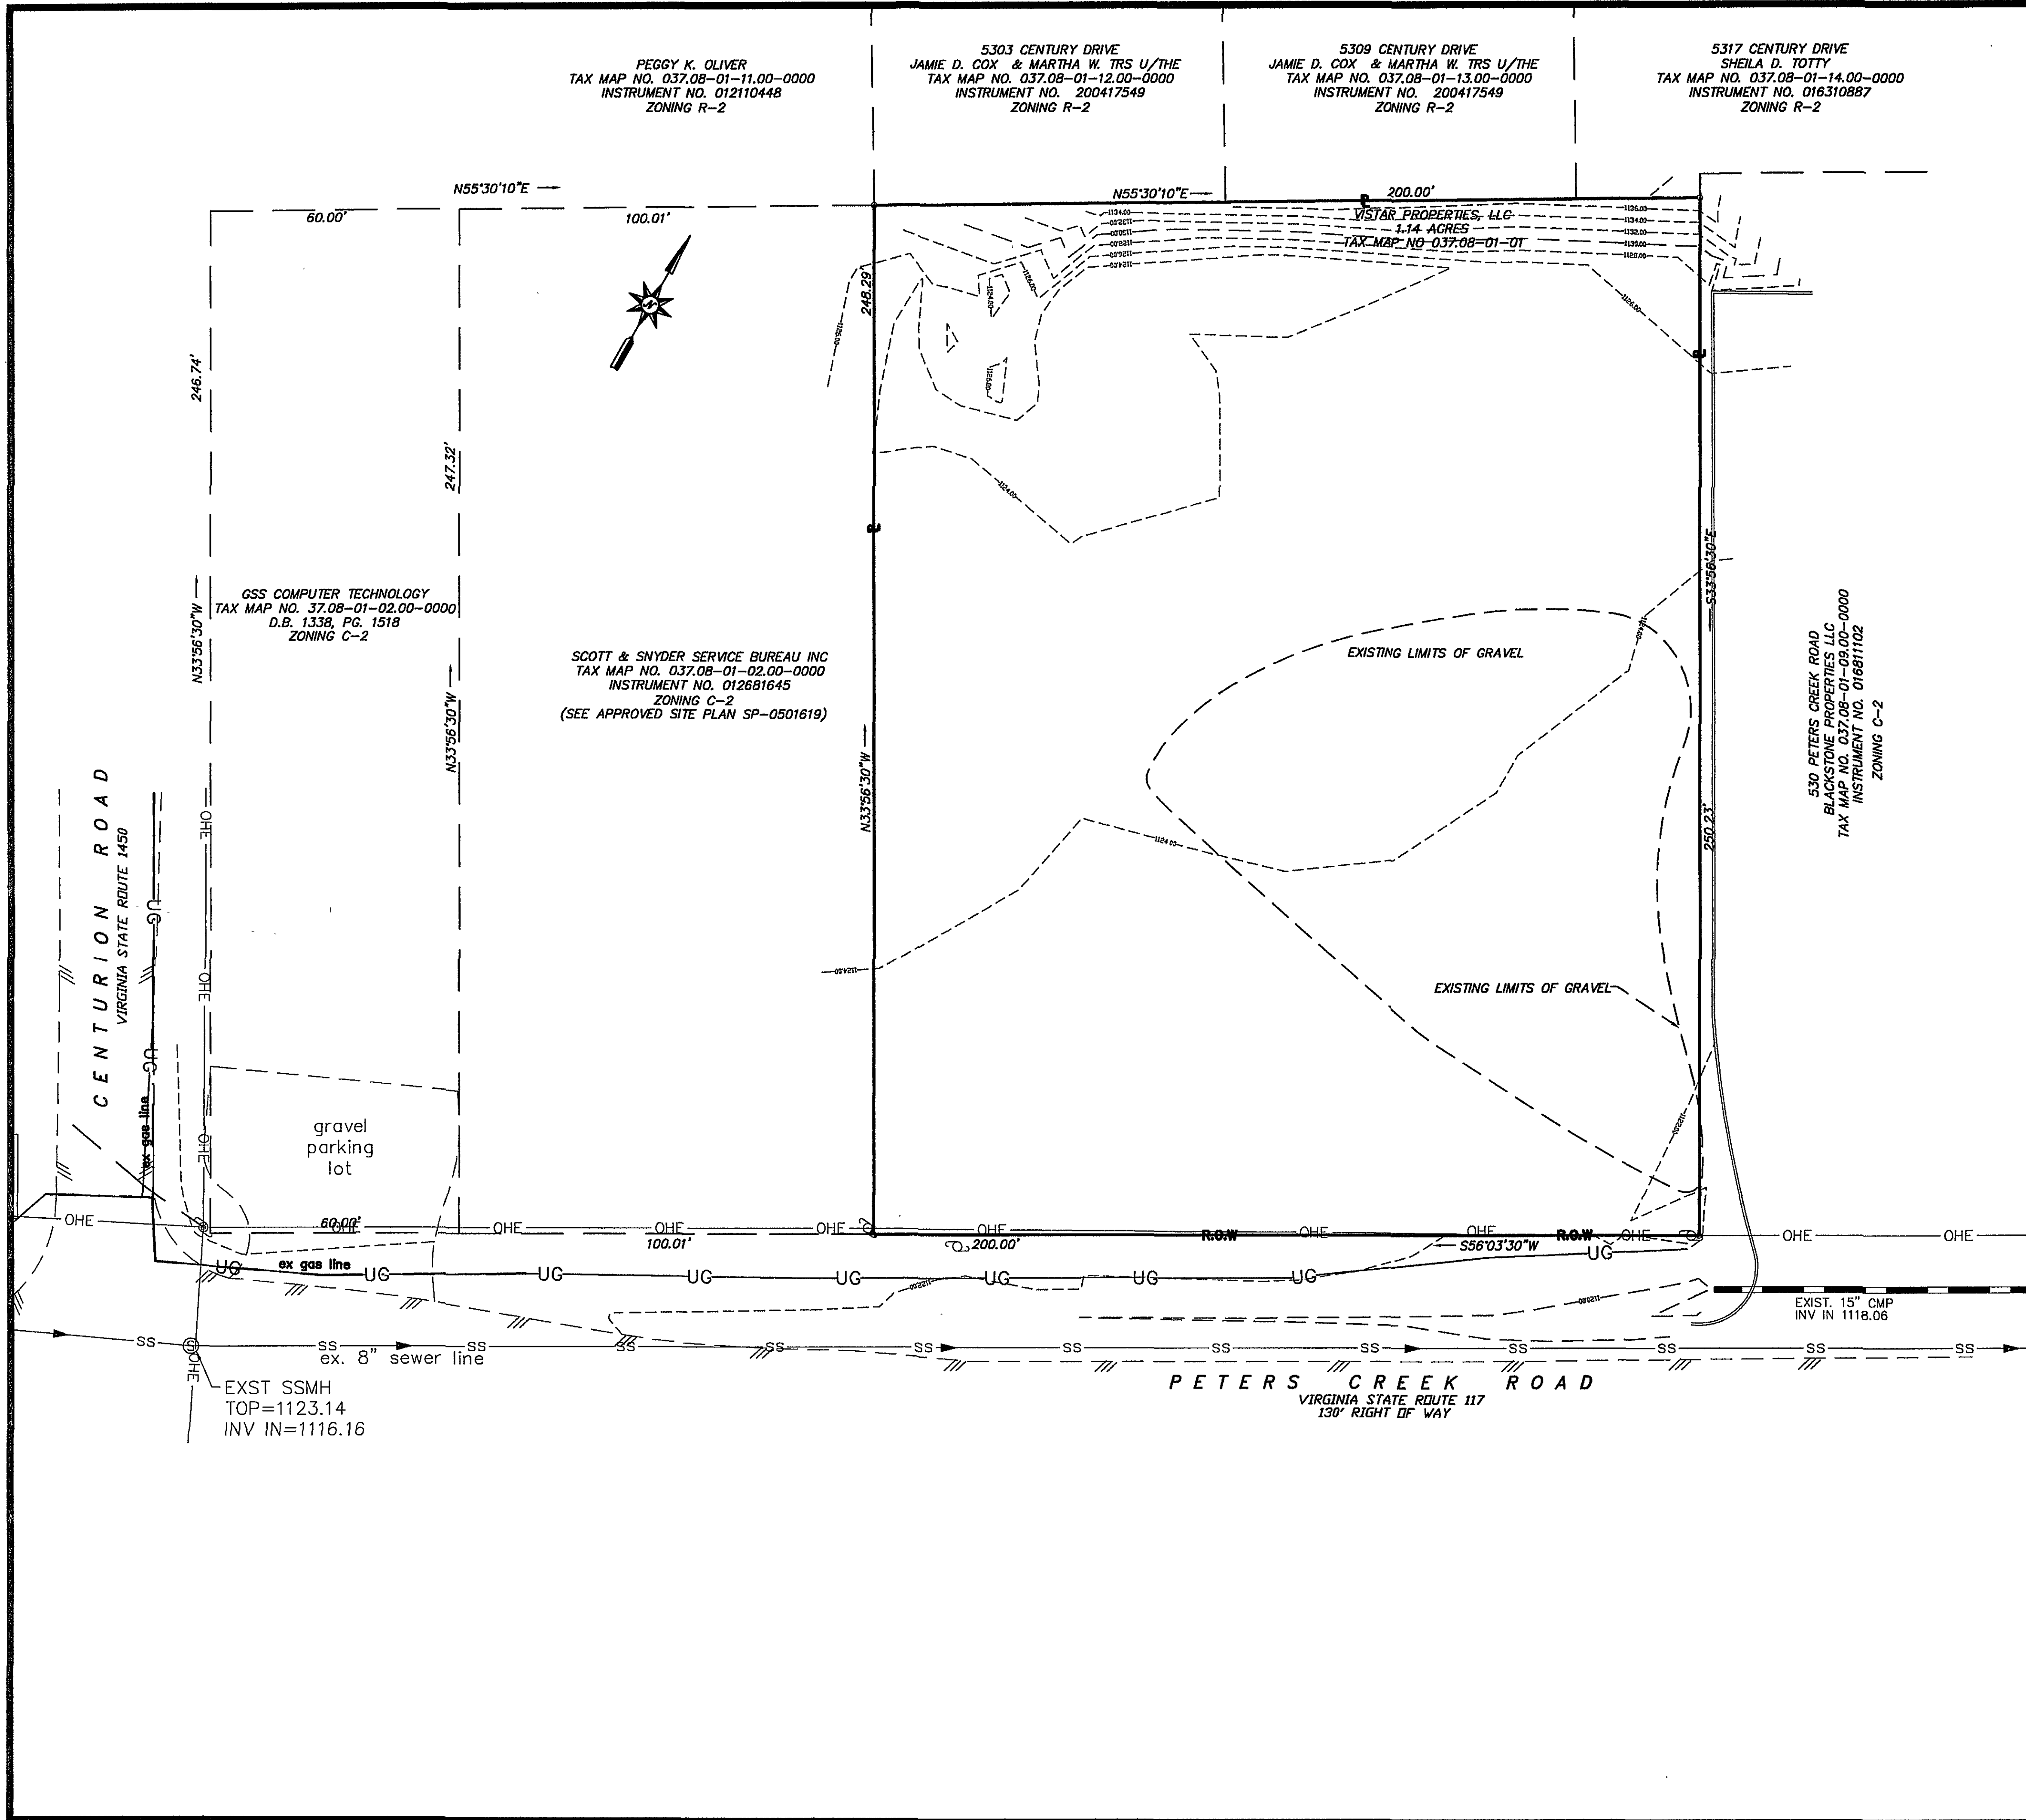

ACS
DESIGN

Engineering-Planning-Surveying
Construction Management

2203 Peters Creek Road, NW
Roanoke, Virginia 24017
Phone: 540 562 2345
Fax: 540 562 2344
Email: info@acsdesignllc.com
www.acsdesignllc.com

VISTAR EYE CENTER
SITE PLAN
ROANOKE COUNTY, VIRGINIA

DRAWN BY: KAL

DESIGNED BY: KAL

CHECKED BY: DME

DATE: 03/28/2006

SCALE: 1"=20'

REVISIONS

REVISION	DATE	COMMENT
1	8/05	Revised Bids & Permits

SHEET No.

C1.1

EXISTING CONDITIONS

JOB No. 06005